


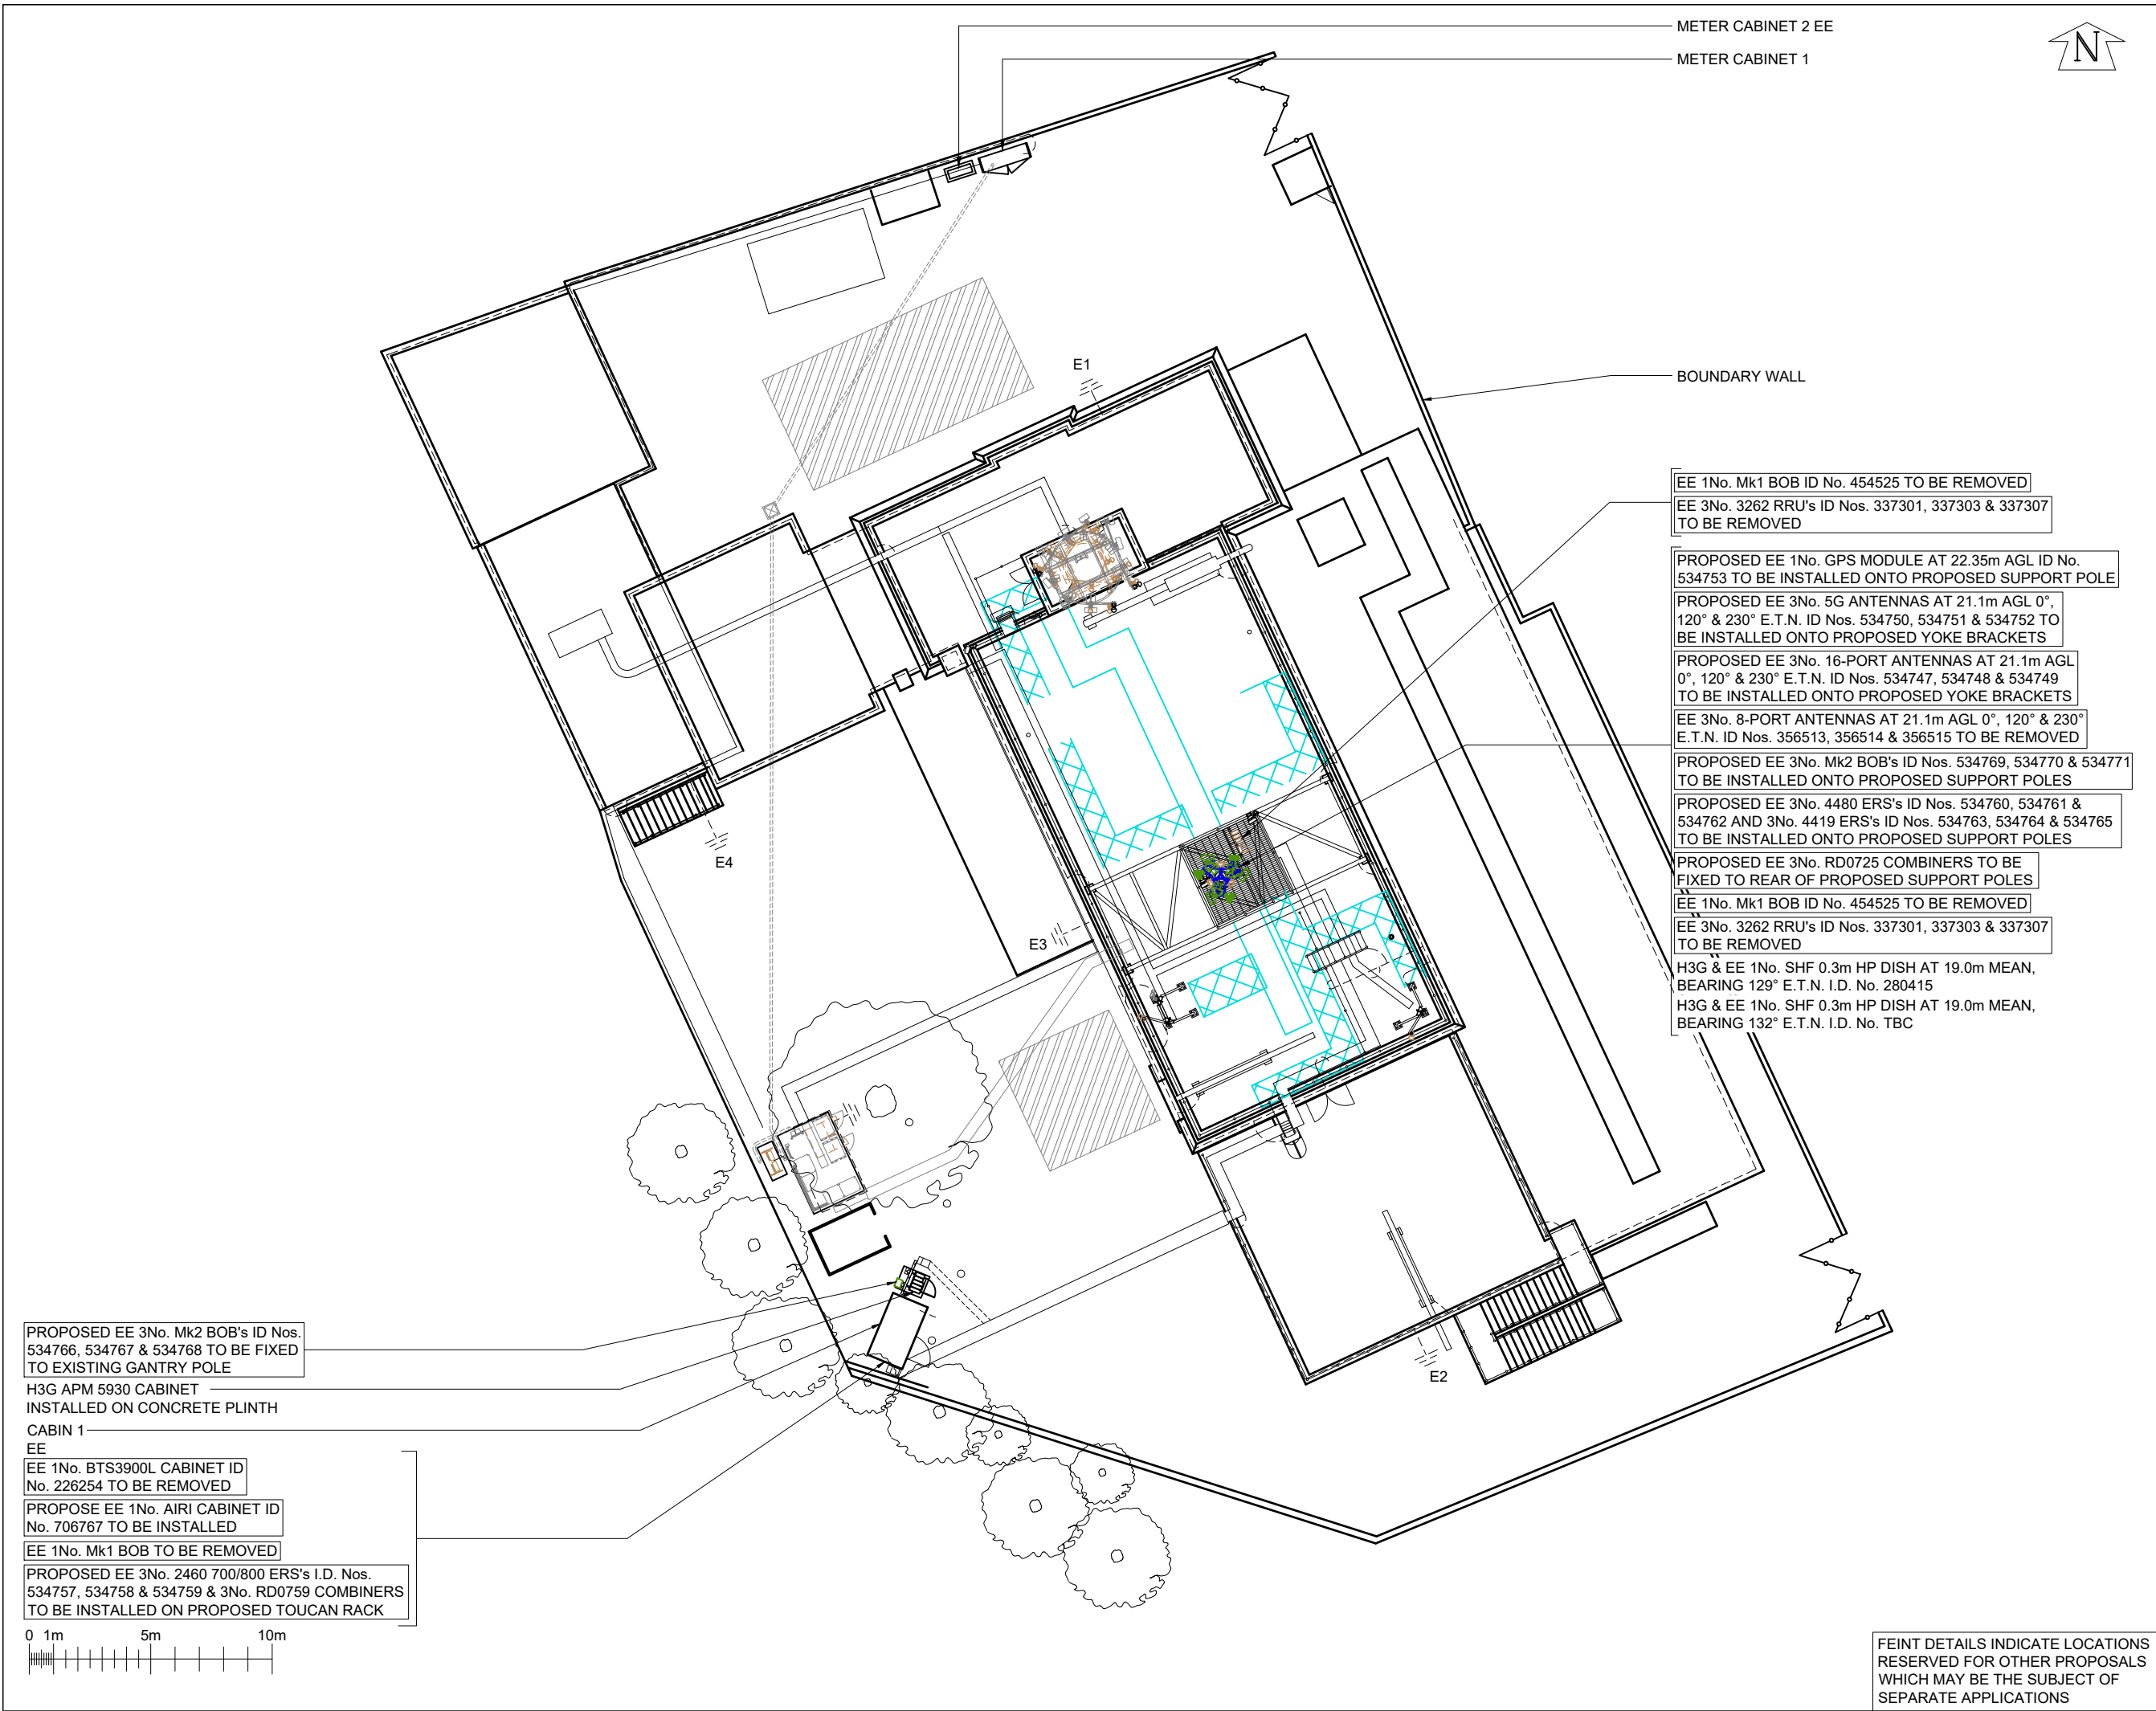

©2020 Cellnex

All rights reserved. No part of this publication may be reproduced, stored in a retrieval system or transmitted in any form or by any means (Electronic, Mechanical, Photocopying, Recording or otherwise), without the prior written consent of the Company.

NOTES

PROJECT No.

238816

CELL No.

98260

BT SKYLINE No.

HA0019

26	PROJ No	238816	24/11/21	WHP	WHP
	PLANNING				
25	PROJ No	212204	07/05/21	DAL	DAL
	PLANNING				
24	PROJ No	231660	16/12/20	HFC	HFC
	MINOR AMEND				
23	PROJ No	231660	03/12/20	HFC	HFC
	PLANNING ISSUE				
22	PROJ No	216790	17/04/20	TCS	MF
	MASTER UPDATE				
ISS	REVISION	DATE	DRN	APP	

cellnex

driving telecom connectivity

CELLNEX UK

R+, 4TH FLOOR, 2 BLA GRAVE STREET, READING, RG1 1AZ

Tel. 020 4526 8553

SITE No

164967

RUISLIP TE

HIGH STREET

RUISLIP

HILLINGDON

GREATER LONDON 3

HA4 7BJ

NGR

TQ 09080 87490

OS GRID

509080 187490

TITLE

SITE PLAN

PROPOSED

H3G & EE

SCALE

1:250

DRAWN	IM	19/08/11
APPROVED	WHP	24/11/21

DRG No.	Sheet 1 of 1	Rev
164967-02-100-MD026	26	

FEINT DETAILS INDICATE LOCATIONS RESERVED FOR OTHER PROPOSALS WHICH MAY BE THE SUBJECT OF SEPARATE APPLICATIONS

NOTES

EE 1No. BTS3900L CABINET ID No. 226254 TO BE REMOVED
PROPOSE EE 1No. AIRI CABINET ID No. 706767 TO BE INSTALLED

EE 1No. Mk1 BOB & LADDER TO BE REMOVED

PROPOSED EE 3No. 2460 700/800 ERS's I.D. Nos.
534757, 534758 & 534759 & 3No. RD0759 COMBINERS
TO BE INSTALLED ON PROPOSED TOUCAN RACK

— ALIFABS AIR VENT

 
— H3G & EE EF2I WALL-MOUNTED ELTEK PSU c/w 4No. 2kW RECTIFIERS TO BE UTILISED FOR UPGRADE

— HEATER

— H3G & EE EF2I WALL-MOUNTED ELTEK PSU c/w 4No. 2kW RECTIFIERS TO BE UTILISED FOR UPGRADE

— HEATER

CABIN 1 EE EQUIPMENT PLAN



FEINT DETAILS INDICATE LOCATIONS
RESERVED FOR OTHER PROPOSALS
WHICH MAY BE THE SUBJECT OF
SEPARATE APPLICATIONS

PROJECT No.		238816	
CELL No.		98260	
BT SKYLINE No.			
HA0019			
26	PROJ No	238816	
	PLANNING		24/11/21
25	PROJ No	212204	
	PLANNING		07/05/21
24	PROJ No	231660	
	MINOR AMEND		16/12/20
23	PROJ No	231660	
	PLANNING ISSUE		03/12/20
22	PROJ No	216790	
	MASTER UPDATE		17/04/20
ISS	REVISION		DATE
			DRN APP



CELLNEX UK
R+, 4TH FLOOR, 2 BLAGRAVE STREET, READING, RG1 1AZ
Tel. 020 4526 8553

SITE No 164967

RUISLIP TE
HIGH STREET
RUISLIP
HILLINGDON
GREATER LONDON 3
HA4 7BJ

NGR	TQ 09080 87490
-----	----------------

OS GRID	509080 187490
---------	---------------

TITLE	EQUIPMENT PLAN PROPOSED H3G & EE
-------	--

SCALE 1:25

DRAWN	IM	19/08/11
-------	----	----------

APPROVED	WHP	24/11/21
----------	-----	----------

DRG No.	Sheet 1 of 1	Rev
---------	--------------	-----

164967-02-101-MD026	26
---------------------	----

H3G & EE 12No. AVA7-50, 6No. LDF7-50 FEEDERS & 3No. MULTIMODE TRUNKS TO BE RE-USED (SUBJECT TO TESTING). PROPOSED 3No. SINGLE MODE TRUNK & 3No. POWER ONLY TRUNK TO BE INSTALLED. EXISTING FEEDER MANAGEMENT TO BE UTILISED.

PROPOSED 3No. YOKE BRACKET & 3No. CHS Ø60.3x5mm, 2.5m LONG ANTENNA SUPPORT POLES TO BE INSTALLED. PROPOSED SWANN 3-SECTOR SPINE TO REPLACE EXISTING ONE.

PROPOSED EE 1No. GPS MODULE AT 22.35m AGL ID No. 534753 TO BE INSTALLED ONTO PROPOSED SUPPORT POLE

PROPOSED EE 3No. 5G ANTENNAS AT 21.1m AGL 0°, 120° & 230° E.T.N. ID Nos. 534750, 534751 & 534752 TO BE INSTALLED ONTO PROPOSED YOKE BRACKETS

PROPOSED EE 3No. 16-PORT ANTENNAS AT 21.1m AGL 0°, 120° & 230° E.T.N. ID Nos. 534747, 534748 & 534749 TO BE INSTALLED ONTO PROPOSED YOKE BRACKETS

EE 3No. 8-PORT ANTENNAS AT 21.1m AGL 0°, 120° & 230° E.T.N. ID Nos. 356513, 356514 & 356515 TO BE REMOVED

PROPOSED EE 3No. Mk2 BOB's ID Nos. 534769, 534770 & 534771 TO BE INSTALLED ONTO PROPOSED SUPPORT POLES

PROPOSED EE 3No. 4480 ERS's ID Nos. 534760, 534761 & 534762 AND 3No. 4419 ERS's ID Nos. 534763, 534764 & 534765 TO BE INSTALLED ONTO PROPOSED SUPPORT POLES

 
PROPOSED EE 3No. RD0725 COMBINERS TO BE FIXED TO REAR OF PROPOSED SUPPORT POLES

EE 1No. Mk1 BOB ID No. 454525 TO BE REMOVED

EE 3No. 3262 RRU's ID Nos. 337301, 337303 & 337307 TO BE REMOVED

H3G & EE 1No. SHF 0.3m HP DISH AT 19.0m MEAN, BEARING 129° E.T.N. I.D. No. 280415

H3G & EE 1No. SHF 0.3m HP DISH AT 19.0m MEAN, BEARING 132° E.T.N. I.D. No. TBC



NORTH WEST ELEVATION

PROPOSED EE 3No. Mk2 BOB's ID Nos. 534766, 534767 & 534768 TO BE FIXED TO EXISTING GANTRY POLE

EE 1No. BTS3900L CABINET ID No. 226254 TO BE REMOVED FROM CABIN 1 EE

PROPOSEE EE 1No. AIRI CABINET ID No. 706767 TO BE INSTALLED IN CABIN 1 EE

EE 1No. Mk1 BOB TO BE REMOVED FROM CABIN 1 EE

PROPOSED EE 3No. 2460 700/800 ERS's I.D. Nos. 534757, 534758 & 534759 & 3No. RD0759 COMBINERS TO BE INSTALLED ON PROPOSED TOUCAN RACK

GROUND LEVEL 0.0m

FEINT DETAILS INDICATE LOCATIONS RESERVED FOR OTHER PROPOSALS WHICH MAY BE THE SUBJECT OF SEPARATE APPLICATIONS

NOTES

PROJECT No.		238816		
CELL No.		98260		
BT SKYLINE No.				
HA0019				
26	PROJ No	238816		
	PLANNING		24/11/21	WHP
25	PROJ No	212204		
	PLANNING		07/05/21	DAL
24	PROJ No	231660		
	MINOR AMEND		16/12/20	HFC
23	PROJ No	231660		
	PLANNING ISSUE		03/12/20	HFC
22	PROJ No	216790		
	MASTER UPDATE		17/04/20	TCS
ISS	REVISION		DATE	DRN
cellnex driving telecom connectivity				
CELLNEX UK R+, 4TH FLOOR, 2 BLA GRAVE STREET, READING, RG1 1AZ Tel. 020 4526 8553				
SITE No 164967				
RUISLIP TE				
HIGH STREET				
RUISLIP				
HILLINGDON				
GREATER LONDON 3				
HA4 7BJ				
NGR		TQ 09080 87490		
OS GRID		509080 187490		
TITLE				
ELEVATION				
PROPOSED				
H3G & EE				
SCALE 1:100				
DRAWN		IM	19/08/11	
APPROVED		WHP	24/11/21	
DRG No.		Sheet 1 of 1	Rev	
164967-02-150-MD026		26		

NOTES

PROJECT No. 238816

CELL No. 98260

BT SKYLINE No.
HA0019

26	PROJ No	238816	24/11/21	WHP	WHP
	PLANNING				
25	PROJ No	212204	07/05/21	DAL	DAL
	PLANNING				
24	PROJ No	231660	16/12/20	HFC	HFC
	MINOR AMEND				
23	PROJ No	231660	03/12/20	HFC	HFC
	PLANNING ISSUE				
22	PROJ No	216790	17/04/20	TCS	MF
	MASTER UPDATE				
ISS	REVISION		DATE	DRN	APP



CELLNEX UK
R+, 4TH FLOOR, 2 BLA GRAVE STREET, READING, RG1 1AZ
Tel. 020 4526 8553

SITE No 164967

RUISLIP TE
HIGH STREET
RUISLIP
HILLINGDON
GREATER LONDON 3
HA4 7BJ

NGR TQ 09080 87490

OS GRID 509080 187490


TITLE
ANTENNA PLAN
PROPOSED
H3G & EE

SCALE 1:25

DRAWN	IM	19/08/11
APPROVED	WHP	24/11/21

DRG No.	Sheet 1 of 1	Rev
164967-02-151-MD026		26

FEINT DETAILS INDICATE LOCATIONS
RESERVED FOR OTHER PROPOSALS
WHICH MAY BE THE SUBJECT OF
SEPARATE APPLICATIONS

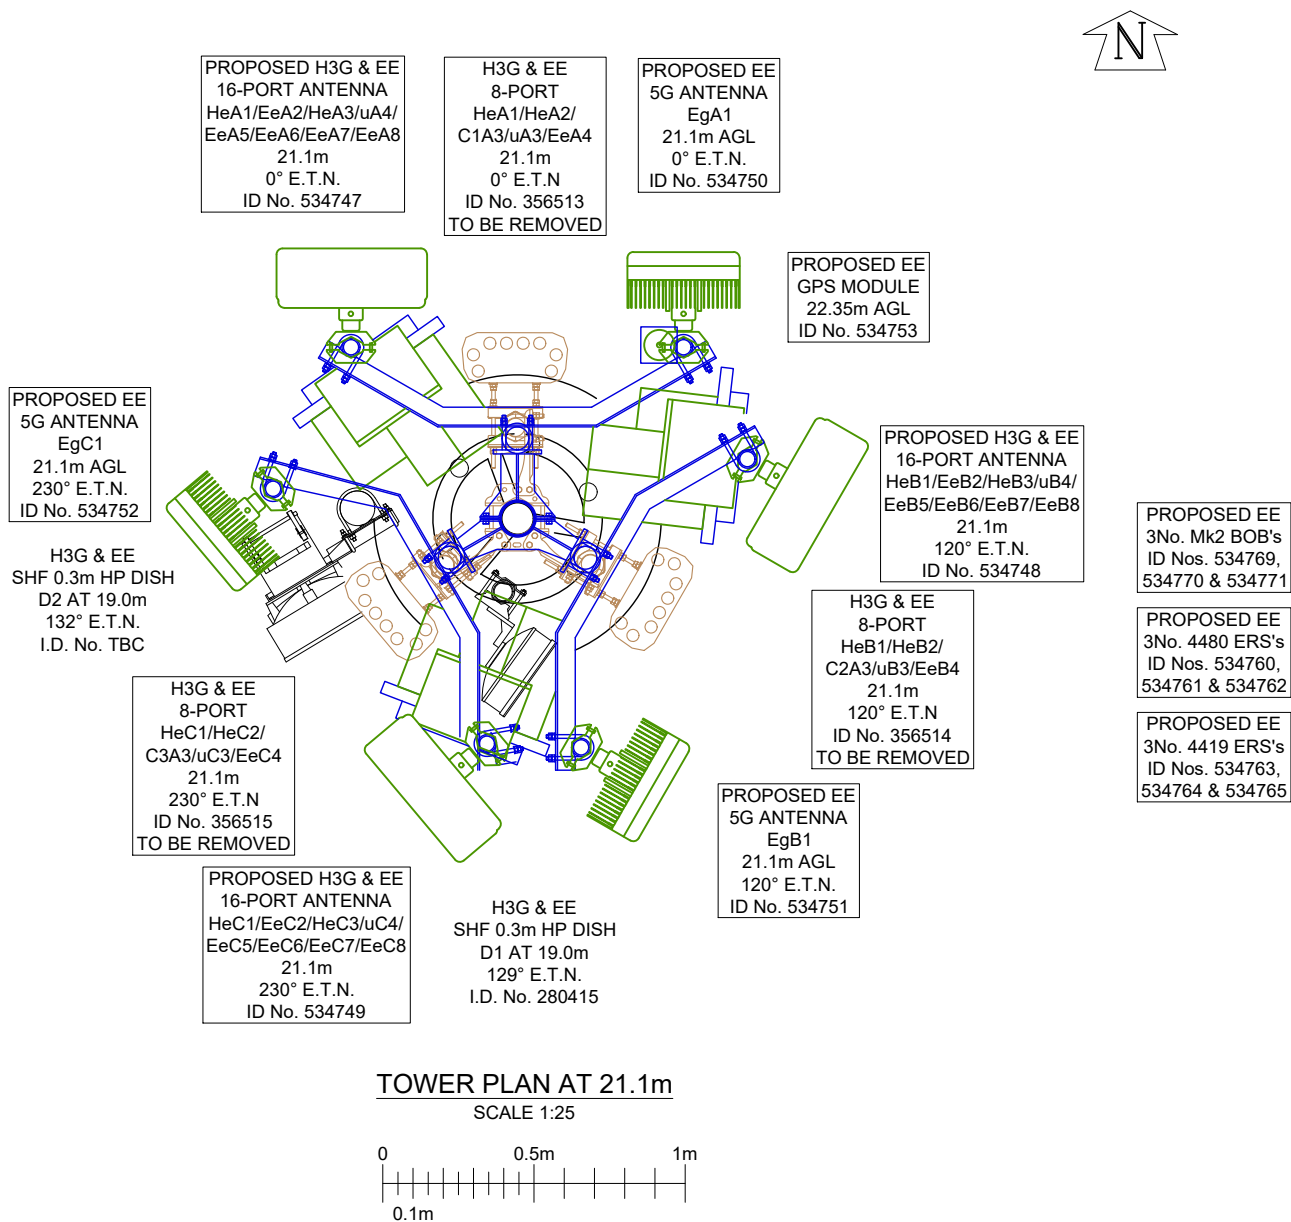

TOWER PLAN AT 21.1m
SCALE 1:25

