


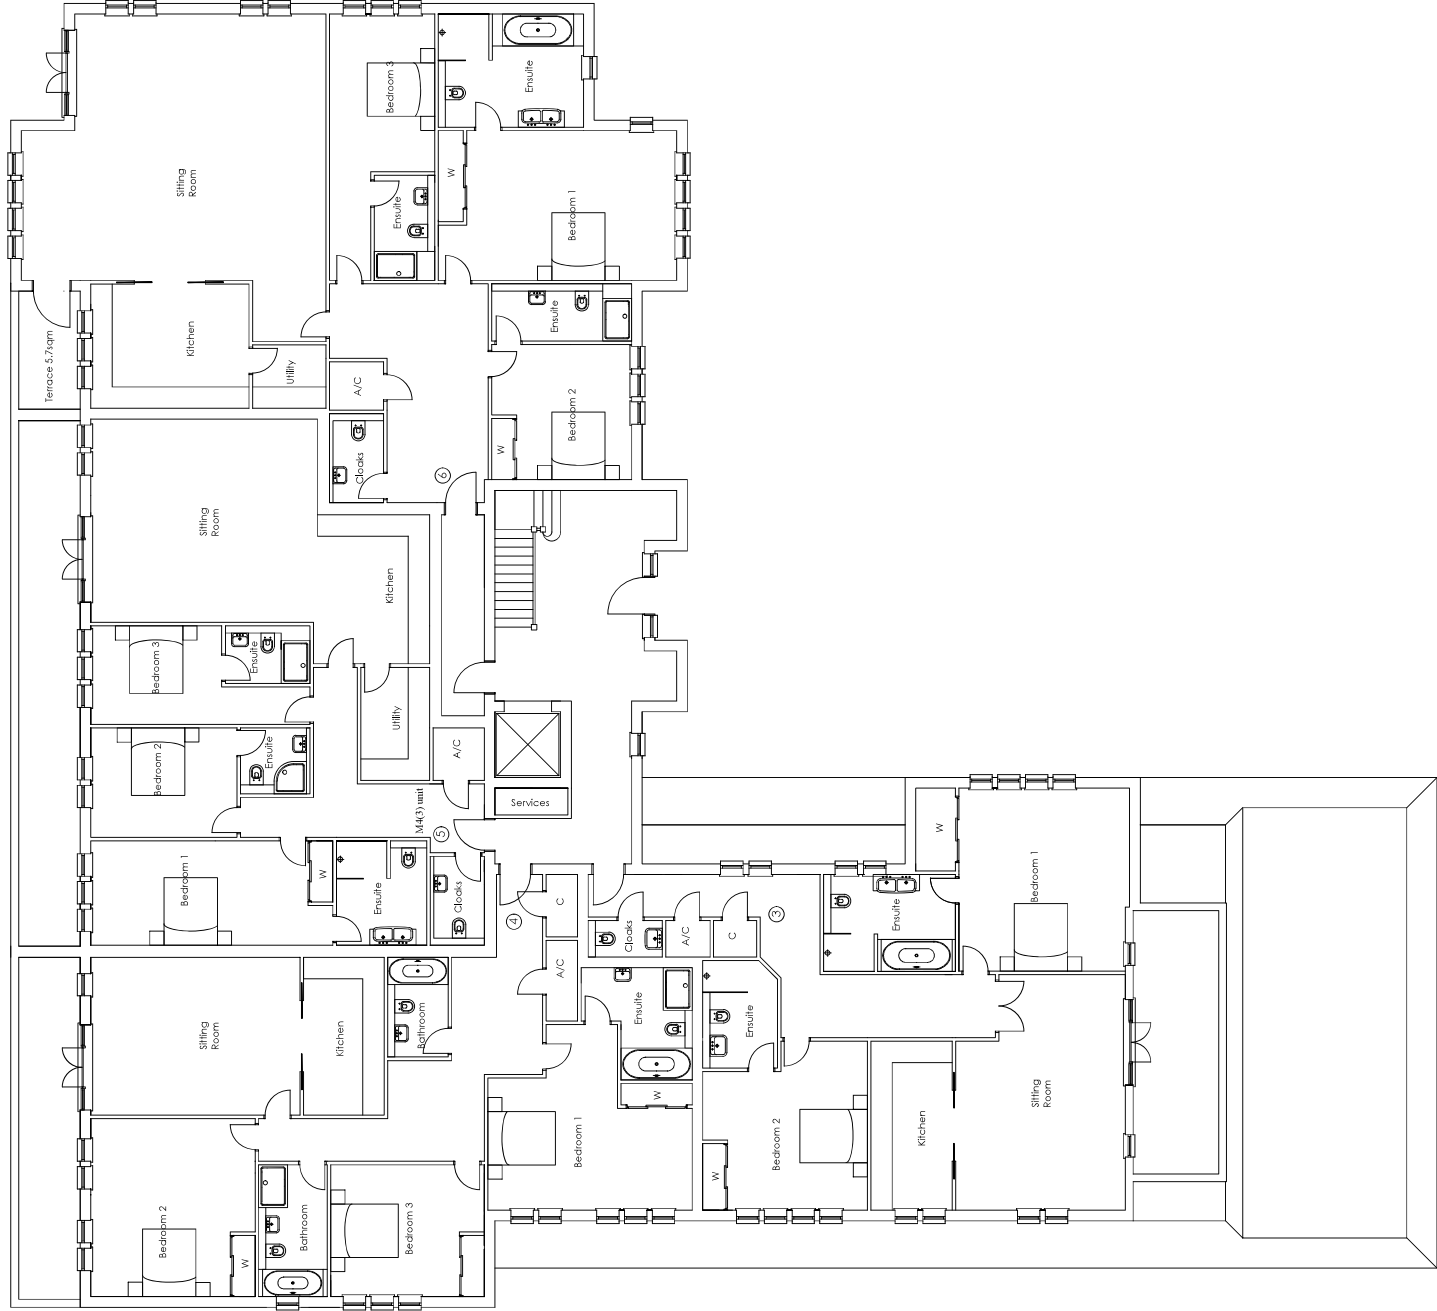

Rev	Date	Description

**Fluent**
ARCHITECTURAL DESIGN SERVICES

FLUENT
ARCHITECTURAL DESIGN SERVICES
251 GARDEN ROAD, #12-01, SINGAPORE 090473
TEL: 65 6339 9292 FAX: 65 6339 9293
WWW.FLUENTDESIGN.COM

Client:
Westcombe Homes Ltd

LST Site C, Green Lane, Northwood

Ground Floor Plan

1:100 @ A3

Scale	Dwg No.
1:100 @ A2	FLU.249.4.04
Date	Rev
24.02.19	J
Drawn	N.Millin