





Rev	Date	Description

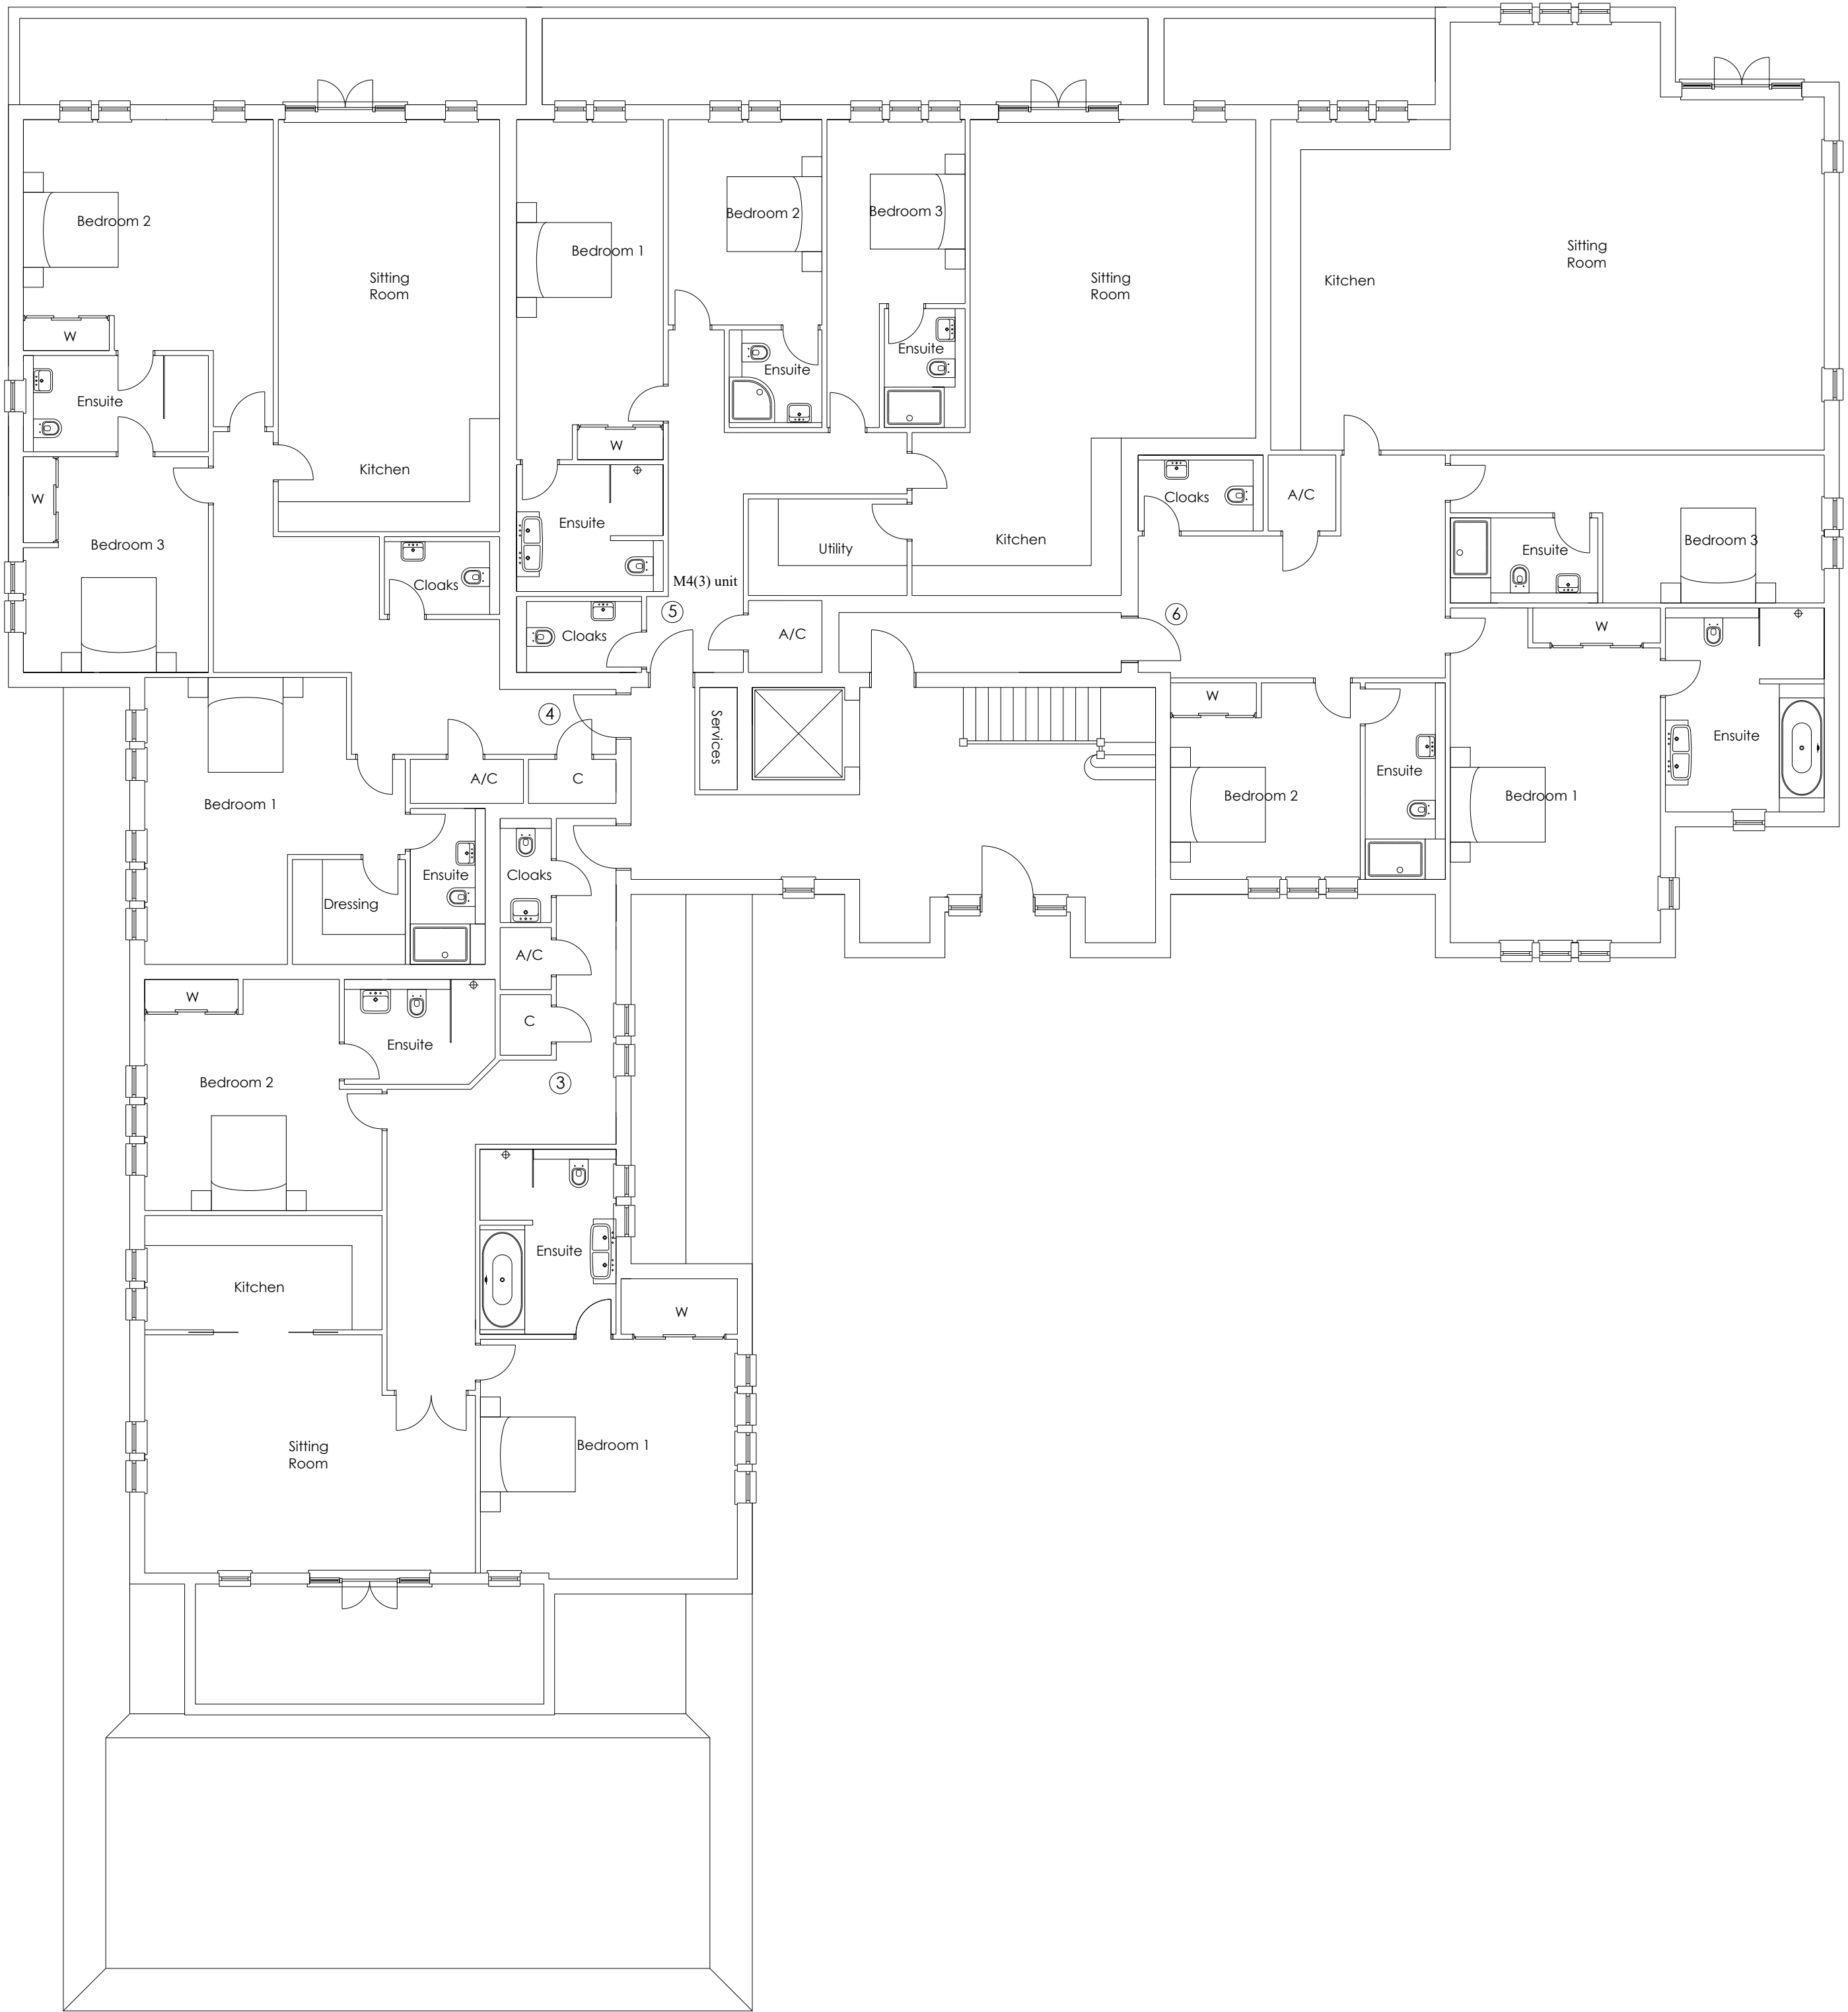

FLUENT
ARCHITECTURAL DESIGN SERVICES

FLUENT
ARCHITECTURAL DESIGN SERVICES
221 CLARE ROAD, STAINES,
MIDDLESEX, TW19 7EF
TEL: 01784 391674 MOB: 07841 848473
E-MAIL: TOMMILLIN@FLUENT-ADS.CO.UK
WEB: FLUENT-ADS.CO.UK

 Client :
Westcombe Homes Ltd
LST Site C, Green Lane, Northwood
Ground Floor Plan



Scale	Dwg No.
1:100 @ A2	FLU.249.4.04
Date	Rev
24.02.19	E
Drawn	
N.Millin	