



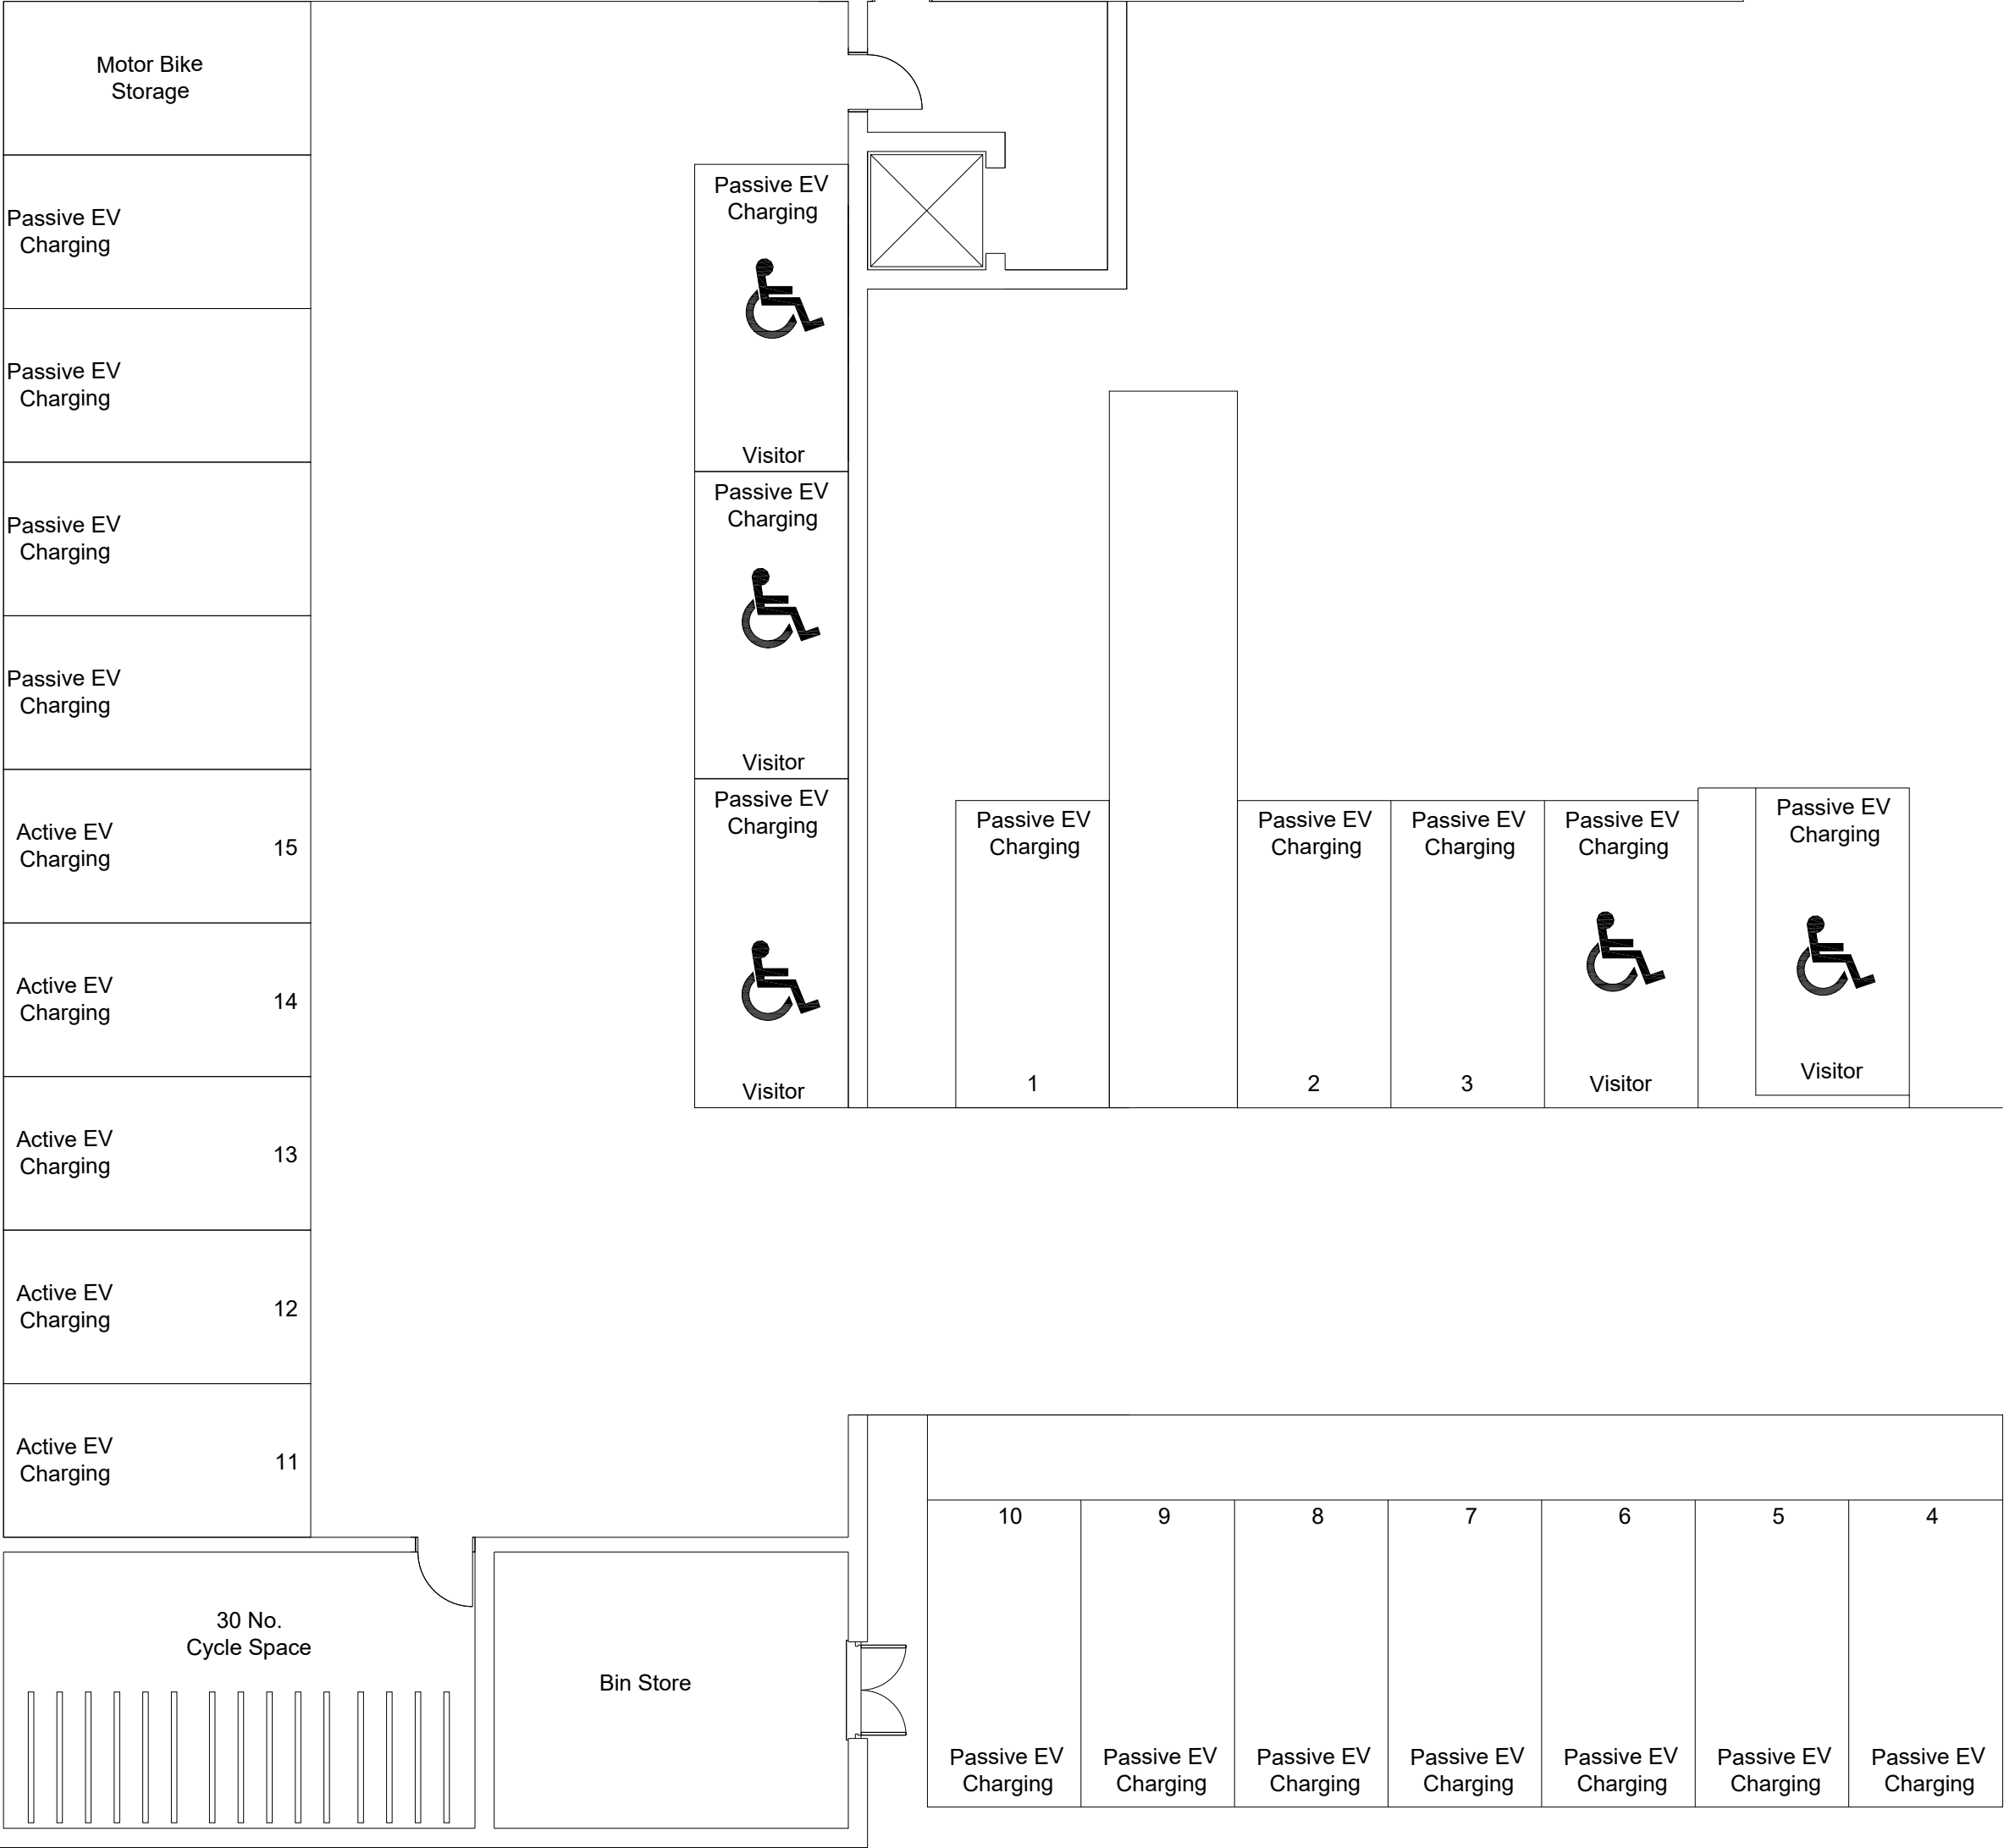

Rev	Date	Description

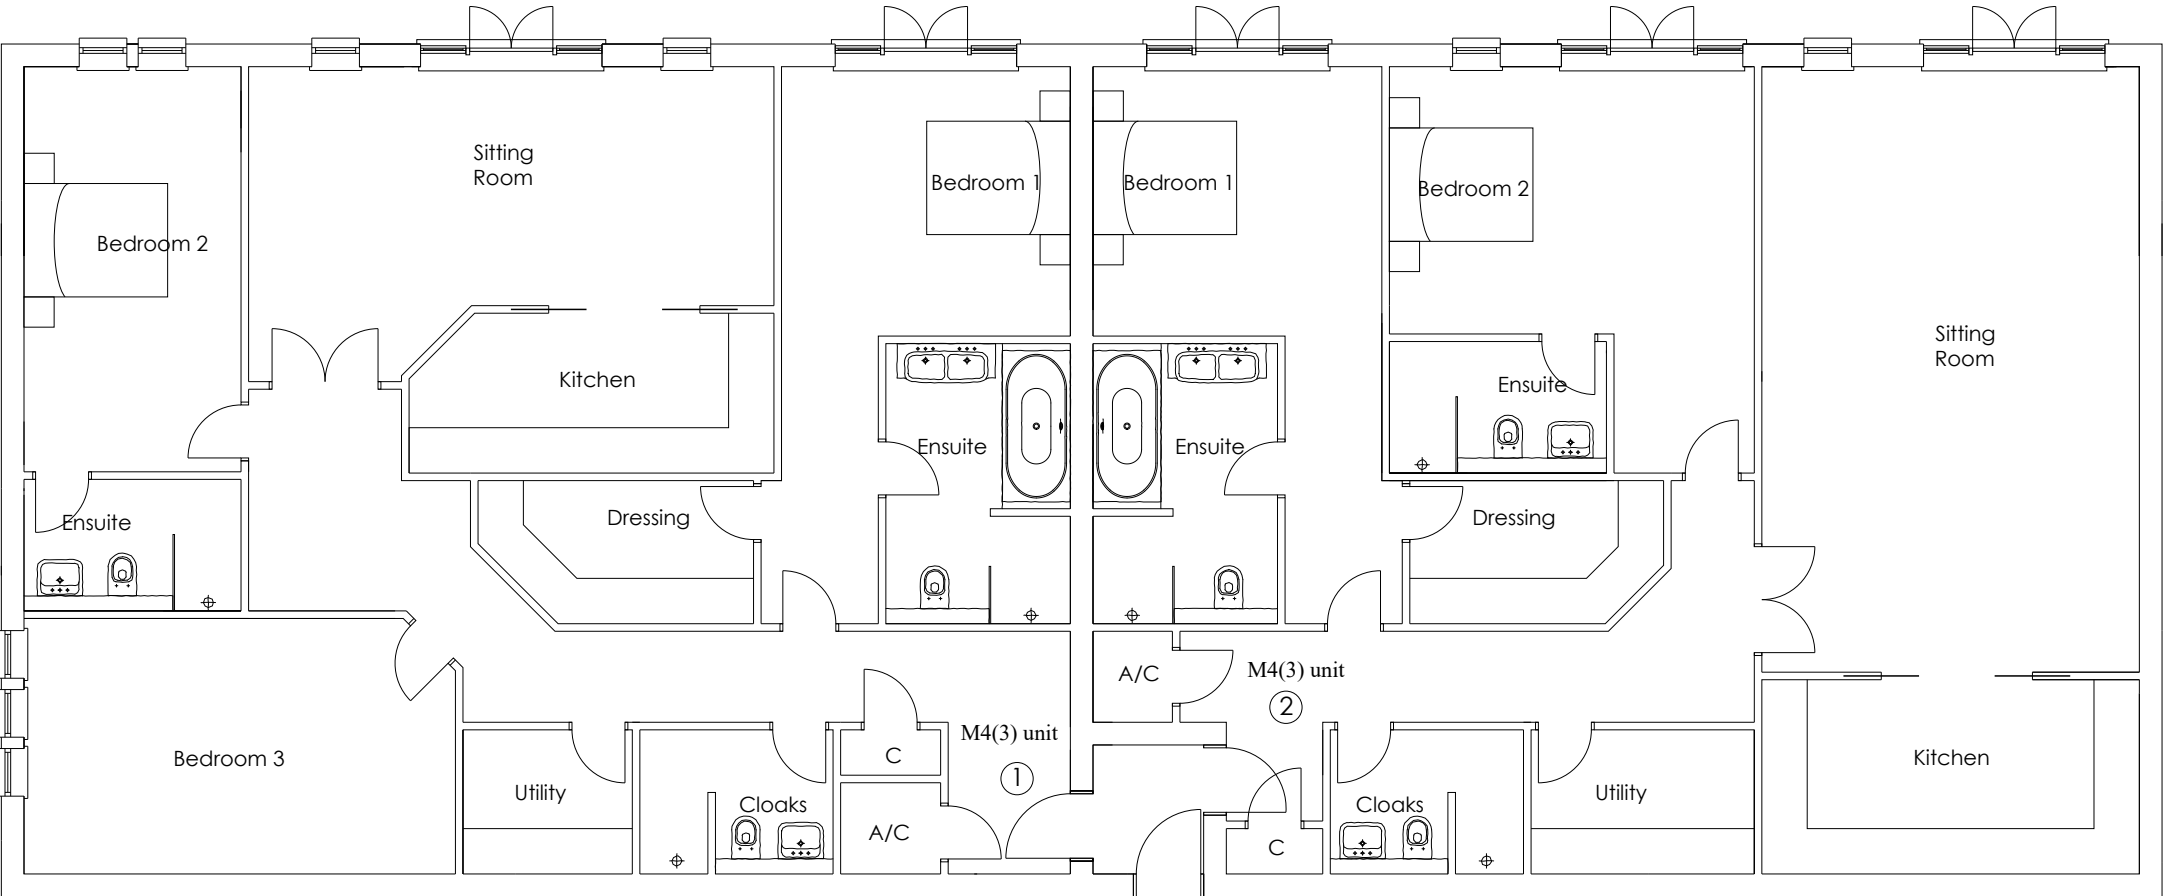

FLUENT
ARCHITECTURAL DESIGN SERVICES

221 CLARE ROAD, STAINES,
MIDDLESEX, TW19 7EF
TEL: 01784 391674 MOB: 07841 848473
E-MAIL: TOM.MILLIN@FLUENT-ADS.CO.UK
WEB: FLUENT-ADS.CO.UK

Client :
Westcombe Homes Ltd
LST Site C, Green Lane, Northwood
Basement Floor Plan



Scale	1:100 @ A2	Dwg No.	FLU.249.5.03
Date	24.02.19	Rev	
Drawn	N.Millin		A