




SOLAR PANELS

ROOF LIGHTS

UNIT B - ROOF PLAN

55

2

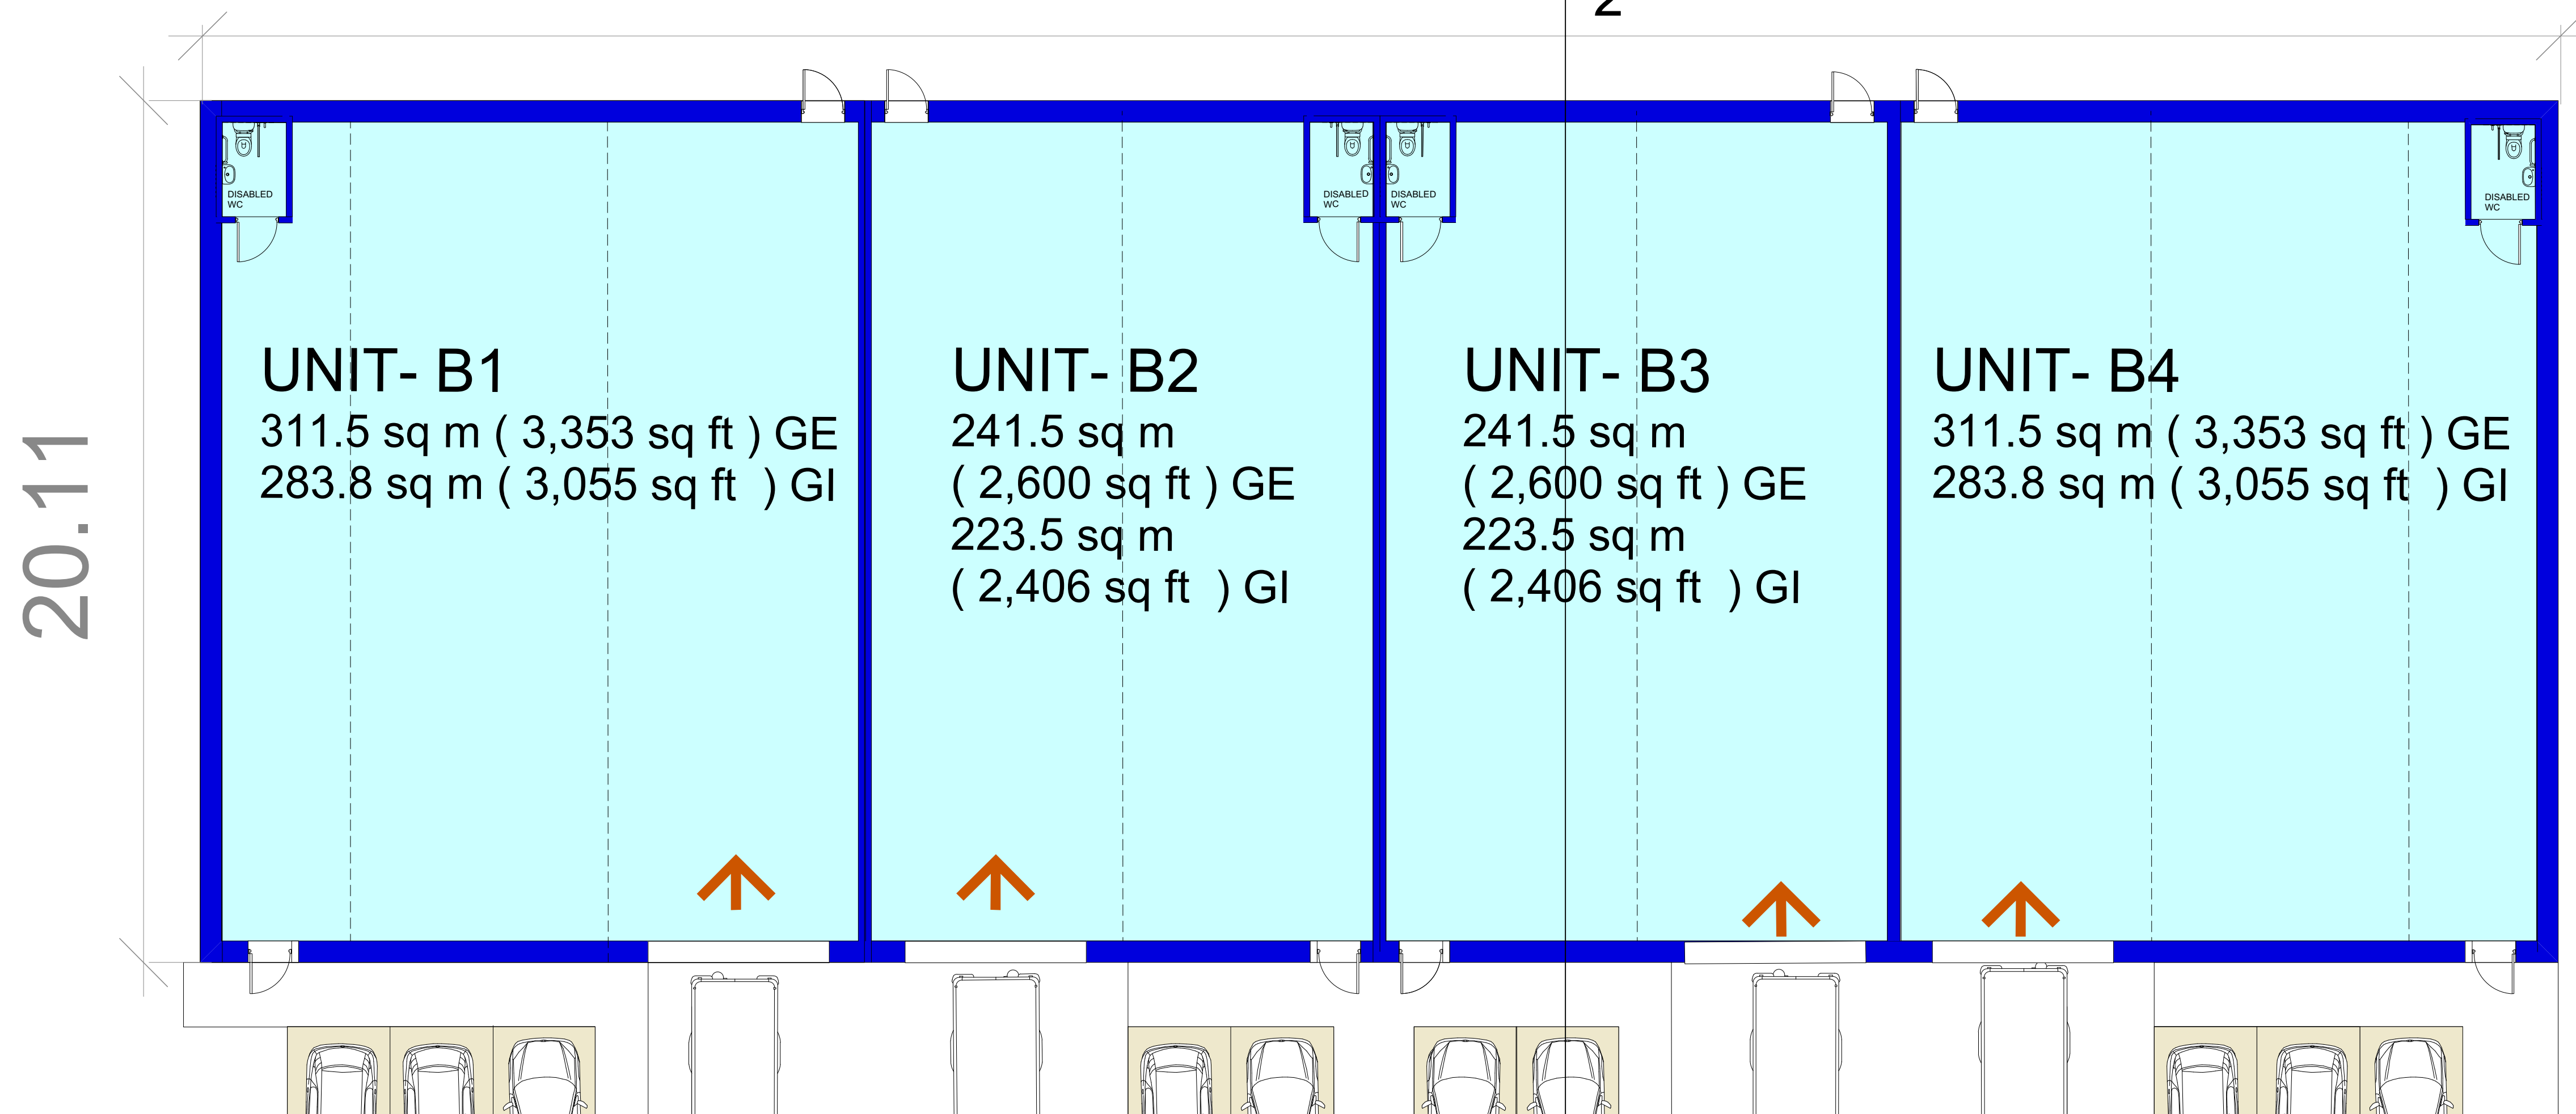

UNIT B - FLOOR PLAN

REV.	DATE	DESCRIPTION
PROJECT		
FROGSDITCH SHEPISTON LANE HEATHROW UB3 1LL		
DRAWING		
UNIT B FLOOR PLAN & ROOF PLAN		
CLIENT		
CAPPARD ESTATES		
SCALE		DRAWN
1:100		
DATE		CHECK
DEC 2021		KO
DRAWING No.		REVISION
2021-FF - PL03		
© copyright retained		

HEROKO

27 Cambridge Park Court
Cambridge Park
Twickenham
Middlesex
TW1 2JN

t - 07595913048
e - ko@heroko.co.uk