


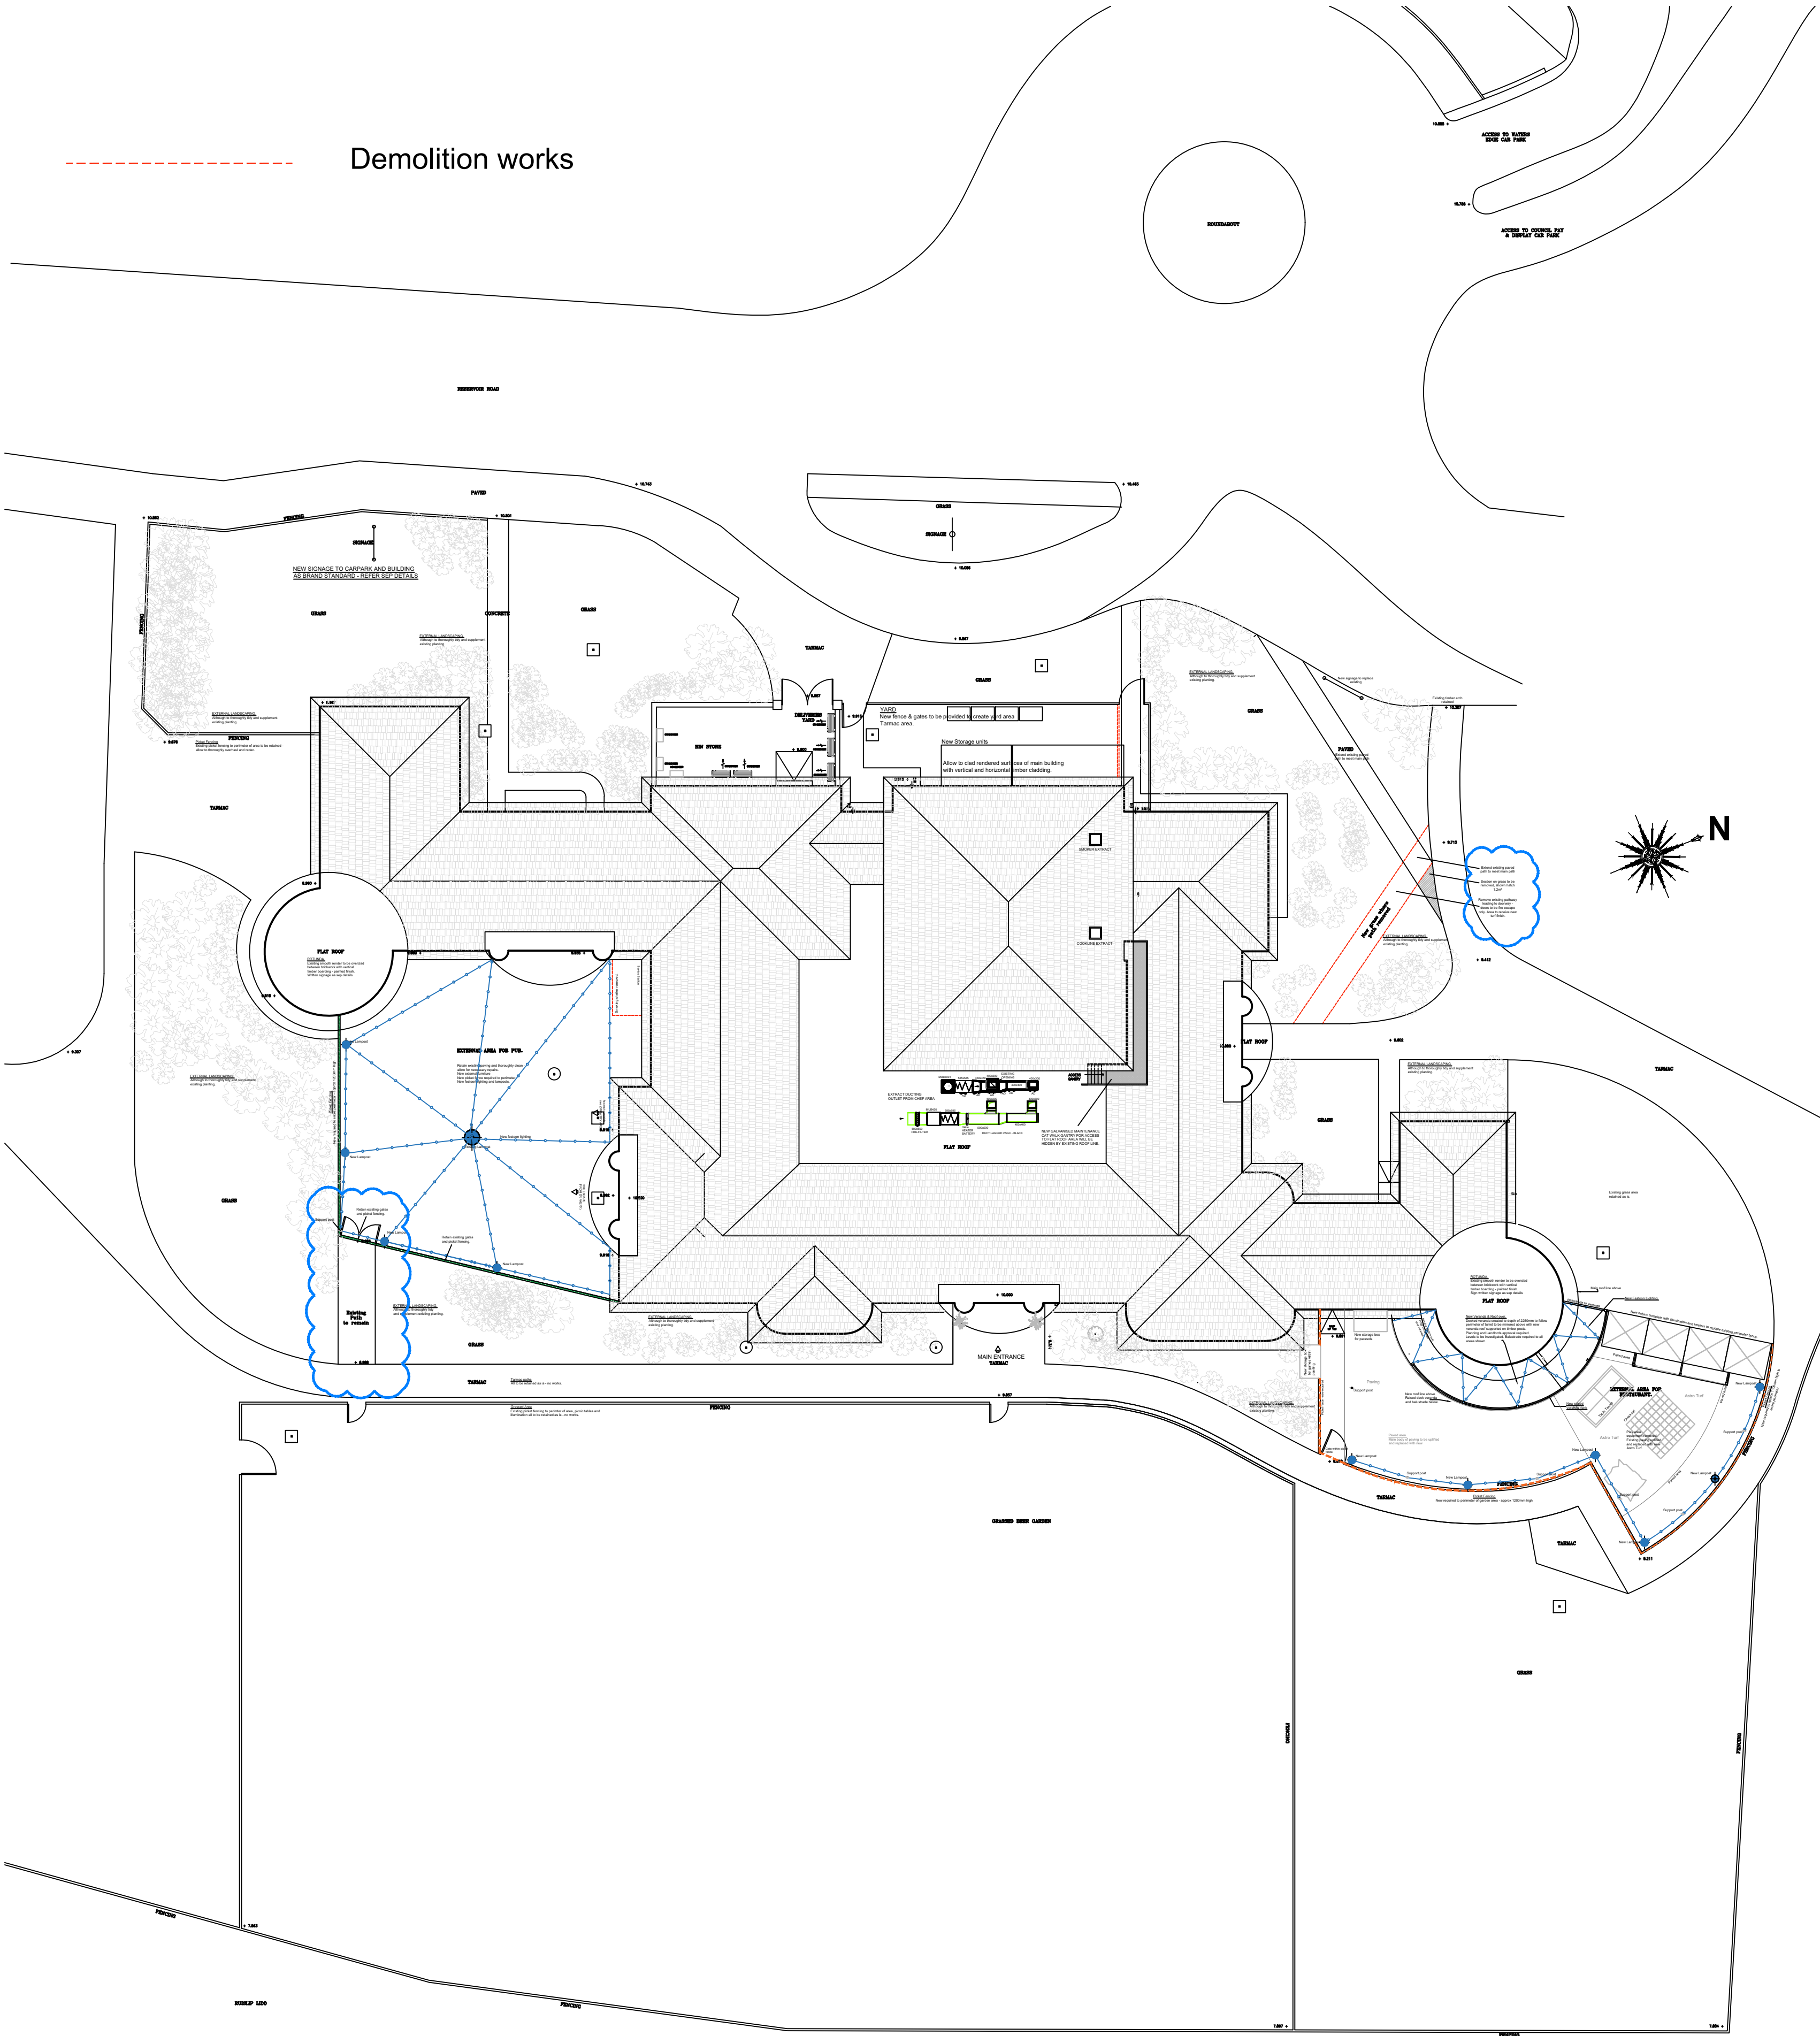

FESTOON LIGHTING

IP65 rated connectable festoon harness
3m lead included with every set
50m spacing
Connect multiple sets together up to 100m.
Maximum of 5w LED per bulb


Symbol indicates
line of festoon lighting



Lamp Post lantern
H = 3200mm, W = 320mm, D = 320mm
Max wattage 60W/E27

Symbol indicates
lamp posts on plan

EXISTING ILLUMINATION.
All existing building and site illumination to be retained
and supplemented with new as above.

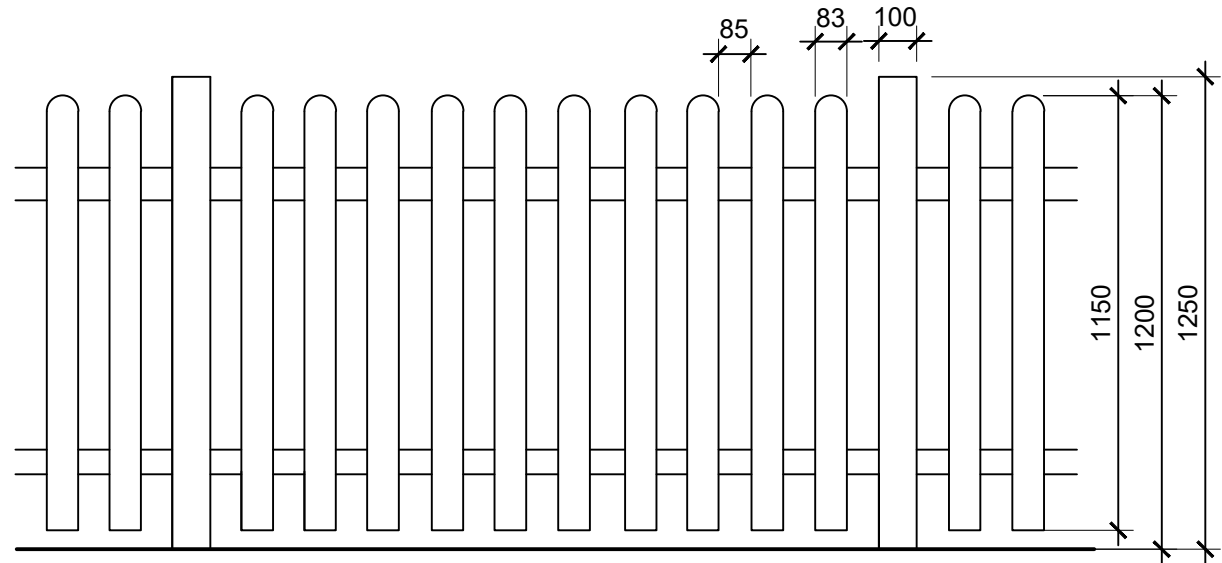

NEW PICKET FENCE

New picket fencing (Dog Ear style) to be constructed of
83 x 16mm individual pickets, with 100 x 100mm posts
secured with softwood tapered cross braces running top
and bottom. Finish to be painted White.

Symbol indicates
line of new picket fence

Symbol indicates
line of picket existing fence



SITE LOCATION PLAN
Scale 1:1250 @ A1



A	Existing path retained,	GT	12.06.24
PEMBROOK design & project management Sworders Court Yard - 19D North Street, Bishops Stortford, Herts. CM23 2LD Tel: 01279 433888, Fax: 01279 433889, E-Mail: pembrook@pembrook.co.uk Website: www.pembrook.co.uk			
Client		Mitchells & Butlers	
Project		The Waters Edge Reservoir Road Ruislip HA4 7TY	
Drawing Title		Proposed site plans and site location plan	
Drawing No		3404-126	
Scale		1:500 & 1:200 & 1:1250 @ A1	
Date		24.04.23	
Drawn By		SC/GT	
Revision		A	