



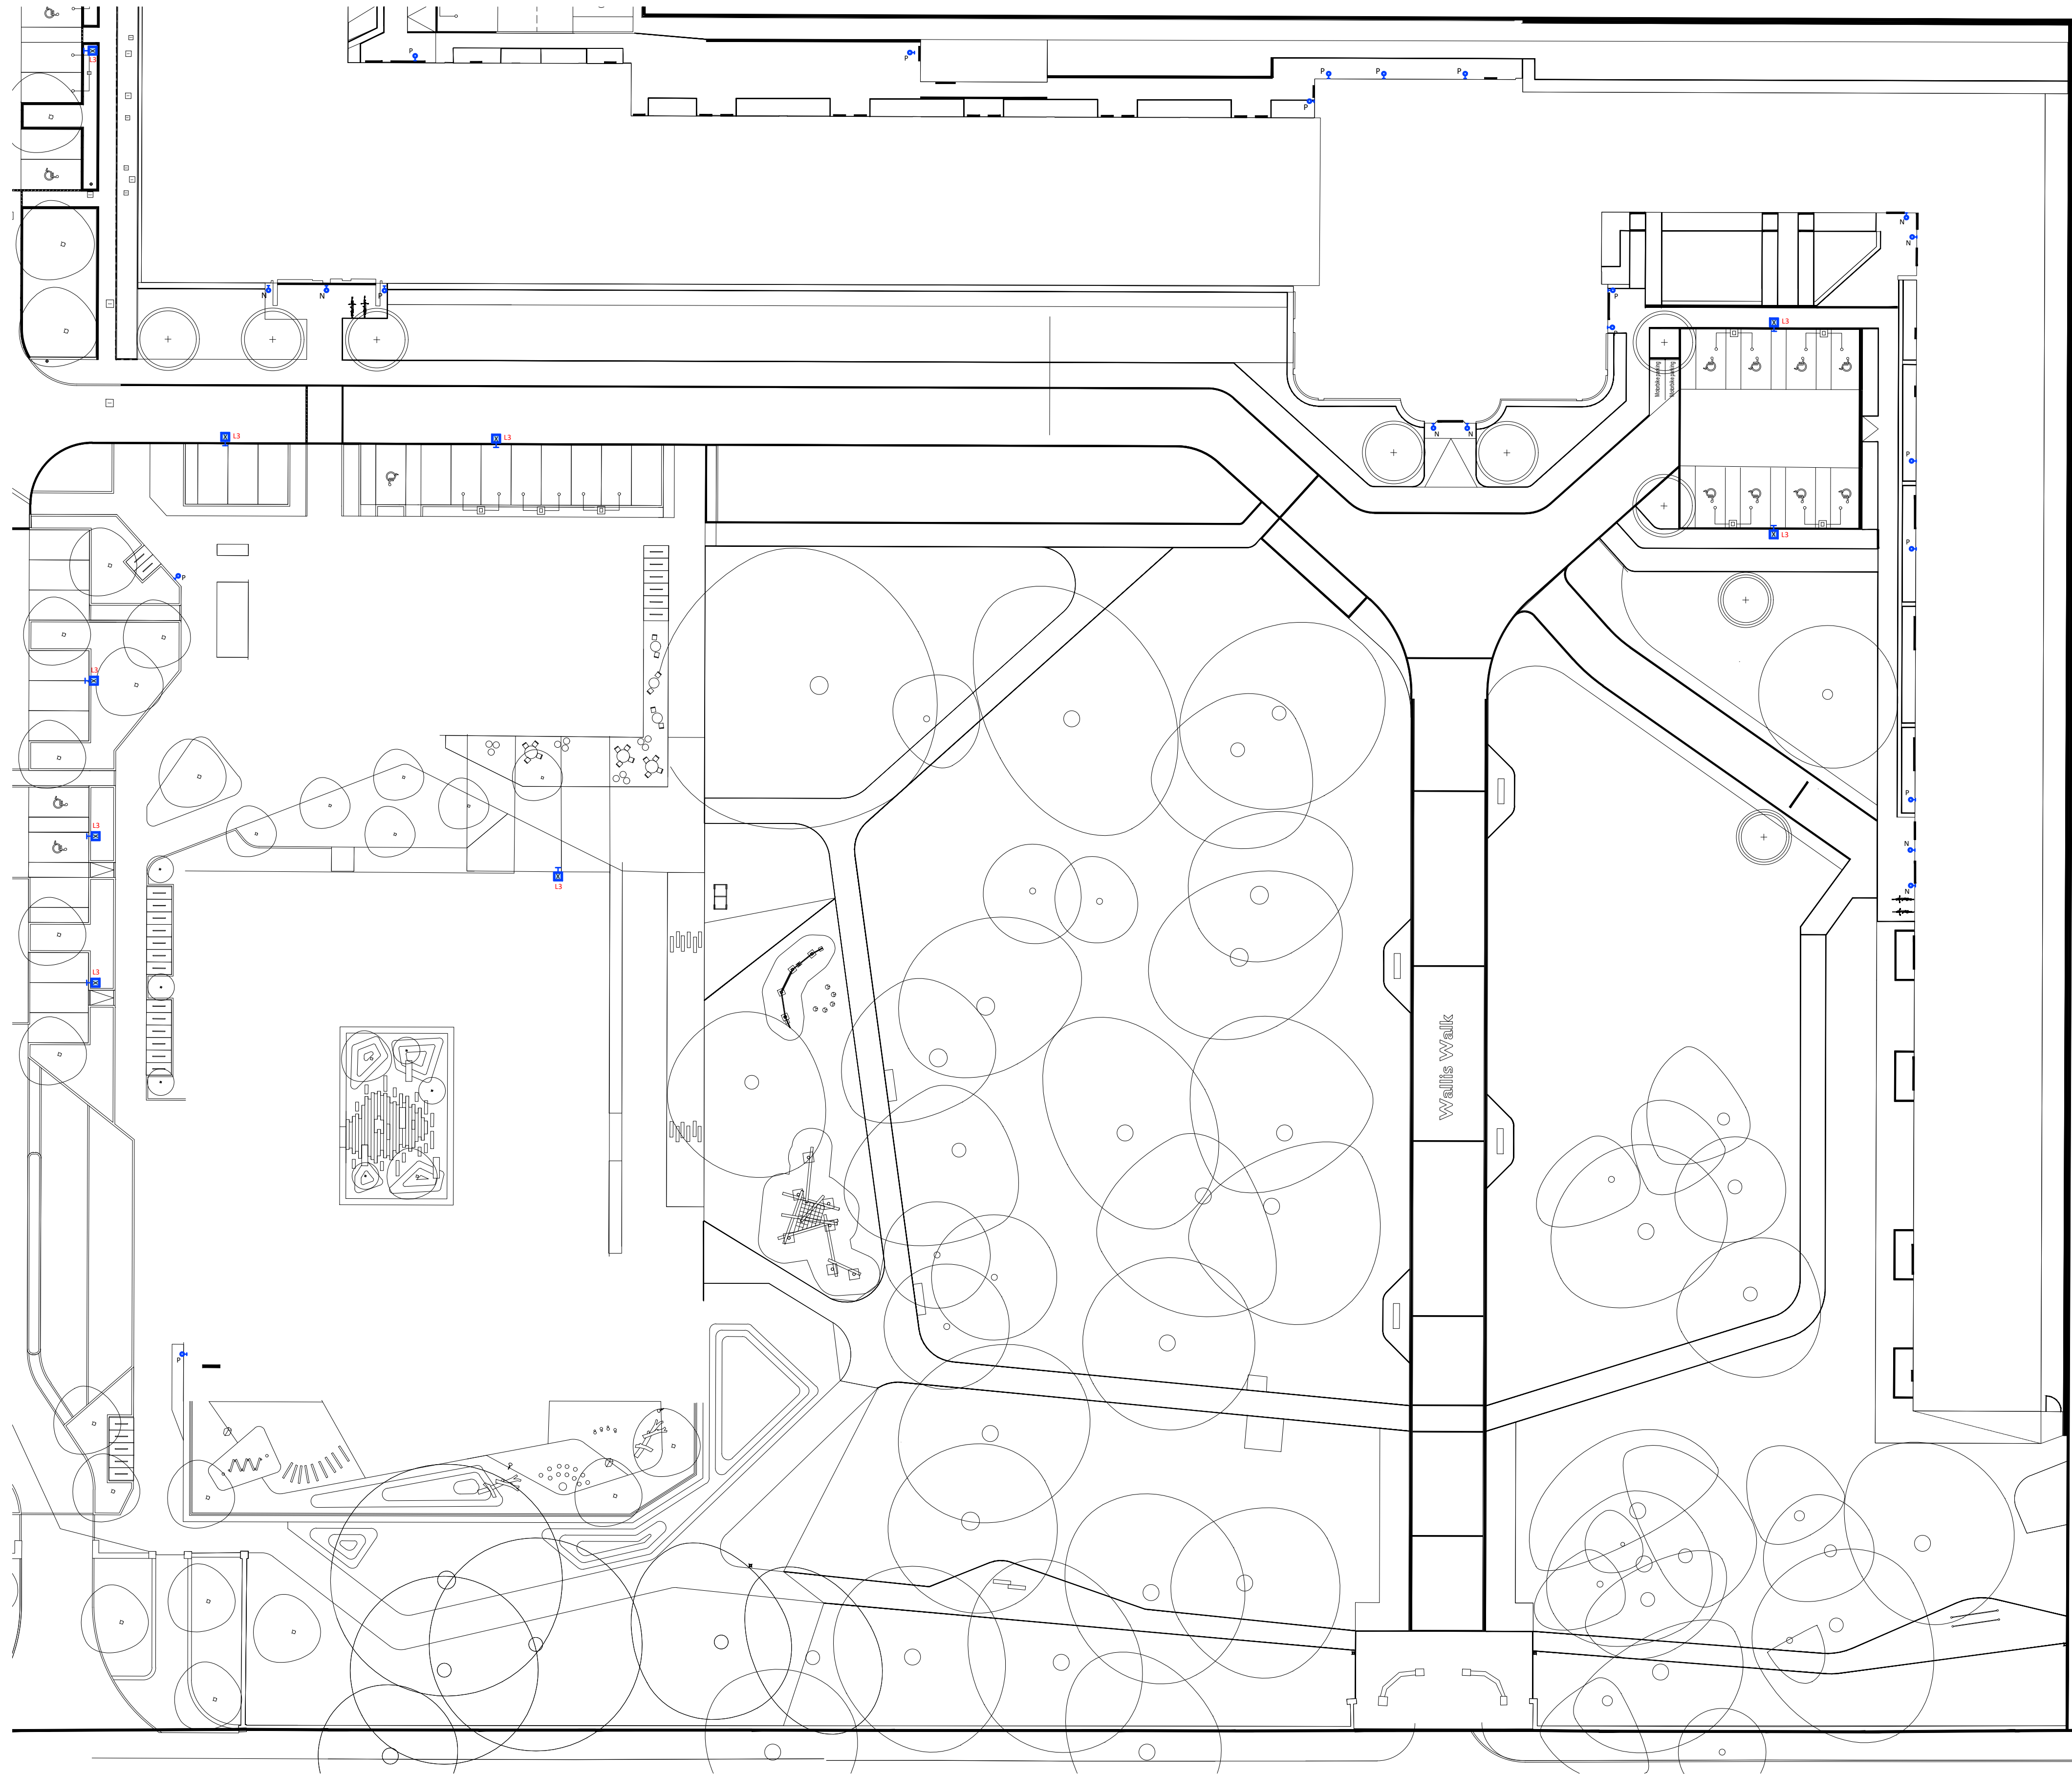

- LEGEND:
- WALKY - ROUND OPTIC ASSEMBLY Ø200MM - AL OPTIC - NEUTRAL WHITE LED - 220-240VAC - DALI - 12.7W 445.5LM - 4000K. MANUFACTURER: GUZZINI.
 - ROOF MOUNTED BOLLARD 1M HIGH 12W LED BOLLARD LUMINAIRE C/W/TRIPLE LENS AND LOUVER AS HALOPNE DENVER RANGE. MANUFACTURER: HALOPNE.
 - 5M HIGH COLUMN MOUNTED 10W LED PV SUPPLIED LUMINAIRE, AS PRO ELECTRIC SOLAR LIGHTING. MANUFACTURER: PRO ELECTRIC.
 - TREE UPLIGHTER FIXTURE WITH STAINLESS STEEL FINISH WITH 4000K AND IP68. MANUFACTURER: ORLIGHT ORLLM96-RC-4000K.
 - LINEAR LED LIGHTING FOR HANDRAIL IP66. MANUFACTURER: THORLUX LIGHTING.
 - WALL MOUNTED FEATURE LIGHT 11W LED IP65 RATED CIRCULAR TUBE, POLISHED GALVANISED STEEL FINISH MOUNTED AT 1600mm AFFL. AS ORLIGHT ORL3020.
 - WALL MOUNTED CIRCULAR 13W LED IP65 RATED LUMINAIRE, BLACK FINISH AND OPAL DIFFUSER, MOUNTED AT 1800mm AFFL. AS ORLIGHT ORL155155.

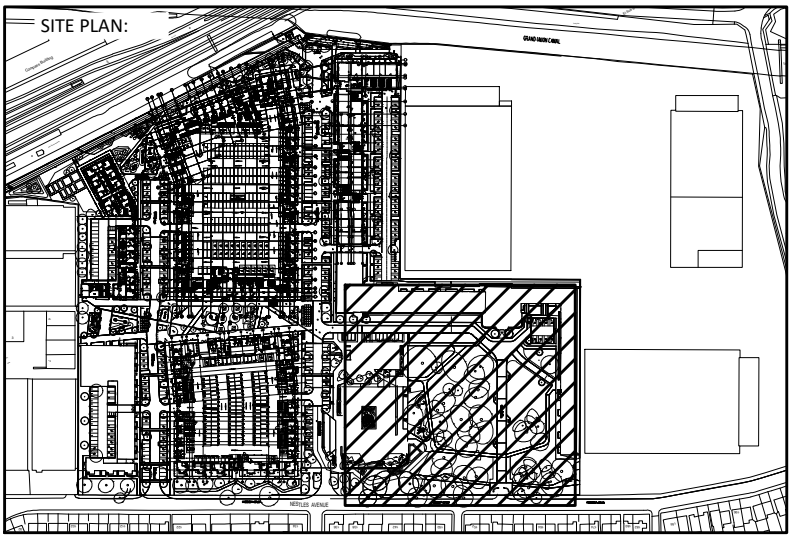

UPDATED IN LINE WITH REVISED LANDSCAPE GA & LIGHTING WHISK COLUMNS ADDED

- FOR SETTING OUT REFER TO ARCHITECT'S DRAWINGS.
- THIS DRAWING TO BE READ IN CONJUNCTION WITH ALL OTHER ARCHITECTURAL AND ENGINEERING DRAWINGS AND ALL OTHER RELEVANT DRAWINGS AND SPECIFICATIONS.
- DO NOT SCALE THIS DRAWING. USE FIGURED DIMENSIONS ONLY.
- NO PART OF THIS DOCUMENT MAY BE REPRODUCED OR TRANSMITTED IN ANY FORM OR STORED IN ANY RETRIEVAL SYSTEM OF ANY NATURE WITHOUT THE WRITTEN PERMISSION OF C CONNOR SUTTON CROWN AS COPYRIGHT HOLDER EXCEPT AS AGREED FOR USE ON THE PROJECT FOR WHICH THE DOCUMENT WAS ORIGINALLY ISSUED.

Rev No.	Date	Revision Note	Drm by	Chkd by
P01	30.10.18	ISSUE FOR INFORMATION	J.D.	J.S.
P02	14.12.18	UPDATED WITH CLIENT COMMENTS	J.D.	J.S.
P03	14.02.19	DRAFT NOTE OMITTED & LEGEND UPDATED	J.D.	J.S.
P04	28.08.20	ISSUE FOR INFORMATION	CAD	J.S.
P05	08.10.20	UPDATED TO SUIT NEW PATH LAYOUT	CAD	J.S.
P06	09.01.24	UPDATED TO SUIT NEW LANDSCAPE REQUIREMENT	D.F.	A.R.

Rev No.	Date	Revision Note	Drm by	Chkd by

BARRATT
LONDON



40 BOWLING GREEN LANE,
LONDON, EC1R 0NE,
UNITED KINGDOM.

TEL +44 207 415 7120
e: OCSC@OCSC.CO.UK
w: WWW.OCSC.CO.UK

Dublin | London | Belfast | Galway | Cork

Client: BARRATT LONDON
Project: FORMER NESTLE FACTORY, HAYES

Title: ELECTRICAL SERVICES
SITEWIDE EXTERNAL LIGHTING LAYOUT
SHEET 2 OF 3

PROJECT | DISCIPLINE | ZONE | ORIGINATOR | TYPE | NUMBER | REVISION
FNF - N - SITE - OCSC - GA - 51-011 - P06
Date: 31.01.18 Scale: 1:200 @ A0 Drm by: J.D. Chkd by: A.B. Aprvd by: J.S.