

 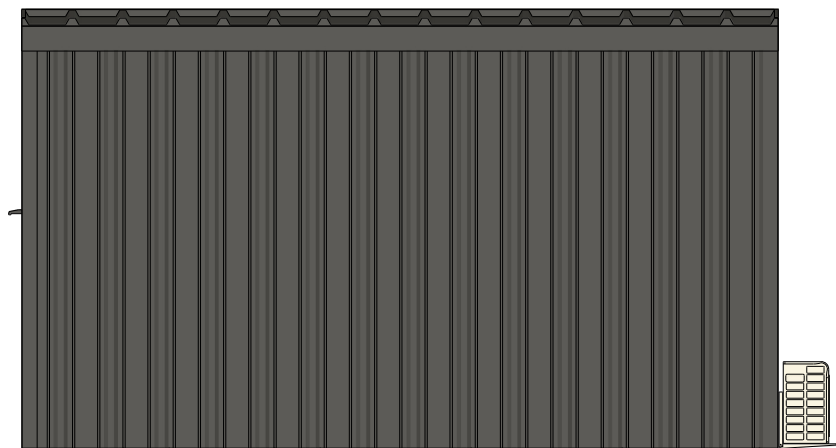


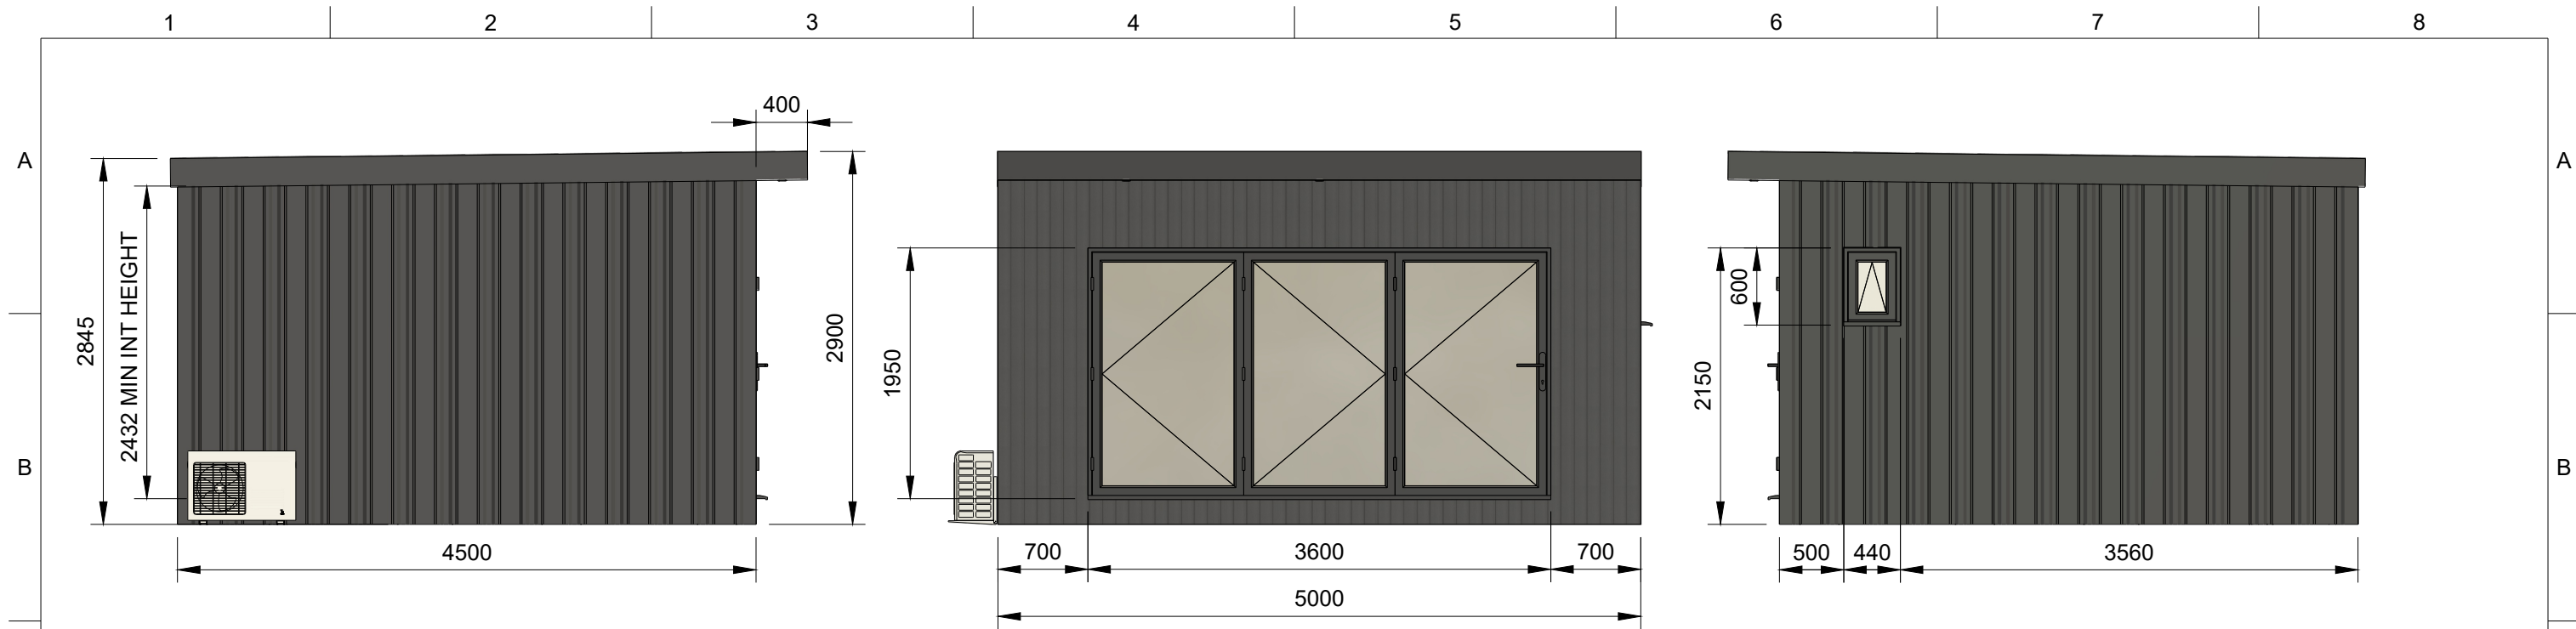

SCALE BAR 1:50 (m)




NOTES:
• SEE SEPARATE WRITTEN SPECIFICATION CHECKLIST FOR MAIN DETAILS

C	29/09/2025	EXTERNAL FINISH / AC LOCATION
B	24/09/2025	MOVE MIRROR / ADD WINDOW / ADD EXT LIGHTS
A	22/08/2025	FIRST ISSUE
REVISION	DATE	DESCRIPTION
2		



Woodlands Home & Garden Group
Unit 1, Thornbury Industrial Estate,
BD3 7AF
T: 0113 258 4326
woodlandsgroup.com

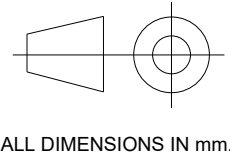

ALL DIMENSIONS IN mm.

Size
A3

Scale
1:50
Date drawn
22/07/2025

Created by
Peter Stevens
Approved by



Title
General Arrangement
DWG No.
3657-GA-001

Rev.
C
Sheet
1/3

ELECTRICAL LAYOUT / PLAN VIEW

BASE SIZE + 45 CLADDING PER WALL
BASE SIZE + 60 STEEL PER WALL

Parts List		
Item	Qty	Part Number
1	3	External Spotlight
2	1	WiFi
3	1	Air Conditioning [outdoor unit]
4	1	Fuseboard
5	4	Internal Double Wall Socket
6	6	Internal Spotlight
7	1	Air Conditioner
8	2	External Up/Down Wall Lights

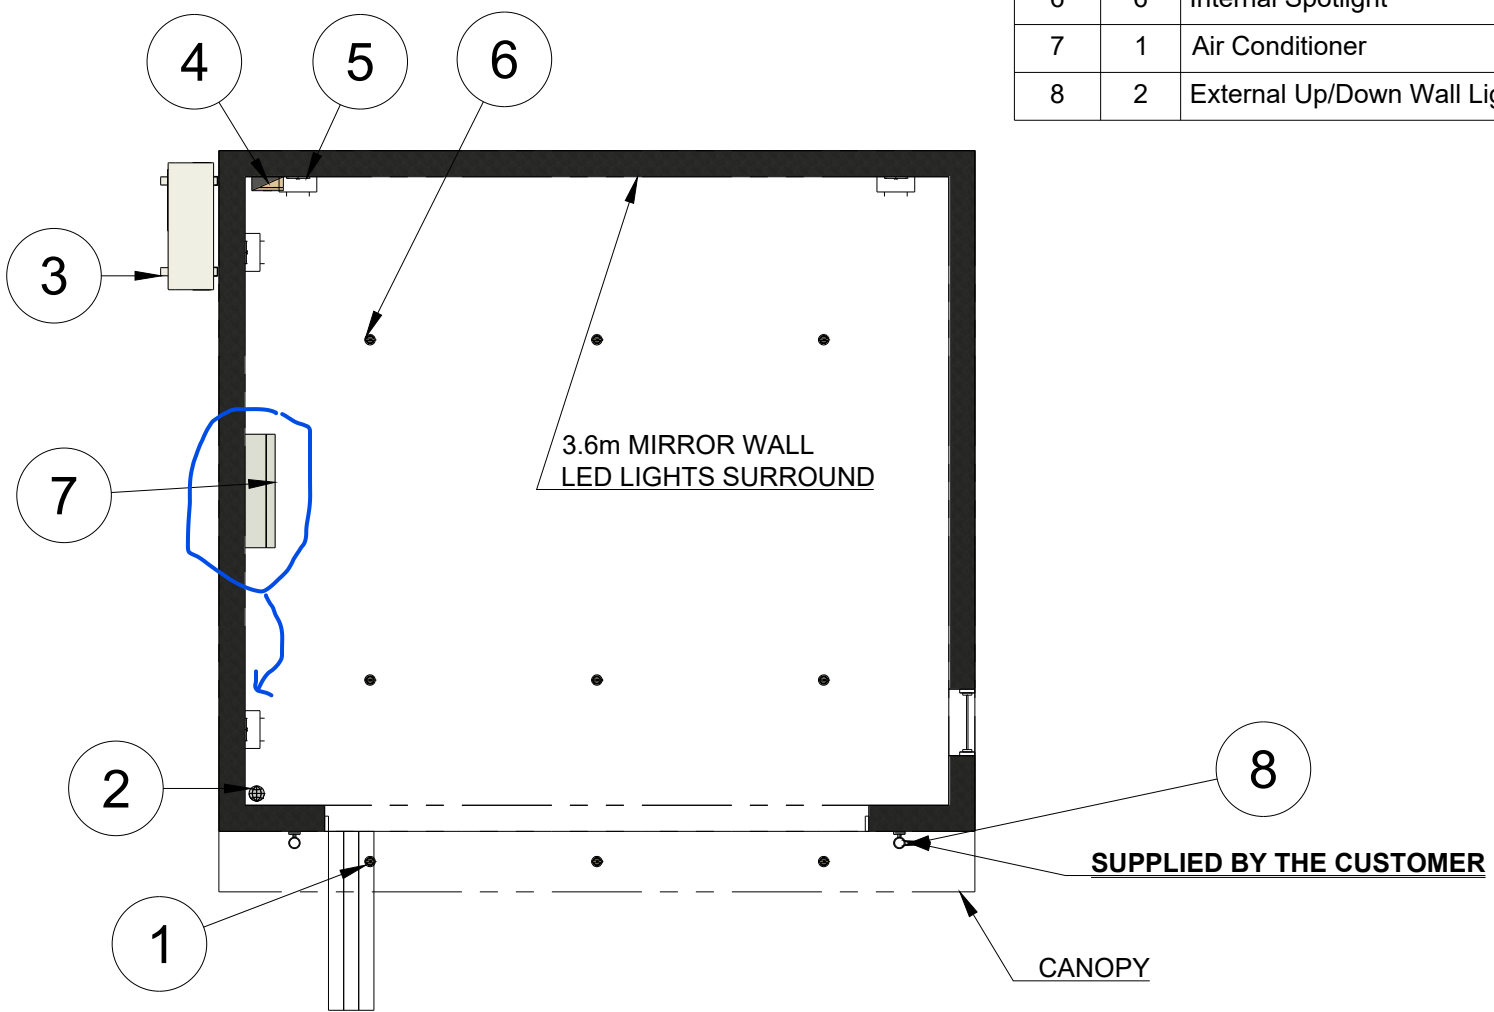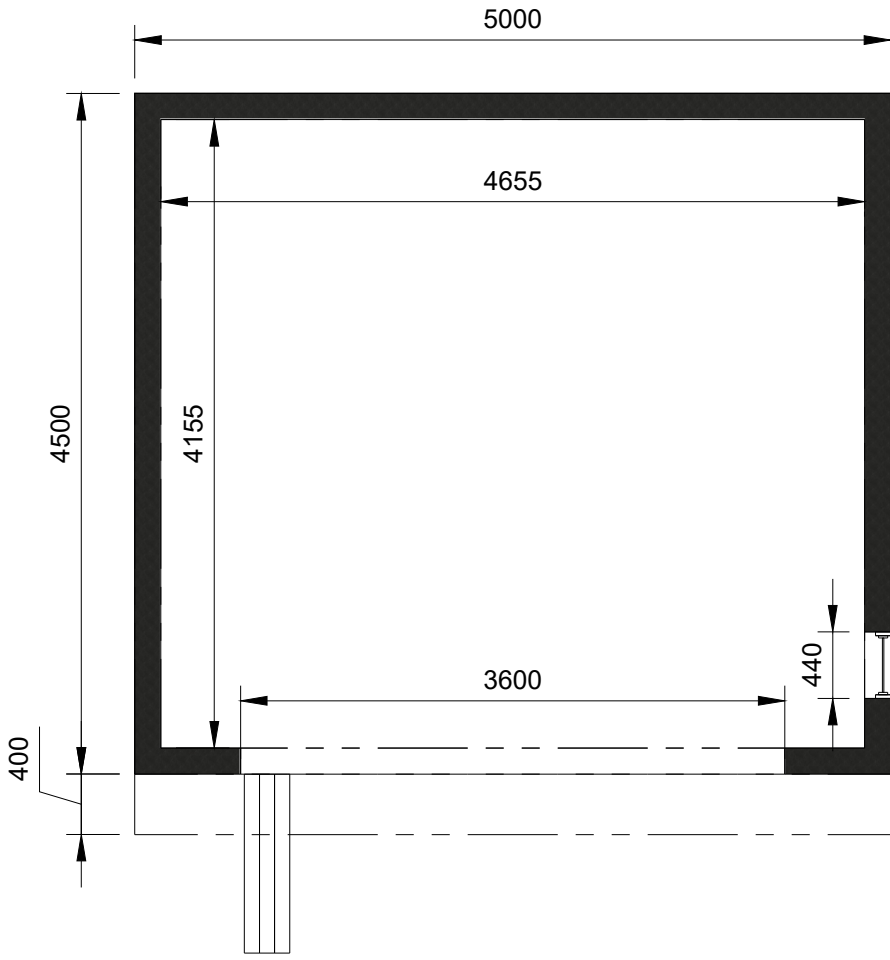

SCALE BAR 1:50 (m)



NOTES:
• SEE SEPARATE WRITTEN SPECIFICATION CHECKLIST FOR MAIN DETAILS

ROOM			
DESCRIPTION	PERIMETER (m)	AREA (m.sq)	AREA (ft.sq)
ROOM DETAILS			

Woodlands Home & Garden Group
Unit 1, Thornbury Industrial Estate,
BD3 7AF
T: 0113 258 4326
woodlandsgroup.com

ALL DIMENSIONS IN mm.

Size
A3

Scale
1:50
Date drawn
22/07/2025

Created by
Peter Stevens
Approved by


Title
Electrical / Int. Plan View
DWG No.
3657-GA-001

Rev.
C


Sheet
2/3

PILING LAYOUT


Parts List	
Qty	Part Number
23	Ground Screw - Standard

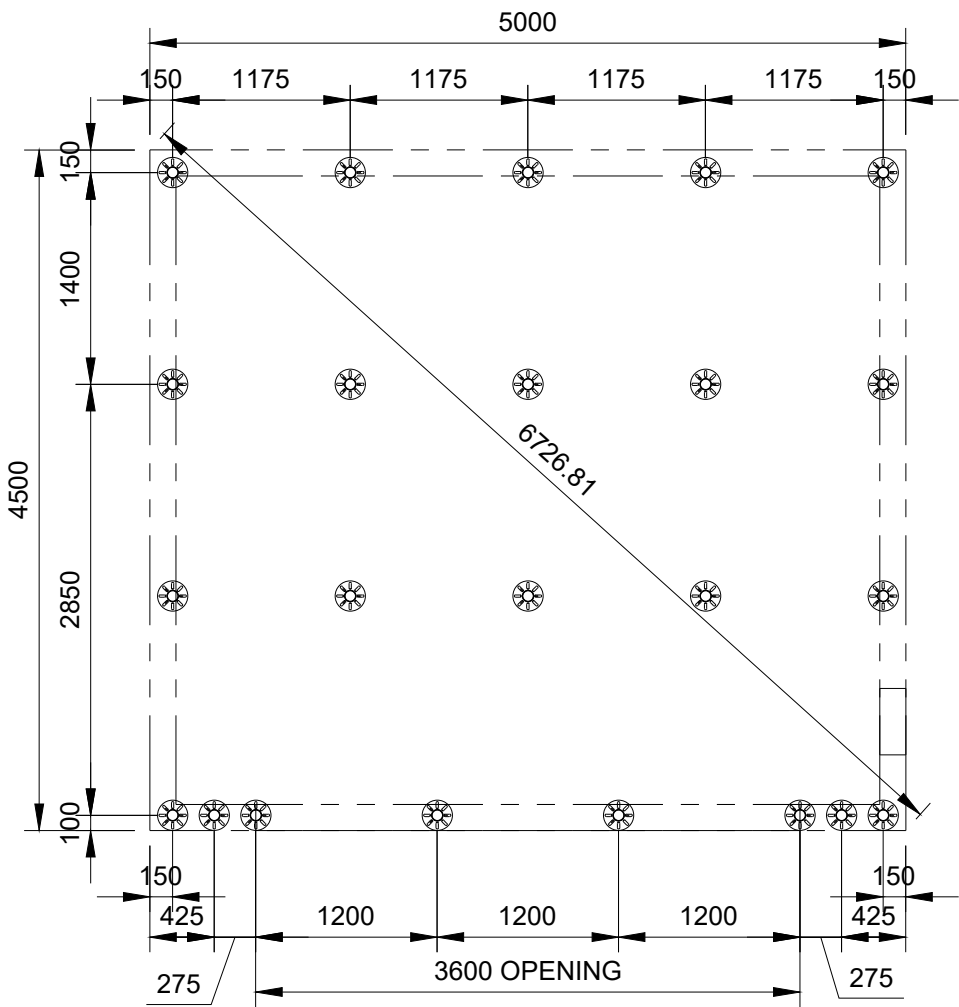

RULES:
WIDTH: 1200 PITCH MAX.
DEPTH: 1500 PITCH MAX.

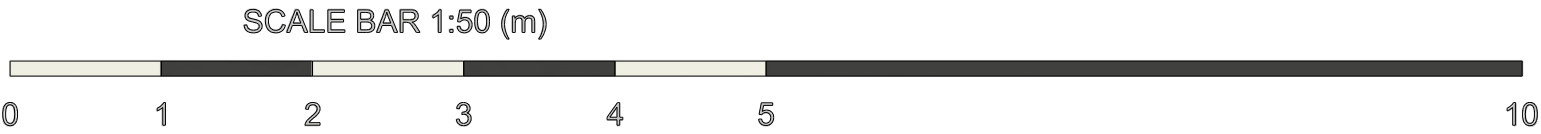

Woodlands Home & Garden Group
Unit 1, Thornbury Industrial Estate,
BD3 7AF
T: 0113 258 4326
woodlandsgroup.com

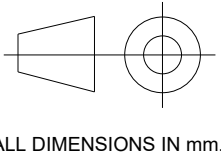

Size
A3

Scale
1:50
Date drawn
22/07/2025

Created by
Peter Stevens
Approved by

Title
Piling Layout
DWG No.
3657-PL-001

Rev.
C
Sheet
3/3