




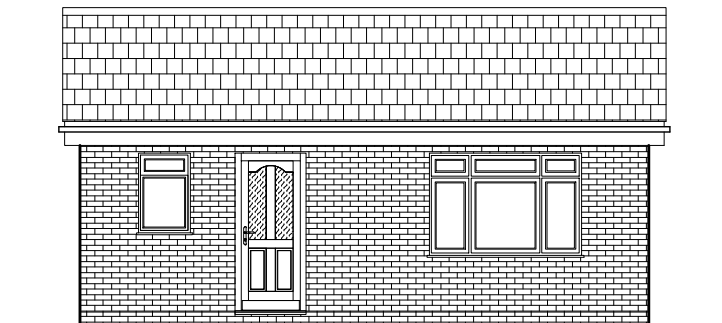


Front Elevation
Scale 1:100

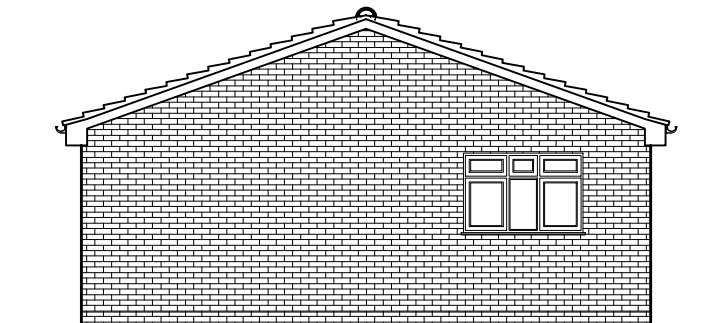

Side Elevation
Scale 1:100

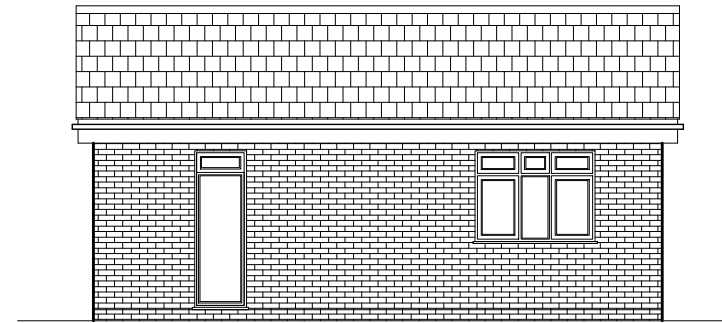

Rear Elevation
Scale 1:100

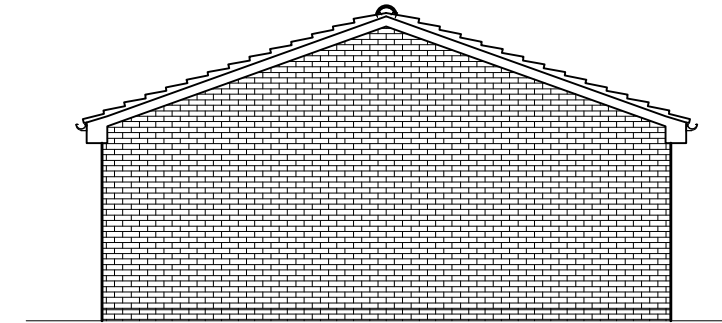

Side Elevation
Scale 1:100

NOTE:

1. THIS DRAWING IS COPYRIGHT.
2. CONTRACTORS MUST CHECK ALL DIMENSIONS AND DETAILS ON SITE.
3. CONTRACTORS MUST CHECK EXISTING FOUNDATION STRUCTURAL STABILITY PRIOR TO COMMENCE ANY FIRST FLOOR EXTENSION.
4. ALL TEMPORARY WORKS AND MECHANICAL PLANT MUST BE IN PLACE AND READY FOR USE BEFORE COMMENCEMENT.
5. FIGURED DIMENSIONS ARE TO BE USED IN PREFERENCE TO SCALED DIMENSIONS.
6. DISCREPANCIES MUST BE REPORTED IMMEDIATELY.
7. ALL NEW PROPOSED MATERIALS TO MATCH EXISTING.
8. ALL STEEL BEAMS/COLUMNS SHOWN ON DRAWING ARE ALL SUBJECT TO CONFIRMATION FROM STRUCTURAL ENGINEER
9. ALL PROPOSED WINDOWS OVERLOOKING OTHER NEIGHBORS IF SHOWN SHOULD BE OF OBSCURE GLAZING
10. CONSTRUCTION (DESIGN & MANAGEMENT) REGULATIONS 2010:
ALL PERSONS ASSOCIATED WITH THIS PROJECT IN PARTICULAR (BUT NOT EXCLUSIVELY) THE INSTRUCTING CLIENT, THE PRINCIPAL CONTRACTOR, SUB-CONTRACTORS AND OTHER DESIGNERS ARE HEREBY NOTIFIED AND/OR REMINDED OF THEIR OBLIGATIONS UNDER HEALTH & SAFETY LEGISLATION IN GENERAL AND IN PARTICULAR UNDER THE CONSTRUCTION (DESIGN & MANAGEMENT) REGULATIONS 2007 (AND ANY SUBSEQUENT AMENDMENTS THAT MAY BE ISSUED FROM TIME TO TIME).
IN DEVELOPING THEIR DESIGN OF THE WORKS, THE HEALTH & SAFETY OF THE BUILDERS AND THE USERS OF THE CONSTRUCTION HAVE BEEN CONSIDERED IN ACCORDANCE WITH THE ABOVE REGULATIONS AND DECLARE THAT ALL REASONABLE EFFORTS HAVE BEEN MADE TO SEE THAT THE CONSTRUCTION AND USE OF THE WORK/BUILDING WILL BE WITHOUT ANY RISKS GREATER THAN THOSE ASSOCIATED WITH THE NORMAL CONSTRUCTION AND USE OF A BUILDING OF THIS TYPE AND SIZE.

0 1 2 3 4 5m
SCALE 1:100

Client :

14 Sidmouth Road, Ruislip,
London, HA4 0BY

Site :

Proposed Granny Annex to 14
Sidmouth Road, Ruislip,
London, HA4 0BY

Drawing Title

Proposed Elevations


Pinnacle House Business Centre, Newark
Road, Peterborough, PE1 5YD, U.K.
Tel : 01733857631, 07852332121
e-mail: info@bretwaydesigns.com

APR 2022 Scale : As Noted

Print @ A3 Sheet Size

PP/22/0513-02