


CDM DESIGNER RISK INFORMATION
IN ADDITION TO THE HAZARDS/RISKS NORMALLY
ASSOCIATED WITH THE TYPES OF WORK DETAILED
ON THIS DRAWING:-
NOTE THE FOLLOWING:-

CONSTRUCTION
MAINTENANCE/CLEANING
DECOMMISSIONING/DEMOLITION


FURTHER INFORMATION CAN BE FOUND ON
DESIGNER RISK ASSESSMENT NUMBER:-
IT IS ASSUMED THAT ALL WORKS WILL BE CARRIED
OUT BY A CONTRACTOR COMPETENT UNDER CDM
2015 WORKING TO AN APPROVED METHOD
STATEMENT

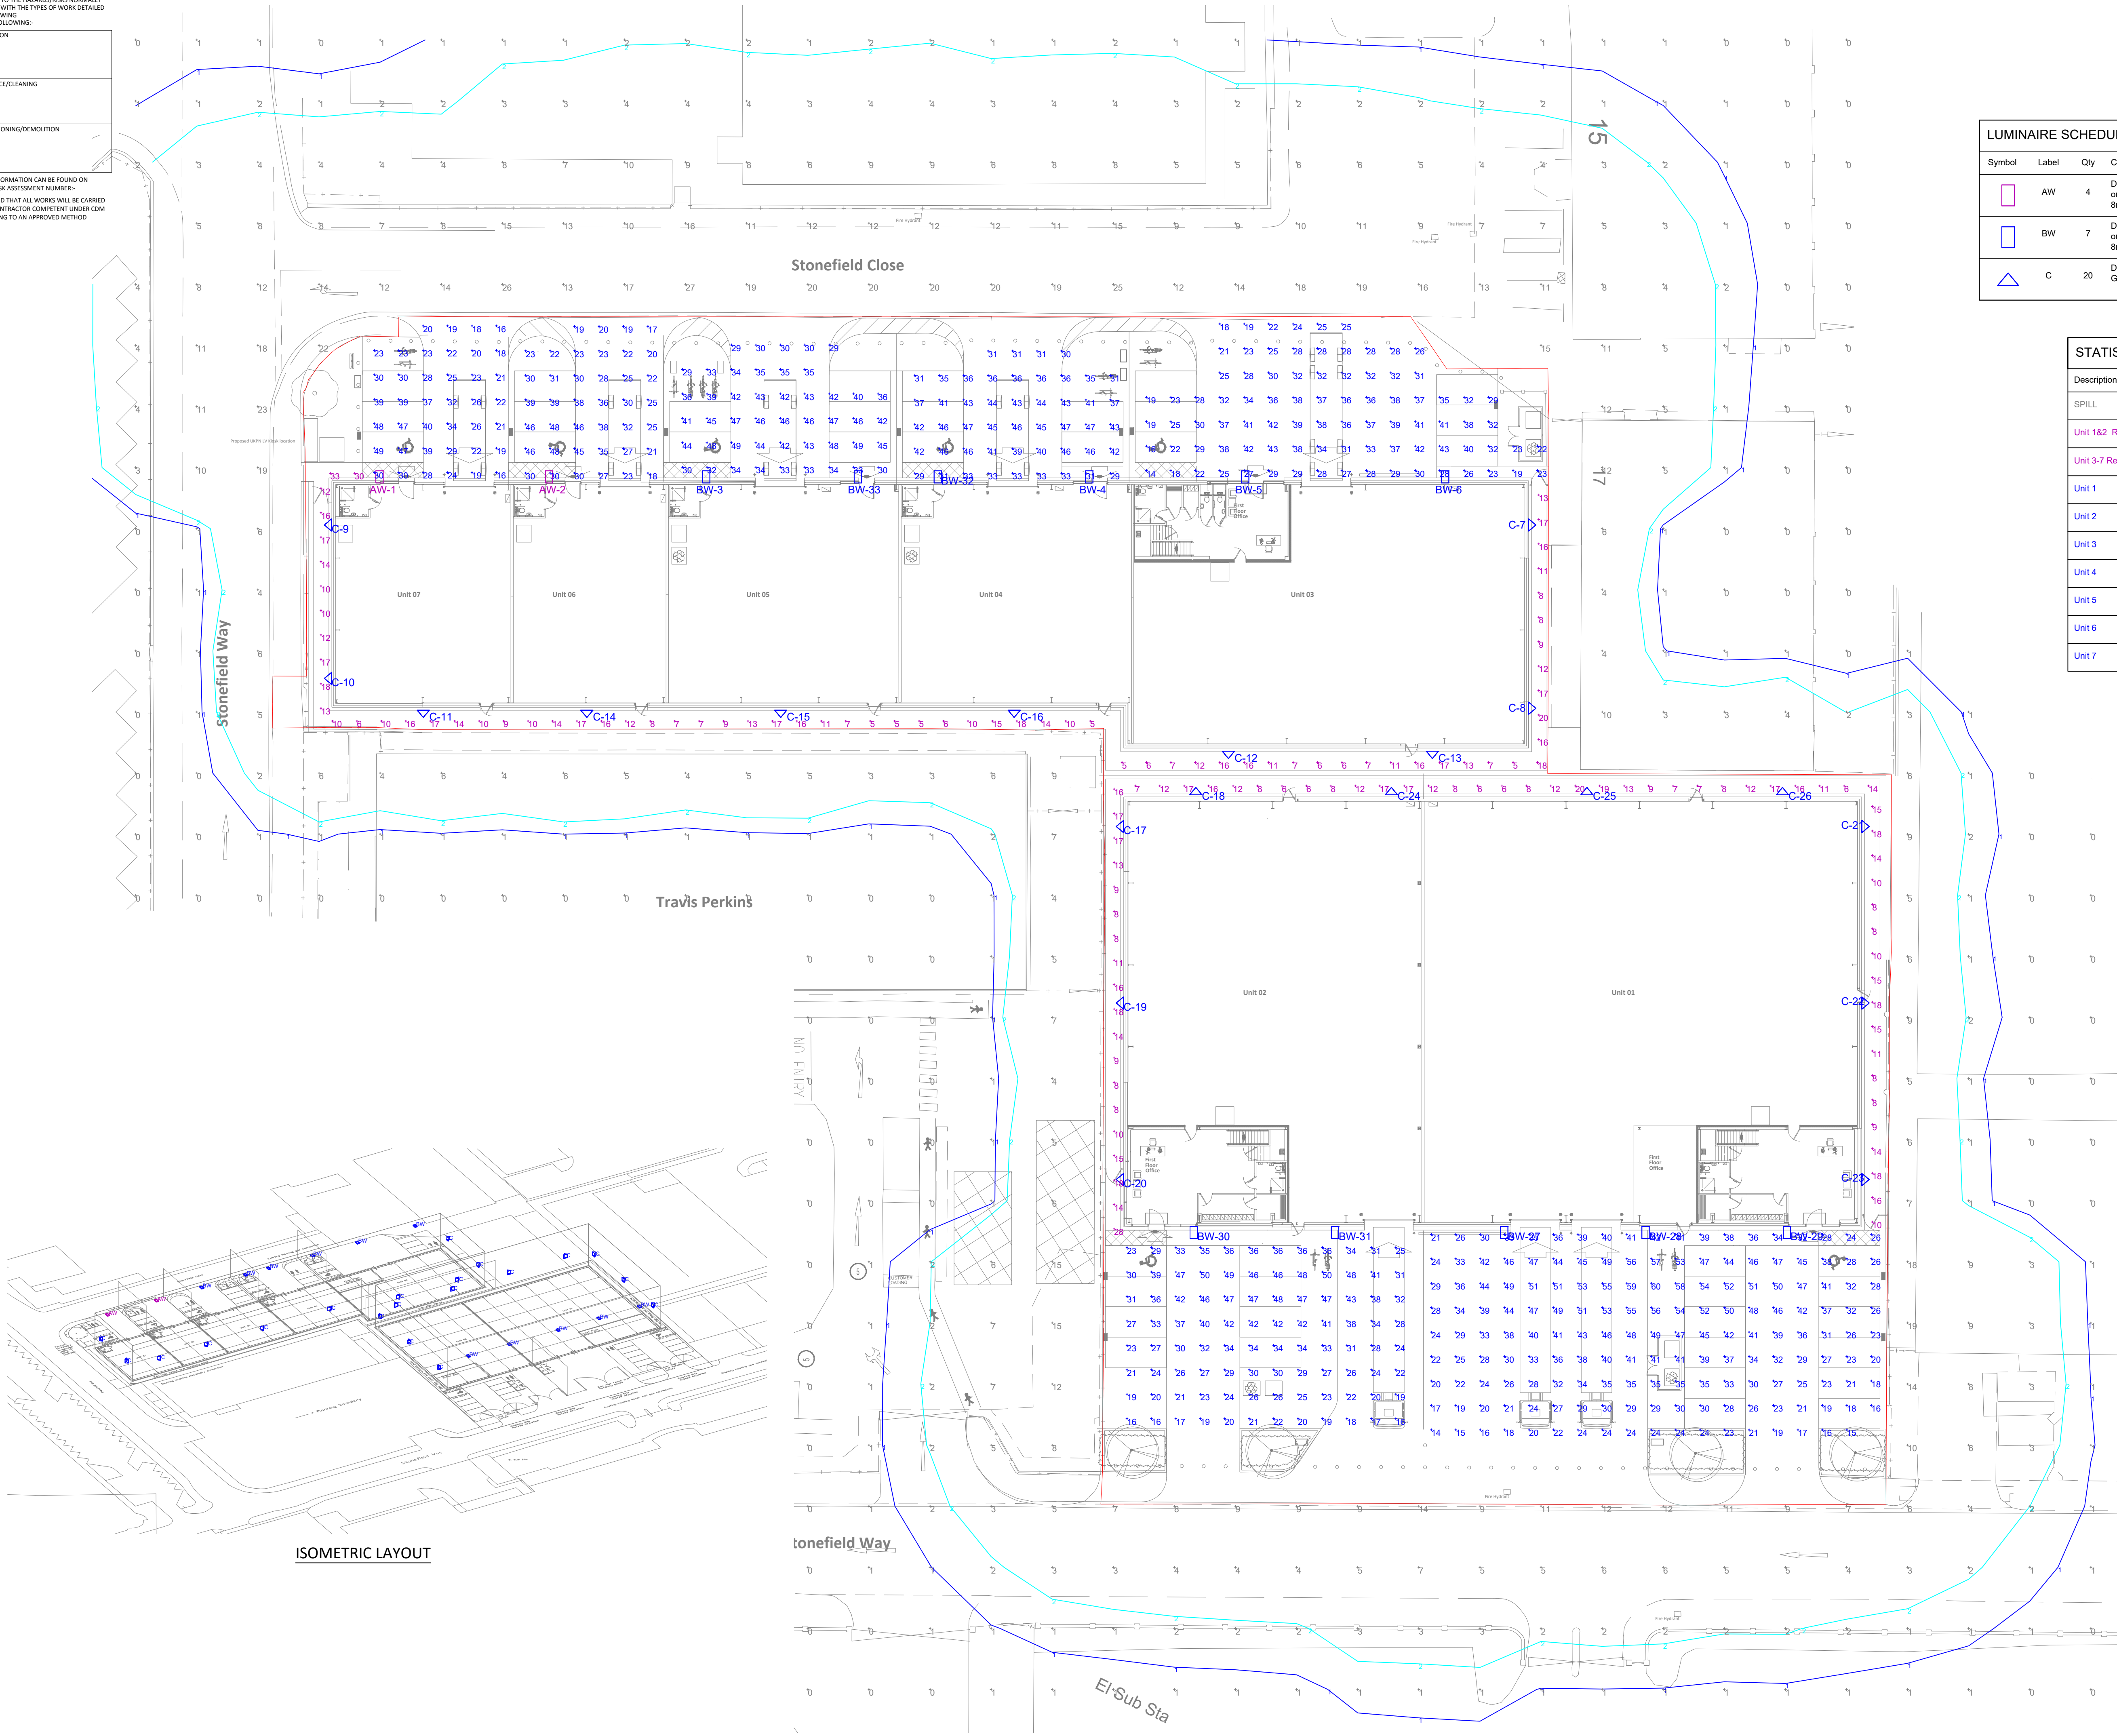

- Notes
- DO NOT SCALE THIS DRAWING.
 - ALL DIMENSIONS ARE IN MILLIMETERS UNLESS OTHERWISE STATED.
 - THIS DRAWING IS TO BE READ IN CONJUNCTION WITH ALL OTHER RELEVANT DRAWINGS AND SPECIFICATIONS.

LUMINAIRE SCHEDULE						
Symbol	Label	Qty	Catalog Number	Description	Lamp	Watts
	AW	4	DSX1.2 LA224 FW on Wall Bracket at 8m AFFL	D-Series 1 Luminaire	LED C.22000LM-4000K	208
	BW	7	DSX1.2 LA164 FW on Wall Bracket at 8m AFFL	D-Series 1 Luminaire	LED C.16000LM-4000K	131
	C	20	DEW LA014 NR.C GL at 4m AFFL	Denver Elite Wall	LED C.1000LM - 4000K	12

STATISTICS					
Description	Symbol	Avg	Max	Min	Min/Avg
SPILL	+	2 lux	27 lux	0 lux	0.00
Unit 1&2 Rear Access	+	12 lux	28 lux	6 lux	0.50
Unit 3-7 Rear Access	+	12 lux	33 lux	5 lux	0.42
Unit 1	+	35 lux	60 lux	14 lux	0.40
Unit 2	+	32 lux	50 lux	16 lux	0.50
Unit 3	+	30 lux	43 lux	14 lux	0.47
Unit 4	+	39 lux	47 lux	29 lux	0.74
Unit 5	+	39 lux	49 lux	29 lux	0.74
Unit 6	+	30 lux	48 lux	17 lux	0.57
Unit 7	+	28 lux	49 lux	16 lux	0.57

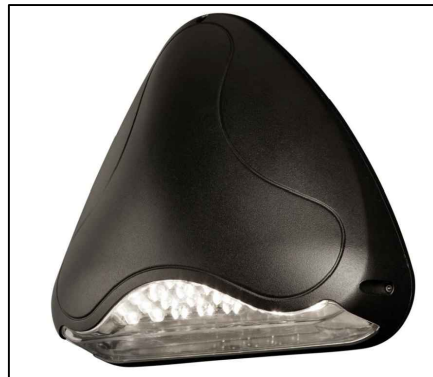

DENVER ELITE LUMINAIRE



D-SERIES 1 LUMINAIRE

PL2	20.03.20	LATEST ARCHITECTURAL ADDED	RH
Rev	Date	Amendments	Appr'd
Client			



Project
**RUISLIP
STONEFIELD CLOSE/
STONEFIELD WAY**

Title
**INDICATIVE EXTERNAL LIGHTING
LAYOUT**

Drawing No	18-108-EX-001	Rev.	PL2
Status	PLANNING	Scale	1:250 @A1
Date	OCT 2018	Designed by	RH
Drawn by	JEG		

mba
CONSULTING ENGINEERS

Maple House, Woodlands Business Park,
Unford Wood West, Milton Keynes, MK14 6FG
T:01908 320099