
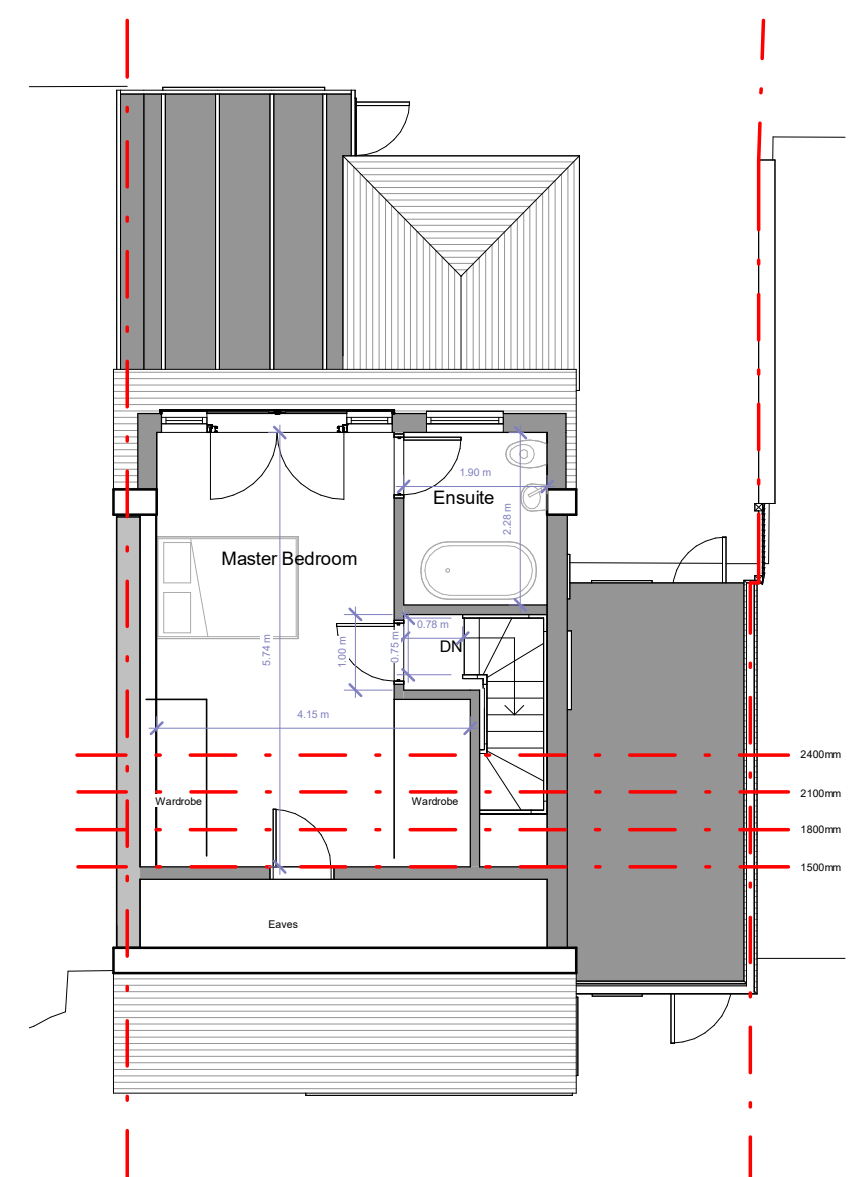
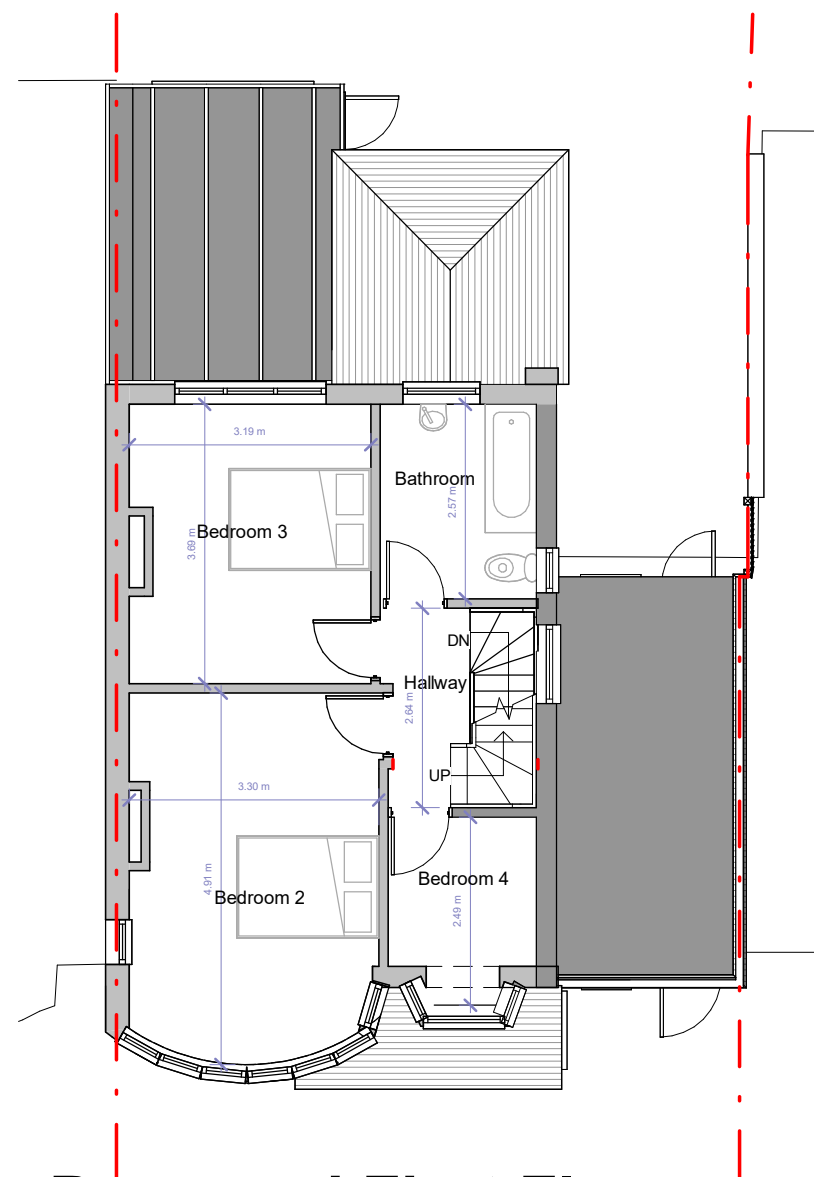


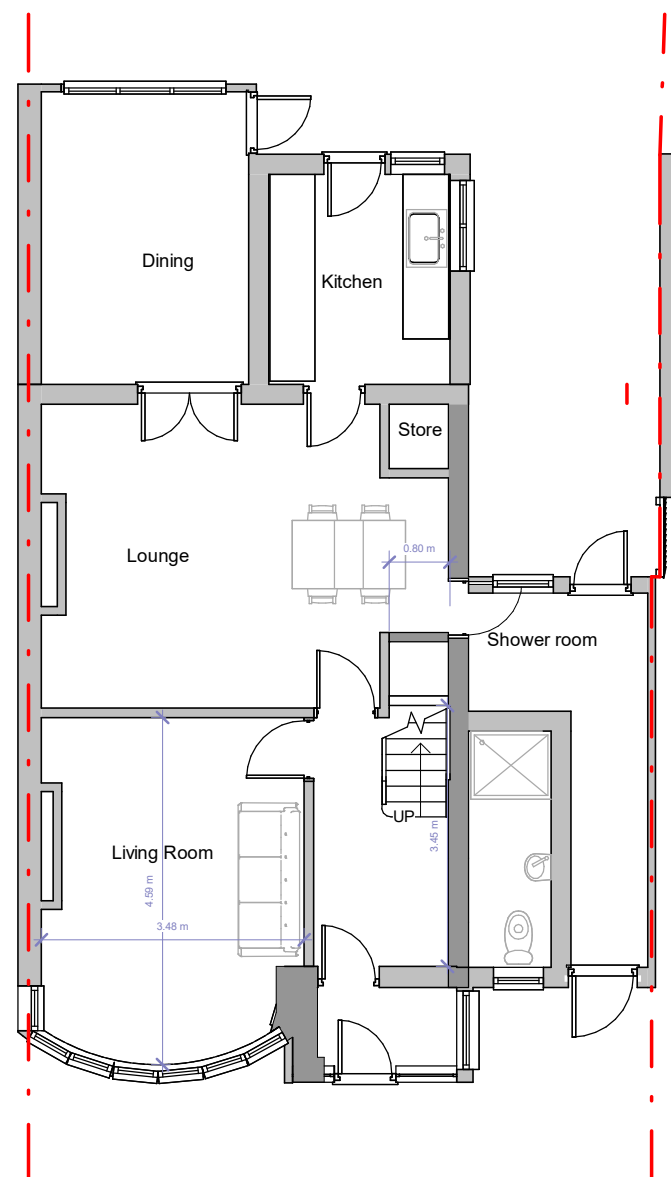

 **Fluent[®]**
ARCHITECTURAL DESIGN SERVICES

FLUENT
ARCHITECTURAL DESIGN SERVICES

TEL: 0800 043 8838
E-MAIL: INFO@FLUENT-ADS.CO.UK
WEB: FLUENT-ADS.CO.UK

130 Shenley Avenue, Ruislip	Scale @ A3 1 : 100	Drawing number P.3.500	Key: Existing Proposed ⊕ SVP Boundary line Existing drainage Proposed drainage Overhead	<table><tr><th>No.</th><th>Description</th><th>Date</th></tr><tr><td></td><td></td><td></td></tr><tr><td></td><td></td><td></td></tr><tr><td></td><td></td><td></td></tr><tr><td></td><td></td><td></td></tr><tr><td></td><td></td><td></td></tr><tr><td></td><td></td><td></td></tr><tr><td></td><td></td><td></td></tr></table>	No.	Description	Date																					
	No.	Description			Date																							
	Date 05.05.2022	Project number 1832																										
Proposed Floor Plans	Drawn by D.Owolana	Rev																										
	01234510 GRAPHIC SCALE: 1:100																											