


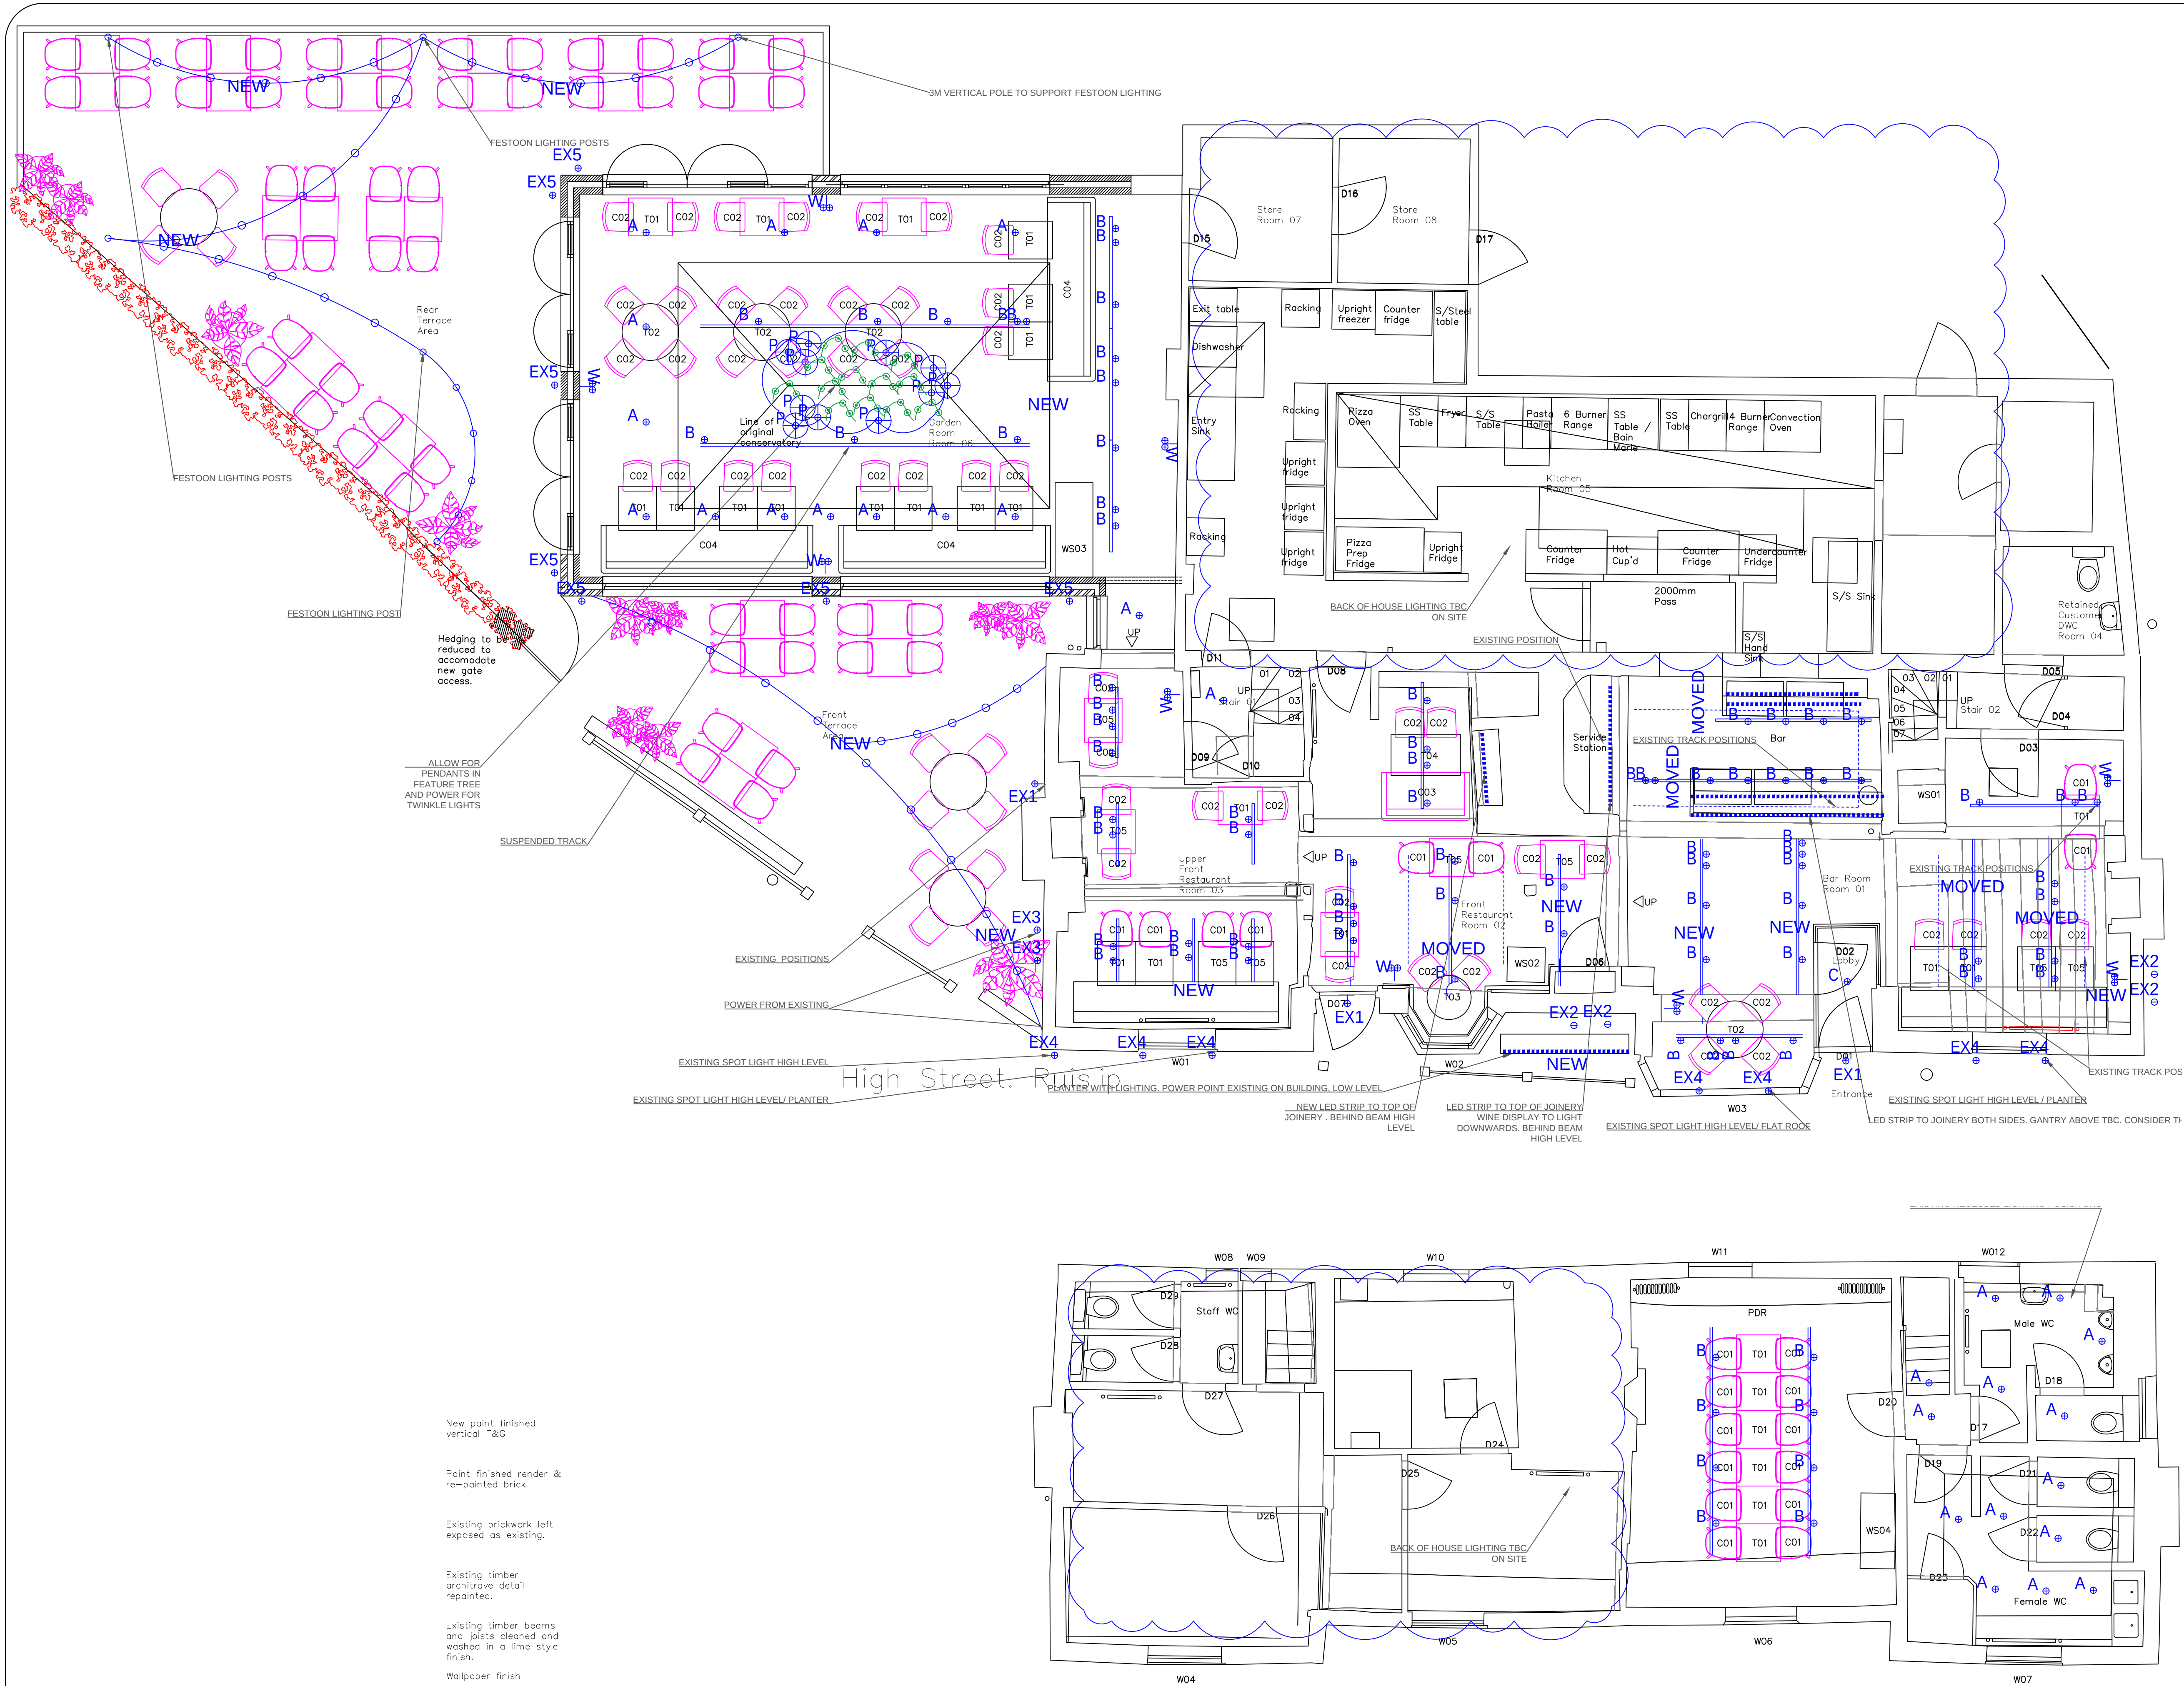

DO NOT SCALE

NOTES:

A

⊕

RECESSED TILT ADJUSTABLE DOWNLIGHT

B

⊕

TRACK MOUNTED SPOT LIGHT

C

⊕

SURFACE SPOT LIGHT

D

⊕

CONDUIT SPOT LIGHTS AND SURFACE ELECTRICAL CONDUIT.

P

⊕

FEATURE TREE SUSPENDED TREE AND TWINKLE LIGHTS

W

⊕

SURFACE WALL LIGHT, DOUBLE HEAD

LED STRIP HIDDEN IN JOINERY

.....

EX1

⊕

EXISTING EXTERNAL WALL LANTERNS

EX2

⊕

EXISTING SIGNAGE LIGHTING

EX3

⊕

EXTERNAL SIGNAGE LIGHTS

EX4

⊕

REPLACE EXISTING EXTERNAL SPOT LIGHT

EX5

⊕

EXTERNAL SPOT LIGHT - HIGH LEVEL FACING DOWN

FEATURE TWINKLE LIGHTS BY SPECIALIST TREE SUPPLIERS

.....

FESTOON LIGHTING

.....

B	12/12/22	Details Of Issue	SM
---	----------	------------------	----

Status

PROPOSAL

Moth Lighting Ltd

Tel: 01883 370 375
Email: info@mothlighting.co.uk Web: www.mothlighting.co.uk

This document and all information herein is confidential and the intellectual property of Moth Lighting Ltd. It is disclosed in confidence on terms that it will not be disclosed to any third party, used, sold, loaned, licensed, or reproduced in whole or in any part in any manner or form for manufacturing, tendering or for any other purpose without the written permission of Moth Lighting Ltd. The copyright is retained by Stuart Moth.
© Moth Lighting Ltd.

Client

ZAZA

Project

ZAZA RUISLIP

Title

LIGHTING LAYOUT
RCP AND FP

Drawn	Date:	Scale (at A1)
SM	23/12/22	1:50

Drg no.	Revision No.
39422	B

A1