
 




NOTE:
ALL EQUIPMENTS SHOWN IN ORANGE
ARE TO BE REMOVED

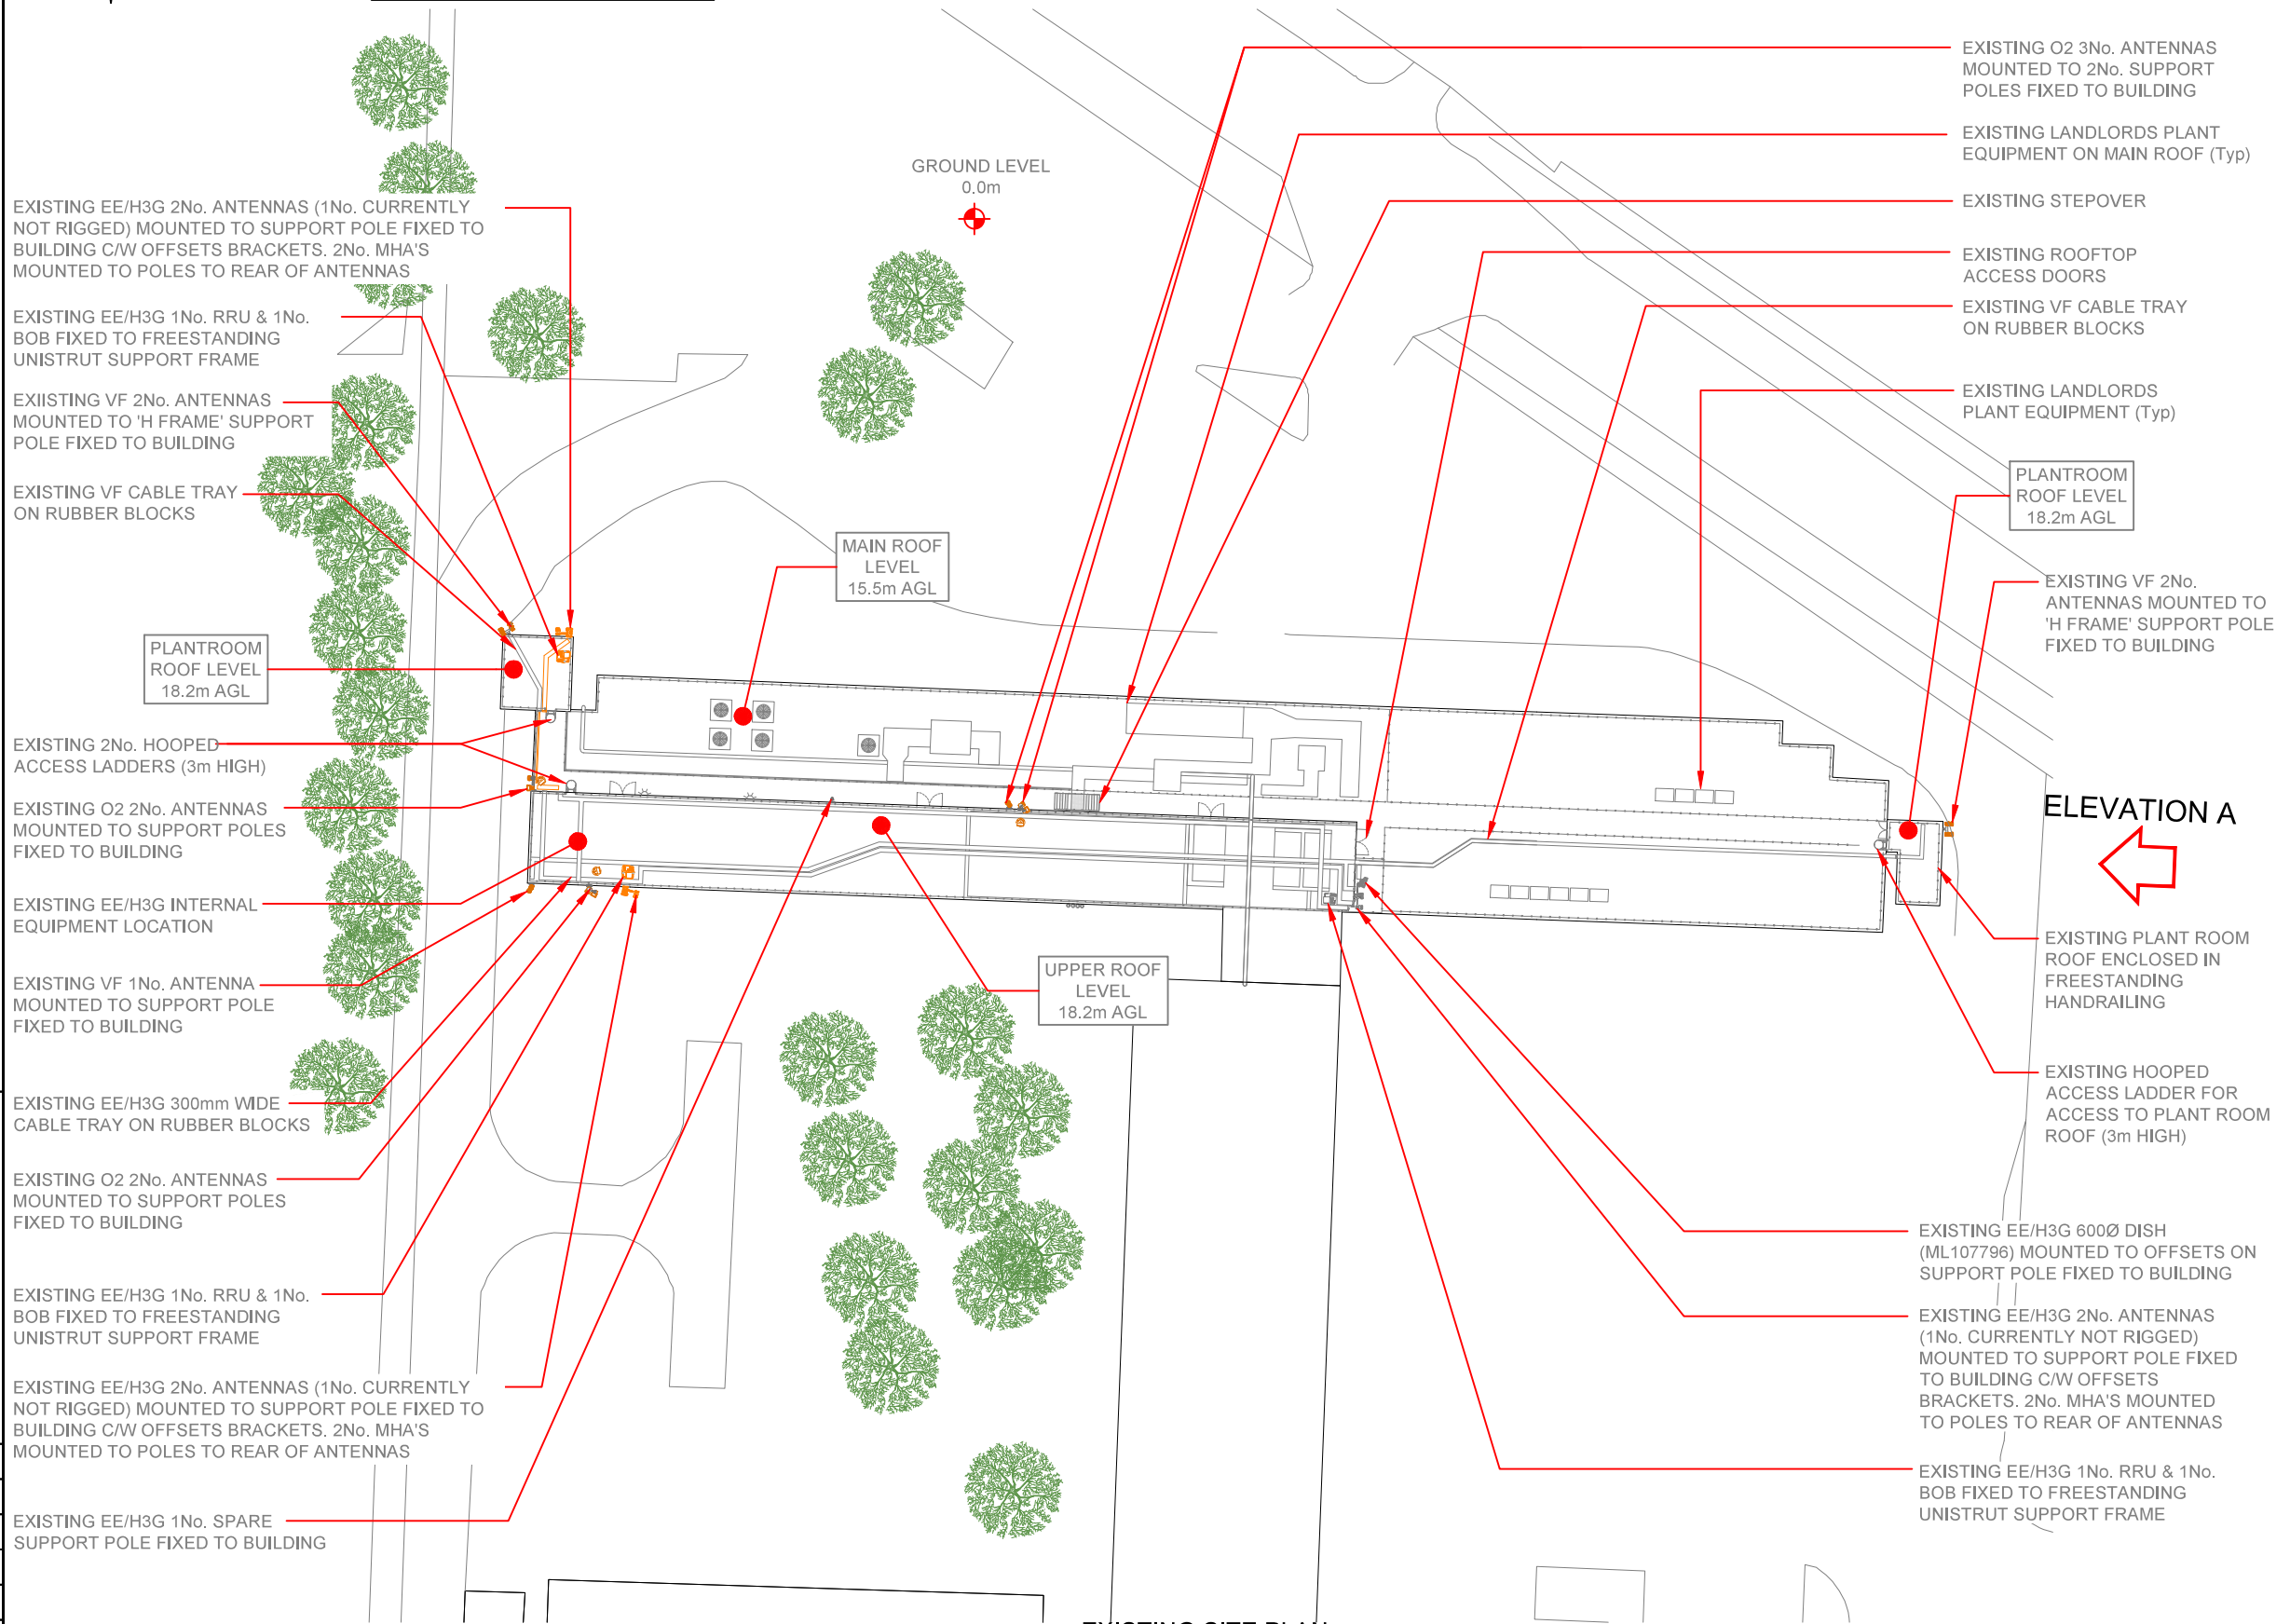

EXISTING SITE PLAN



3G Antenna ID	Existing 3G Bearing
uA1	0°
uB1	90°
uC1	180°

NOTES:

- ALL DIMENSIONS IN MM UNLESS OTHERWISE NOTED.

Master:	MBNL / EE / H3G	Project:	T&A	Purpose of Issue:	Planning	Issue:	D
M004	MBNL	Revision / Upgrade Description: Sector A relocation					
Date:	26/05/2021	Drawn:	B.Binding	Checked:	J. Maguire	Approved:	C.Yates
Master:	MBNL / EE / H3G	Project:	T&A	Purpose of Issue:	Planning	Issue:	C
M003	MBNL	Revision / Upgrade Description: Site solution changed to H4a as a result of HLD					
Date:	20/05/2020	Drawn:	S.Prabhakaran	Checked:	C.Yates	Approved:	D.Pankhania
Master:	MBNL / EE / H3G	Project:	Acquisition Trial	Purpose of Issue:	Planning	Issue:	B
M002	MBNL	Revision / Upgrade Description: Antenna Bearings and Mounting Solution Amended					
Date:	05/12/2018	Drawn:	J.Howden	Checked:	C.Yates	Approved:	D.Pankhania
Master:	MBNL / EE / H3G	Project:	Acquisition Trial	Purpose of Issue:	Planning	Issue:	A
M001	MBNL	Revision / Upgrade Description: First Issue - Site nomination dated:					
Date:	25/06/2018	Drawn:	P.Norman	Checked:	N. Rowlings	Approved:	S.Bader



Hutchison 3G UK Limited
Star House, 20 Grenfell Road
Maidenhead, SL6 1EH
Tel: 01628 765 000
Fax: 01628 765 001
H3G Base Station Information Line
0845 6043000
Available 8am-6pm Monday to Friday



Hatfield Business Park
Hatfield
Hertfordshire
AL10 9BW
Tel: 01707 315000
Fax: 01707 319001



Mobile Broadband Network Limited
Sixth Floor, Thames Tower, Station Road, Reading, RG1 1LX

Design Consultant & Principal Contractor:



WALDON TELECOM
PHOENIX HOUSE
PYRFORD ROAD
WEST BYFLEET
SURREY
KT14 6RA
TEL : 01932 411011
FAX : 01932 411012

Site Name:	UB0047 PARK INN HEATHROW		
Site ID:	1109217		
Address:	PARK INN HOTEL HEATHROW BATH ROAD WEST DRAYTON LONDON UB7 0DU		
Title:	100 EXISTING SITE PLAN		
Project:	ATAP		
Purpose of Issue:	GENERAL ARRANGEMENT		
EE Cell ID:	27296	MBNL Cell ID:	HGN100
3UK Cell ID:	UB0047		
Master Drawing No:	1109217_HGN100_27296_UB0047_M004		
Issue:	D		