 



28 Croft Gardens - Air Source Heat Pump Install - Site Plan

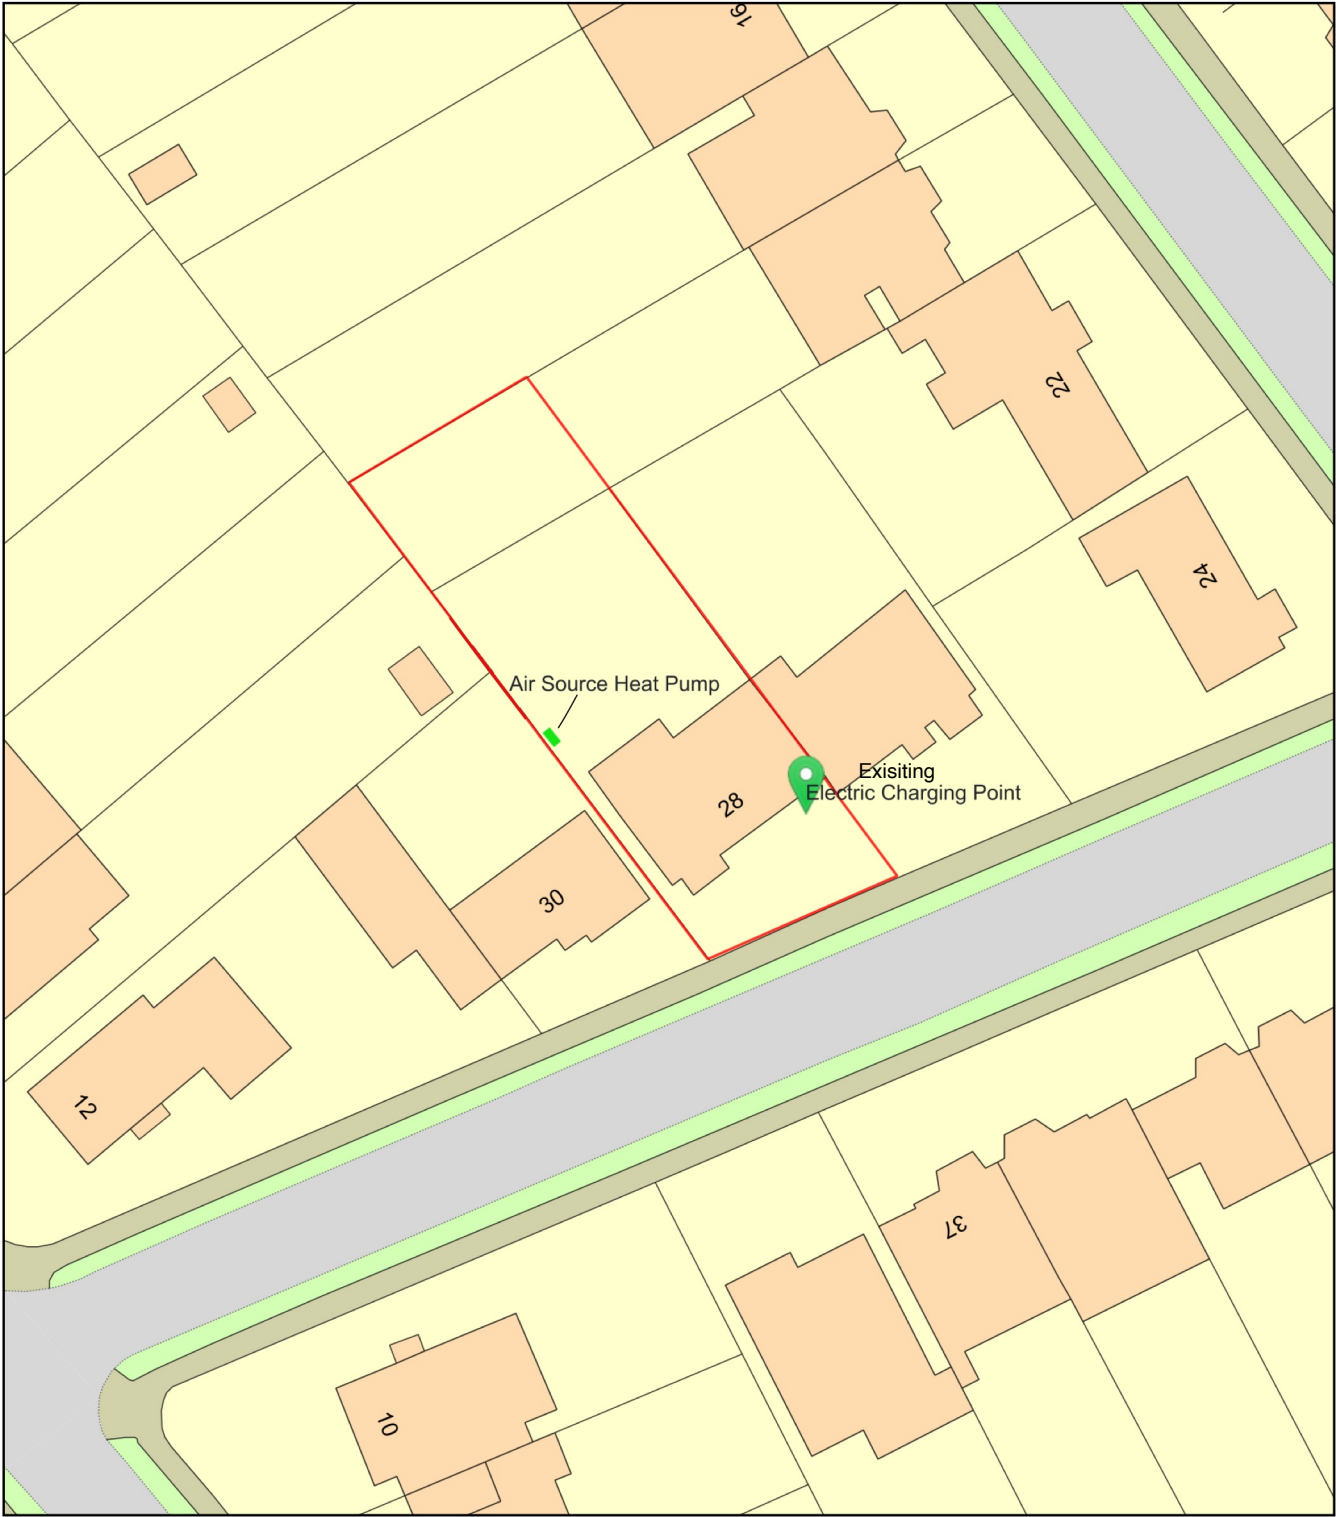

Plan Produced for: Thomas John Bates
Date Produced: 24 Apr 2024
Plan Reference Number: TQRQM24115103412231
Scale: 1:500 @ A4