 



Proposed site plan for 6 new floodlights

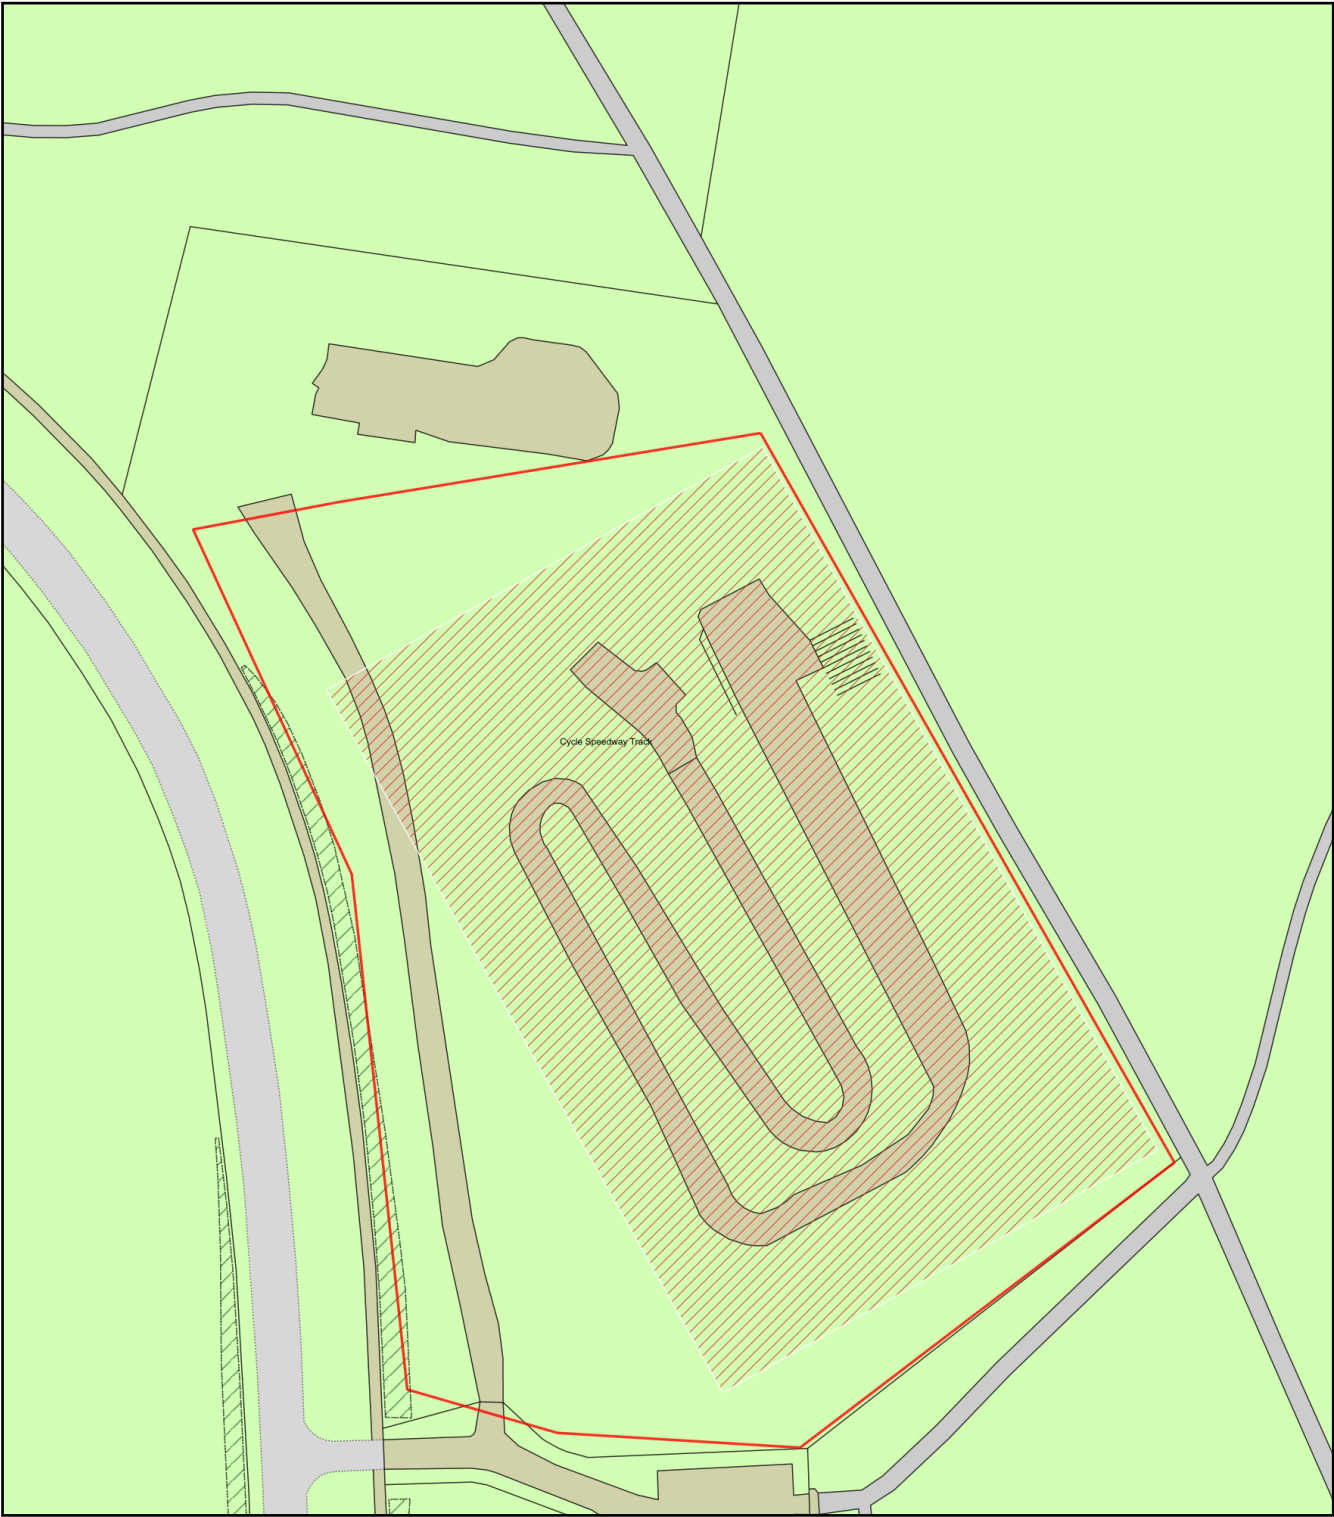

Plan Produced for: Hillingdon Council
Date Produced: 20 Mar 2026
Plan Reference Number: TQRQM26079180611231
Scale: 1:1250 @ A4