



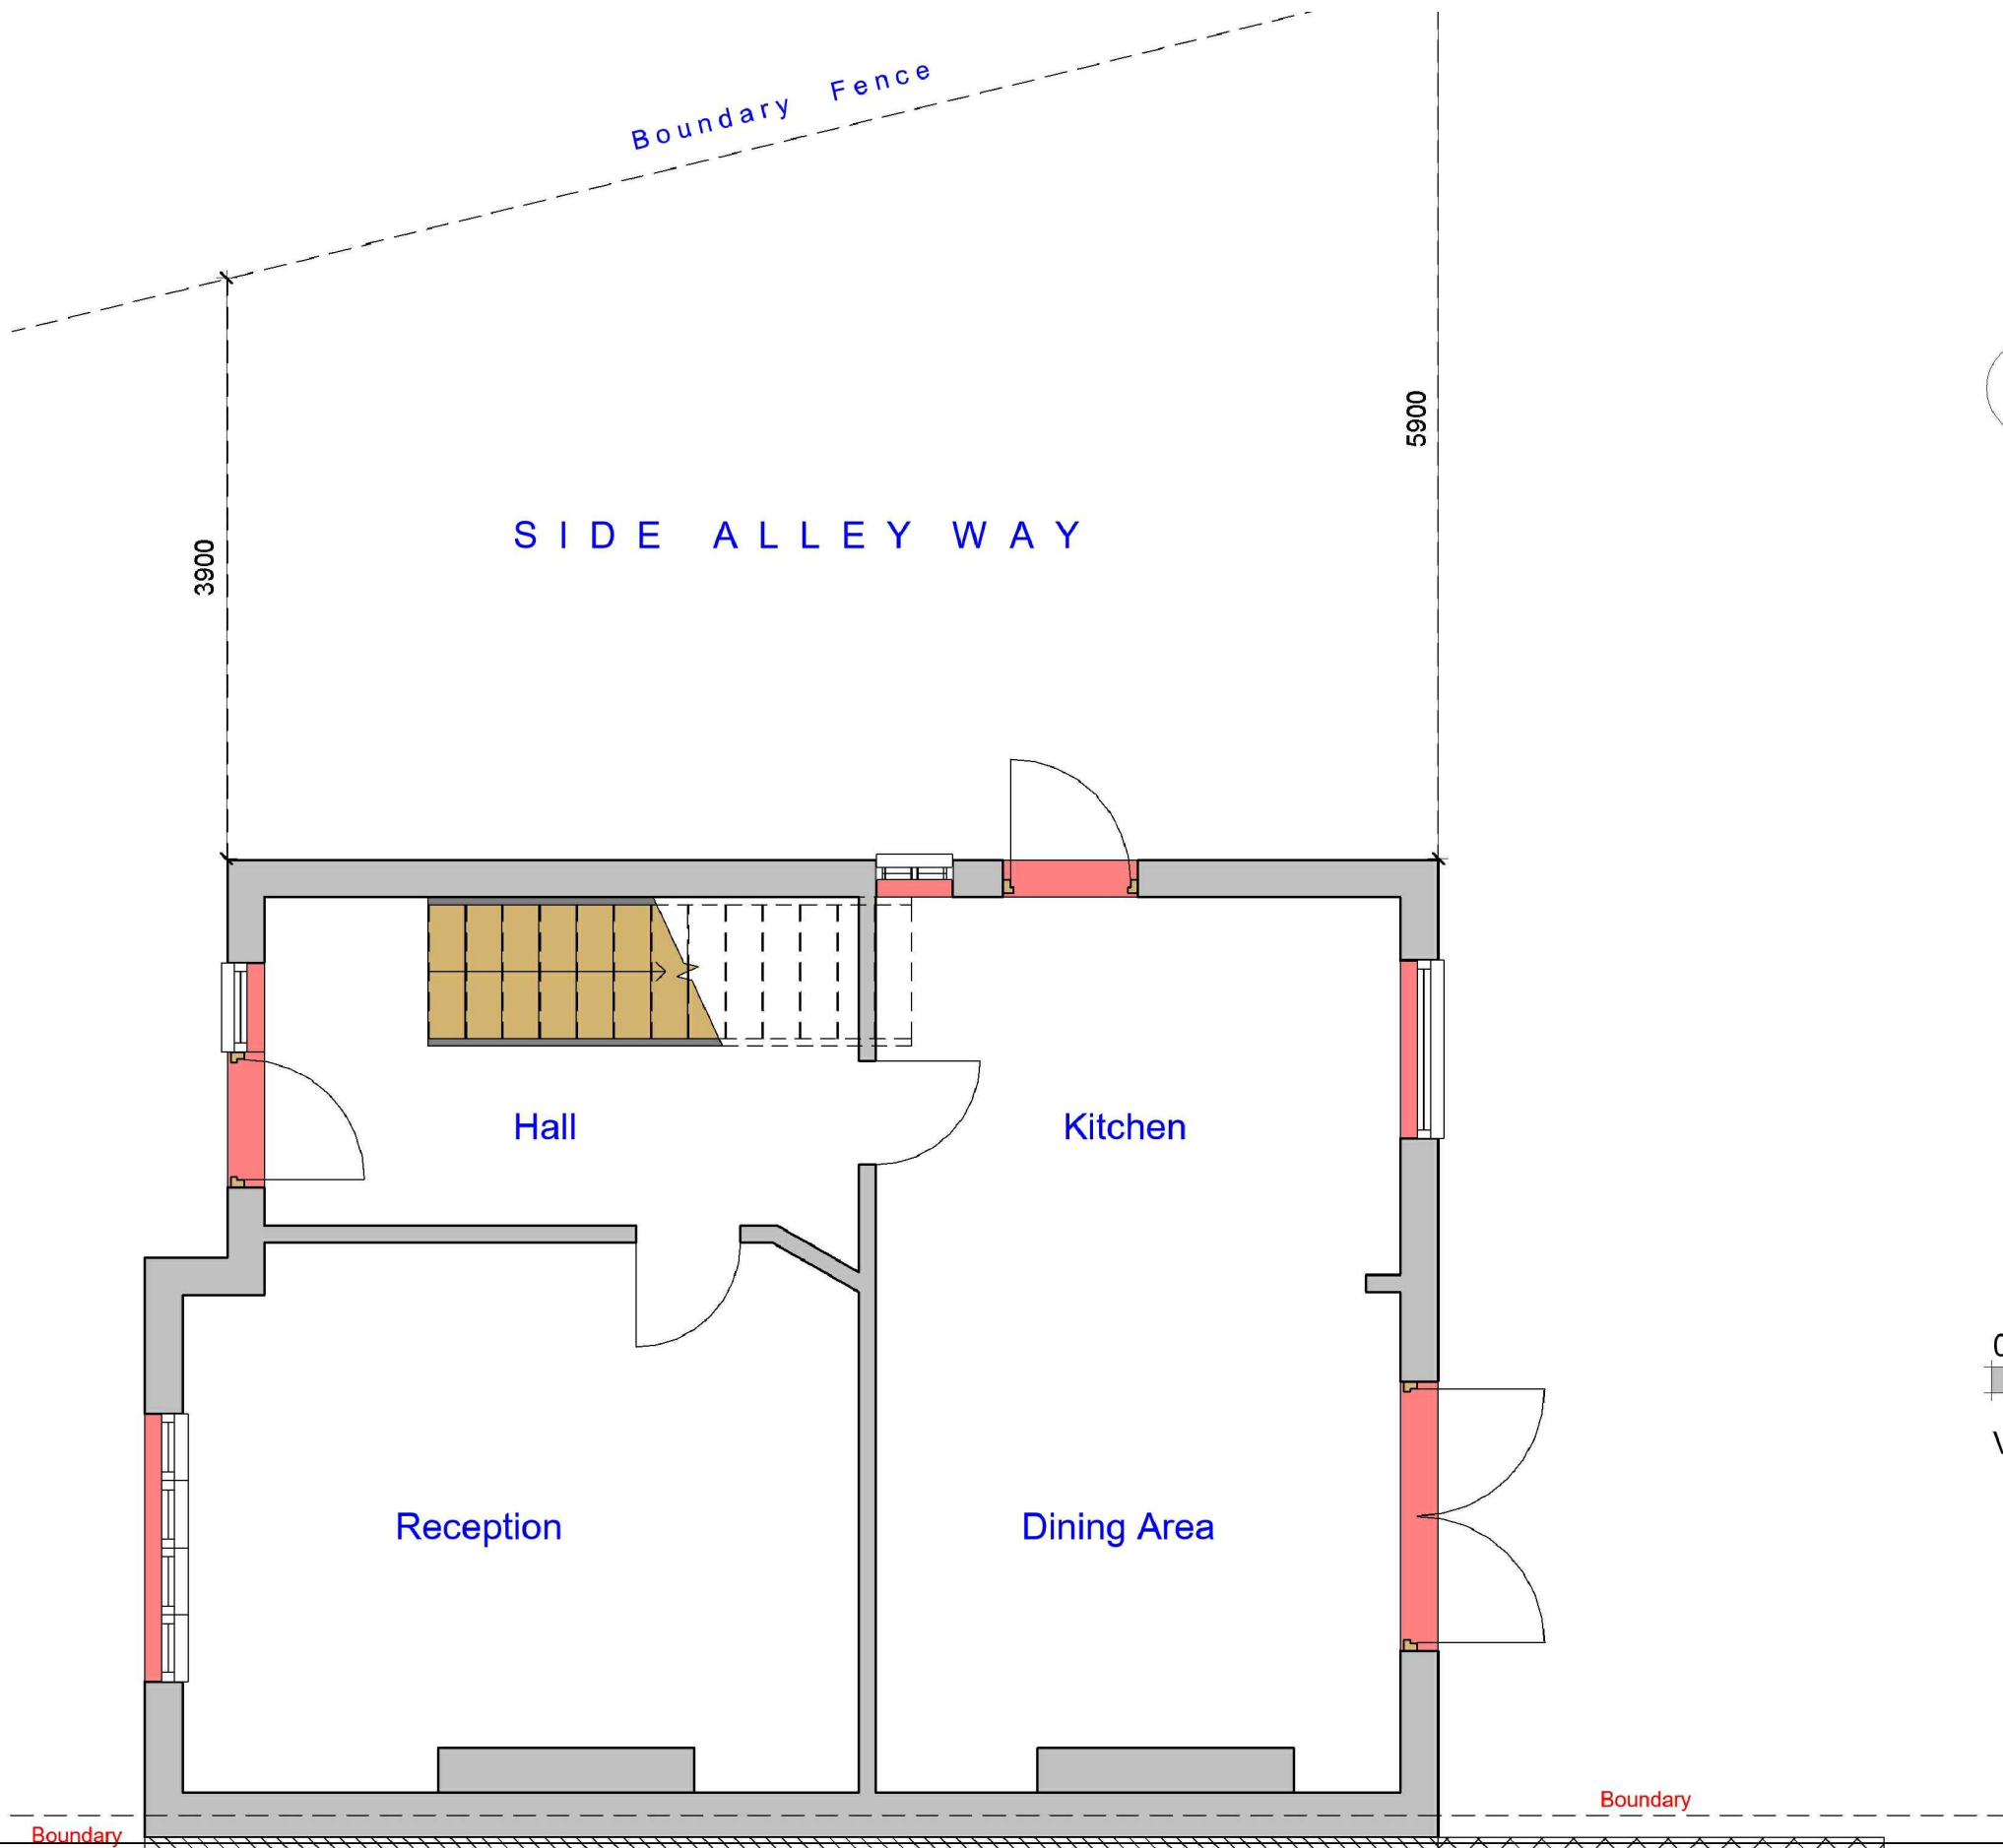

1

Existing Ground Floor

1 : 50

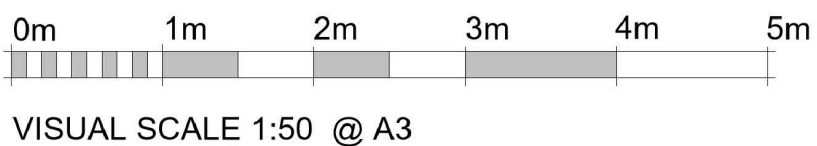

GENERAL NOTES:

- DO NOT SCALE FROM THE DRAWINGS
- ALL DIMENSIONS ARE IN MILLIMETER.
- VERIFY ALL DIMENSIONS AND CONDITIONS BEFORE BUILDING OR STARTING CONSTRUCTION.
- NOTIFY THE DESIGNER IMMEDIATELY OF ANY DISCREPANCY OR VARIATION.
- ALL WORK TO COMPLY WITH CURRENT BUILDING REGULATIONS AND CODES OF PRACTICE.



Art @ Rooshika

NISARG@HOTMAIL.COM

+44 - 7951491310


ion (already built)  
PROJECT

37 Wimborne Ave Hayes UB4 0HQ


SHEET

Existing Ground Floor Plan


|            |                |                   |     |
|------------|----------------|-------------------|-----|
| CLIENT     |                | Mr Amrinder Singh |     |
| Date       | Project number | Scale (@ A3)      |     |
| Issue Date | Project Number |                   |     |
| Drawn by   | DRAWING NUMBER |                   | REV |
| Author     | A101           |                   |     |
| Checked by |                |                   |     |
| Checker    |                |                   |     |

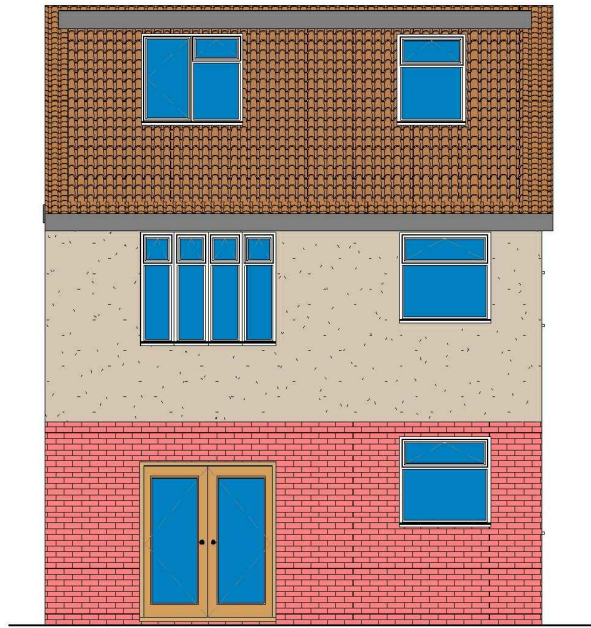

**1 Existing Rear\_Elevation**  
1 : 100

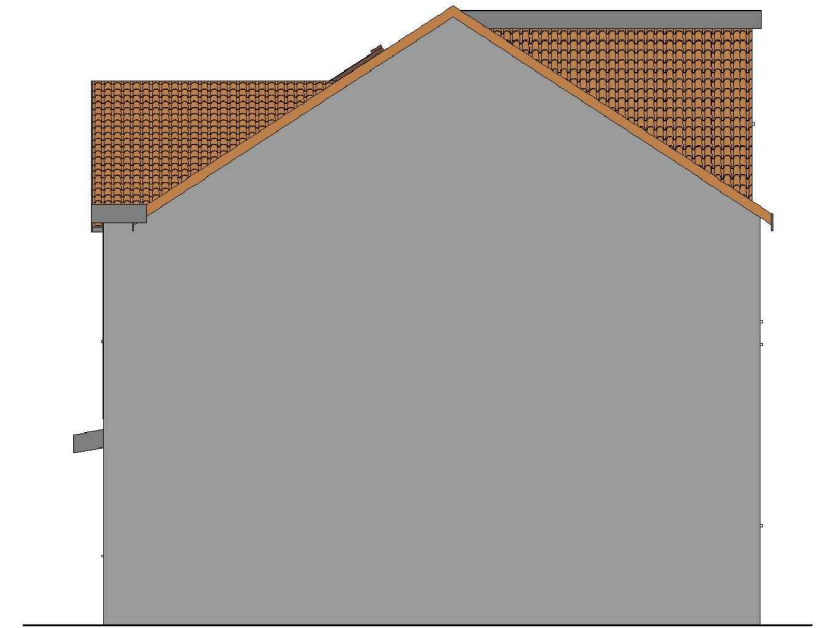

**2 Existing Side 02\_Elevation**  
1 : 100

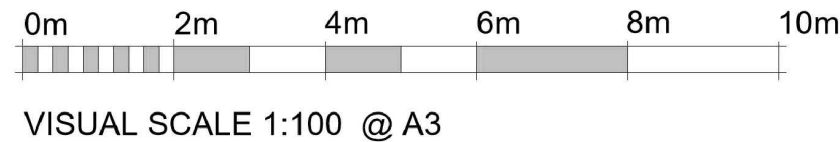

**3 Existing Side 01\_Elevation**  
1 : 100



**4 Existing Front\_Elevation**  
1 : 100

**GENERAL NOTES:**

- DO NOT SCALE FROM THE DRAWINGS
- ALL DIMENSIONS ARE IN MILLIMETER.
- VERIFY ALL DIMENSIONS AND CONDITIONS BEFORE BUILDING OR STARTING CONSTRUCTION.
- NOTIFY THE DESIGNER IMMEDIATELY OF ANY DISCREPANCY OR VARIATION.
- ALL WORK TO COMPLY WITH CURRENT BUILDING REGULATIONS AND CODES OF PRACTICE.



Art @ Rooshika

NISARG@HOTMAIL.COM

+44 - 7951491310

**PROJECT**

37 Wimborne Ave Hayes UB4 0HQ

**SHEET**

Existing Elevations

**CLIENT**

Mr Amrinder Singh

**Date**

Issue Date

Drawn by

Author

Checked by

Checker

Project number


Project Number

DRWAING NUMBER

A102

Scale (@ A3)

REV

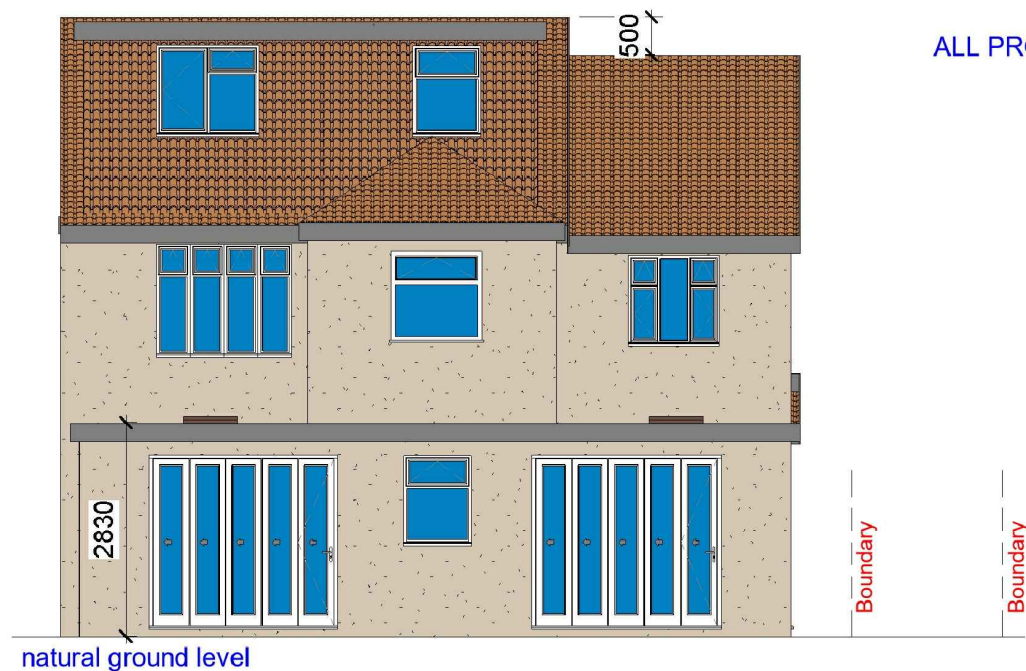


ALL PROPOSED MATERIALS/FINISHED TO MATCH WITH EXISTING.




**1 Proposed Rear\_Elevation**  
1 : 100

**2 Proposed Side 02\_Elevation**  
1 : 100

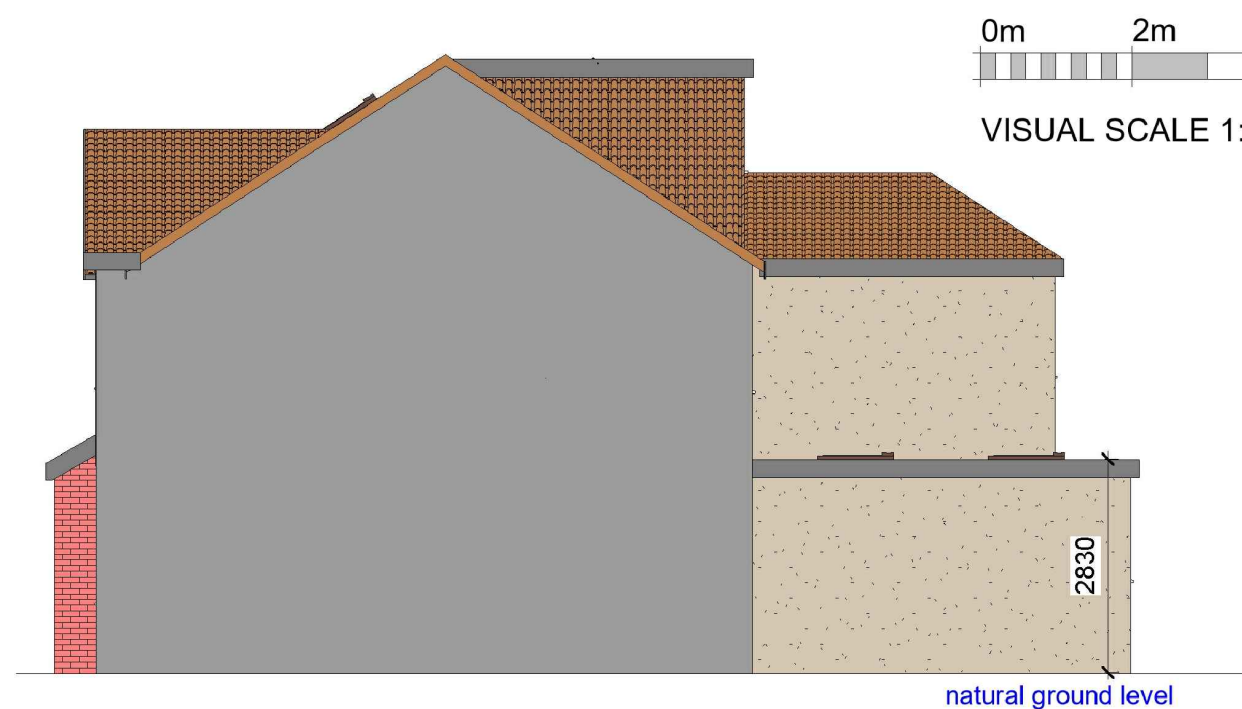

0m 2m 4m 6m 8m 10m  
VISUAL SCALE 1:100 @ A3

**3 Proposed Side 01\_Elevation**  
1 : 100

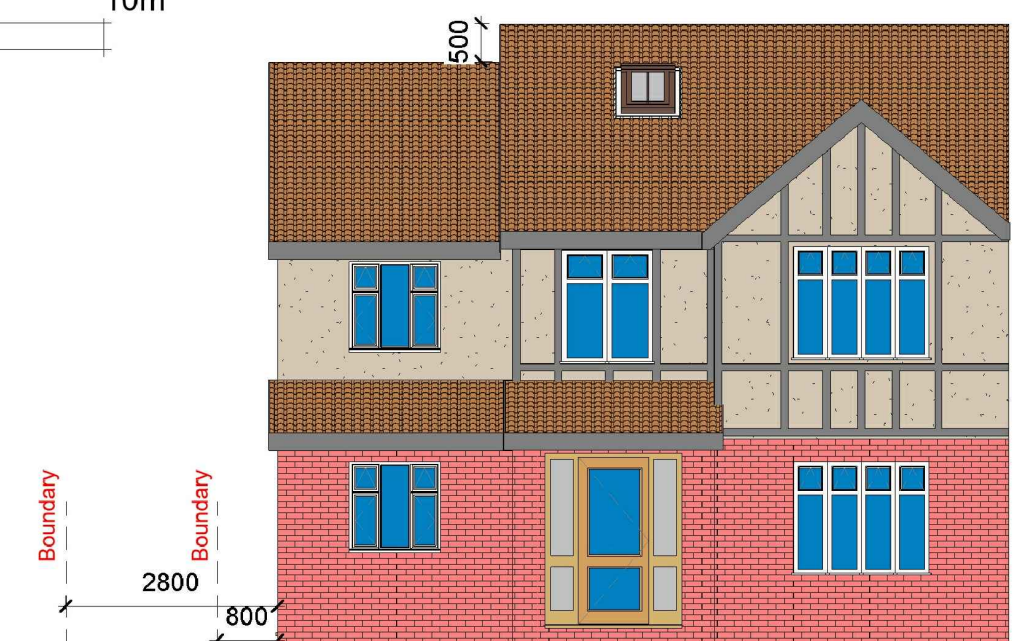

**4 Proposed Front\_Elevation**  
1 : 100

**GENERAL NOTES:**

- DO NOT SCALE FROM THE DRAWINGS
- ALL DIMENSIONS ARE IN MILLIMETER.
- VERIFY ALL DIMENSIONS AND CONDITIONS BEFORE BUILDING OR STARTING CONSTRUCTION.
- NOTIFY THE DESIGNER IMMEDIATELY OF ANY DISCREPANCY OR VARIATION.
- ALL WORK TO COMPLY WITH CURRENT BUILDING REGULATIONS AND CODES OF PRACTICE.



Art @ Rooshika

NISARG@HOTMAIL.COM

+44 - 7951491310

**PROJECT**

37 Wimborne Ave Hayes UB4 0HQ

**SHEET**

Proposed Elevations

**CLIENT**

Mr Amrinder Singh

**Date**

**Issue Date**

**Drawn by**

**Author**

**Checked by**

**Checker**

**Project number**

 

**Project Number**

**DRWAING NUMBER**


**A103**

**Scale (@ A3)**

**REV**

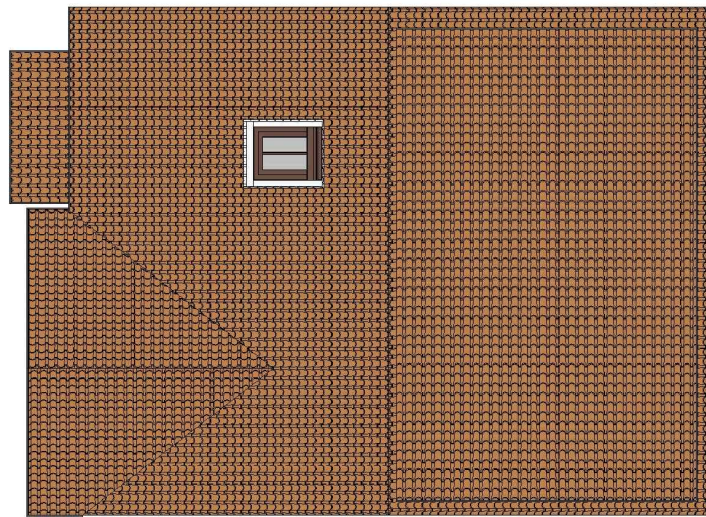


VISUAL SCALE 1:100 @ A3

 

VISUAL SCALE 1:50 @ A3

## 1 Existing Roof

1 : 100

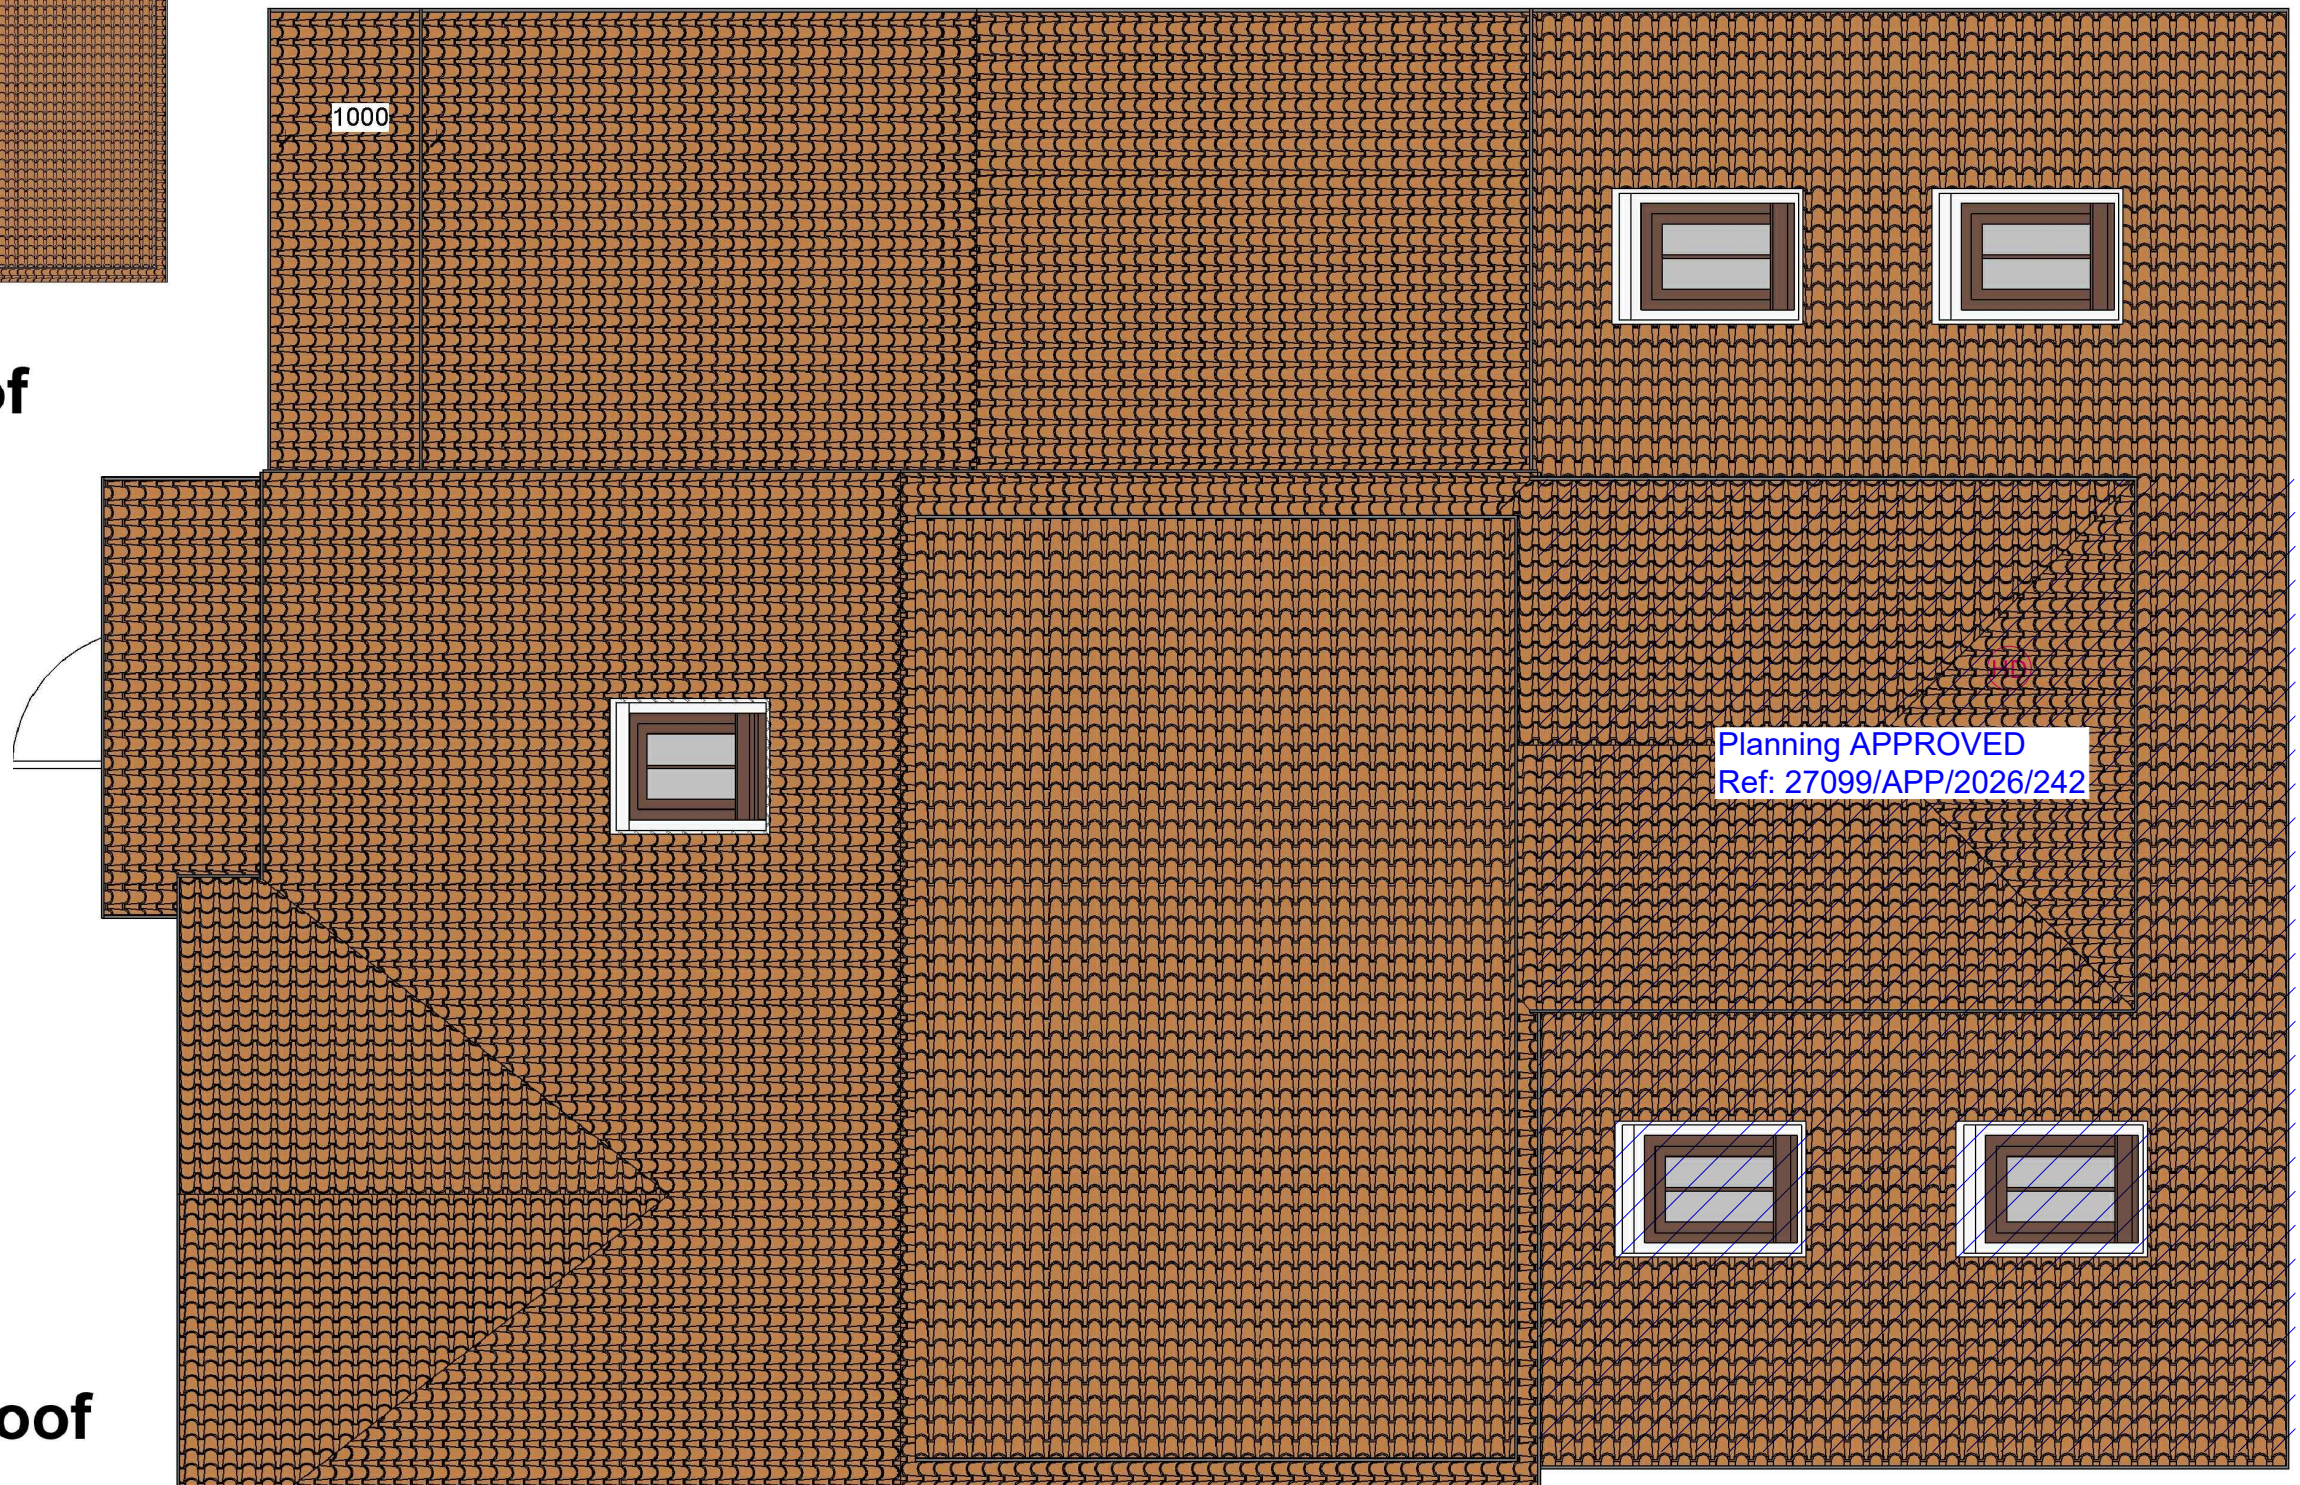

## 2 Proposed Roof

1 : 50

### GENERAL NOTES:

- DO NOT SCALE FROM THE DRAWINGS
- ALL DIMENSIONS ARE IN MILLIMETER.
- VERIFY ALL DIMENSIONS AND CONDITIONS BEFORE BUILDING OR STARTING CONSTRUCTION.
- NOTIFY THE DESIGNER IMMEDIATELY OF ANY DISCREPANCY OR VARIATION.
- ALL WORK TO COMPLY WITH CURRENT BUILDING REGULATIONS AND CODES OF PRACTICE.



Art @ Rooshika

NISARG@HOTMAIL.COM

+44 - 7951491310

### PROJECT

37 Wimborne Ave Hayes UB4 0HQ


### SHEET

Existing & Proposed Roof Plan

### CLIENT

Mr Amrinder Singh

|            |                |              |
|------------|----------------|--------------|
| Date       | Project number | Scale (@ A3) |
| Issue Date | Project Number |              |
| Drawn by   | DRWAING NUMBER | REV          |
| Author     |                |              |
| Checked by | A104           |              |
| Checker    |                |              |

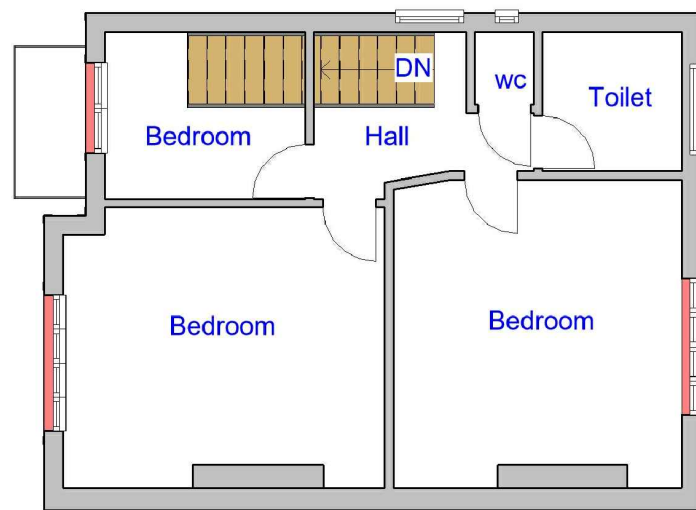

# 1 Existing First Floor 1 : 100

Fire Alarm System comply with BS 5839:Part 1:2017

FIRE EXIT Fire Exit Sign Comply with BS 5499

CM Carbon Monoxide Detector

Extract Vent

FD 30 Fire check doors 30 min fire resistance with smoke seal and self closing

HD Heat Detector comply with BS 5466 2:2016

Assembly Point

Smoke alarm/detector to comply with BS EN14604

Foam 6 litre foam spray

EL Emergency lights To be Installed in Accordance with BS5266: 2016


Call Point



VISUAL SCALE 1:100 @ A3



VISUAL SCALE 1:50 @ A3

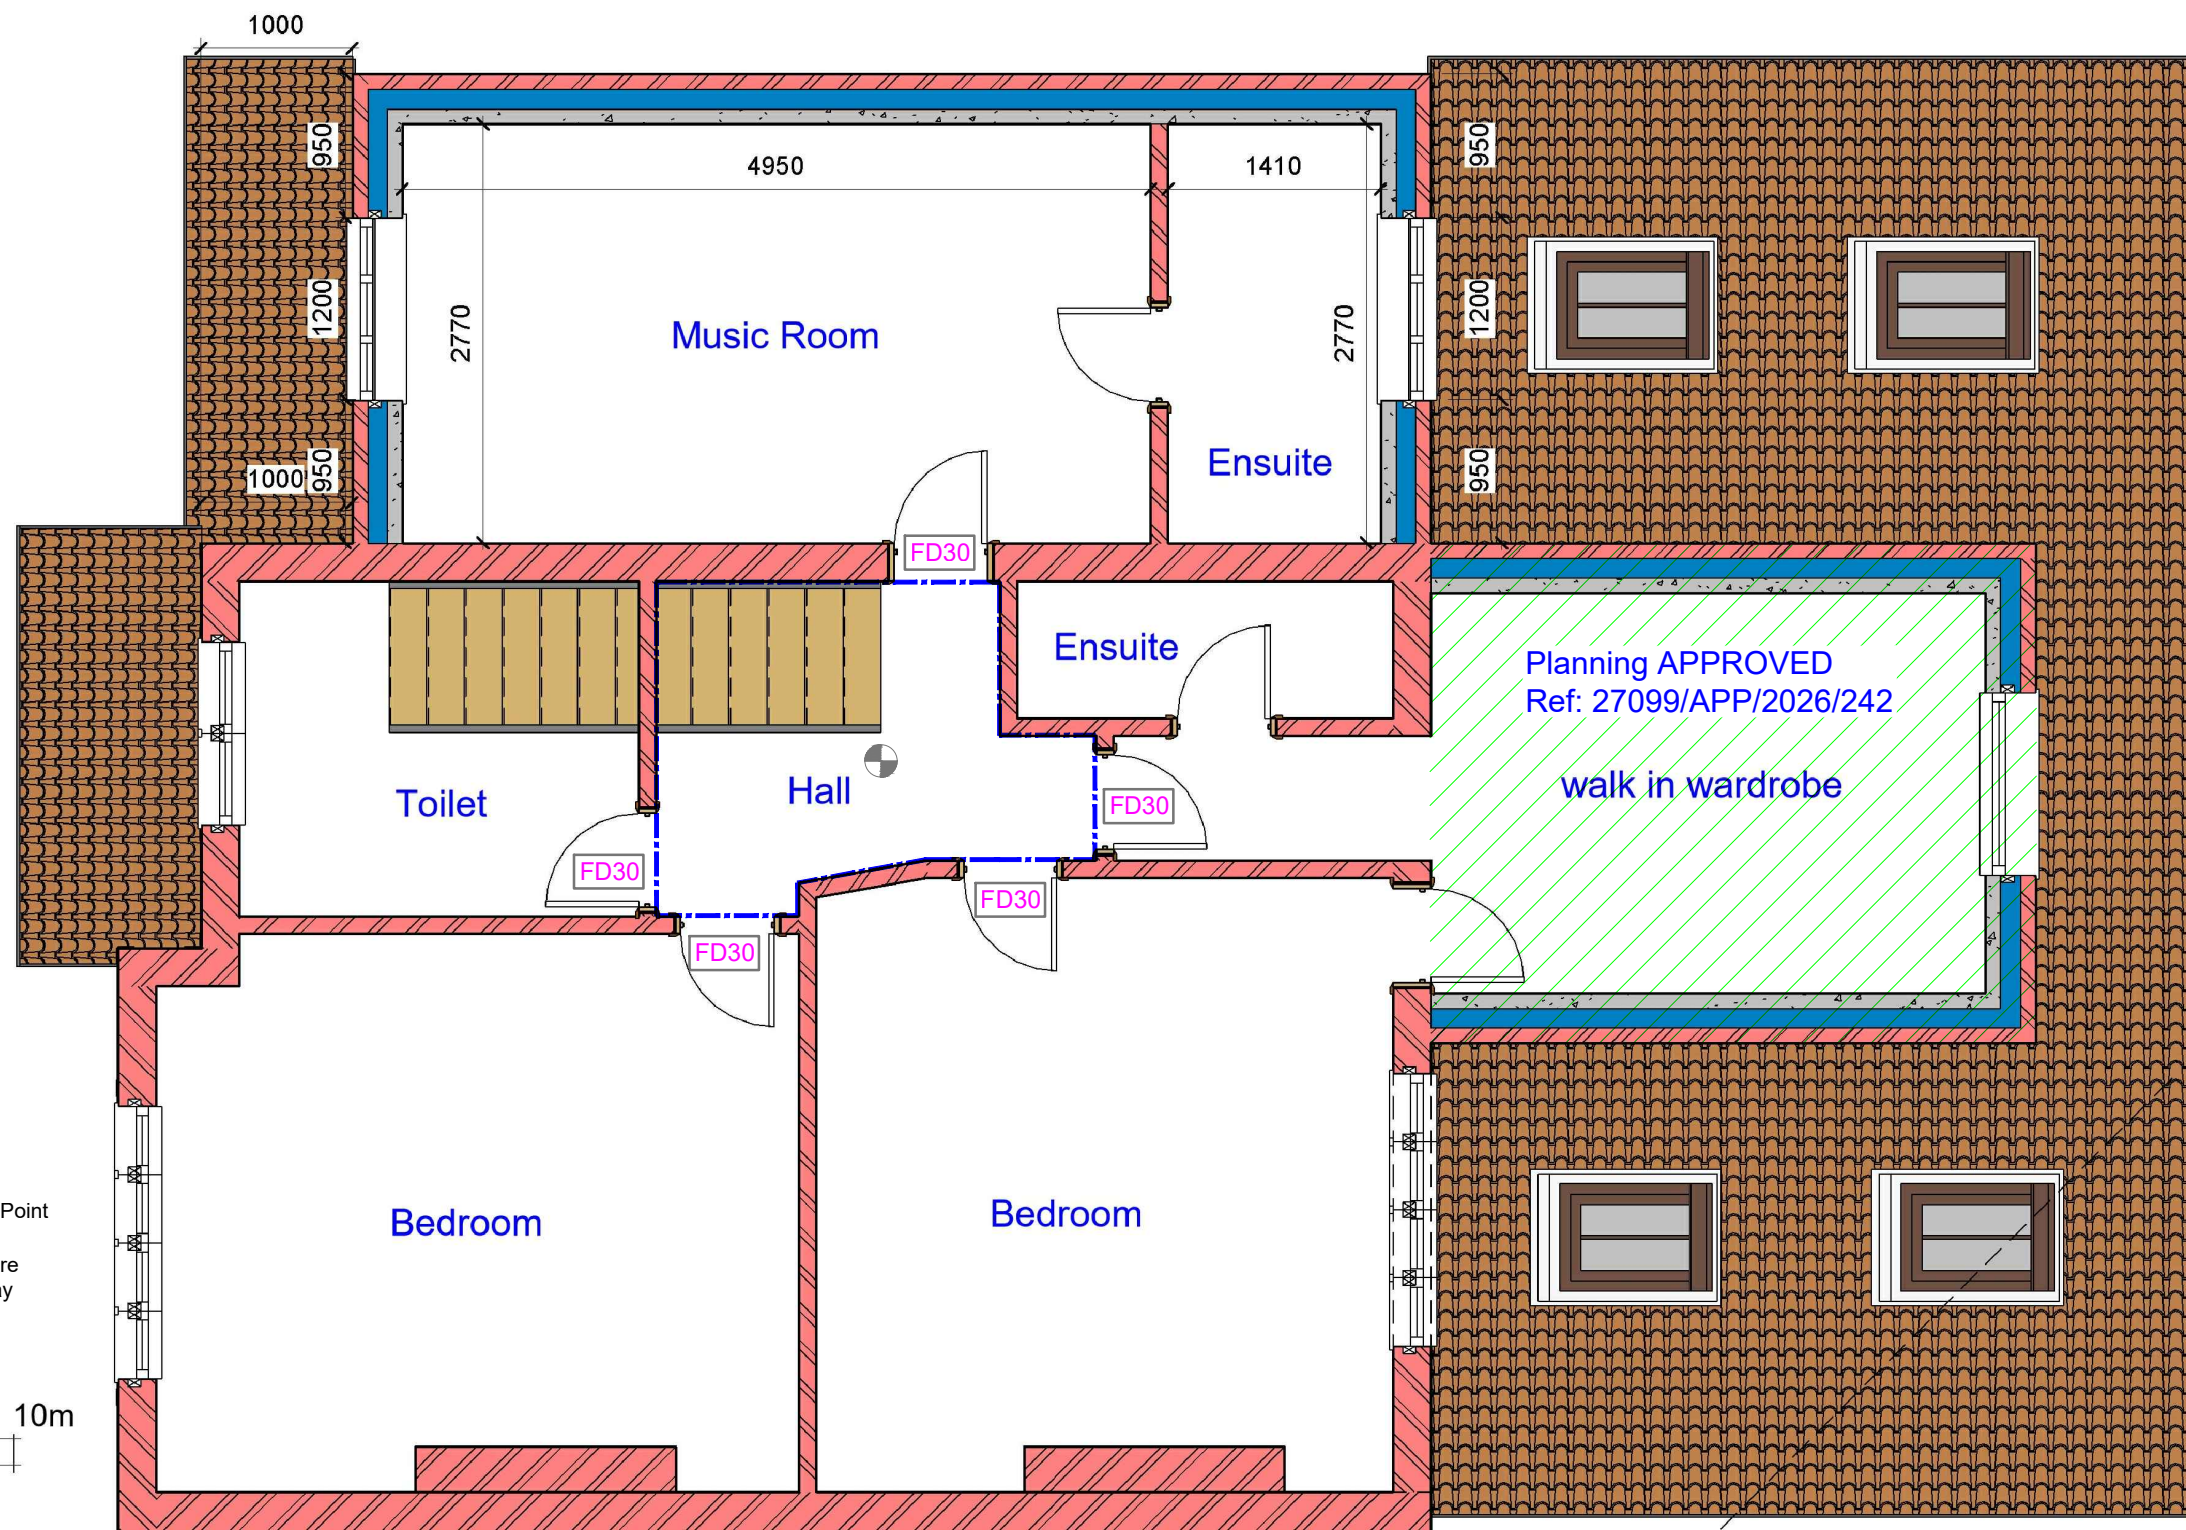

# 2 Proposed First Floor 1 : 50

neighbour's window

The existing partitions forming the protected staircase must provide half-hour fire resistance. They must be lined with 12.5mm plasterboard and skim

The doors to Bedrooms and any habitable rooms and the final exit door must not be fitted with a key on the inside. Thumb turns are acceptable

## GENERAL NOTES:

- DO NOT SCALE FROM THE DRAWINGS
- ALL DIMENSIONS ARE IN MILLIMETER.
- VERIFY ALL DIMENSIONS AND CONDITIONS BEFORE BUILDING OR STARTING CONSTRUCTION.
- NOTIFY THE DESIGNER IMMEDIATELY OF ANY DISCREPANCY OR VARIATION.
- ALL WORK TO COMPLY WITH CURRENT BUILDING REGULATIONS AND CODES OF PRACTICE.



Art @ Rooshika

NISARG@HOTMAIL.COM

+44 - 7951491310

## PROJECT

37 Wimborne Ave Hayes UB4 0HQ

## SHEET

Existing & Proposed First Floor Plan

## CLIENT

Mr Amrinder Singh

Date

Issue Date

Drawn by

Author

Checked by

Checker

Project number


Project Number

DRWAING NUMBER

A107

Scale (@ A3)

REV

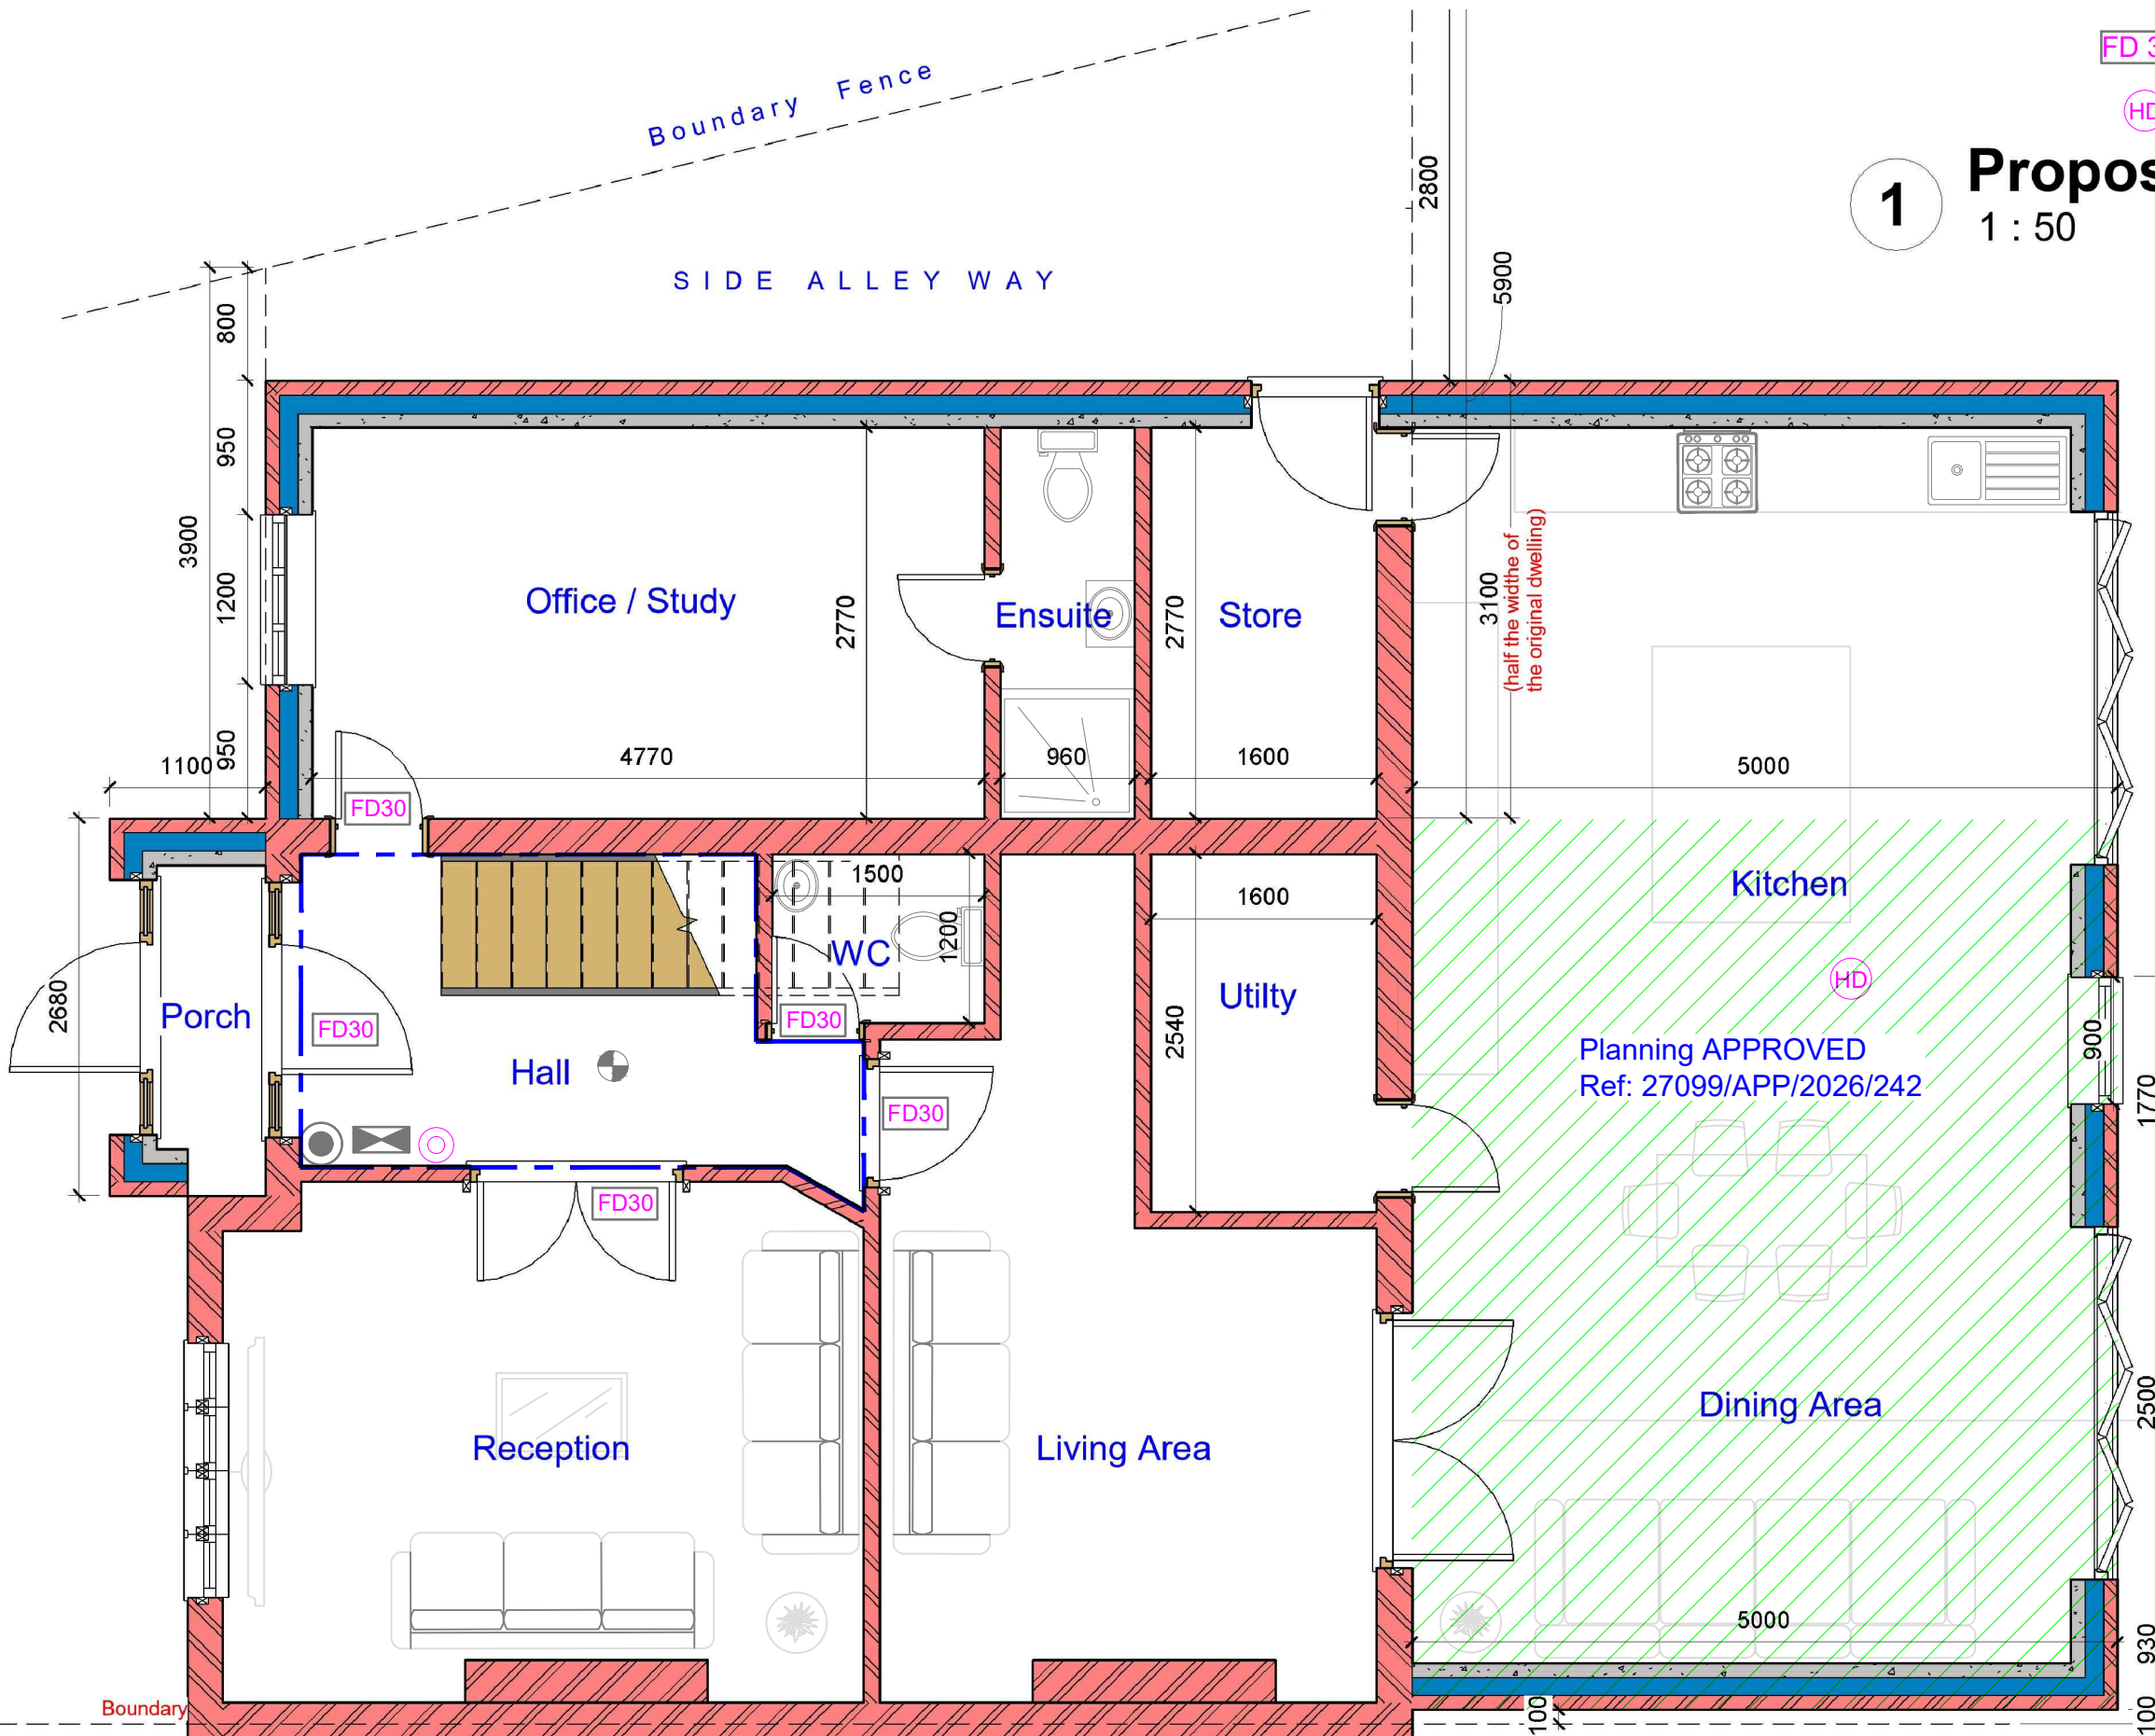

# 1 Proposed Ground Floor

1 : 50

- FD 30** Fire check doors 30 min fire resistance with smoke seal and self closing
- HD** Heat Detector comply with BS 5466 2:2016

The existing partitions forming the protected staircase must provide half-hour fire resistance. They must be lined with 12.5mm plasterboard and skim

**FD30** The doors to Bedrooms and any habitable rooms and the final exit door must not be fitted with a key on the inside. Thumb turns are acceptable

Assembly Point

Fire Alarm System comply with BS 5839:Part 1:2017

**FIRE EXIT** Fire Exit Sign Comply with BS 5499

**CM** Carbon Monoxide Detector


Extract Vent

Smoke alarm/detector to comply with BS EN14604

Foam 6 litre foam spray

Call Point

**EL** Emergency lights To be Installed in Accordance with BS5266: 2016

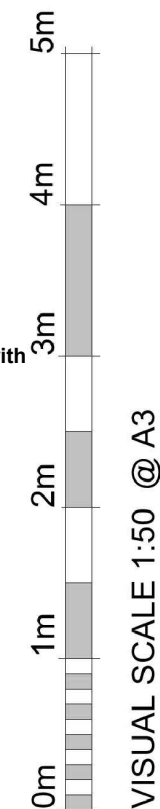

## GENERAL NOTES:

- DO NOT SCALE FROM THE DRAWINGS
- ALL DIMENSIONS ARE IN MILLIMETER.
- VERIFY ALL DIMENSIONS AND CONDITIONS BEFORE BUILDING OR STARTING CONSTRUCTION.
- NOTIFY THE DESIGNER IMMEDIATELY OF ANY DISCREPANCY OR VARIATION.
- ALL WORK TO COMPLY WITH CURRENT BUILDING REGULATIONS AND CODES OF PRACTICE.

Art @ Rooshika

NISARG@HOTMAIL.COM

+44 - 7951491310

37 Wimborne Ave Hayes UB4 0HQ

Proposed Ground Floor Plan

|            |                |                   |  |
|------------|----------------|-------------------|--|
| CLIENT     |                | Mr Amrinder Singh |  |
| Date       | Project number | Scale (@ A3)      |  |
| Issue Date | Project Number |                   |  |
| Drawn by   | DRWAING NUMBER | REV               |  |
| Author     | A105           |                   |  |
| Checked by |                |                   |  |
| Checker    |                |                   |  |