




Project No.	AR0712	
Dwg No.	AR-PL-3001	
Revision	A	
Scale at A3	1 : 100	
Date	18-01-24	
Designed	SS	Checked AC
Drawn	SS	Approved AC

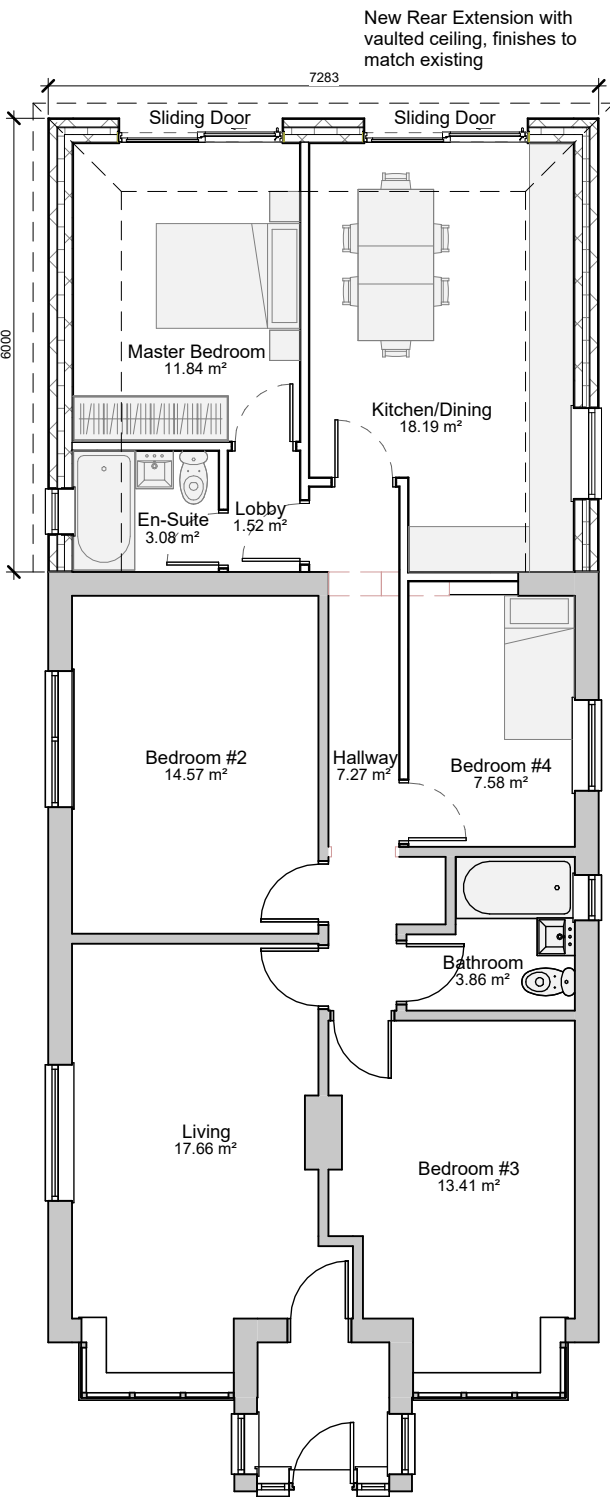

0 - Proposed Ground Floor Plan  
1 : 100

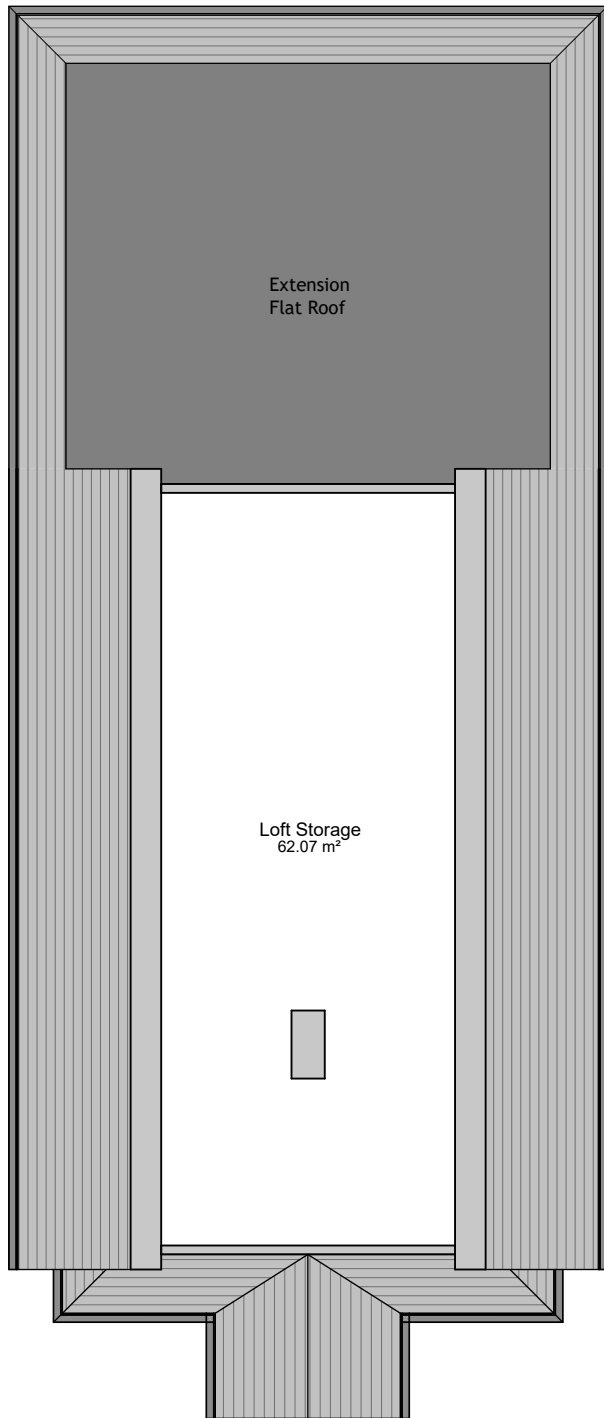

1 - Proposed Loft Plan  
1 : 100

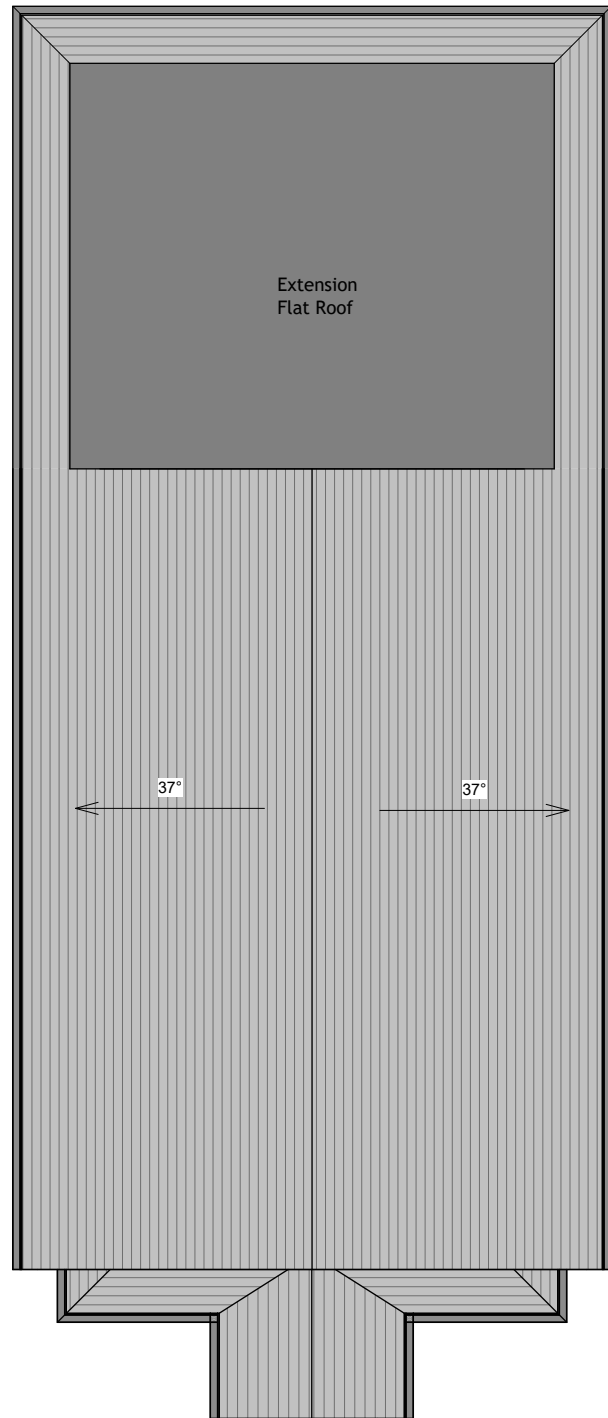

3 - Proposed Roof Plan  
1 : 100

