




Project No.	AR0712	
Dwg No.	AR-PL-3001	
Revision	-	
Scale at A3	1 : 100	
Date	18-12-24	
Designed	SS	Checked AC
Drawn	SS	Approved AC

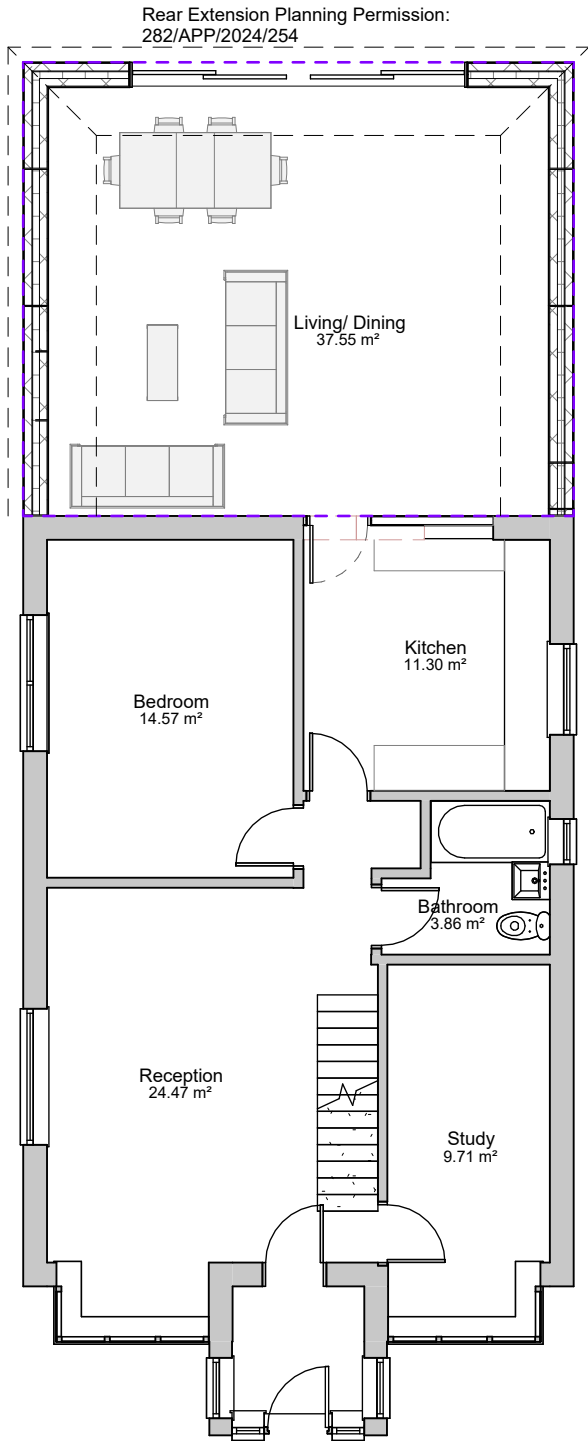

0 Existing Ground Floor Plan  
1 : 100

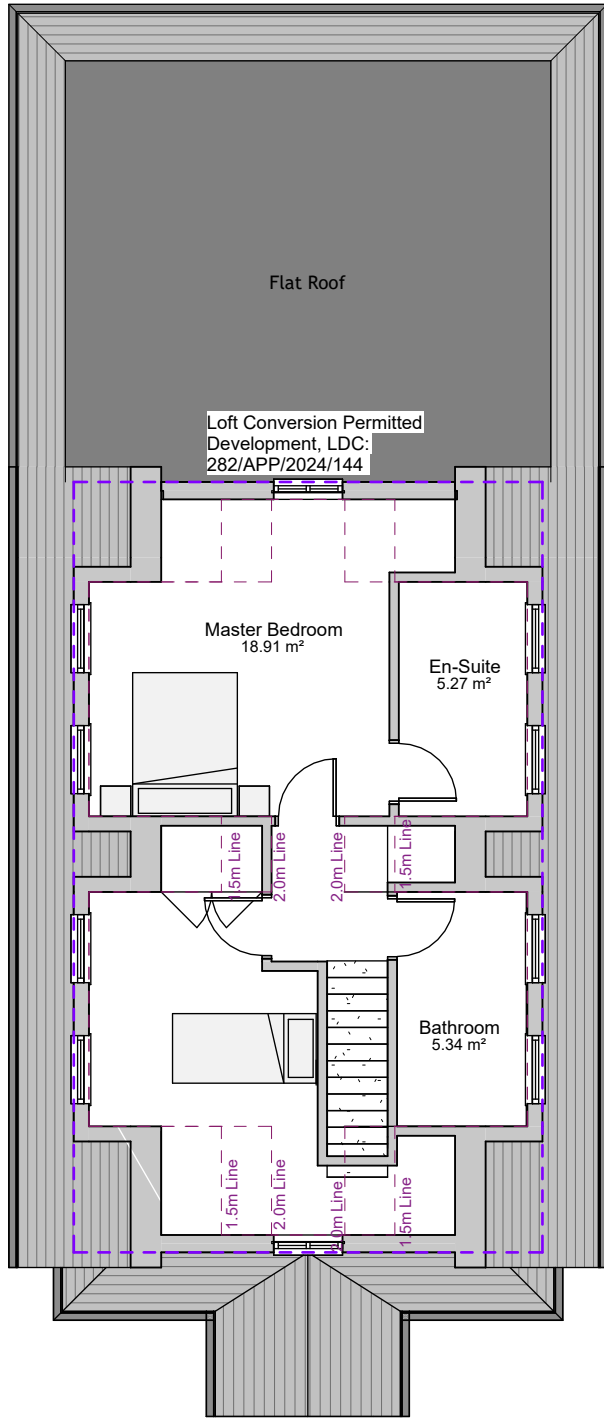

1 Existing First Floor Plan  
1 : 100

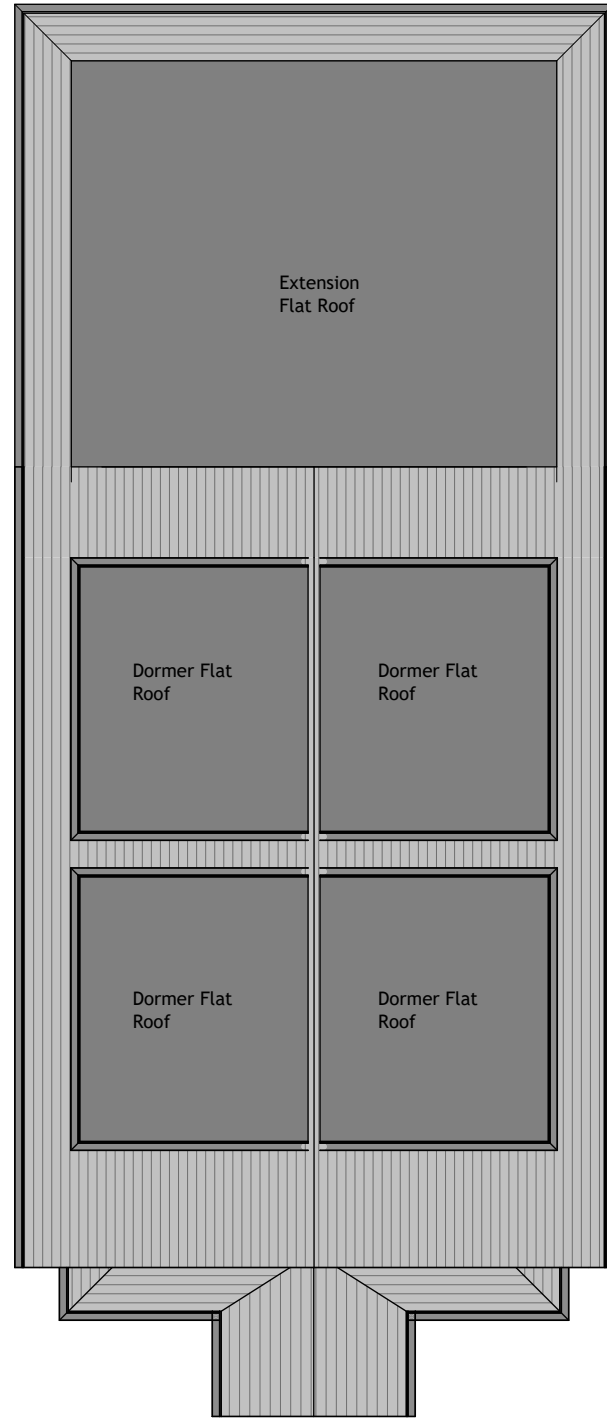

3 Existing Second Floor Plan  
1 : 100

