
 


SITE LOCATION

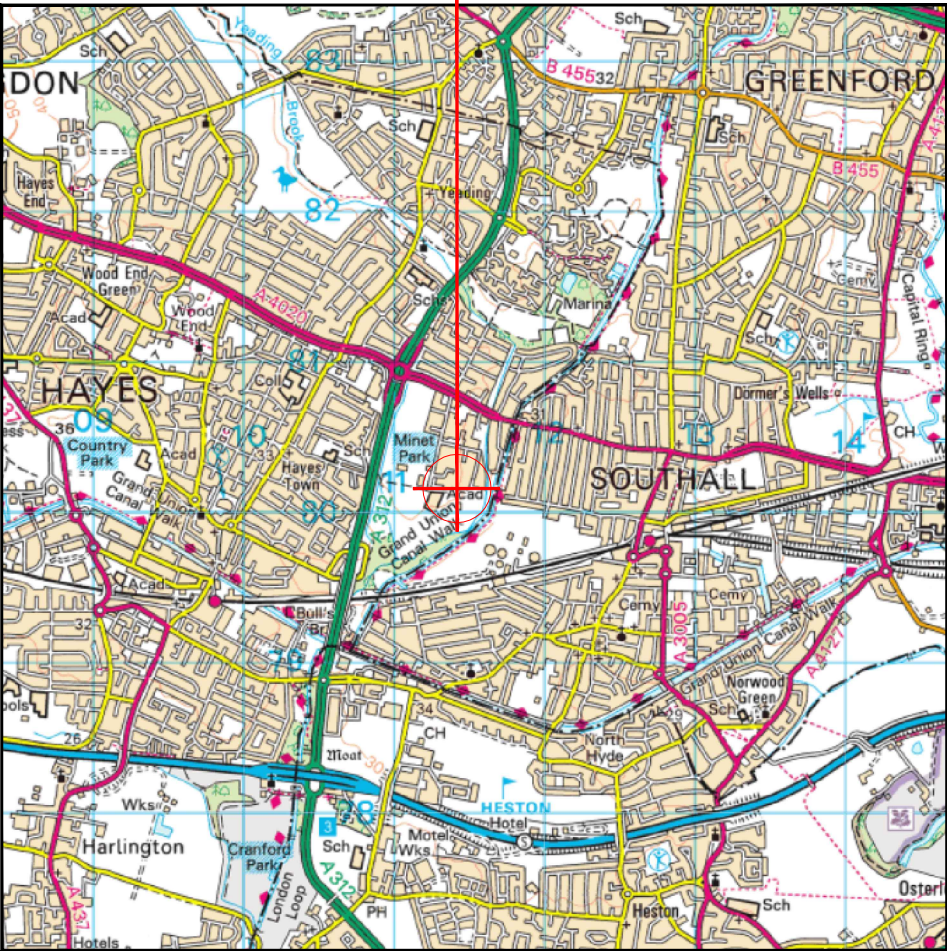


Reproduced by permission of Ordnance Survey on behalf of the Controller of Her Majesty's Stationary Office
All rights reserved. © Crown Copyright licence no. 100062043

SITE AREA PLAN




SITE PHOTOGRAPH

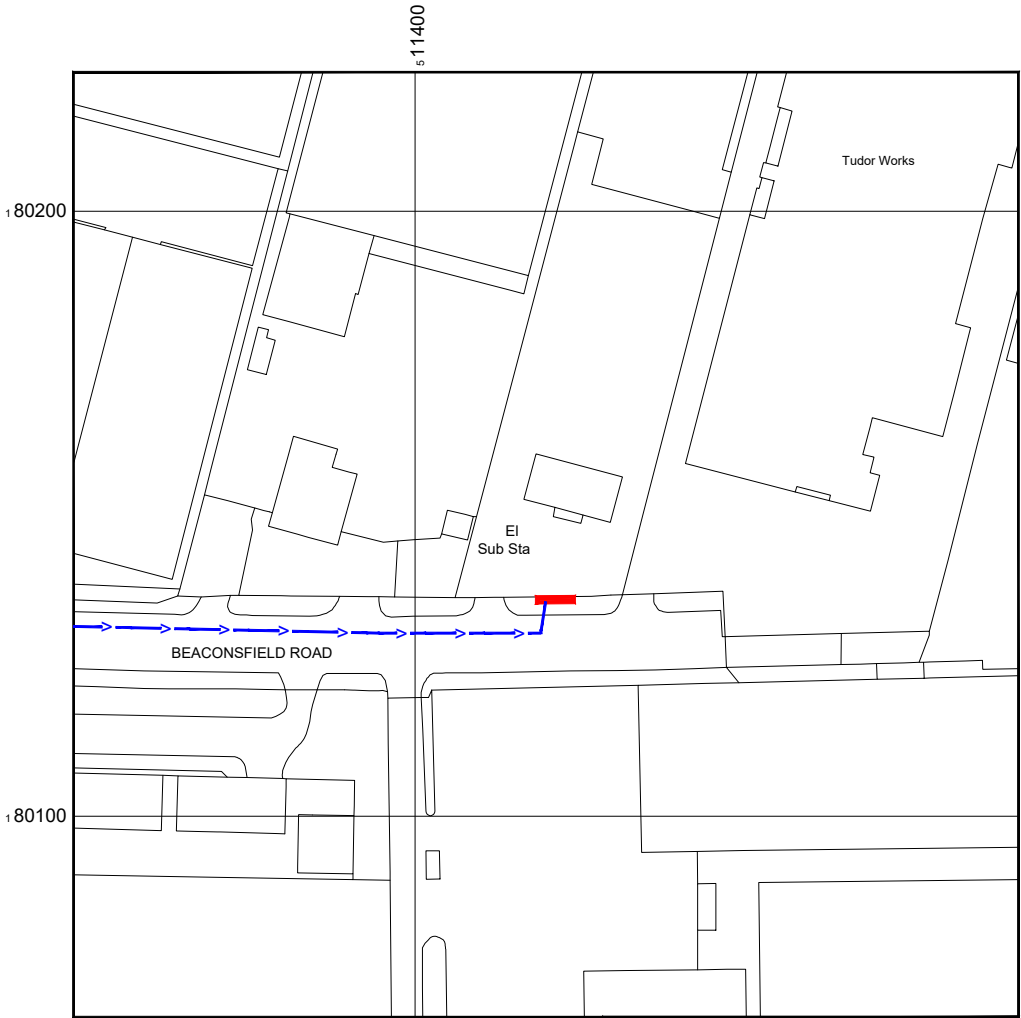

Reproduced by permission of Ordnance Survey on behalf of the Controller of Her Majesty's Stationary Office
All rights reserved. © Crown Copyright licence no. 100062043

NGR E: 511427 N: 180137

 SITE LOCATION PLAN



GOOGLE MAPS QR CODE

GOOGLE MAPS - <https://goo.gl/maps/qkCgLaThA8CKTXo16>

GOOGLE STREETVIEW - <https://goo.gl/maps/hkYWD8hjNqGto3Pv5>

NOTES:

1. ALL DIMENSIONS IN MM UNLESS OTHERWISE NOTED.

DIRECTIONS TO SITE:

Head east on M4. At junction 3, take the A312 exit to Harrow/Hayes/Hounslow/Heathrow Airport. At Cranford Parkway Interchange, take the 1st exit onto The Pkwy/A312. At the roundabout, take the 2nd exit and stay on The Pkwy/A312. Take the A4020 exit toward Uxbridge/Hayes/Ealing/Southall. At the roundabout, take the 3rd exit onto Uxbridge Rd/A4020. Turn right onto Springfeld Rd. Turn left onto Beaconsfield Road. Follow Beaconsfield Road and site location is on the left hand side.

Site Provider's
Property Boundary:



Access Route To Site:



Access Route:



Master:	MBNL / EE:	Project:	Purpose of Issue:	Issue:
M001	MBNL	5G UNILATERAL	Planning	A
Date:	03/05/2021	Revision / Upgrade Description:		
Drawn:	CDN	First Issue - Site nomination dated: TBC		
Checked:	DH			
Approved:	SD			

CK Hutchison
Networks (UK)
Limited

Great Brighams Mead,
Vastern Road, Reading,
Berkshire, England,
RG1 8DJ

Design Consultant & Principal Contractor:



WHP Telecoms

Unit 1 Maple Park,
Low Fields Avenue, Leeds
LS12 6HH

Tel: 01133023550
e-mail: info@whptelecoms.com

Site Name:
BEACONSFIELD ROAD STREETWORKS

Site ID:
EAL16785

Address:
BEACONSFIELD ROAD, HAYES,
LONDON BOROUGH OF HILLINGDON,
LONDON, GREATER LONDON,
UB4 0SL


Title:
002 SITE LOCATION PLAN

Project:
5G UNILATERAL

Purpose of Issue:
PLANNING

EE Cell ID:	MBNL Cell ID:	Cell ID:
N/A	N/A	N/A

Master Drawing No:	Issue:
EAL16785_M001	A

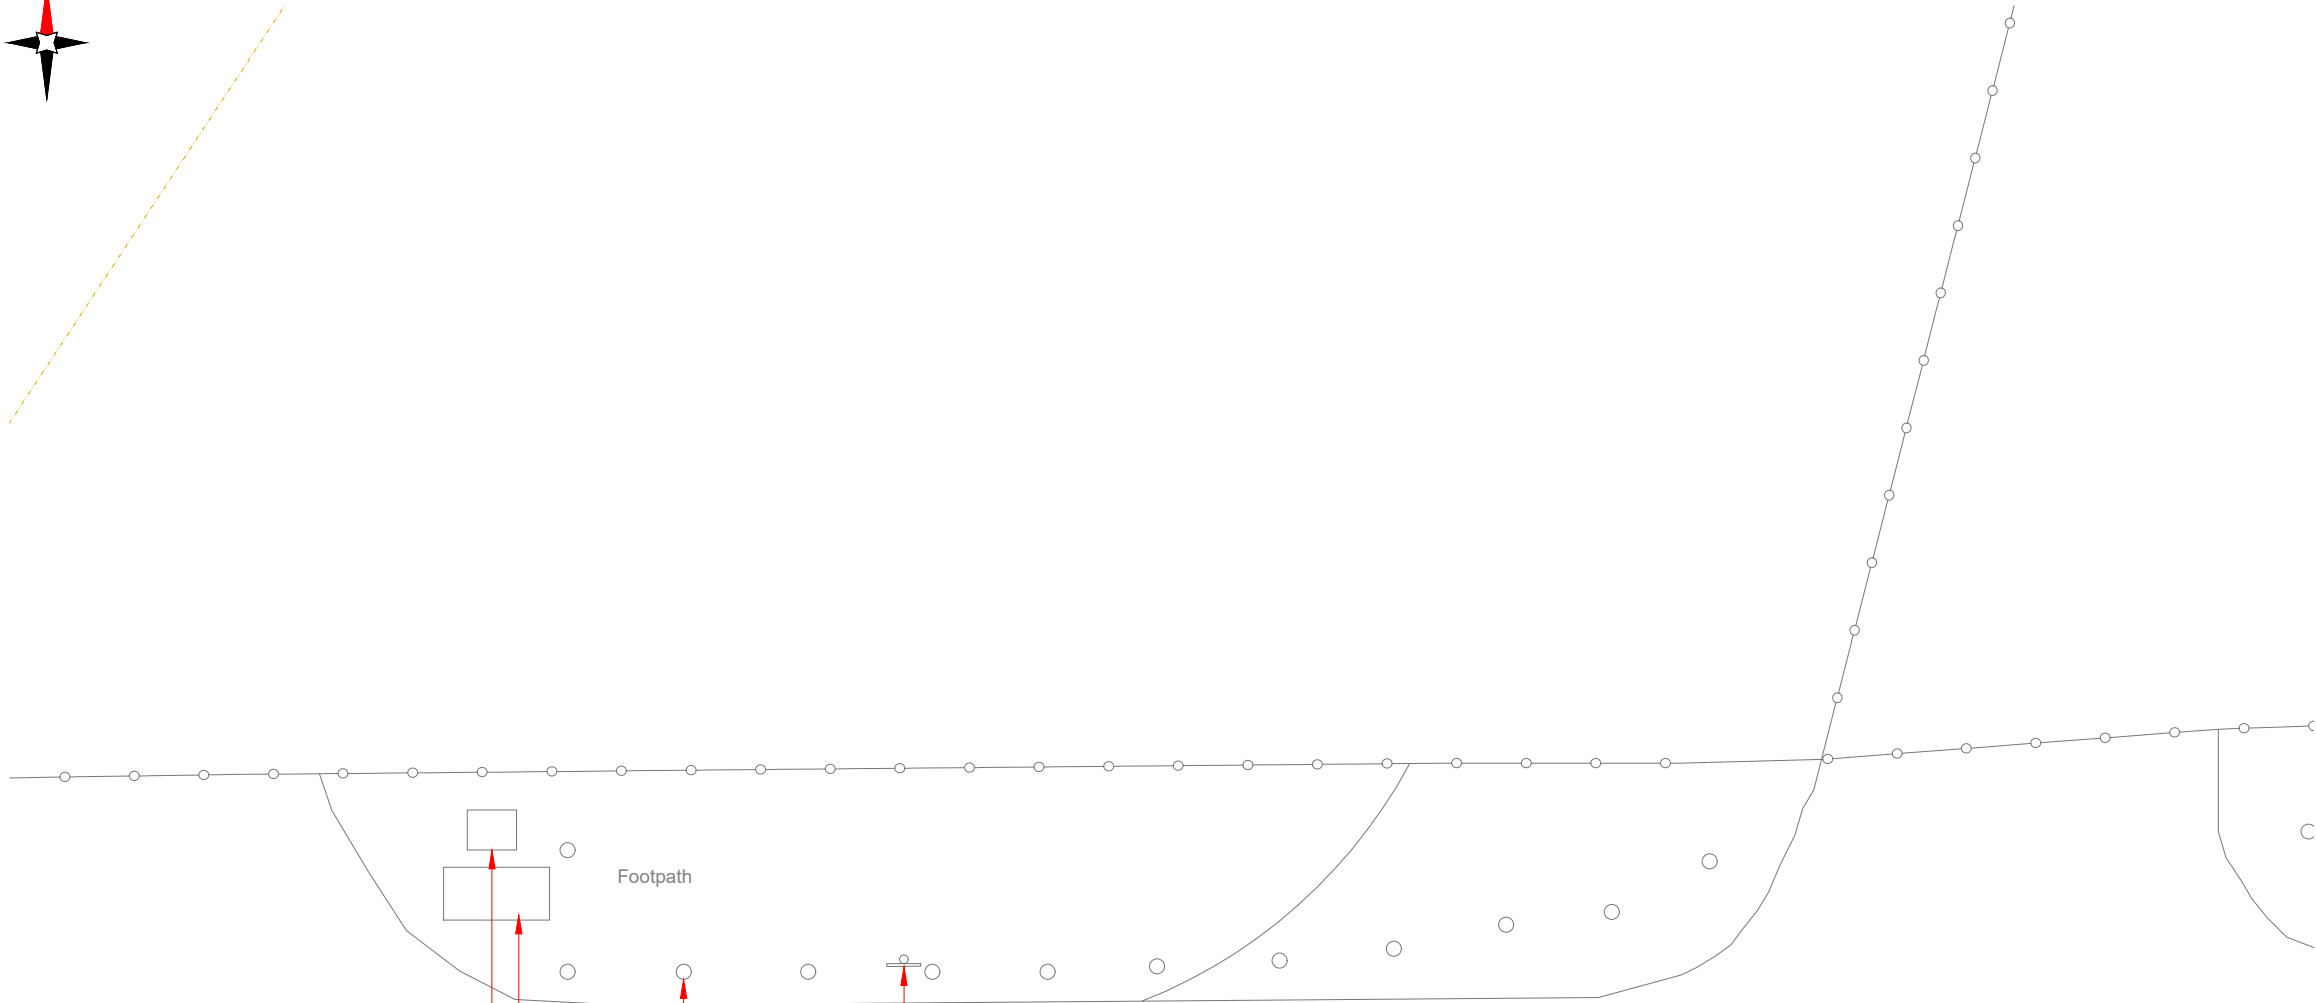

Existing vm chamber

Existing bt chamber

Existing bollards


Existing street sign

Beaconsfield Road
(20mph)




ELEVATION A

Existing approx. 8.0m high streetlight

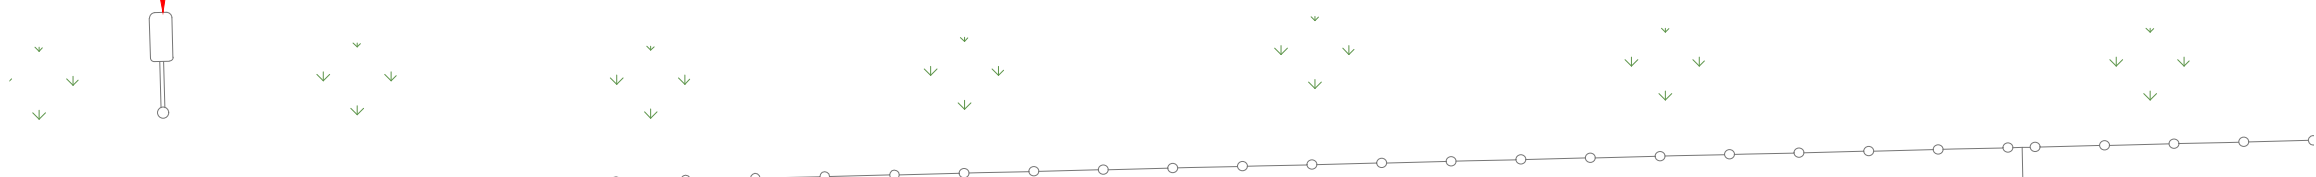

EXISTING SITE PLAN

 

- NOTES:
1. ALL DIMENSIONS IN MM UNLESS OTHERWISE NOTED.

Master:	MBNL / EE:	Project:	Purpose of Issue:	Issue:
M001	MBNL	5G UNILATERAL	Planning	A
Date:	03/05/2021	Revision / Upgrade Description:		
Drawn:	CDN	First Issue - Site nomination dated: TBC		
Checked:	DH			
Approved:	SD			

CK Hutchison
Networks (UK)
Limited

Great Brighams Mead,
Vastern Road, Reading,
Berkshire, England,
RG1 8DJ

Design Consultant & Principal Contractor:



WHP Telecoms
Unit 1 Maple Park,
Low Fields Avenue, Leeds
LS12 6HH

Tel: 01133023550
e-mail: info@whptelecoms.com

Site Name:
BEACONSFIELD ROAD STREETWORKS

Site ID:
EAL16785

Address:
BEACONSFIELD ROAD, HAYES,
LONDON BOROUGH OF HILLINGDON,
LONDON, GREATER LONDON,
UB4 0SL

Title:
100 EXISTING SITE PLAN

Project:
5G UNILATERAL

Purpose of Issue:
PLANNING

EE Cell ID:	MBNL Cell ID:	Cell ID:
N/A	N/A	N/A

Master Drawing No:	Issue:
EAL16785_M001	A

 
100mm

50mm

10mm



EXISTING ELEVATION A



- NOTES:
- ALL DIMENSIONS IN MM UNLESS OTHERWISE NOTED.

Master:	MBNL / EE:	Project:	Purpose of Issue:	Issue:
M001	MBNL	5G UNILATERAL	Planning	A
Date:	03/05/2021	Revision / Upgrade Description:		
Drawn:	CDN	First Issue - Site nomination dated: TBC		
Checked:	DH			
Approved:	SD			

CK Hutchison
Networks (UK)
Limited

Great Brighams Mead,
Vastern Road, Reading,
Berkshire, England,
RG1 8DJ

Design Consultant & Principal Contractor:



WHP Telecoms

Unit 1 Maple Park,
Low Fields Avenue, Leeds
LS12 6HH

Tel: 01133023550
e-mail: info@whptelecoms.com

Site Name:
BEACONSFIELD ROAD STREETWORKS

Site ID:
EAL16785

Address:
BEACONSFIELD ROAD, HAYES,
LONDON BOROUGH OF HILLINGDON,
LONDON, GREATER LONDON,
UB4 0SL


Title:
150 EXISTING ELEVATION A

Project:
5G UNILATERAL

Purpose of Issue:
PLANNING

EE Cell ID: N/A	MBNL Cell ID: N/A	Cell ID: N/A
--------------------	----------------------	-----------------

Master Drawing No: EAL16785_M001	Issue: A
-------------------------------------	-------------

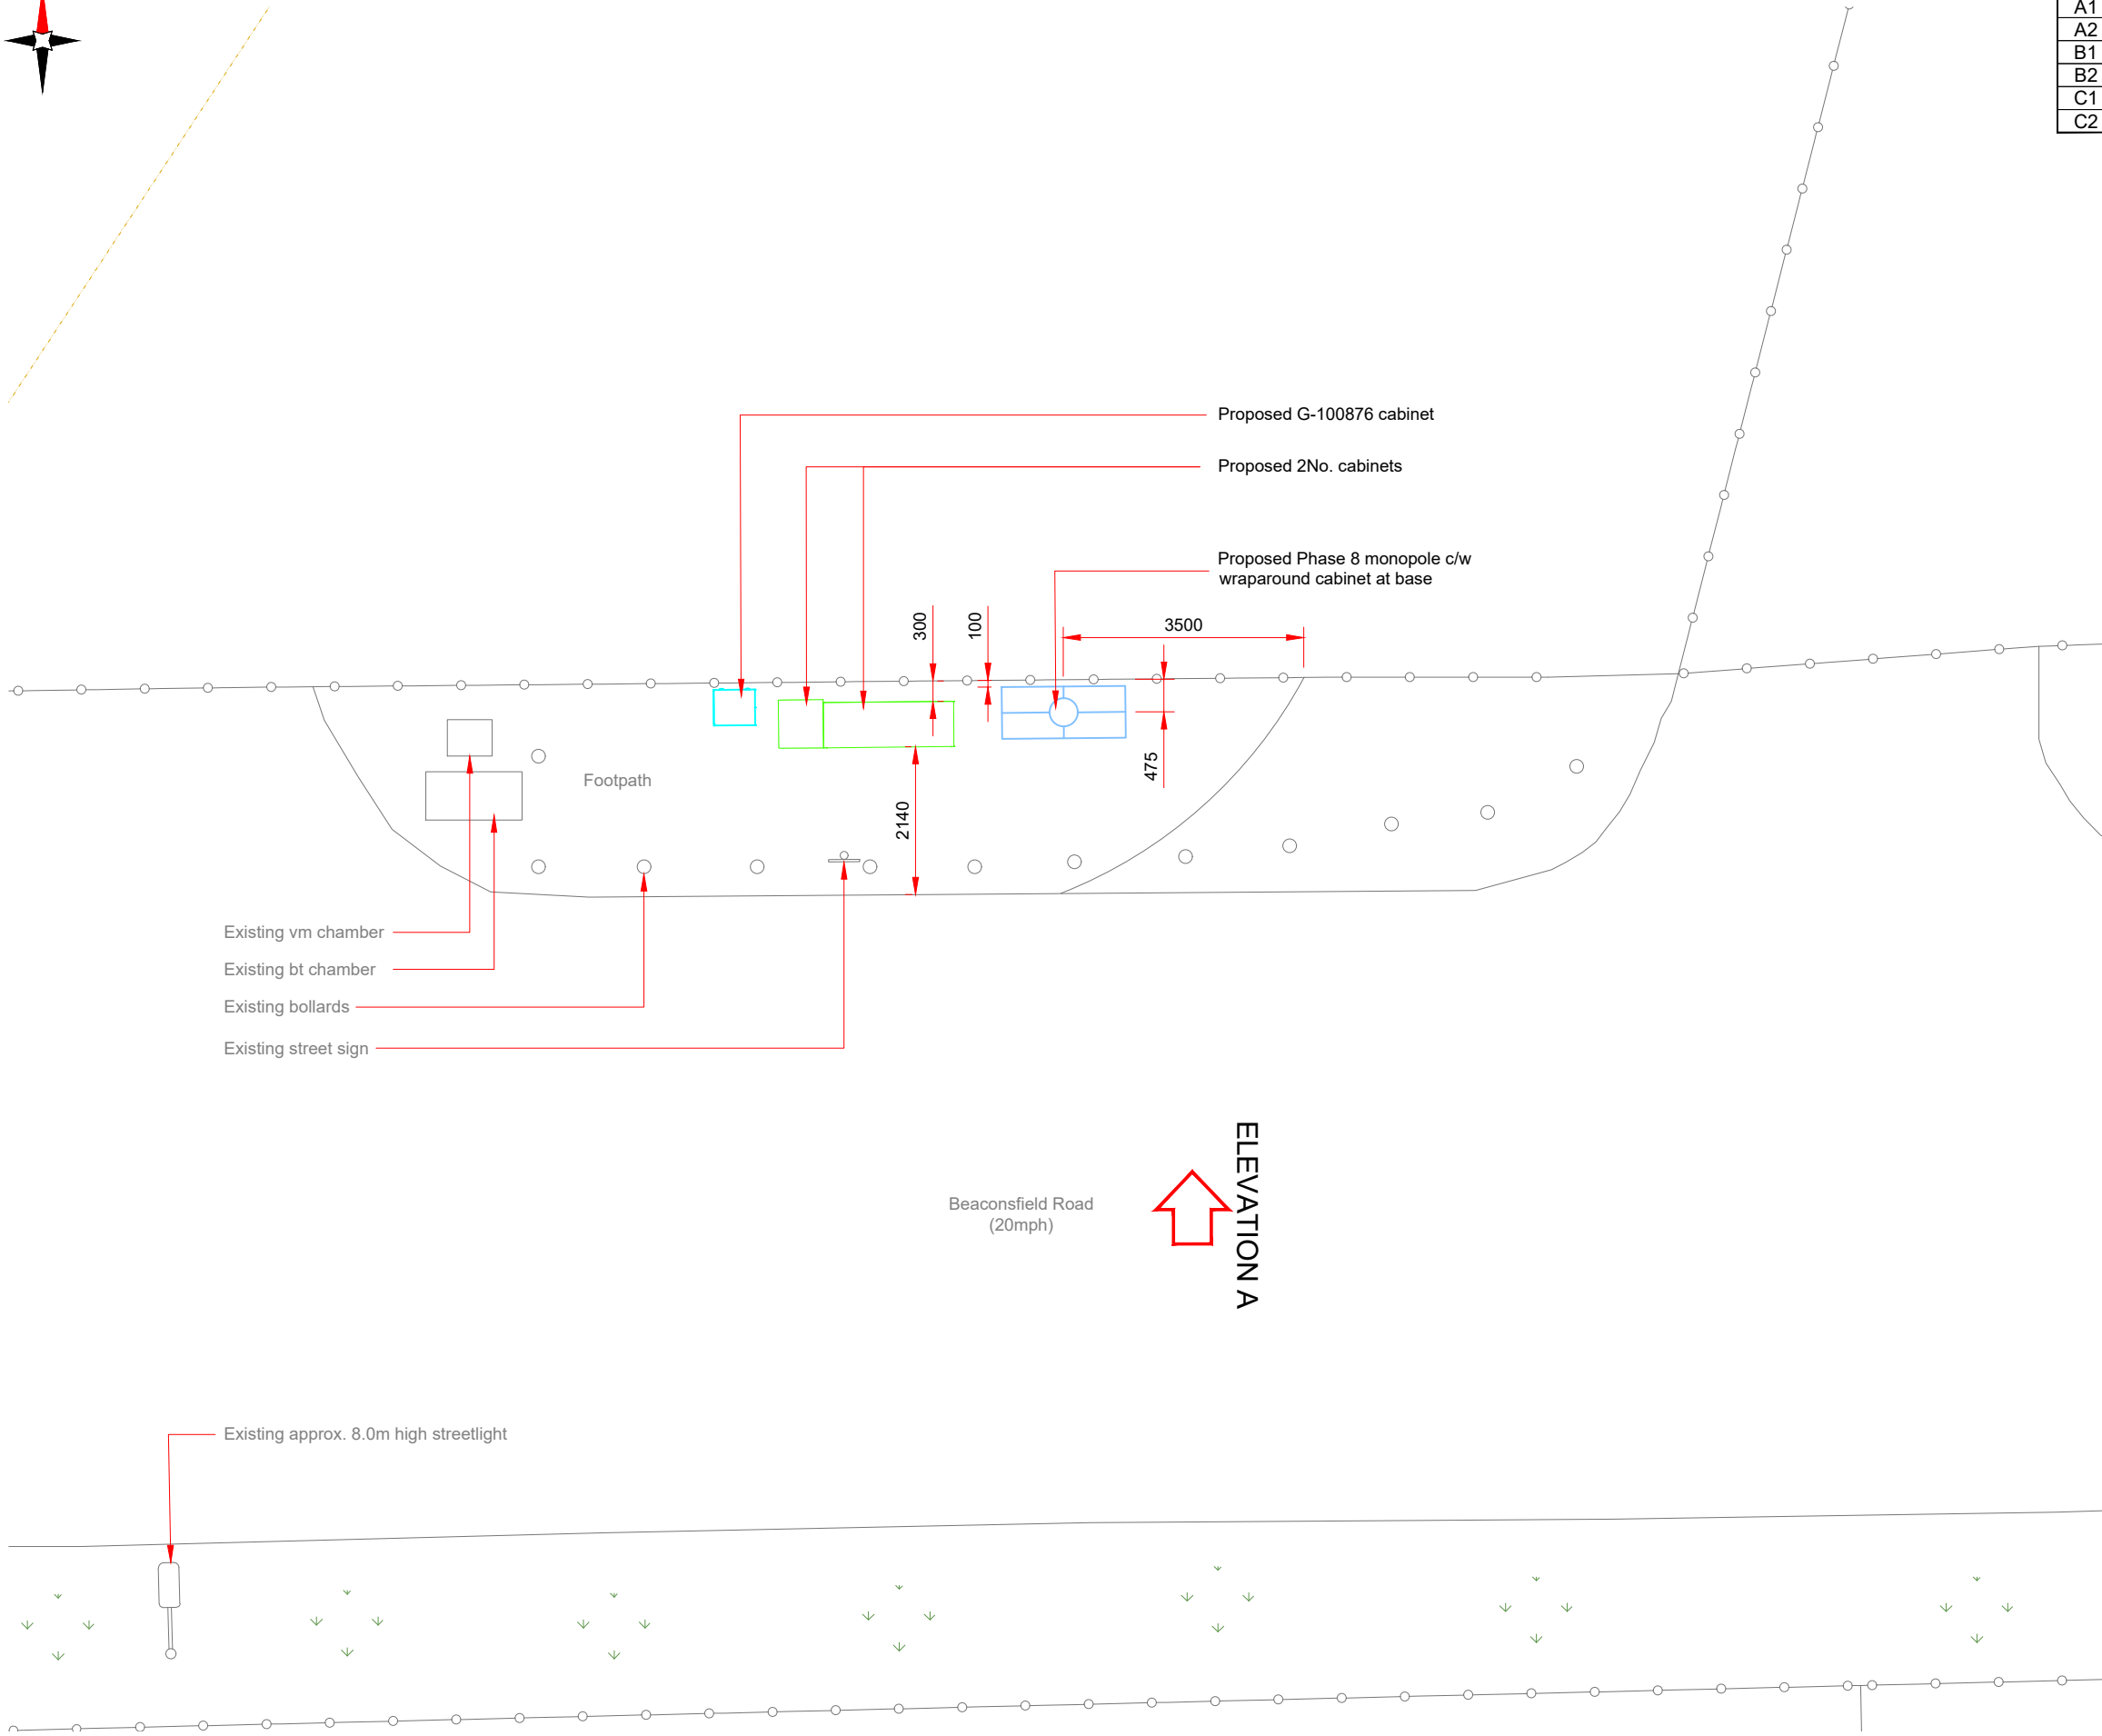

Antenna Aperture ID	Proposed 4G/5G Bearing
A1	60°
A2	60°
B1	180°
B2	180°
C1	300°
C2	300°

- NOTES:
- ALL DIMENSIONS IN MM UNLESS OTHERWISE NOTED.

Master:	MBNL / EE:	Project:	Purpose of Issue:	Issue:
M001	MBNL	5G UNILATERAL	Planning	A
Date:	03/05/2021	Revision / Upgrade Description:		
Drawn:	CDN	First Issue - Site nomination dated: TBC		
Checked:	DH			
Approved:	SD			

CK Hutchison Networks (UK) Limited
Great Brighams Mead,
Vastern Road, Reading,
Berkshire, England,
RG1 8DJ



WHP Telecoms
Unit 1 Maple Park,
Low Fields Avenue, Leeds
LS12 6HH
Tel: 01133023550
e-mail: info@whptelecoms.com

Site Name:
BEACONSFIELD ROAD STREETWORKS

Site ID:
EAL16785


Address:
**BEACONSFIELD ROAD, HAYES,
LONDON BOROUGH OF HILLINGDON,
LONDON, GREATER LONDON,
UB4 0SL**

Title:
210 PROPOSED SITE PLAN

Project:
5G UNILATERAL

Purpose of Issue:
PLANNING

EE Cell ID: N/A	MBNL Cell ID: N/A	Cell ID: N/A
Master Drawing No: EAL16785_M001		Issue: A

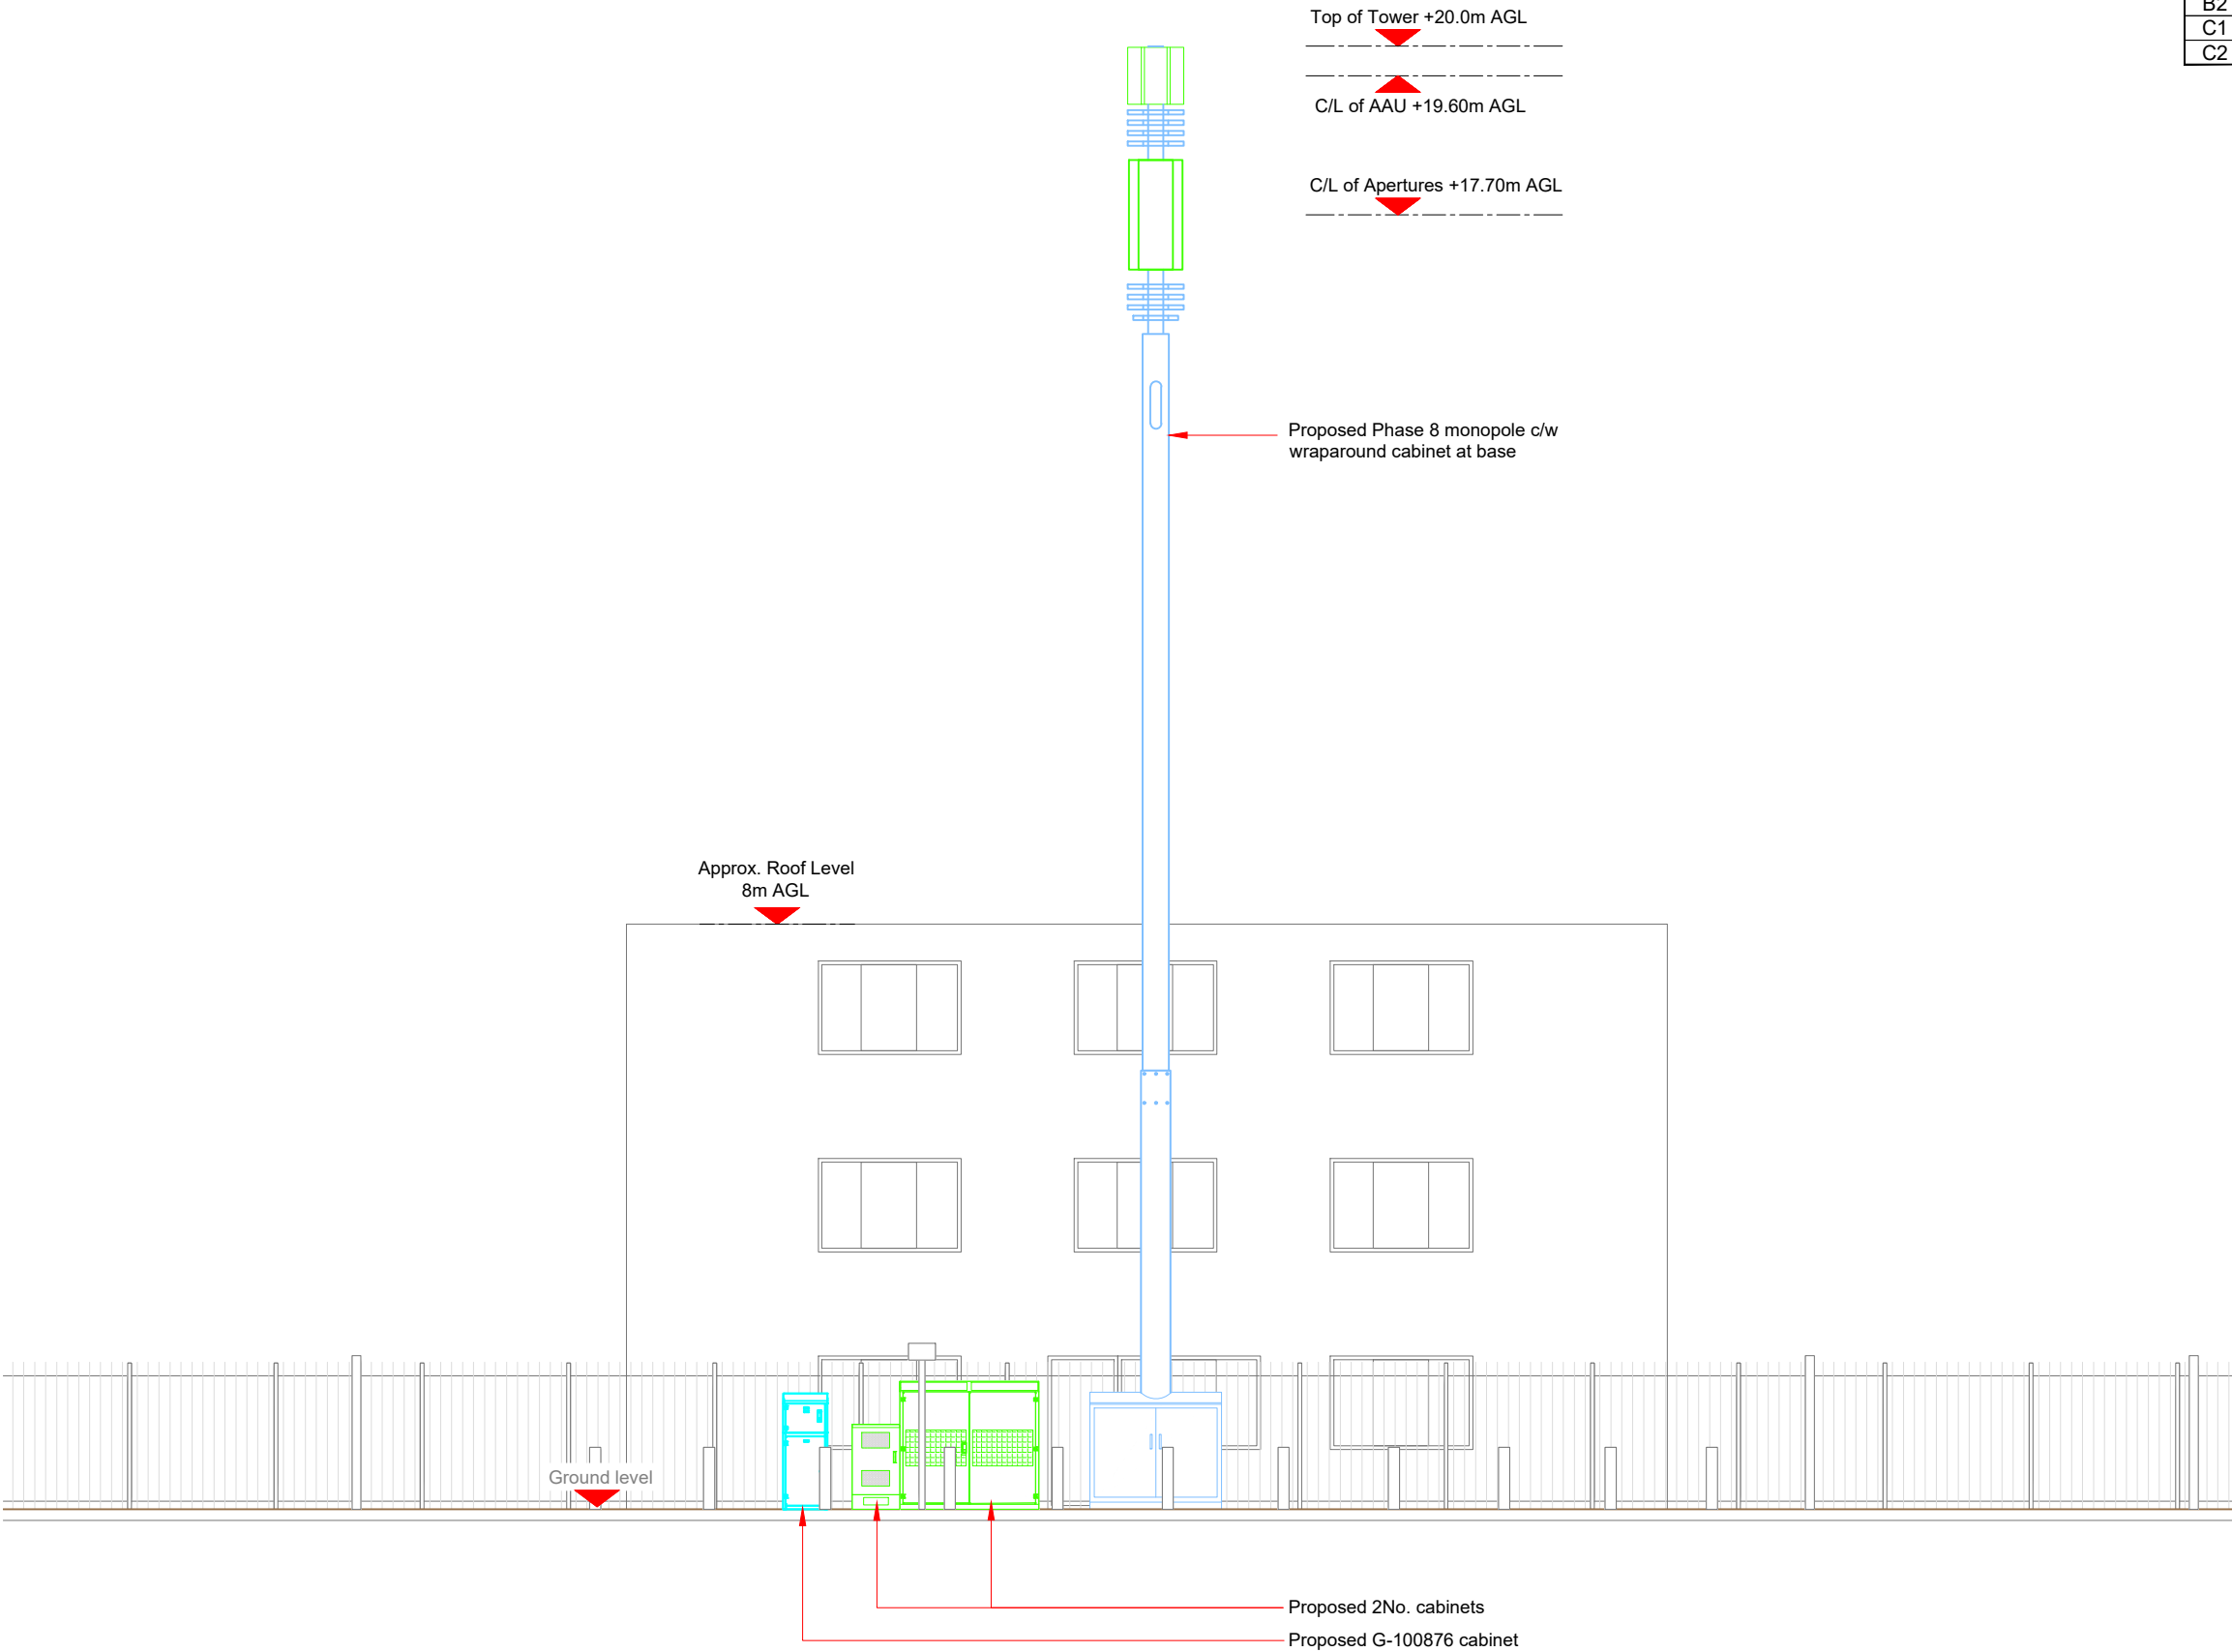

Antenna Aperture ID	Proposed 4G/5G Bearing
A1	60°
A2	60°
B1	180°
B2	180°
C1	300°
C2	300°

NOTES:

1. ALL DIMENSIONS IN MM UNLESS OTHERWISE NOTED.

Master:	MBNL / EE:	Project:	Purpose of Issue:	Issue:
M001	MBNL	5G UNILATERAL	Planning	A
Date:	03/05/2021	Revision / Upgrade Description:		
Drawn:	CDN	First Issue - Site nomination dated: TBC		
Checked:	DH			
Approved:	SD			

CK Hutchison Networks (UK) Limited

Great Brighams Mead,
Vastern Road, Reading,
Berkshire, England,
RG1 8DJ

Design Consultant & Principal Contractor:



WHP Telecoms
Unit 1 Maple Park,
Low Fields Avenue, Leeds
LS12 6HH

Tel: 01133023550
e-mail: info@whptelecoms.com

Site Name:
BEACONSFIELD ROAD STREETWORKS

Site ID:
EAL16785

Address:
**BEACONSFIELD ROAD, HAYES,
LONDON BOROUGH OF HILLINGDON,
LONDON, GREATER LONDON,
UB4 0SL**

Title:
260 PROPOSED ELEVATION


Project:
5G UNILATERAL

Purpose of Issue:
PLANNING

EE Cell ID:	MBNL Cell ID:	Cell ID:
N/A	N/A	N/A

Master Drawing No:	Issue:
EAL16785_M001	A

Proposed Antenna Aperture Schedule & RF Equipment Capacity																	
Antenna Aperture ID	Antenna Aperture Size (Length x Width x Depth)	Aperture Height C/L	Aperture Max Weight (kg)	Proposed 4G/5G Bearing	Tech: 4G/5G	Operator:	Antenna Aperture Coordinates		RRU No. Max Size & Weight L=300mm W=400mm D=150mm Weight=25kg	MHA No. Max Size & Weight L=300mm W=300mm D=150mm Weight=10kg	Main Feeder			BOB Max Size & Weight (300x300x250mm & 5kg)		Active Router No. Max Size & Weight (370x260x150mm & 10kg)	Passive Router No. Max Size & Weight (350x220x150mm & 10kg)
							Eastings	Northings			Size	Length	No.	No. Top	No. Bottom		
A1	778x403x268mm	19.60m	43.4kg	60°	5G	-	-	-	0	0	TBC	TBC	4	1	1	1	
A2	1499x448x165mm	17.70m	37.5kg	60°	4G	-	-	-	3	0	TBC	TBC	4	1	1	1	
B1	778x403x268mm	19.60m	43.4kg	180°	5G	-	-	-	0	0	TBC	TBC	4	1	1	1	
B2	1499x448x165mm	17.70m	37.5kg	180°	4G	-	-	-	3	0	TBC	TBC	4	1	1	1	
C1	778x403x268mm	19.60m	43.4kg	300°	5G	-	-	-	0	0	TBC	TBC	4	1	1	1	
C2	1499x448x165mm	17.70m	37.5kg	300°	4G	-	-	-	3	0	TBC	TBC	4	1	1	1	

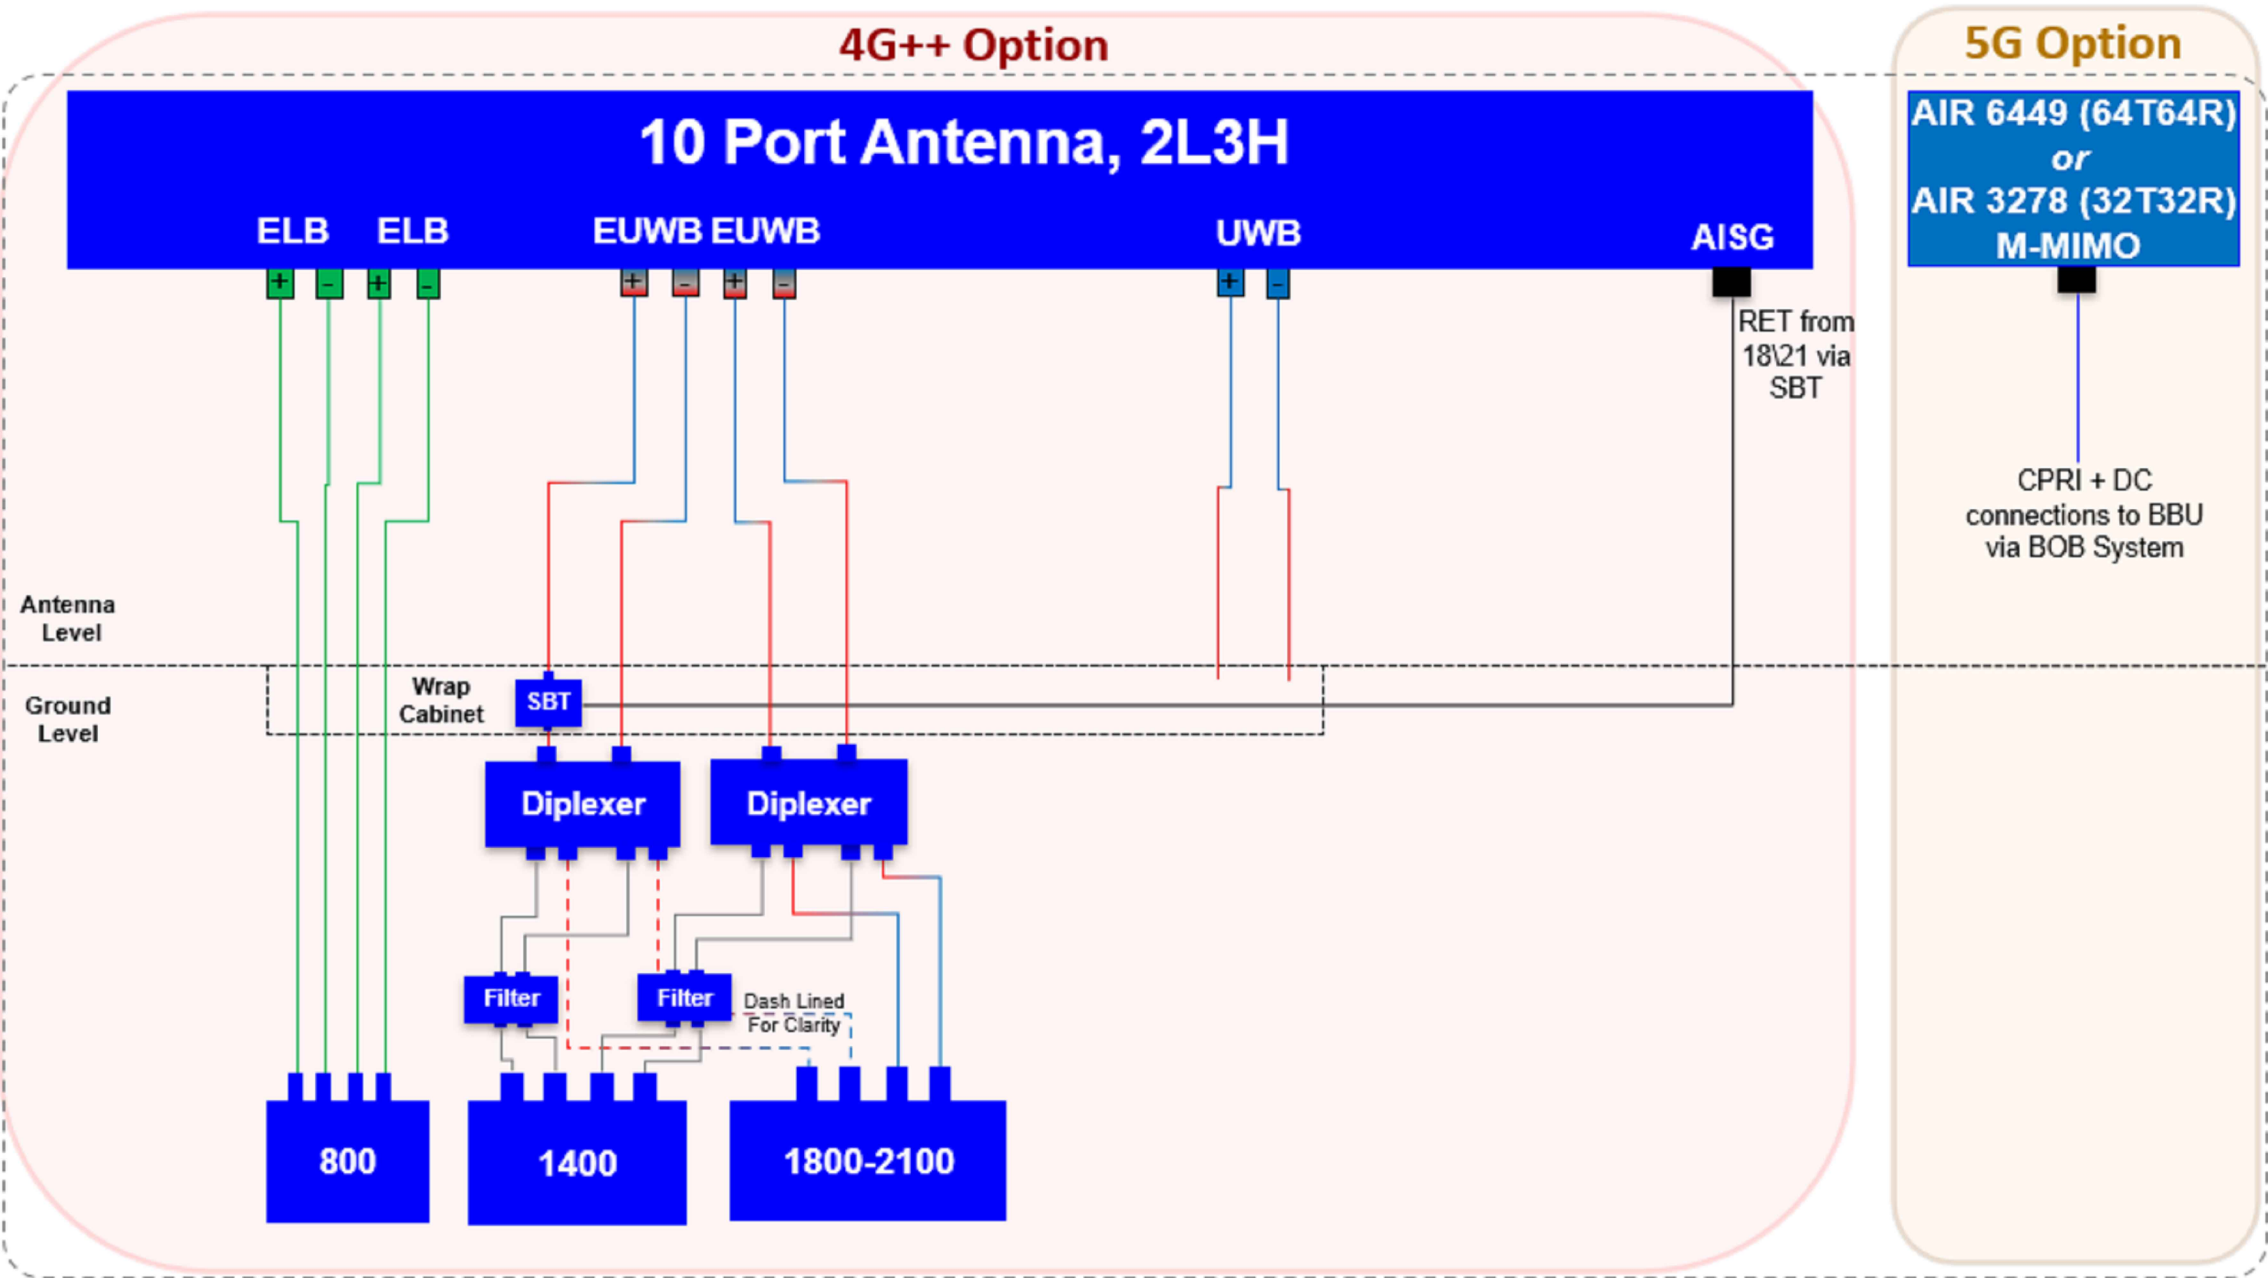

STATUS KEY:

Installed: Existing
Retain: Existing and to remain
Relocate: Existing and to be relocated
Remove: Existing to be removed from site
Proposed: New on site

Master:	MBNL / EE:	Project:	Purpose of Issue:	Issue:
M001	MBNL	5G UNILATERAL	Planning	A
Date:	03/05/2021	Revision / Upgrade Description:		
Drawn:	CDN	First Issue - Site nomination dated: TBC		
Checked:	DH			
Approved:	SD			
CK Hutchison Networks (UK) Limited Great Brighams Mead, Vastern Road, Reading, Berkshire, England, RG1 8DJ				
Design Consultant & Principal Contractor:				
		WHP Telecoms Unit 1 Maple Park, Low Fields Avenue, Leeds LS12 6HH Tel: 01133023550 e-mail: info@whptelecoms.com		
Site Name:				
BEACONSFIELD ROAD STREETWORKS				
Site ID:				
EAL16785				
Address:				
BEACONSFIELD ROAD, HAYES, LONDON BOROUGH OF HILLINGDON, LONDON, GREATER LONDON, UB4 0SL				
Title: 303 PROPOSED ANTENNA SCHEDULE & LINE CONFIGURATION				
Project:				
5G UNILATERAL				
Purpose of Issue:				
PLANNING				
EE Cell ID:		MBNL Cell ID:		Cell ID:
N/A		N/A		N/A
Master Drawing No:				Issue:
EAL16785_M001				A

