


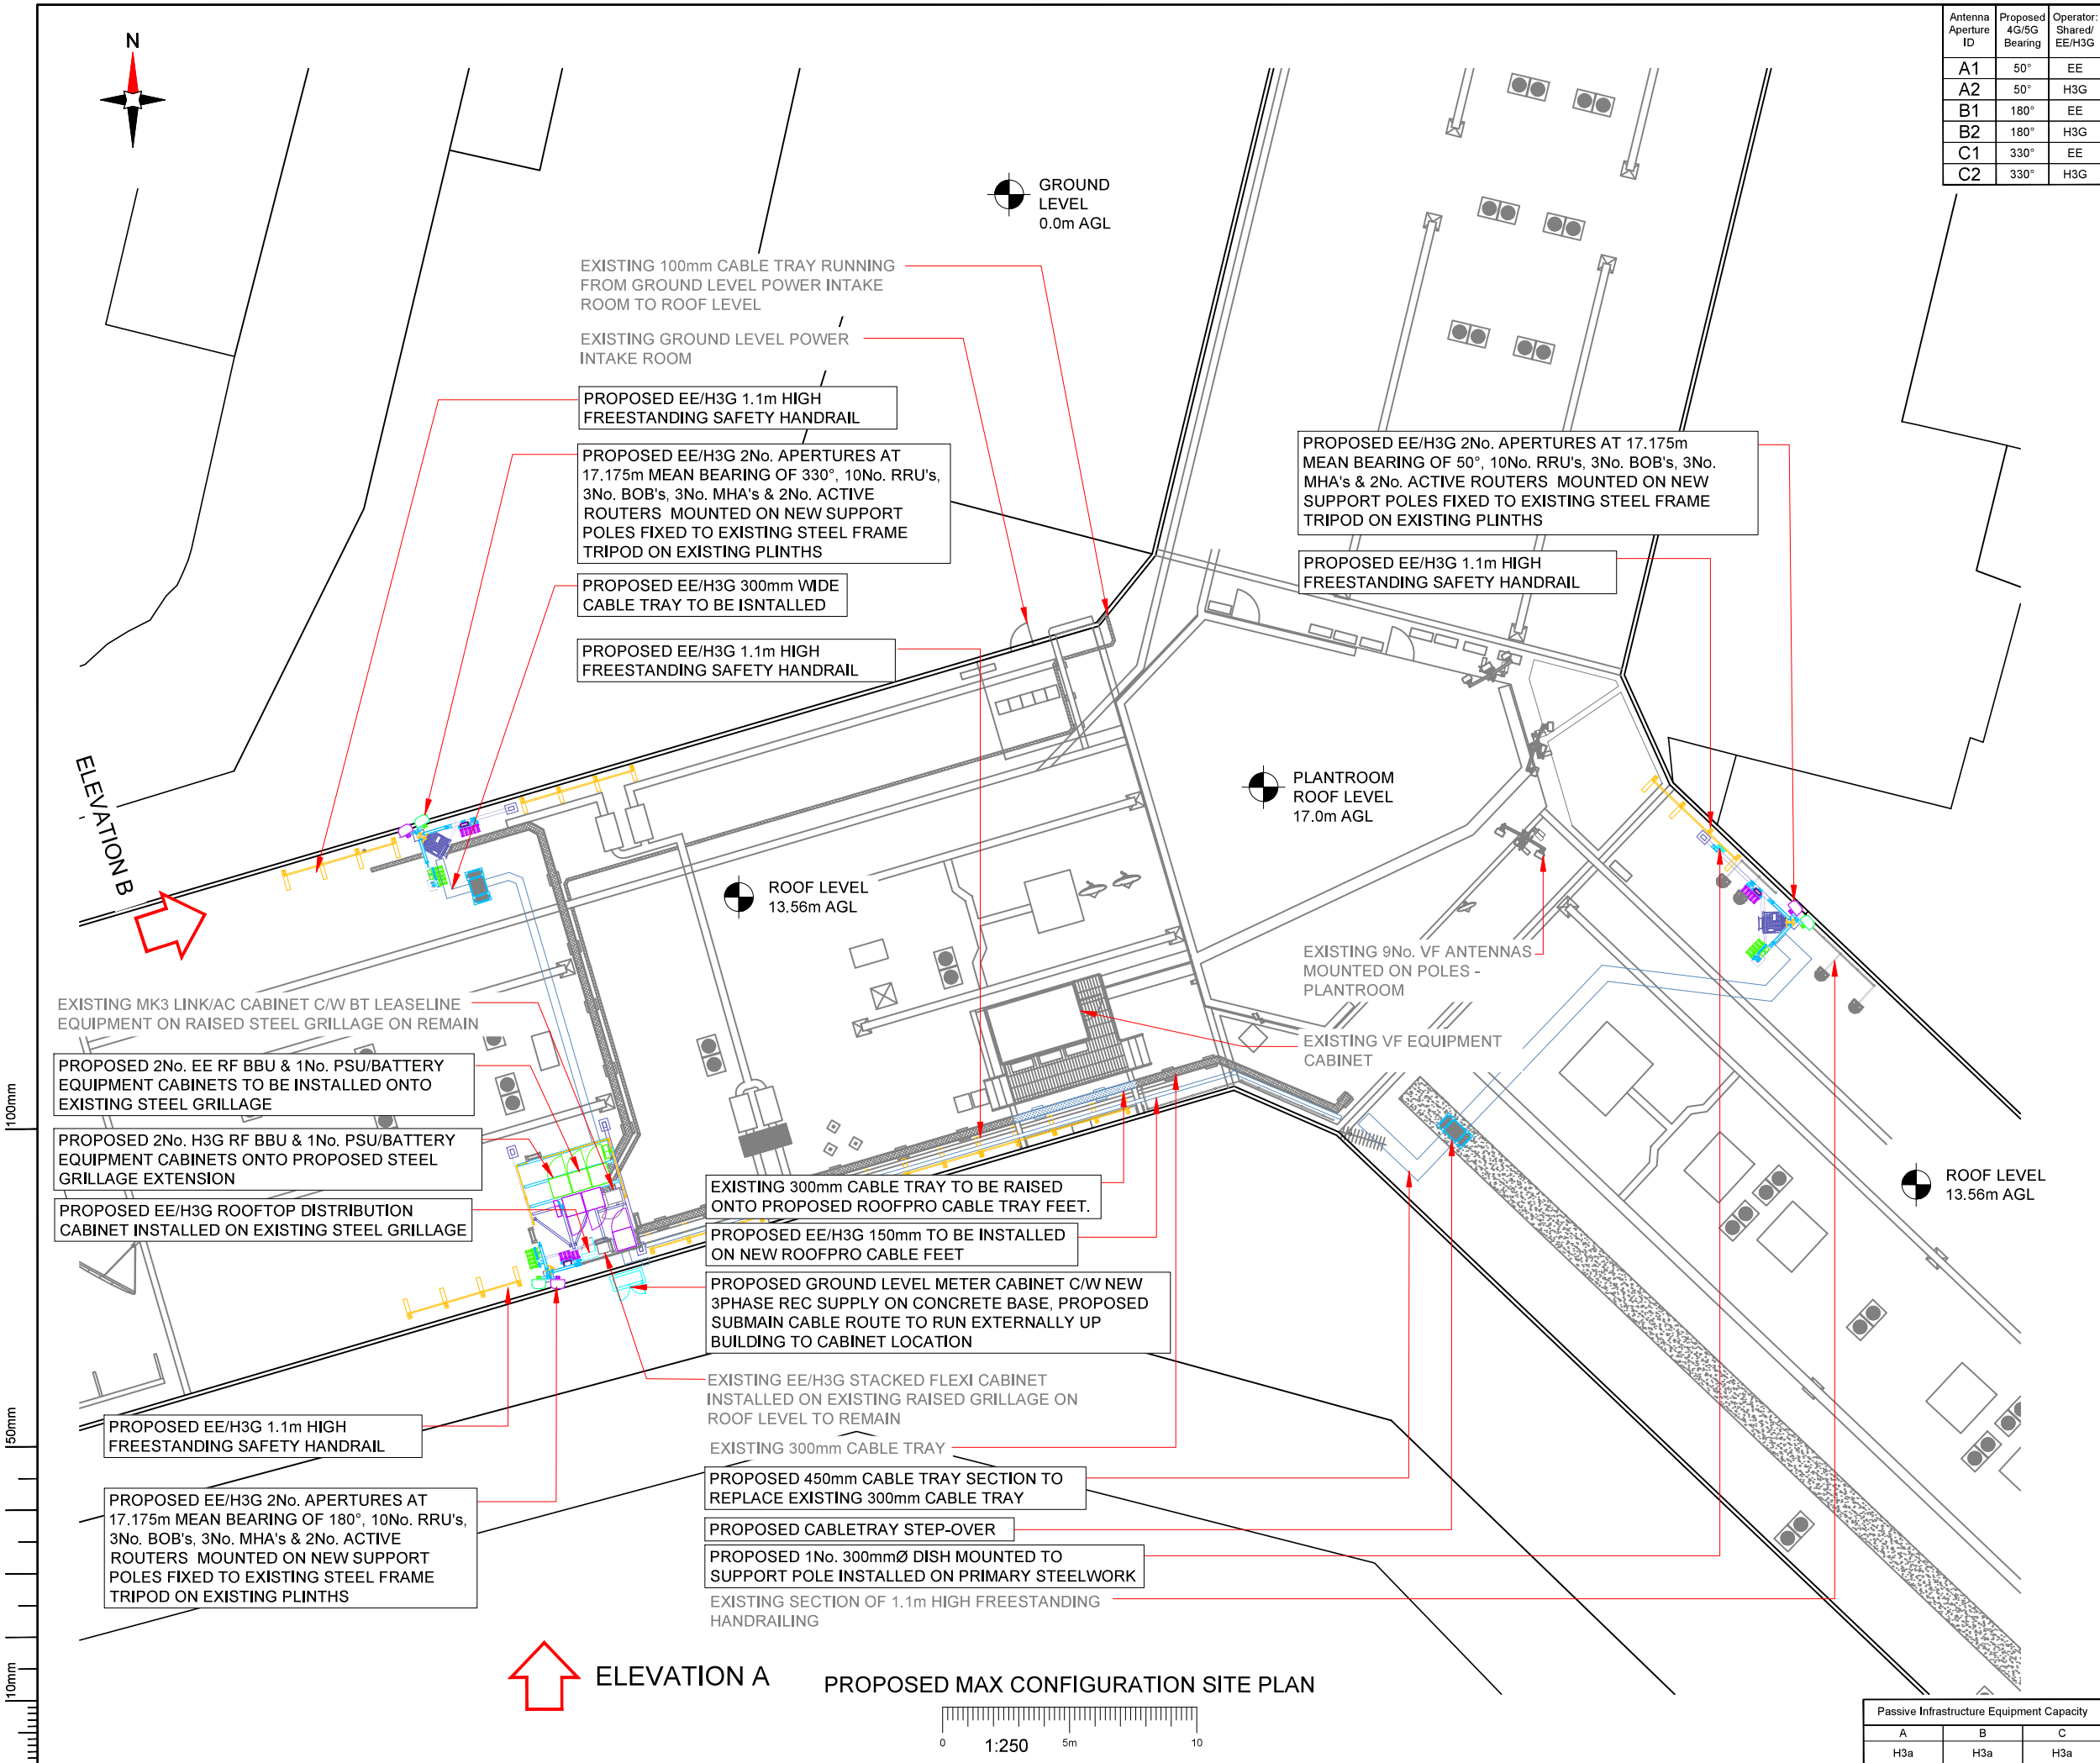

Antenna Aperture ID	Proposed 4G/5G Bearing	Operator: Shared/ EE/H3G
A1	50°	EE
A2	50°	H3G
B1	180°	EE
B2	180°	H3G
C1	330°	EE
C2	330°	H3G

NOTES:

1. ALL DIMENSIONS IN MM UNLESS OTHERWISE NOTED.

Master: M004	MBNL / EE / H3G	Project: T&A	Purpose of Issue: Planning	Issue: D
Date: 26/08/2021	Revision / Upgrade Description: Site Redesign to H3 solution			
Drawn: B. Jamieson				
Checked: J. Maguire				
Approved: C. Yates				
Master: M003	MBNL	Project: T&A	Purpose of Issue: Planning	Issue: C
Date: 20/07/2021	Revision / Upgrade Description: Site Redesign			
Drawn: B. Binding				
Checked: S. Tyndall				
Approved: C. Yates				
Master: M002	MBNL	Project: ATAP	Purpose of Issue: Planning	Issue: B
Date: 20/01/2020	Revision / Upgrade Description: Site amended & solution changed to H2a			
Drawn: ASE				
Checked: A. Spencer				
Approved: C. Yates				
Master: M001	MBNL	Project: ATAP	Purpose of Issue: Planning	Issue: A
Date: 11/01/2018	Revision / Upgrade Description: First Issue - Site nomination dated:			
Drawn: ASE				
Checked: C. Yates				
Approved: D. Pankhania				



Hutchison 3G UK Limited
Star House, 20 Grenfell Road
Maidenhead, SL0 1EH
Tel: 01628 769 000
Fax: 01628 769 001



Hatfield Business Park
Hatfield
Hertfordshire
AL10 9BW
Tel: 01707 315000
Fax: 01707 319001



Mobile Broadband Network Limited
Sixth Floor, Thames Tower, Station Road, Reading, RG1 1LX

Design Consultant & Principal Contractor:



A part of MGroup Services

WALDON TELECOM
PHOENIX HOUSE
PYRFORD ROAD
WEST BYFLEET
SURREY
KT14 6RA
TEL : 01932 411011
FAX : 01932 411012

Site Name:	CROWN PLAZA HEATHROW		
Site ID:	1005868		
Address:	CROWNE PLAZA HEATHROW STOCKLEY ROAD WEST DRAYTON HILLINGDON LONDON UB7 9NA		
Title:	215 MAX CONFIGURATION SITE PLAN		
Project:	T&A		
Purpose of Issue:	GENERAL ARRANGEMENT		
EE Cell ID:	50674	MBNL Cell ID:	HGN002
3UK Cell ID:	UB0123		
Master Drawing No:	1005868_HGN002_50674_UB0123_M004		Issue:
			D

Passive Infrastructure Equipment Capacity		
A	B	C
H3a	H3a	H3a