



KEY:

7Kw Electric Vehicle Charging Point

Provision for future EVCP Infrastructure

Provision for future EVCP Infrastructure

Provision for a free-standing vertical rack system capable of accommodating up to 10 bicycles.

1no. Zappi 7kW/22kW Tethered EV Charger

PROPOSED GROUND FLOOR PLAN
1:50@A1

BRL DESIGN GROUP LTD


 
Office 17, Creykes Court, The Millfields, Plymouth, PL1 3JB

info@brldesign.co.uk

www.brldesign.co.uk

01752 963147

1:50

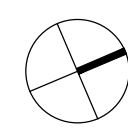

Project number: 9015

Project name: Quba Masjid Nursery

Client: Quba Masjid & Education Centre

Drawn by: TY

Dwg No:9015N-A-DR-00-1028 A

Date: August 25

Detail: PROPOSED EVCP AND CYCLE STORE

Status: PLANNING

Checked by: CP

Scale: 1:50 A1