



Plan
Ground Floor

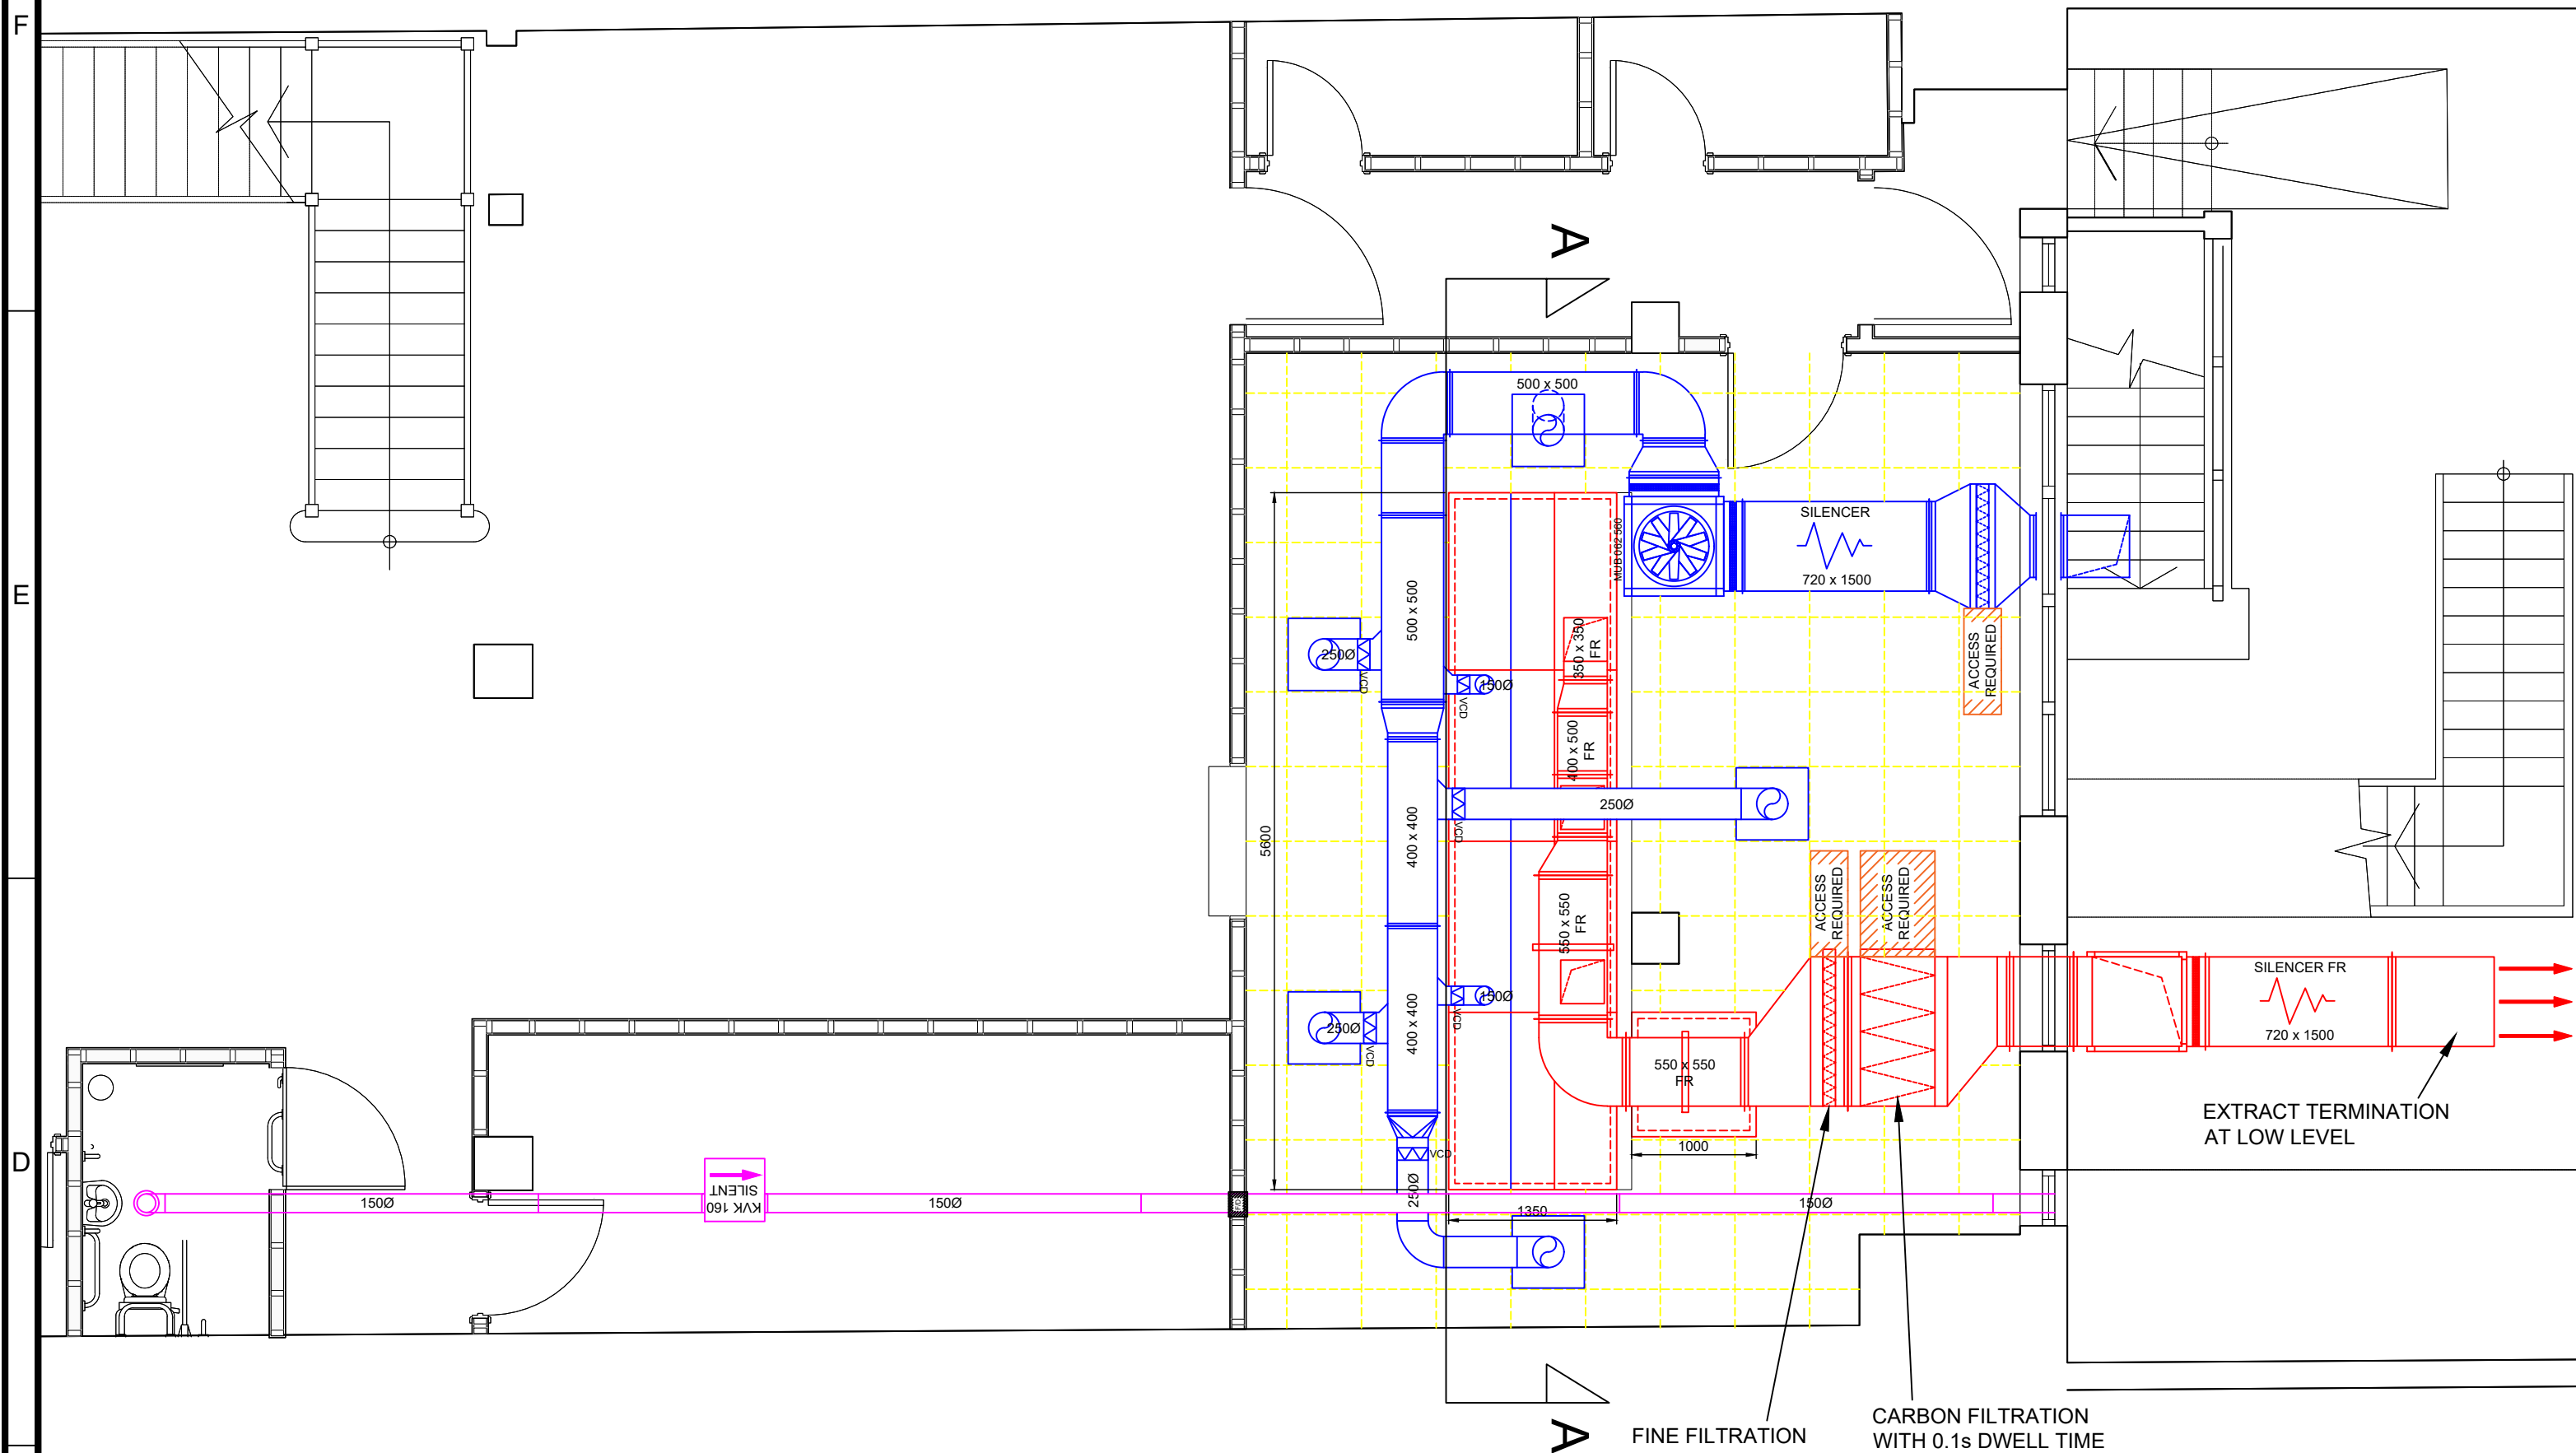

Rear Elevation

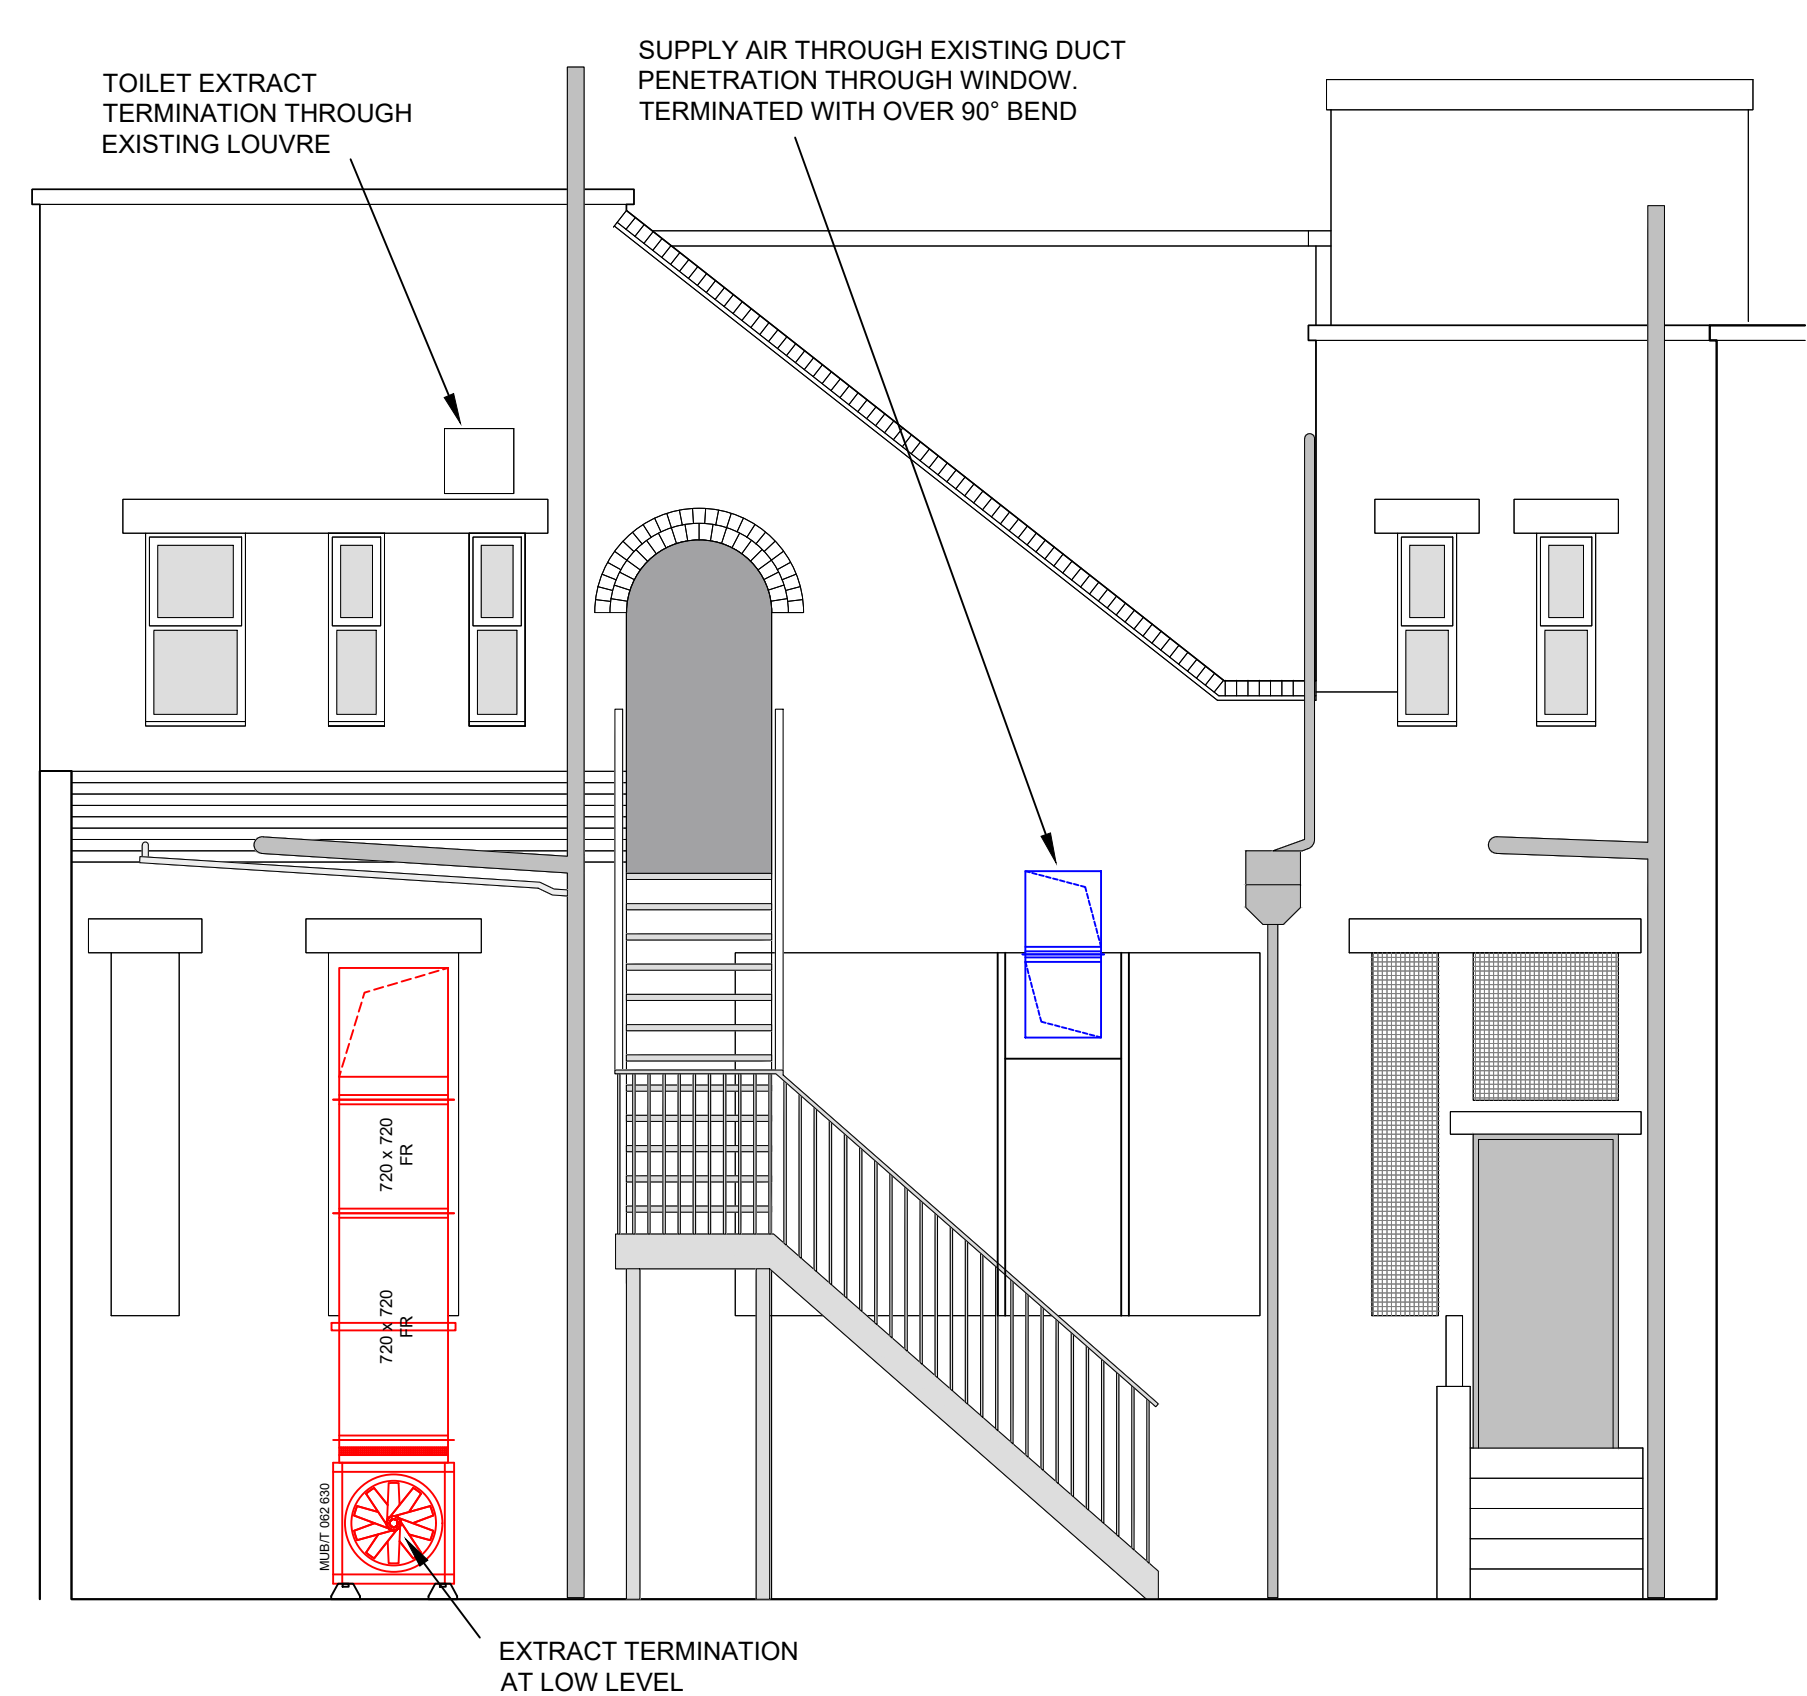

FOR APPROVAL

DO NOT SCALE FROM THIS DRAWING!
ALL MEASUREMENTS IN MILLIMETERS
GENERAL TOLERANCE +/- 1mm.
ALL POWER & SERVICES INSTALLATION BY
CLIENT AND/OR M&E CONTRACTOR.

Kitchen extract
Kitchen supply
Ceiling grid
Toilet extract

FAN INFORMATION
Extract fan: MUB/T 062 630
Start current: 60.9 amps 3PH
Sound level: 58 dB @ 3m
Supply fan: MUB 062 560
Start current: 32.4 amps 3PH
Sound level: 56 dB @ 3m

Approximate canopy weight: 300kg

Drawing to be used in conjunction with
Architect: Richard Pedlar LNG4535.10/11
Kitchen:

REVISIONS:

REV	DATE	NOTES

Client:

Loungers

Project:

Ruislip Lounge
81-83 High Street
HA4 7AB

Scale:	1:50 @ A1
Date:	04/01/2021
Drawn by:	CH
Drawing number:	
Revision:	


Partridge Ventilation
"a breath of fresh air"
Cardrew Industrial Estate, Redruth, Cornwall TR15 1SH
01209 204700
enquiries@partridge-ventilation.co.uk

I hereby confirm my acceptance of all information
on this drawing and understand that any subsequent
changes to this plan may be subject to additional charges


Customers Signature: .

Date: .

Plan
First Floor

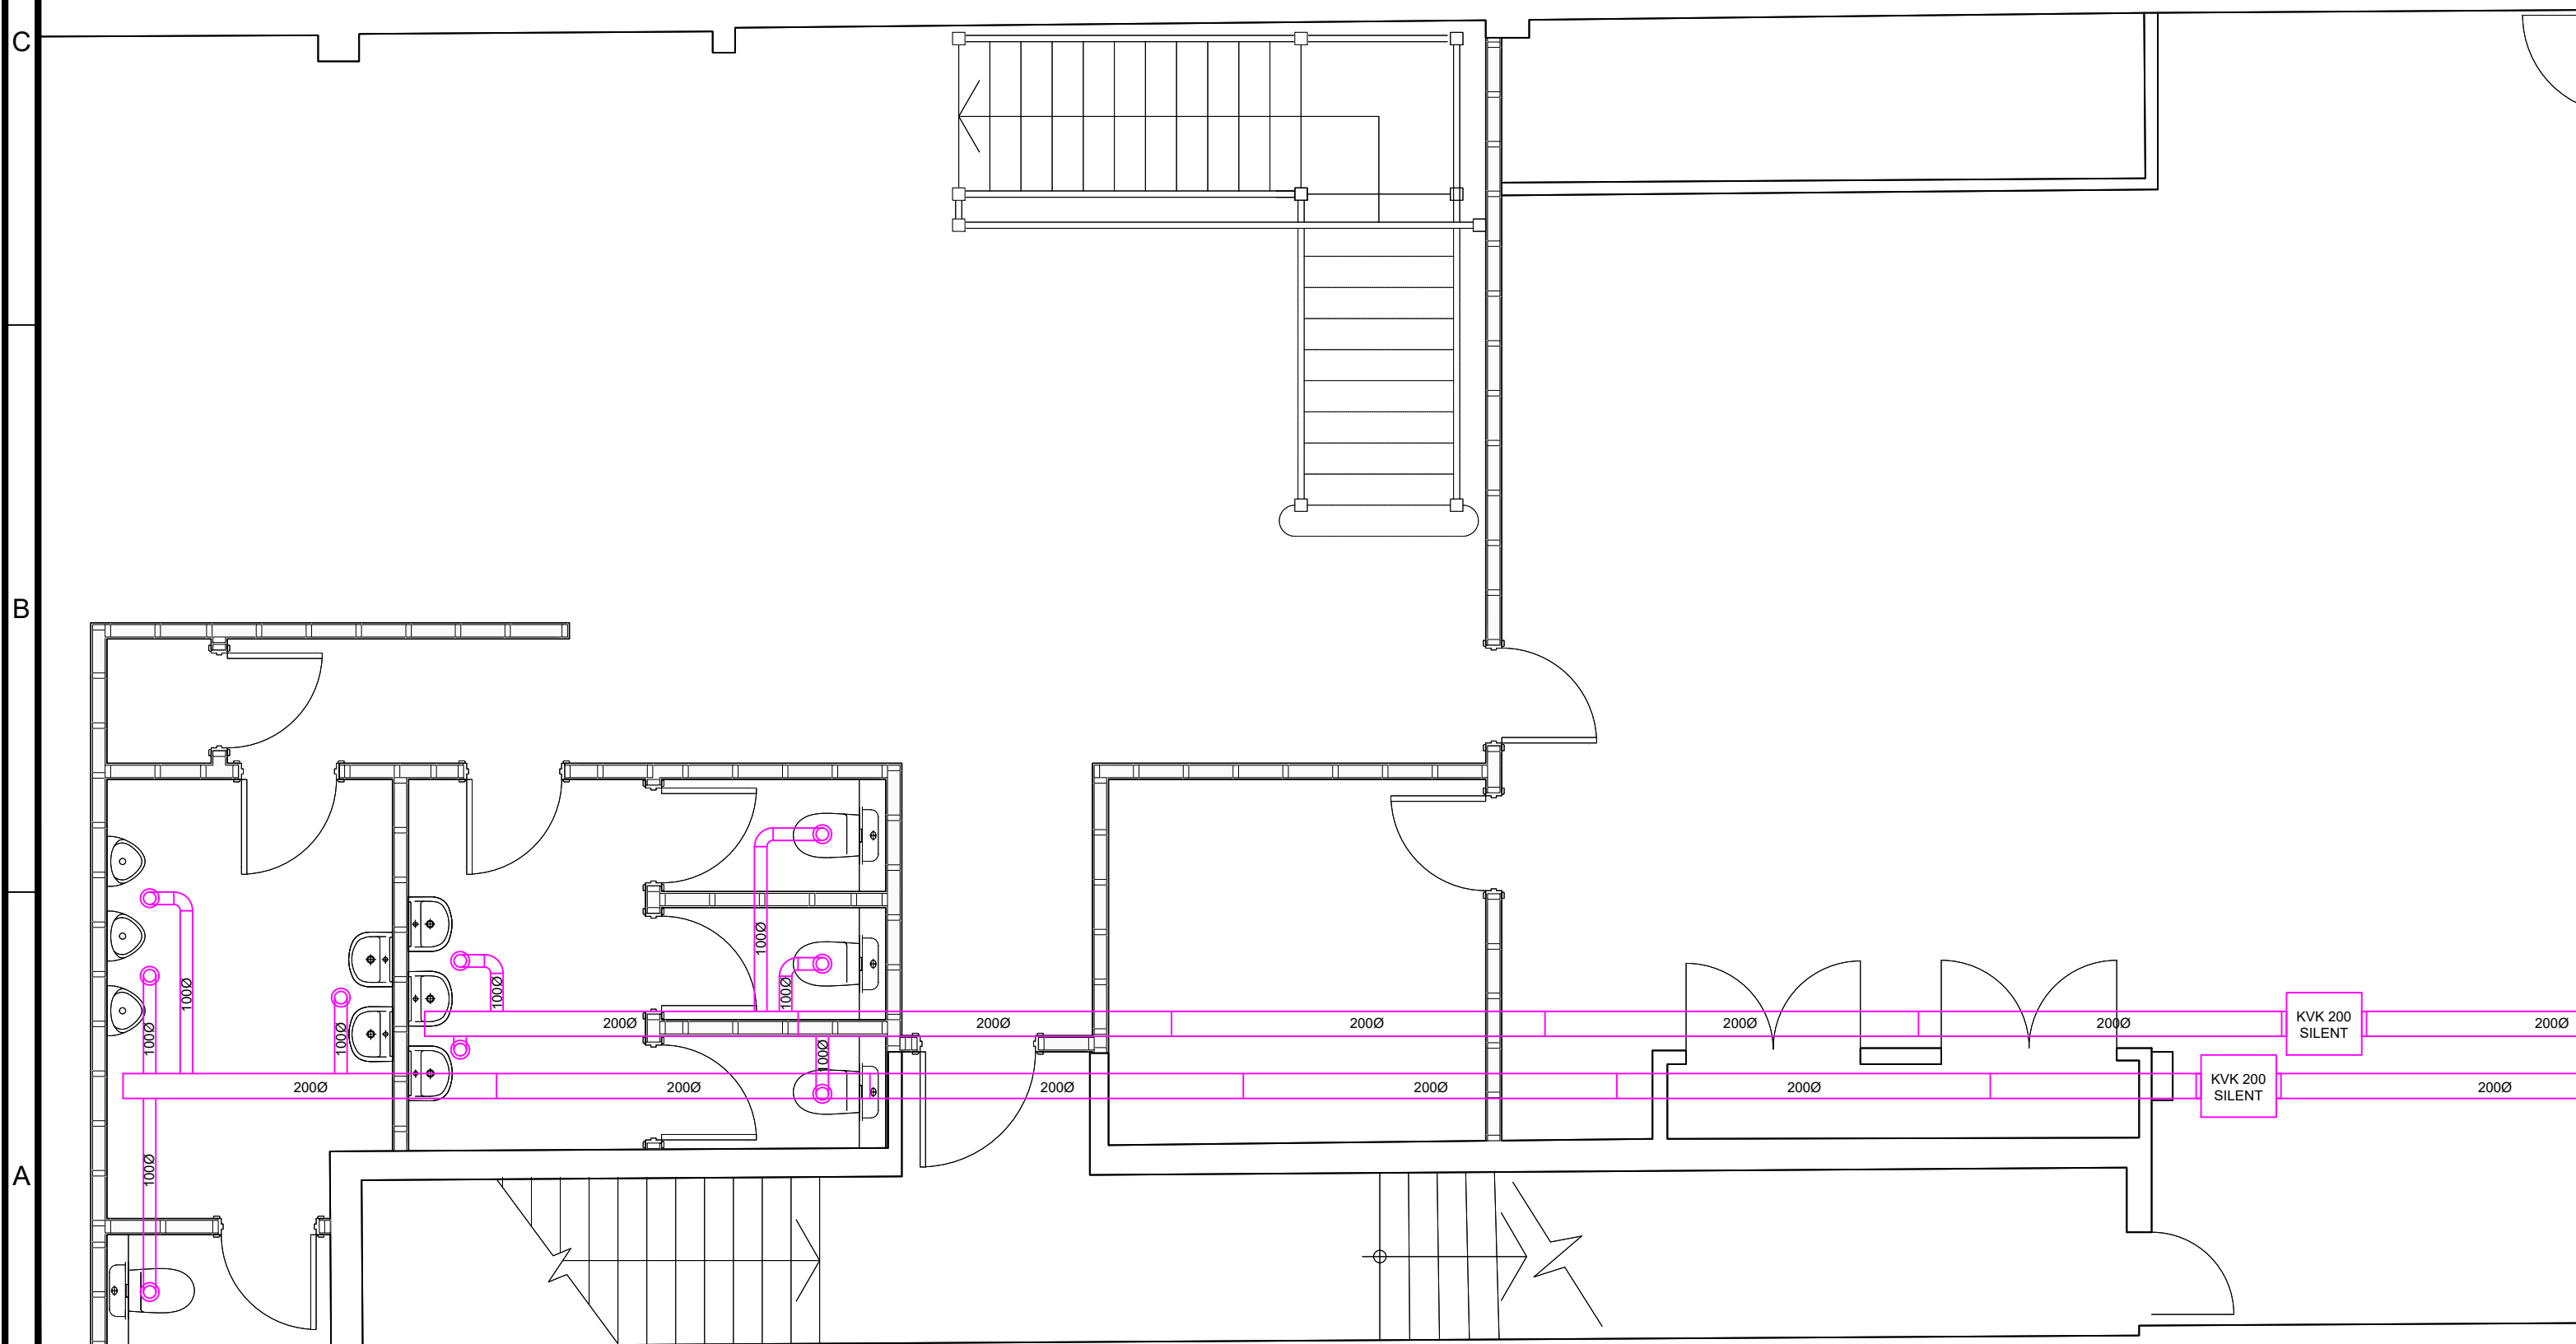

Section A-A

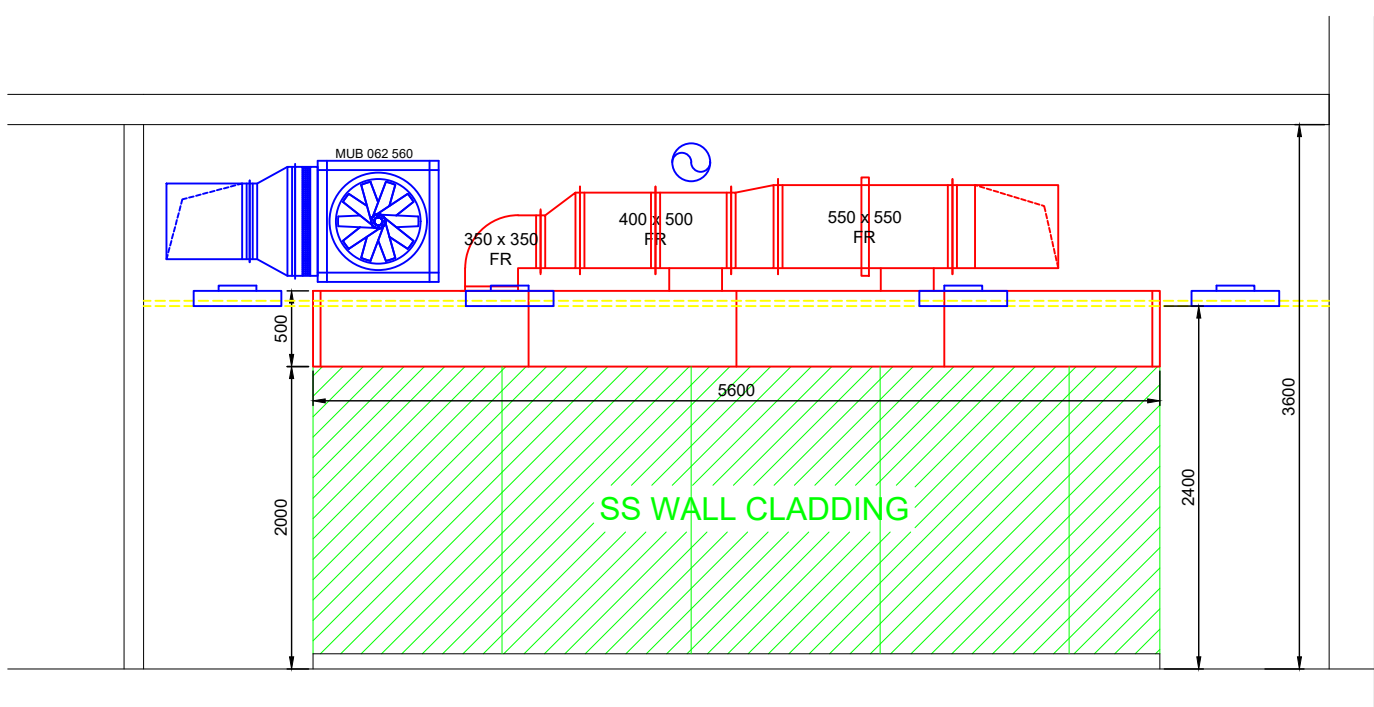

TOILET EXTRACT
TERMINATION THROUGH
EXISTING LOUVRE