


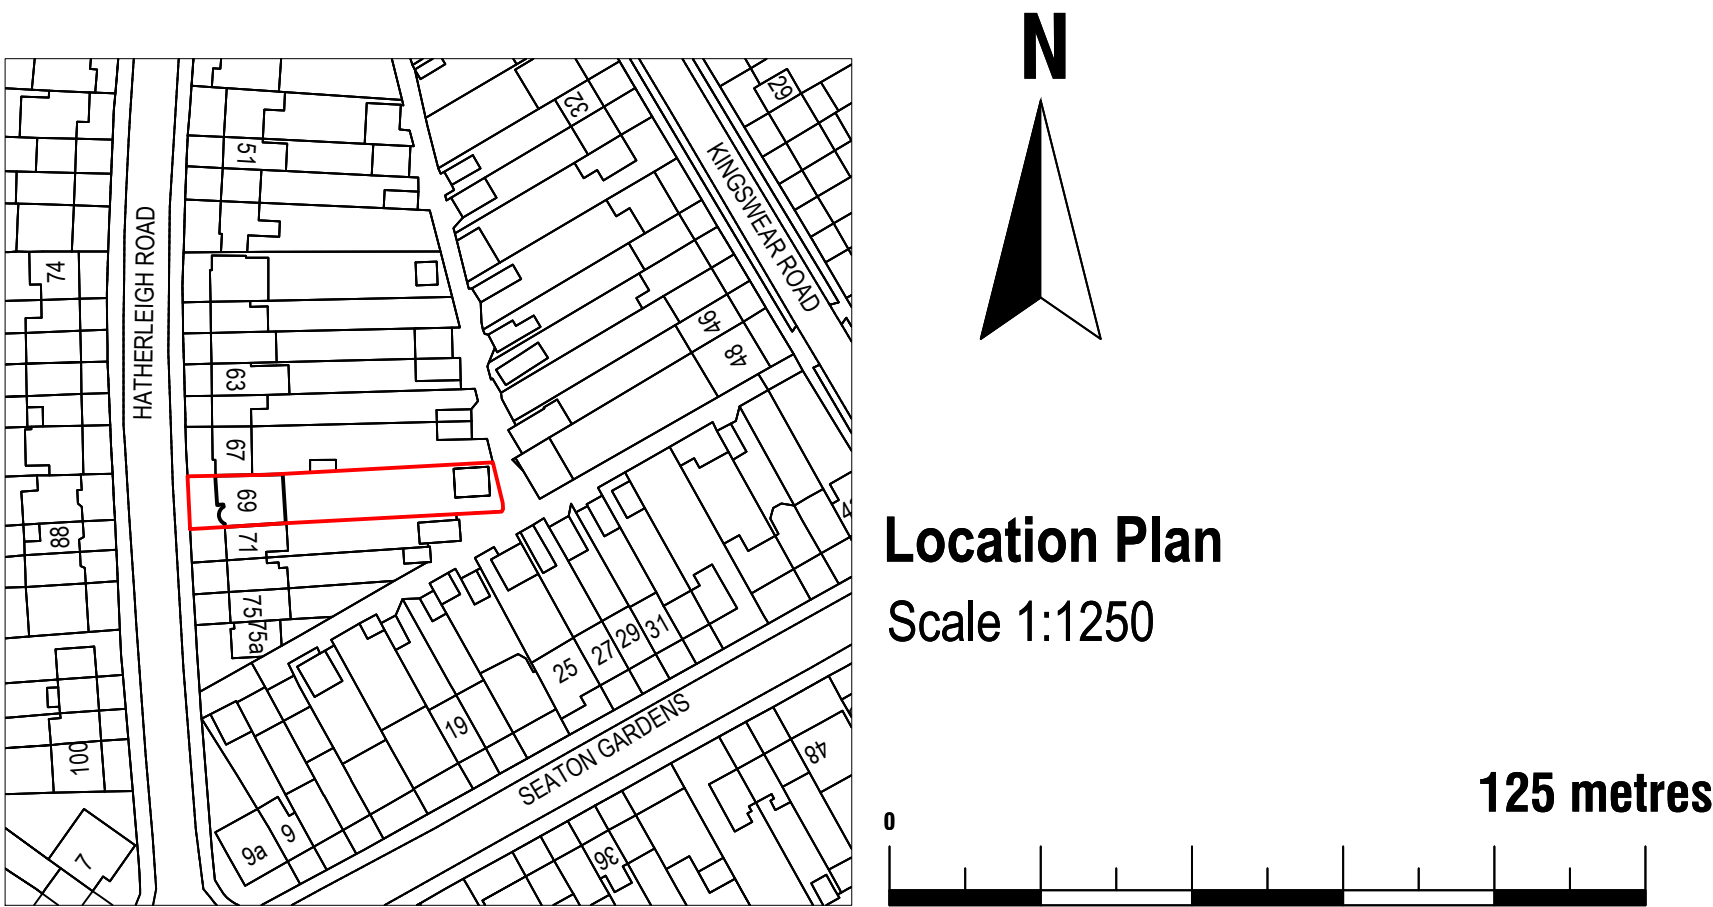

Note to Contractor: Contractor is recommended to carry out an intrusive site investigation prior to commencing works on site to ensure all details designed for this project are appropriate. Contractor to cross reference with Structural Calculations package for suitability, to assess site levels and confirm any design assumptions within the calculations package prior to works commencing on site. If the Contractor requires any additional information, please send a Request For Information to hello@planituk.co.uk before ordering materials and starting the works - requests will be acknowledged and responded to as soon as possible. Please ensure that the drawings have been submitted to Building Control for a Full Plans submission and the compliance report has been discharged before starting works on site. All dimensions must be checked and verified on site by the contractor prior to the commencement of any works. Any discrepancies or variations must be reported to Plan It UK immediately. Drain location is an estimated location, contractor to investigate on site and allow a time and cost contingency for adjustments to drainage if required.

Drawn by:
FD

Title Number
MX22195

Project:
69 Hatherleigh Road, HA4 6AX

Date:
17.07.2026

No.:
26-0899


Rev:
01

Page:
001





Client:
Kieran Murphy

Drawing Title:
EXISTING BLOCK PLAN
PROPOSED BLOCK PLAN, LOCATION PLAN

Scale:
1:500, 1:1250 @A1, 1:1000,
1:2500 @A3

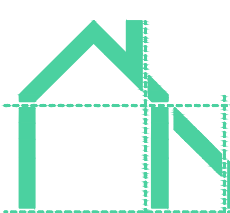 **Plan It UK**
Architectural Services
7 Leigh House, Bexleyheath, DA7 4QP
Enquiries@planituk.co.uk
Engineer: se@planituk.co.uk

EXISTING

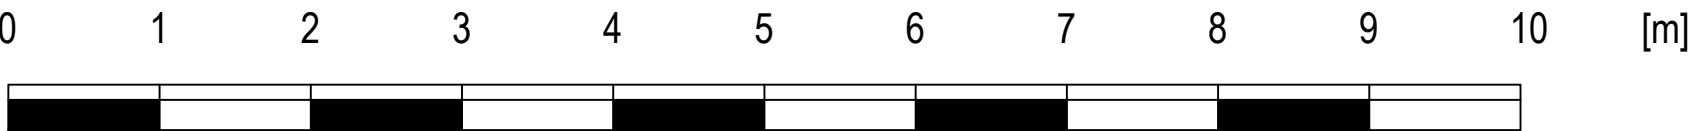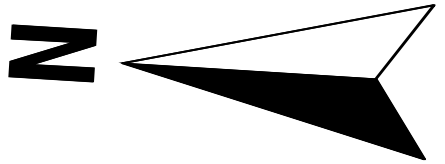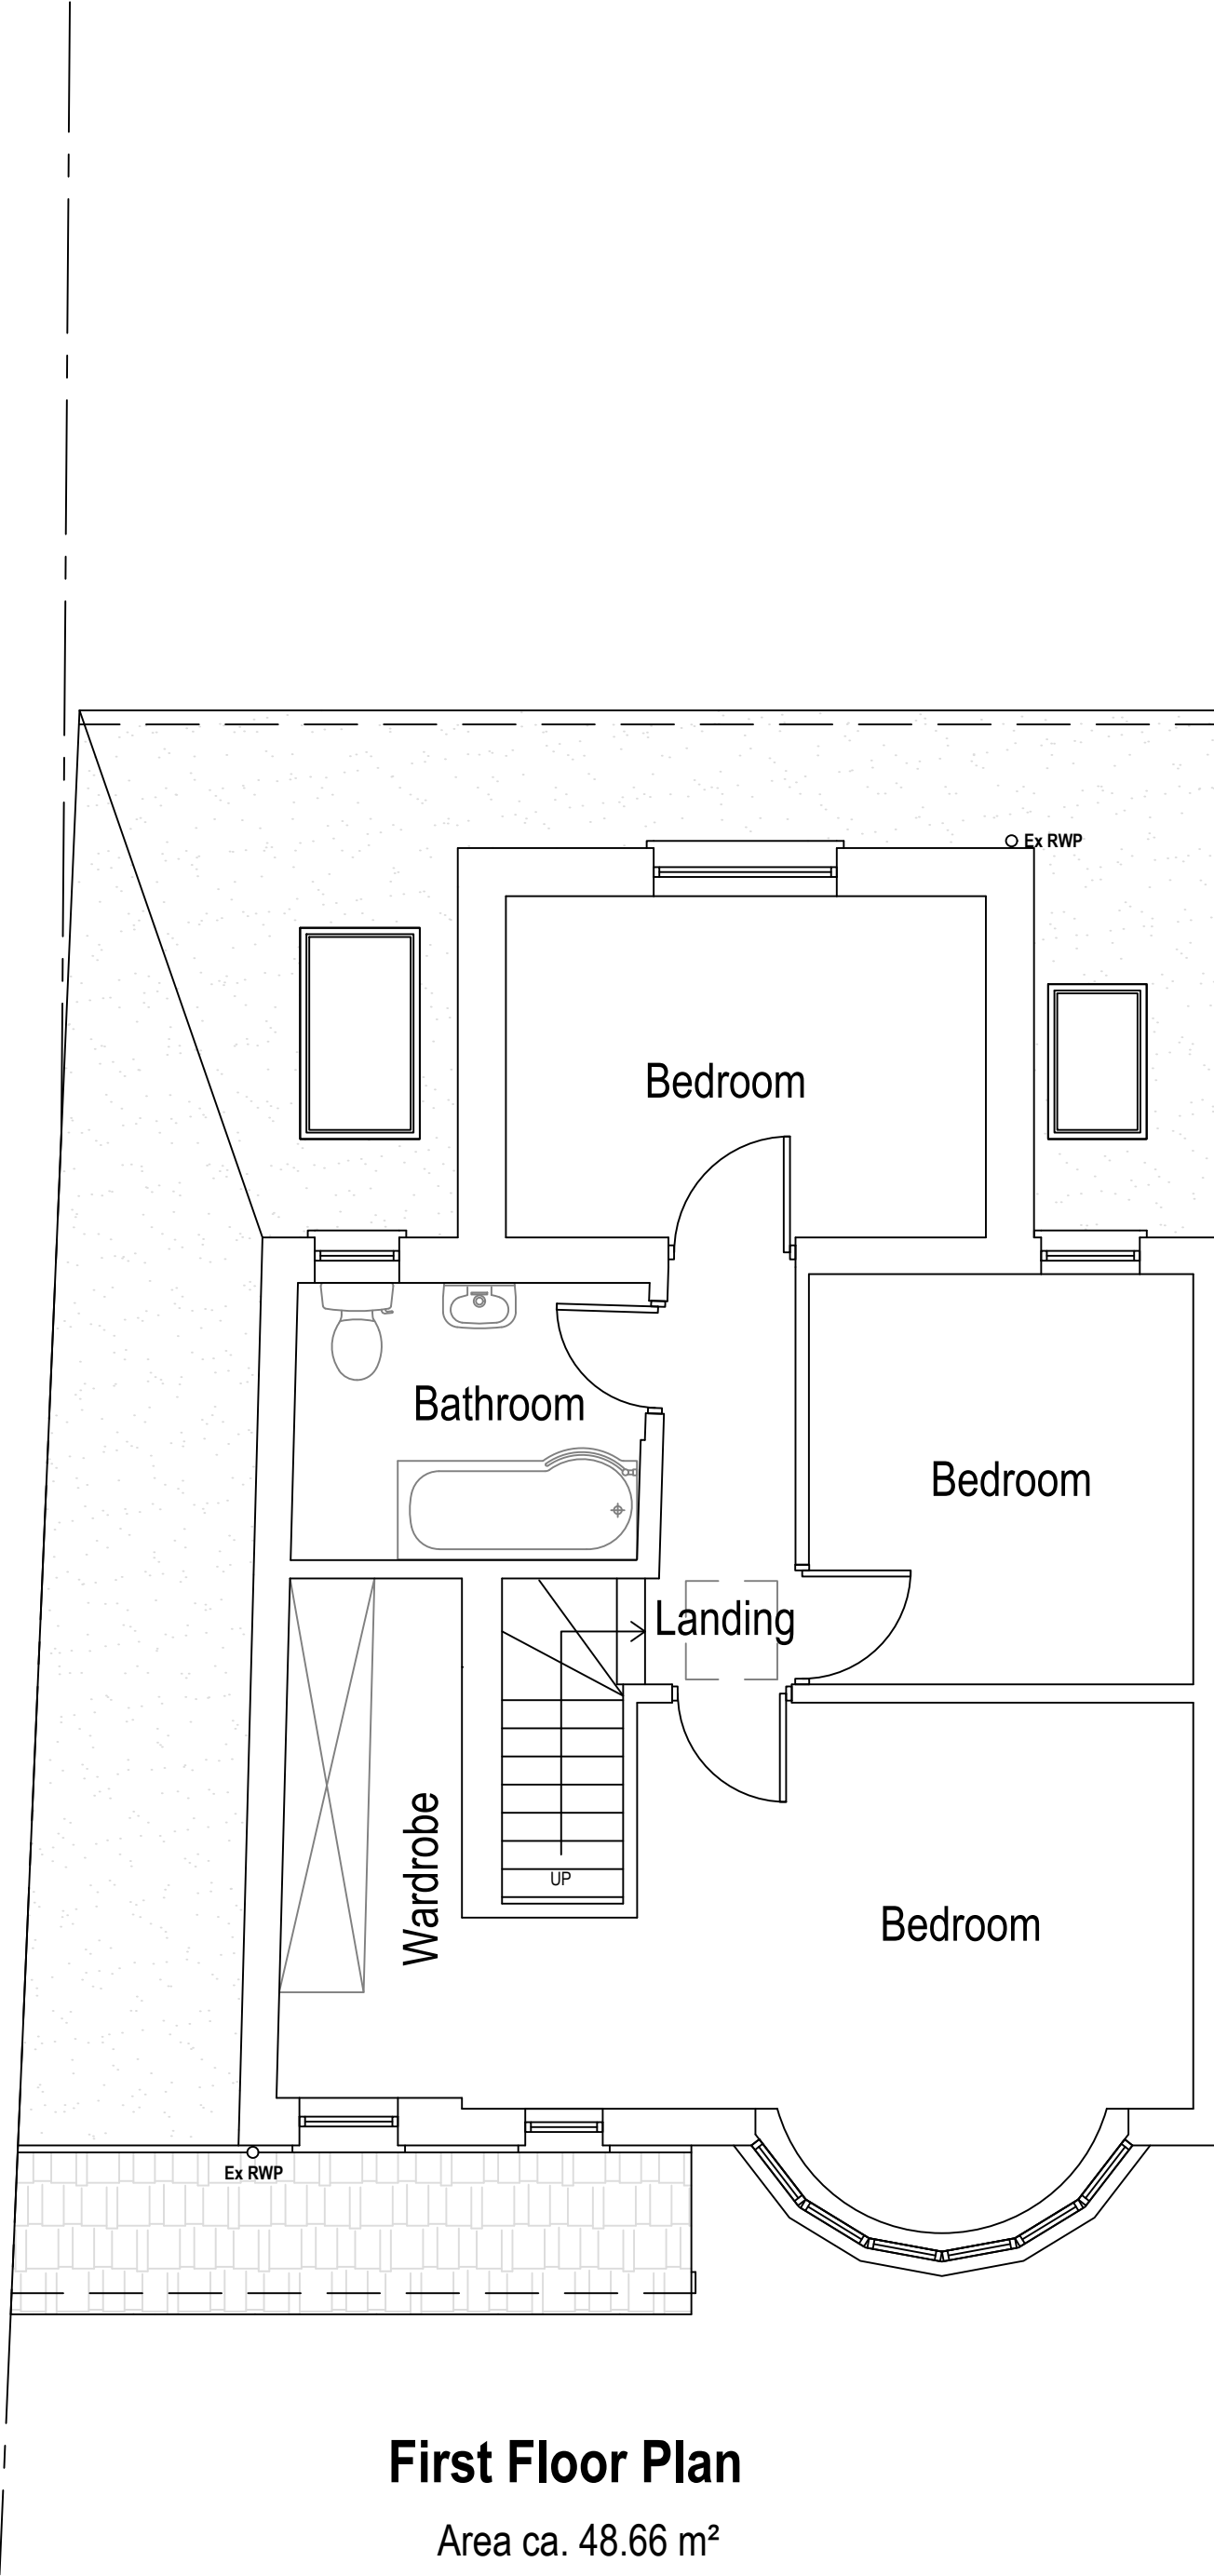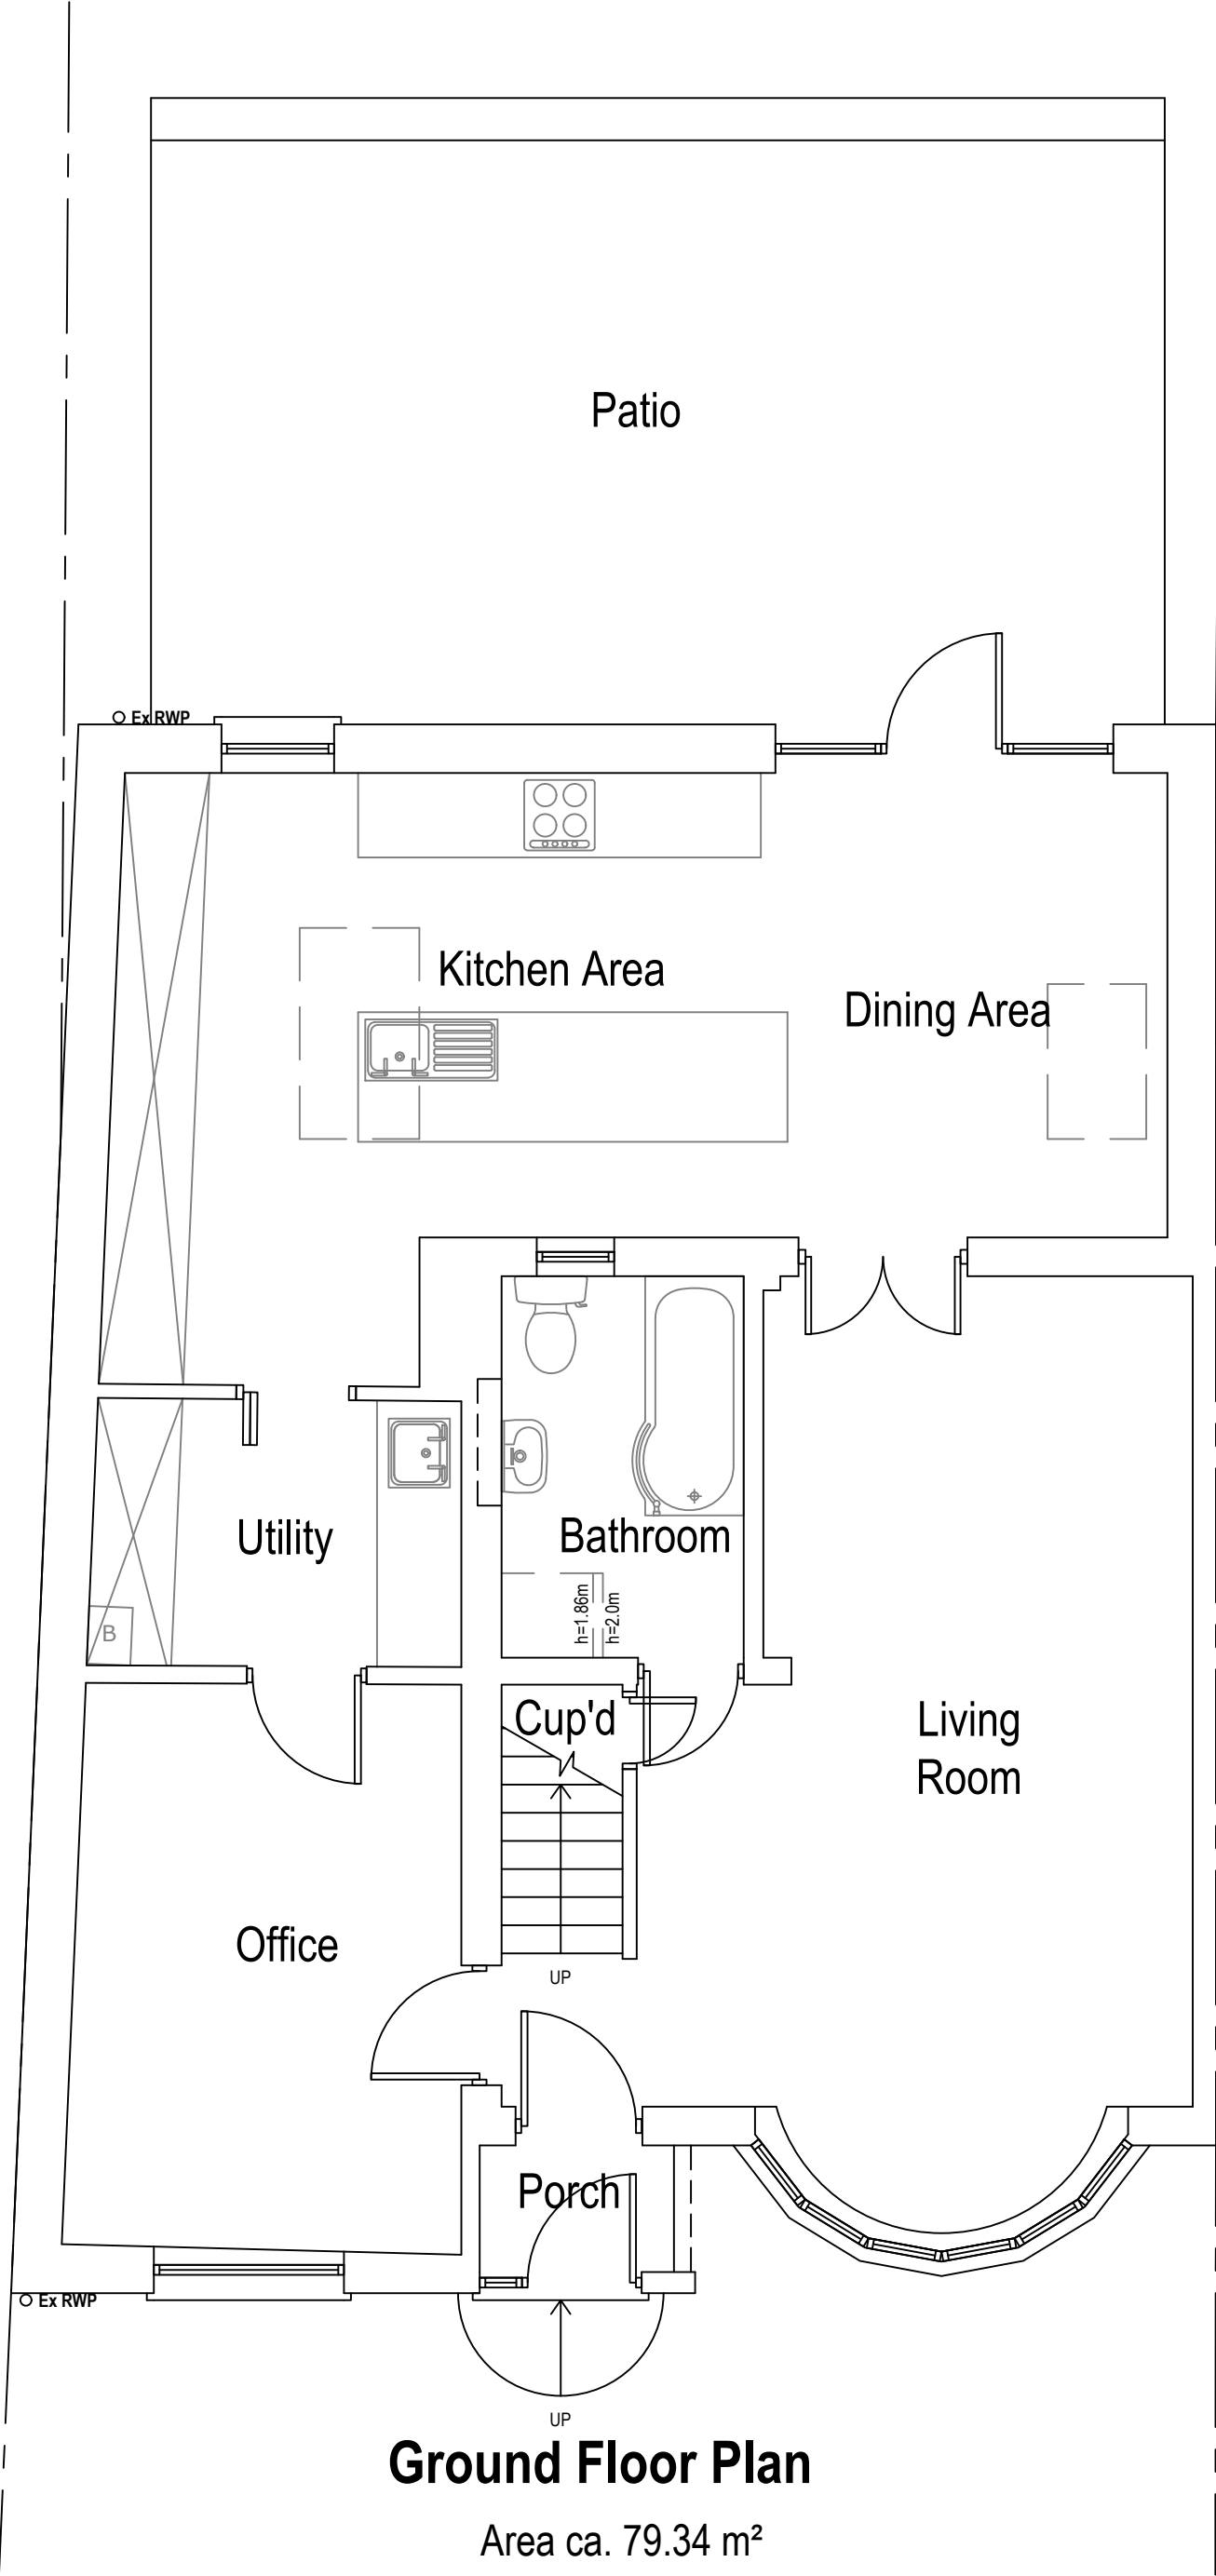

Note to Contractor: Contractor is recommended to carry out an intrusive site investigation prior to commencing works on site to ensure all details designed for this project are appropriate. Contractor to cross reference with Structural Calculations package for suitability, to assess site levels and confirm any design assumptions within the calculations package prior to works commencing on site. If the Contractor requires any additional information, please send a Request For Information to hello@planituk.co.uk before ordering materials and starting the works - requests will be acknowledged and responded to as soon as possible. Please ensure that the drawings have been submitted to Building Control for a Full Plans submission and the compliance report has been discharged before starting works on site. All dimensions must be checked and verified on site by the contractor prior to the commencement of any works. Any discrepancies or variations must be reported to Plan It UK immediately. Drain location is an estimated location, contractor to investigate on site and allow a time and cost contingency for adjustments to drainage if required.

Drawn by:
FD

Title Number
MX22195

Project:
69 Hatherleigh Road, HA4 6AX

Date:
17.07.2026

No.:
26-0899

Rev:
01

Page:
D02

Client:
Kieran Murphy



Drawing Title:
EXISTING PLANS

Scale:
1:50 @A1, 1:100 @A3



7 Leigh House, Bexleyheath, DA7 4QP
Enquiries@planituk.co.uk
Engineer: se@planituk.co.uk


PROPOSED

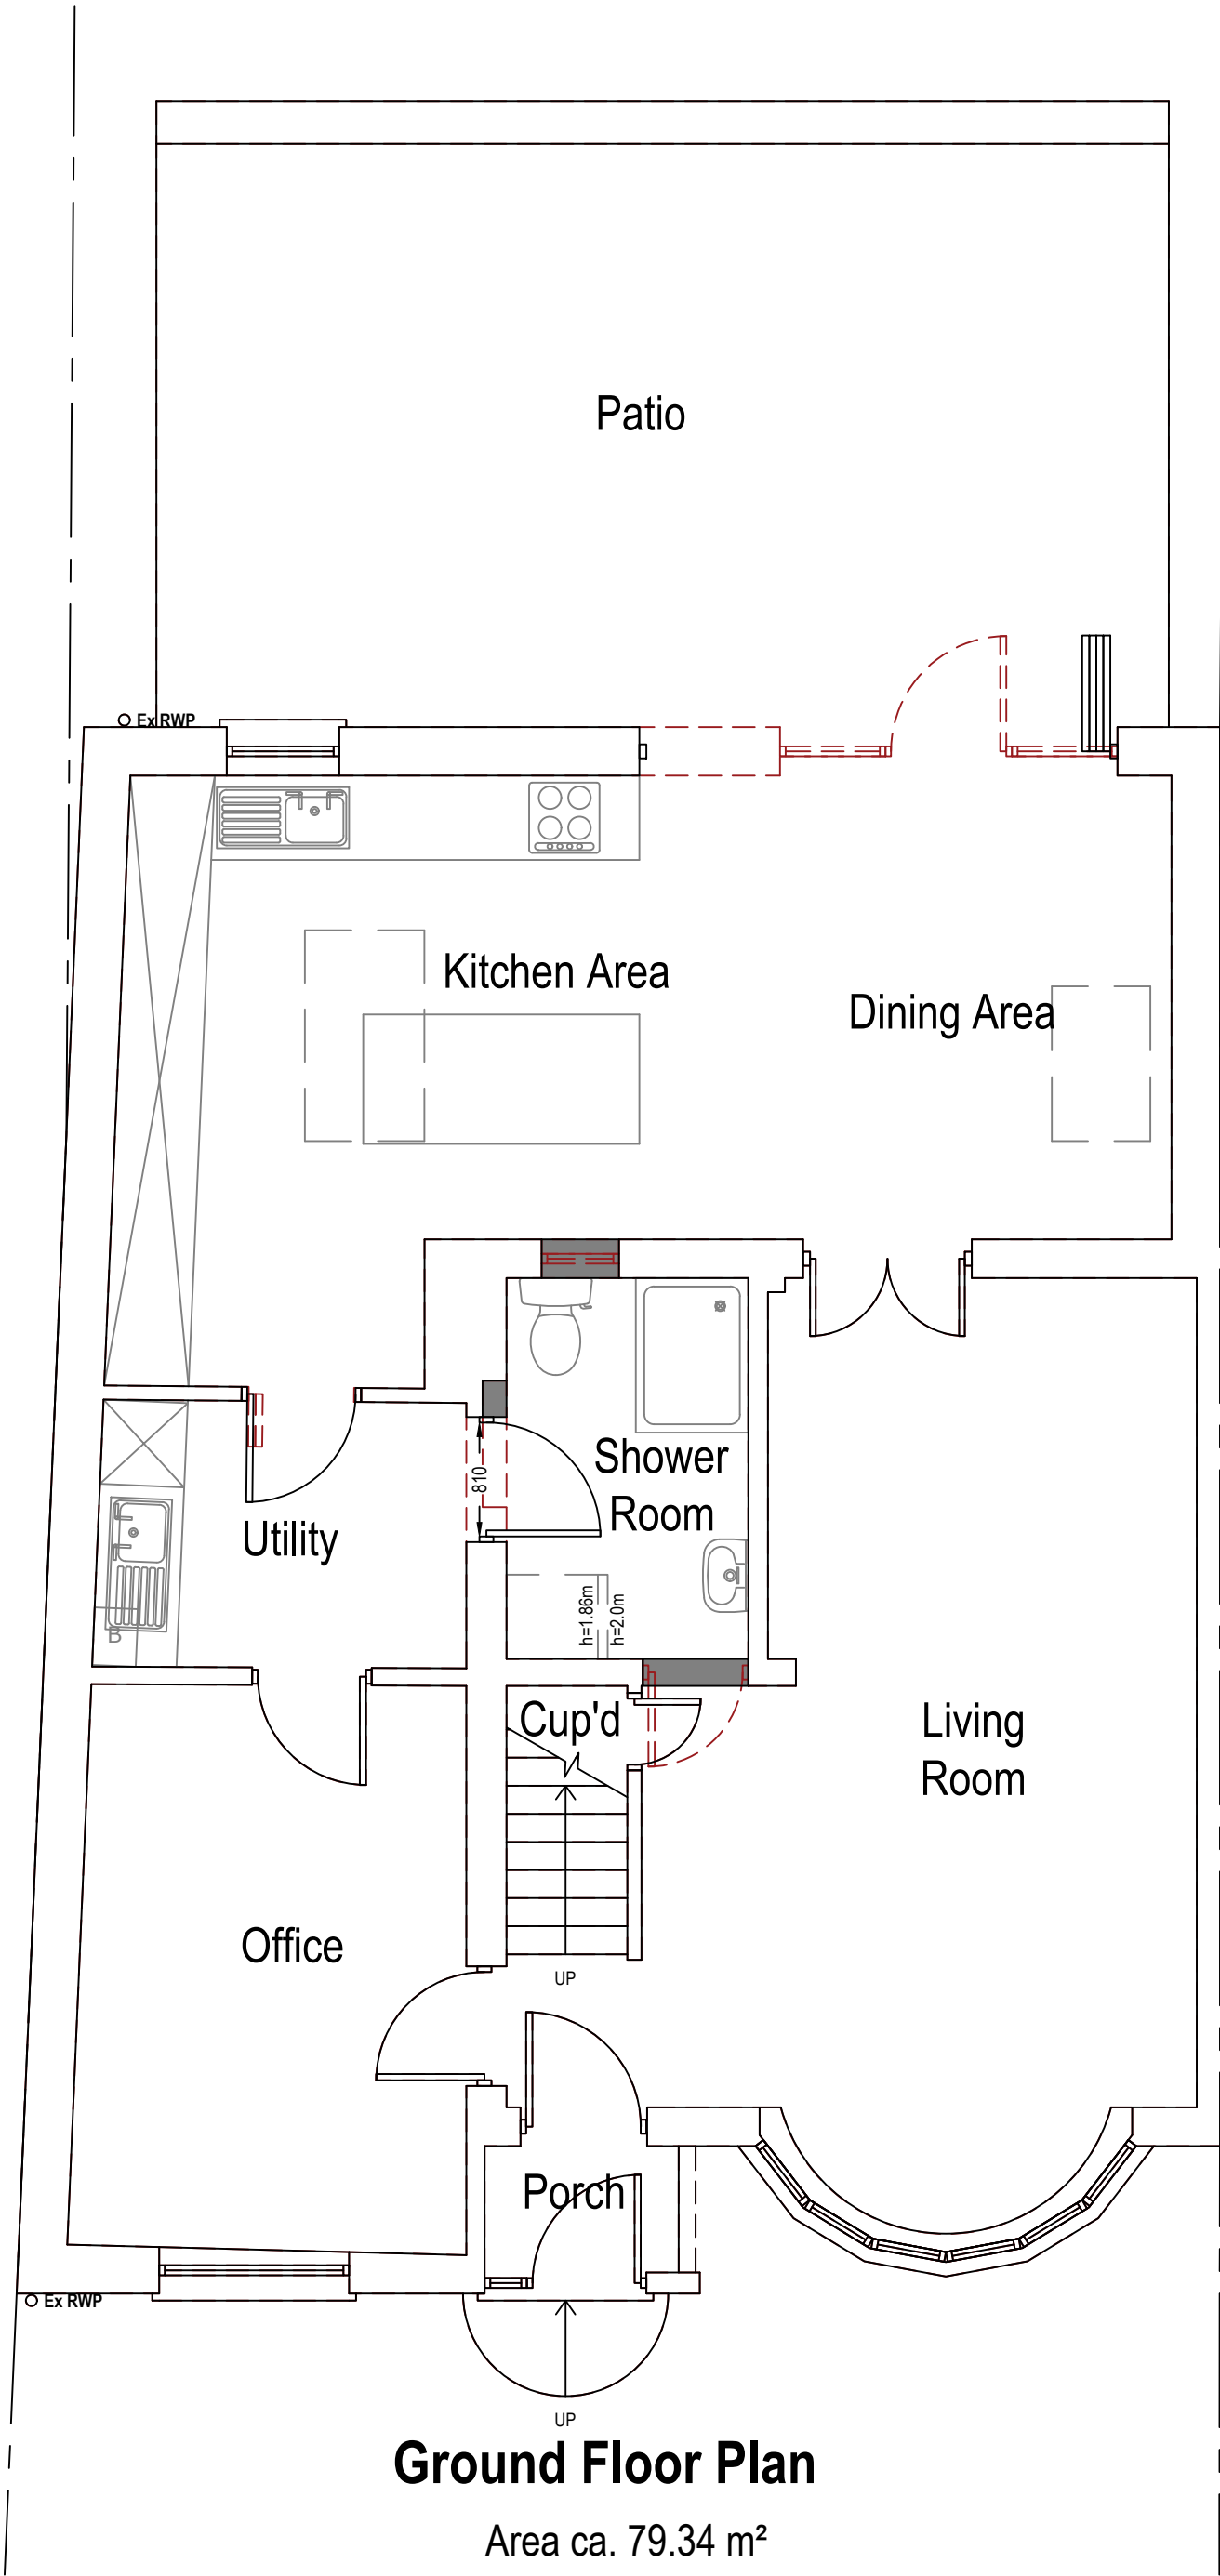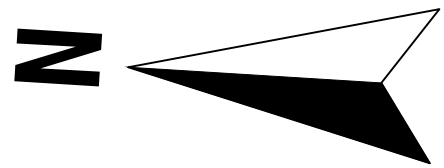

Ground Floor Plan

Area ca. 79.34 m²

Additional Area: 0.00 m²

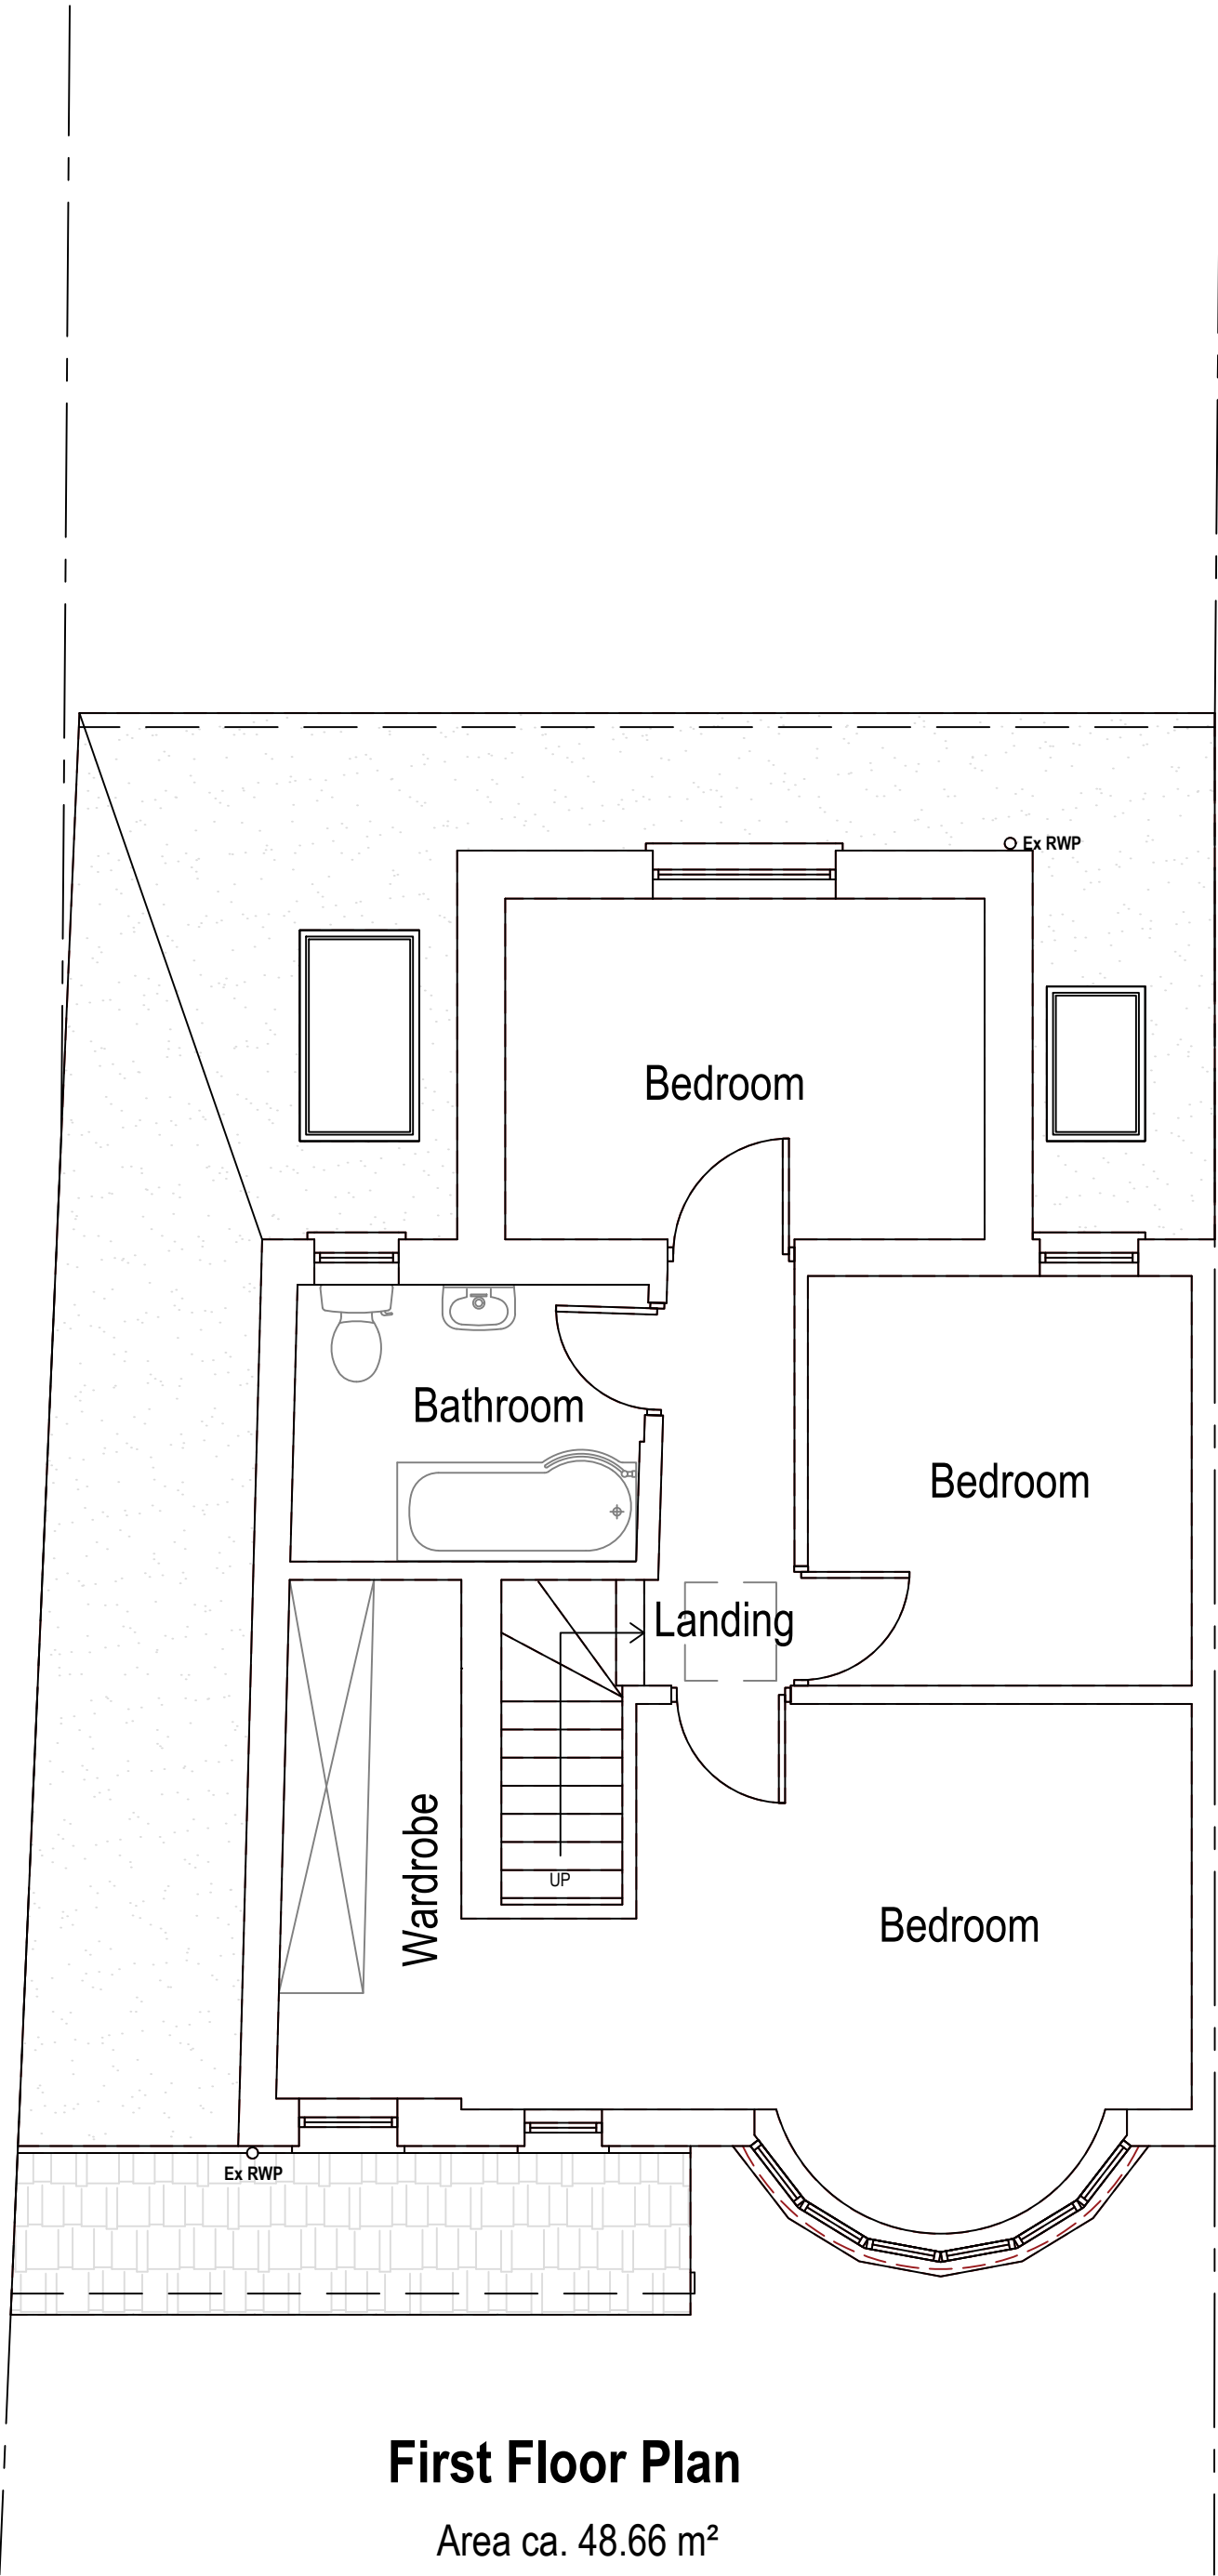

First Floor Plan


Area ca. 48.66 m²

Additional Area: 0.00 m²

Symbol Key:

- Proposed wall
- Boundary line
- Details above
- Waste drainage layout
- Demolished
- Rainwater layout

Proposed Materials:
All new drainage to match material of existing drainage

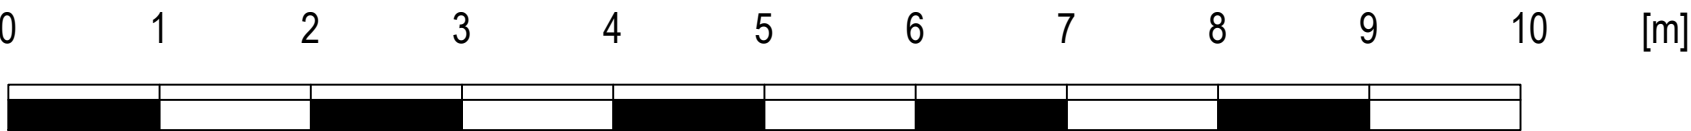

Note to Contractor: Contractor is recommended to carry out an intrusive site investigation prior to commencing works on site to ensure all details designed for this project are appropriate. Contractor to cross reference with Structural Calculations package for suitability, to assess site levels and confirm any design assumptions within the calculations package prior to works commencing on site. If the Contractor requires any additional information, please send a Request For Information to hello@planituk.co.uk before ordering materials and starting the works - requests will be acknowledged and responded to as soon as possible. Please ensure that the drawings have been submitted to Building Control for a Full Plans submission and the compliance report has been discharged before starting works on site. All dimensions must be checked and verified on site by the contractor prior to the commencement of any works. Any discrepancies or variations must be reported to Plan It UK immediately. Drain location is an estimated location, contractor to investigate on site and allow a time and cost contingency for adjustments to drainage if required.

Drawn by:
FD

Title Number
MX22195

Project:
69 Hatherleigh Road, HA4 6AX

Date:
17.07.2026

No.:
26-0899

Rev:
01

Page:
D03

Client:
Kieran Murphy



Drawing Title:
PROPOSED PLANS

Scale:
1:50 @A1, 1:100 @A3




7 Leigh House, Bexleyheath, DA7 4QP
Enquiries@planituk.co.uk
Engineer: se@planituk.co.uk

EXISTING

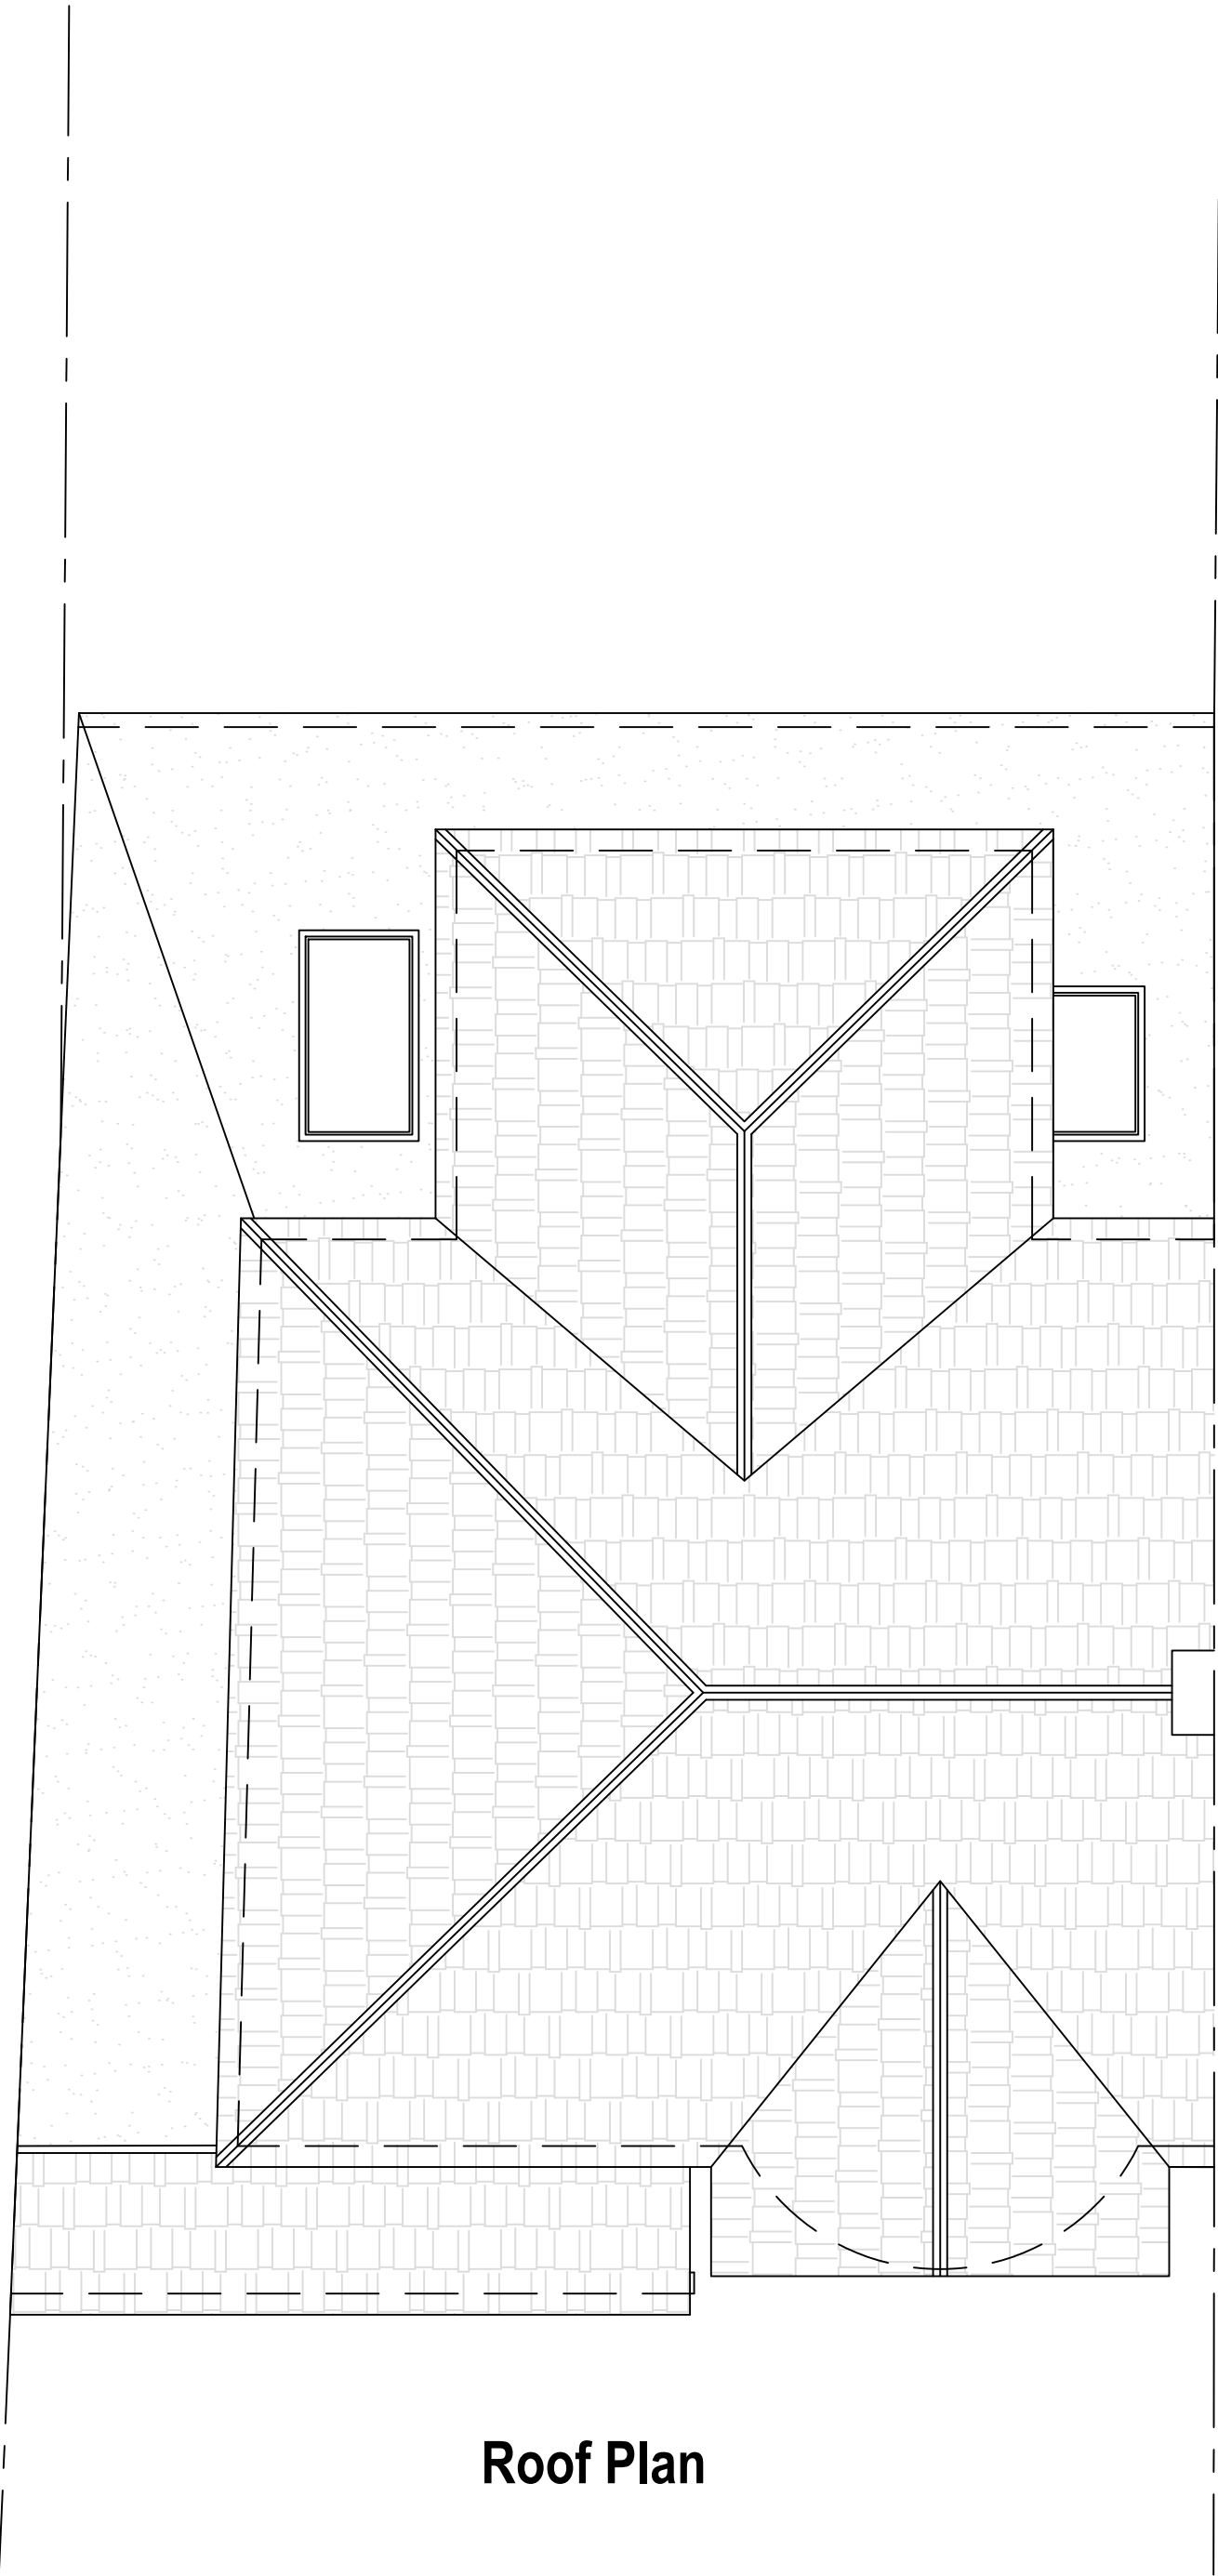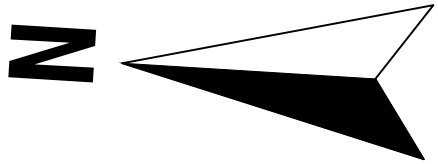

Roof Plan

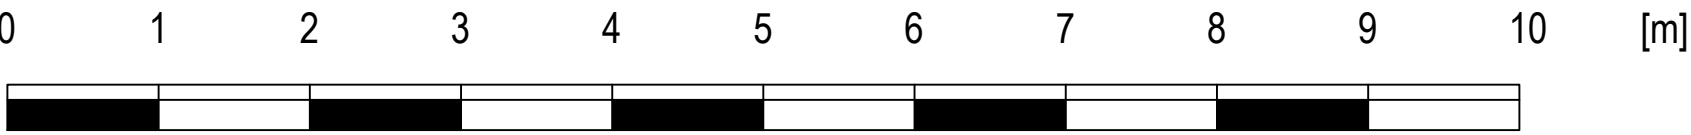

Note to Contractor: Contractor is recommended to carry out an intrusive site investigation prior to commencing works on site to ensure all details designed for this project are appropriate. Contractor to cross reference with Structural Calculations package for suitability, to assess site levels and confirm any design assumptions within the calculations package prior to works commencing on site. If the Contractor requires any additional information, please send a Request For Information to hello@planituk.co.uk before ordering materials and starting the works - requests will be acknowledged and responded to as soon as possible. Please ensure that the drawings have been submitted to Building Control for a Full Plans submission and the compliance report has been discharged before starting works on site. All dimensions must be checked and verified on site by the contractor prior to the commencement of any works. Any discrepancies or variations must be reported to Plan It UK immediately. Drain location is an estimated location, contractor to investigate on site and allow a time and cost contingency for adjustments to drainage if required.

Drawn by:
FD

Title Number
MX22195

Project:
69 Hatherleigh Road, HA4 6AX

Date:
17.07.2026

No.:
26-0899

Rev:
01

Page:
D04

Client:
Kieran Murphy



Drawing Title:
EXISTING PLANS

Scale:
1:50 @A1, 1:100 @A3



7 Leigh House, Bexleyheath, DA7 4QP
Enquiries@planituk.co.uk
Engineer: se@planituk.co.uk

PROPOSED

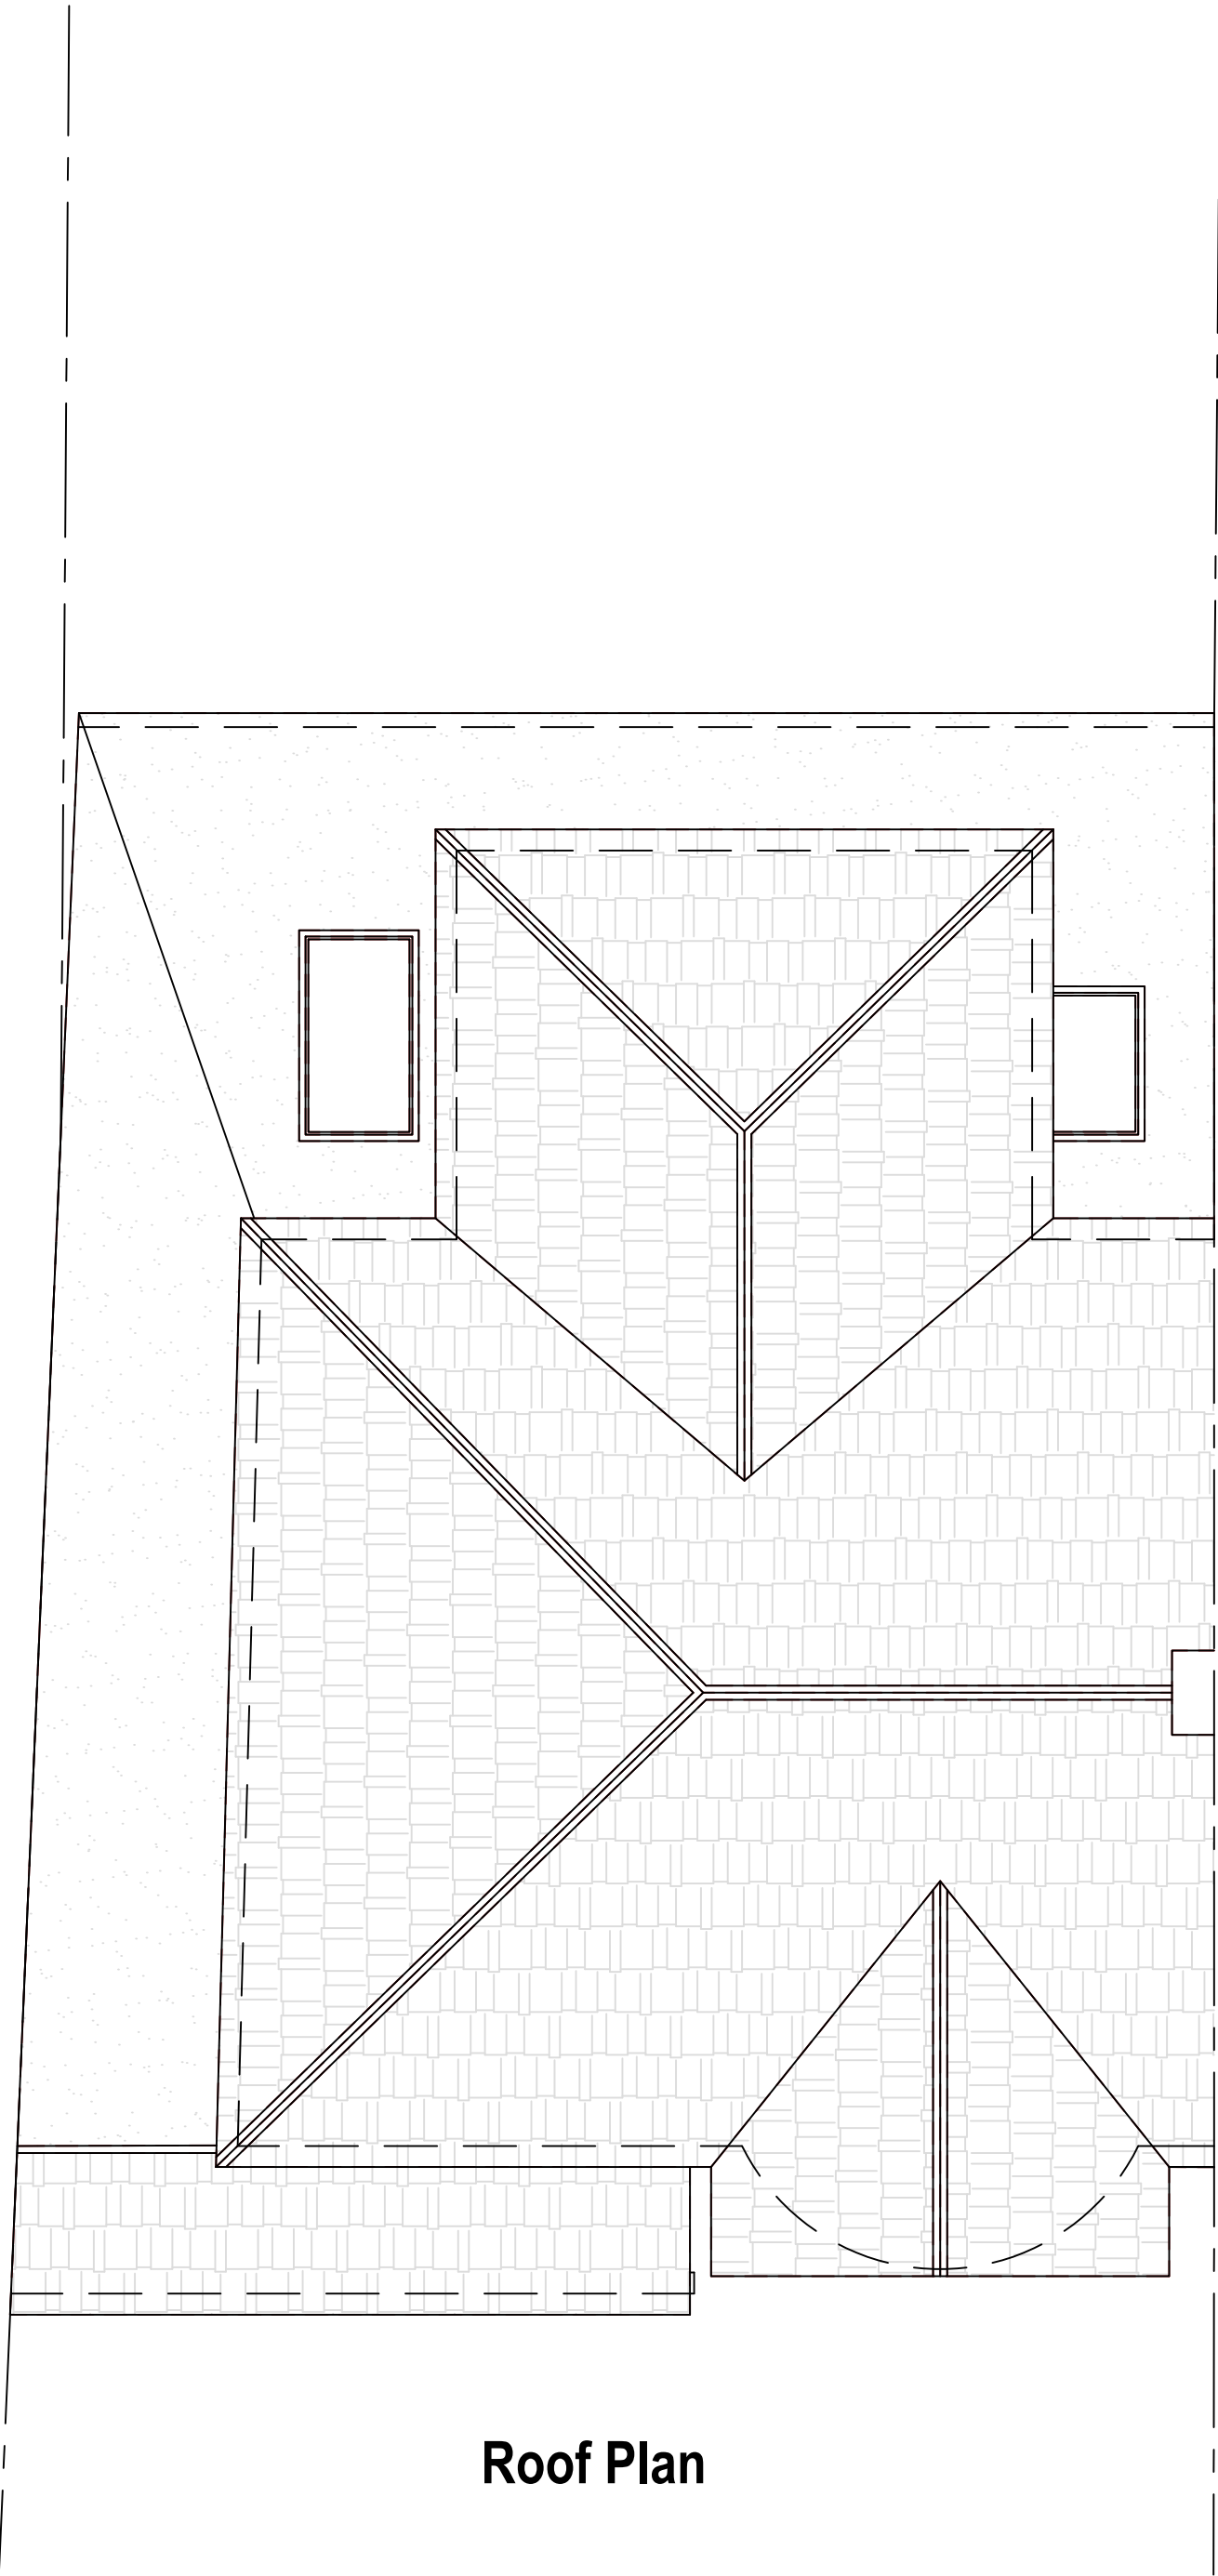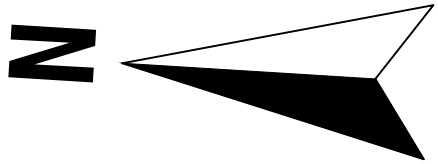


Roof Plan

Symbol Key:

- Proposed wall
- Boundary line
- Details above
- Waste drainage layout
- Demolished
- Rainwater layout

Proposed Materials:
All new drainage to match material of existing drainage

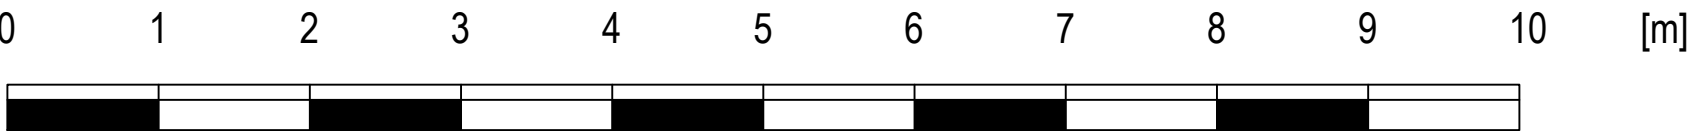

Note to Contractor: Contractor is recommended to carry out an intrusive site investigation prior to commencing works on site to ensure all details designed for this project are appropriate. Contractor to cross reference with Structural Calculations package for suitability, to assess site levels and confirm any design assumptions within the calculations package prior to works commencing on site. If the Contractor requires any additional information, please send a Request For Information to hello@planituk.co.uk before ordering materials and starting the works - requests will be acknowledged and responded to as soon as possible. Please ensure that the drawings have been submitted to Building Control for a Full Plans submission and the compliance report has been discharged before starting works on site. All dimensions must be checked and verified on site by the contractor prior to the commencement of any works. Any discrepancies or variations must be reported to Plan It UK immediately. Drain location is an estimated location, contractor to investigate on site and allow a time and cost contingency for adjustments to drainage if required.

Drawn by:
FD

Title Number
MX22195

Project:
69 Hatherleigh Road, HA4 6AX

Date:
17.07.2026

No.:
26-0899

Rev:
01


Scale:
1:50 @A1, 1:100 @A3

Page:
D05




7 Leigh House, Bexleyheath, DA7 4QP
Enquiries@planituk.co.uk
Engineer: se@planituk.co.uk

EXISTING

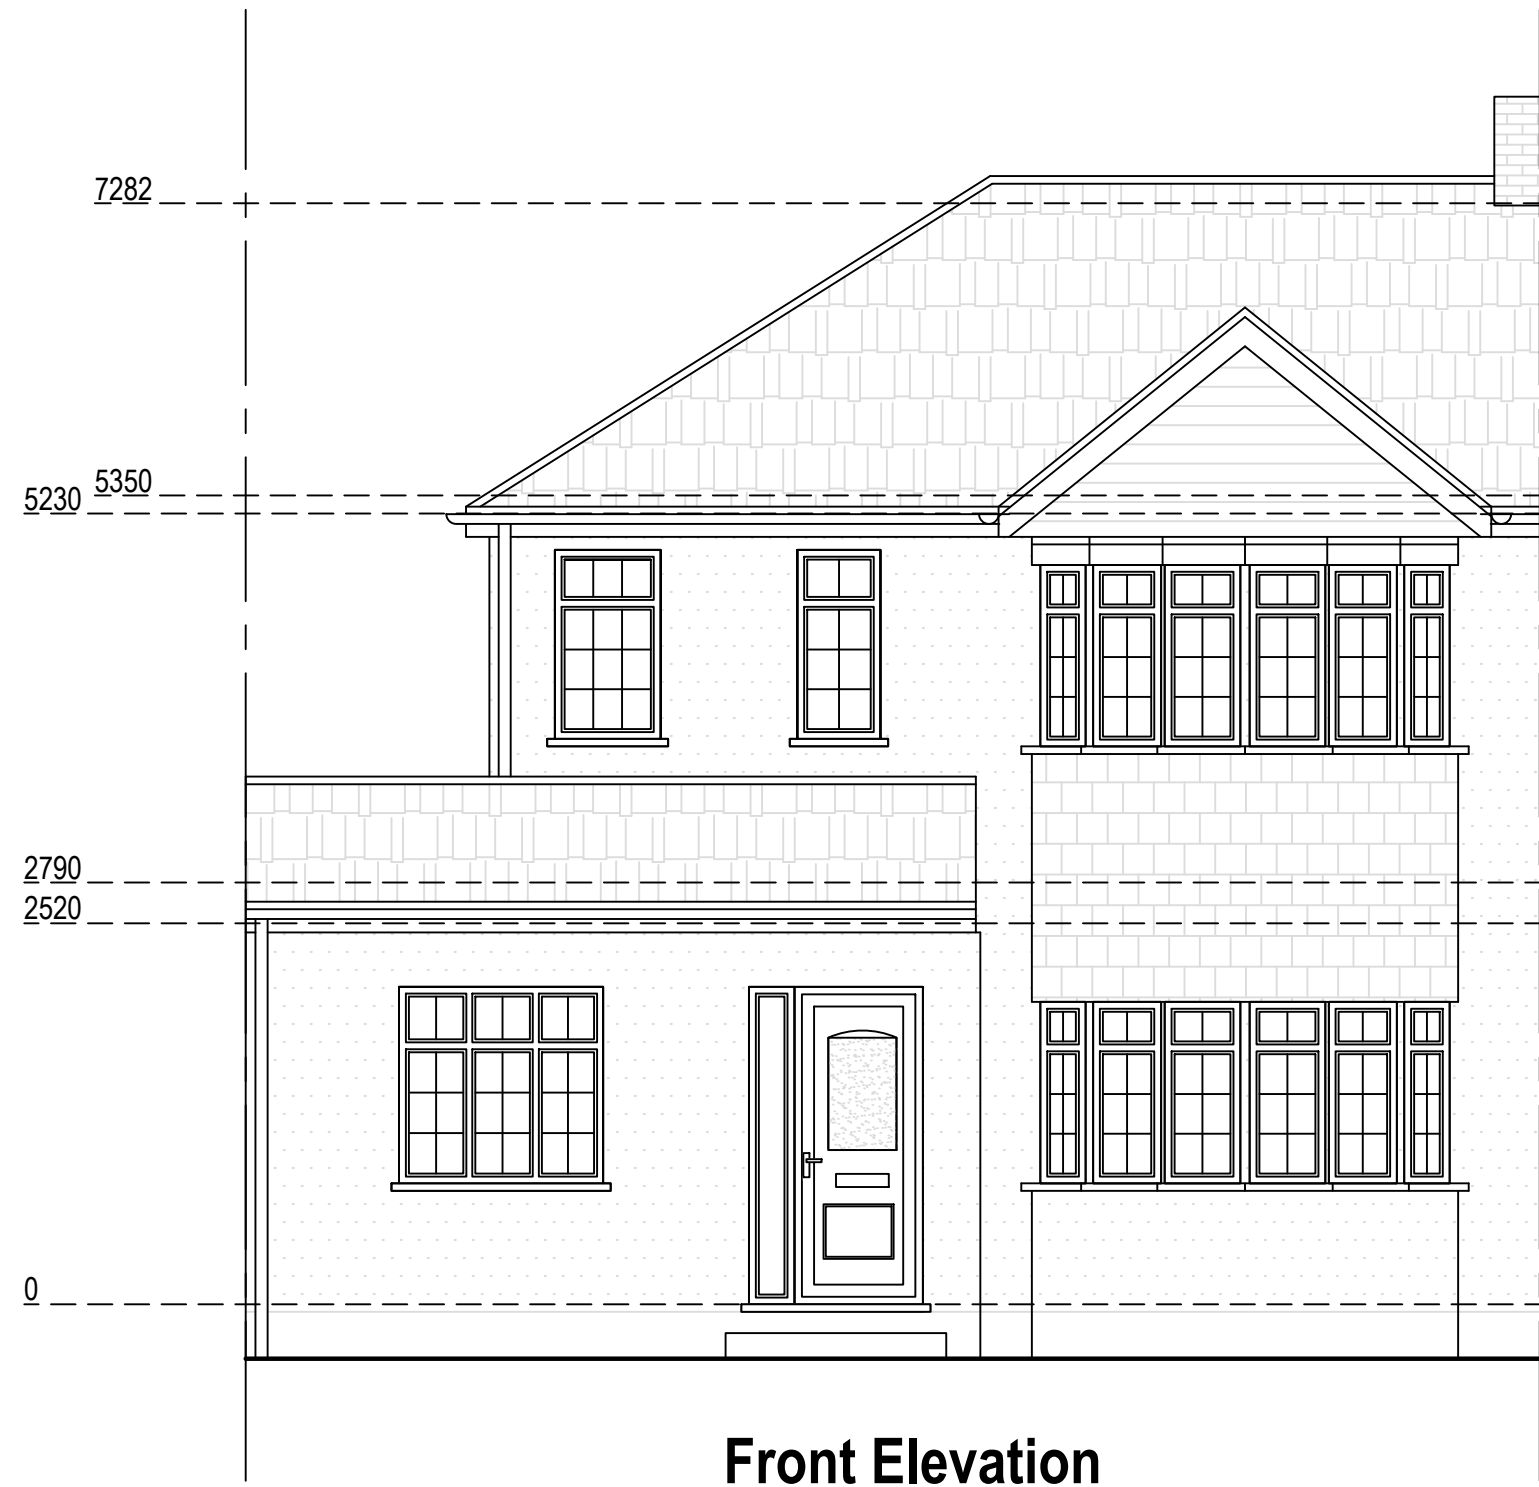


Front Elevation

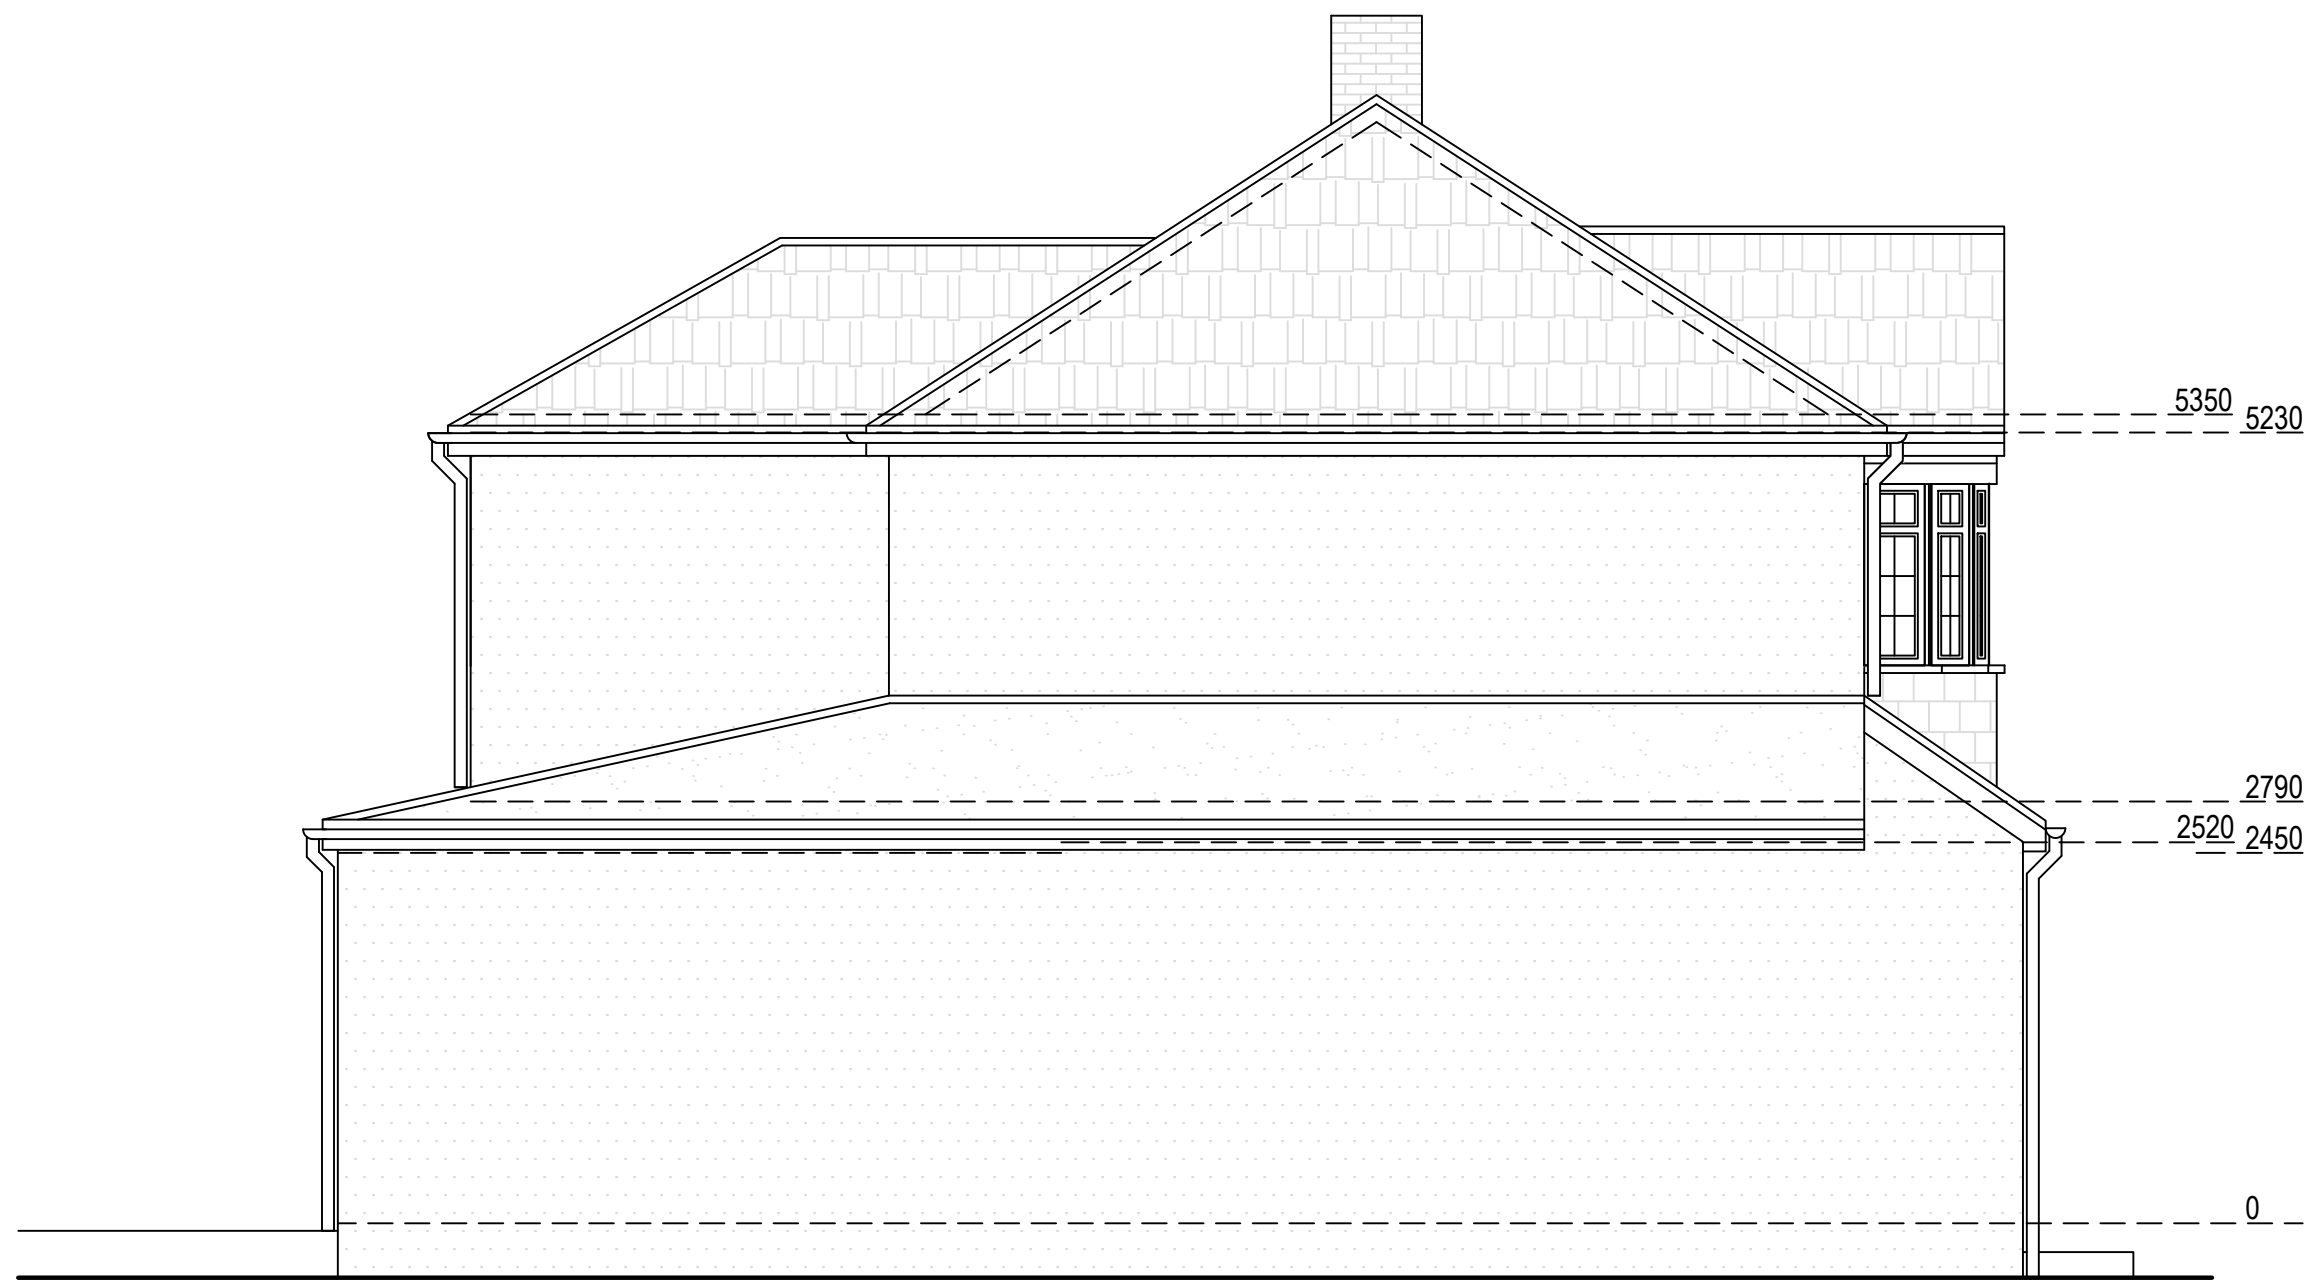


Left Side Elevation



Rear Elevation

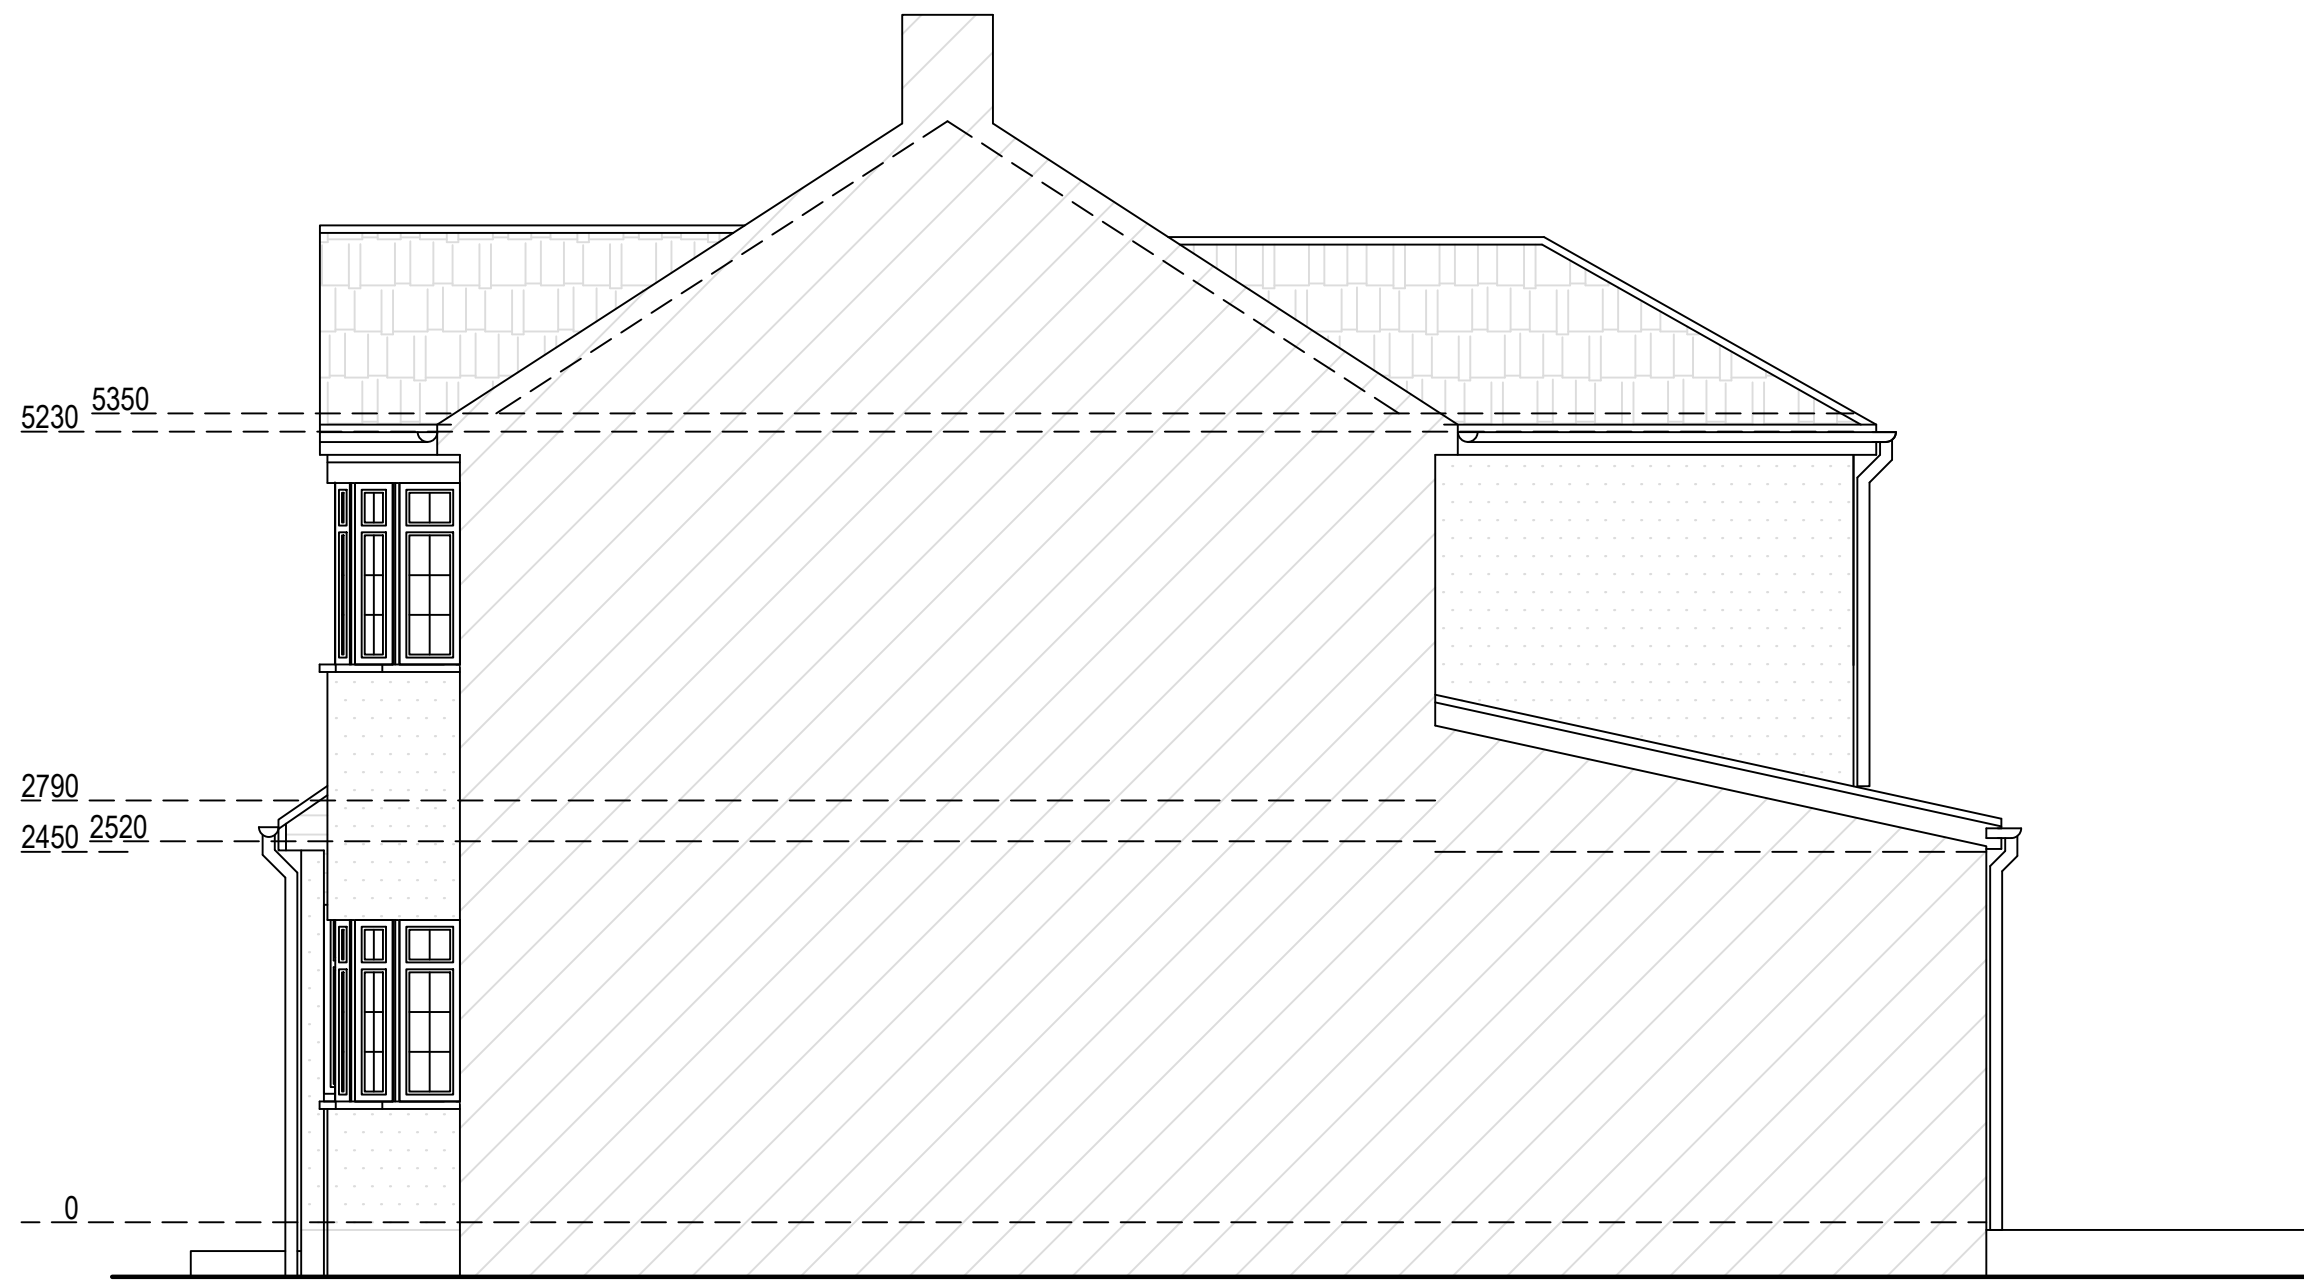

Right Side Elevation

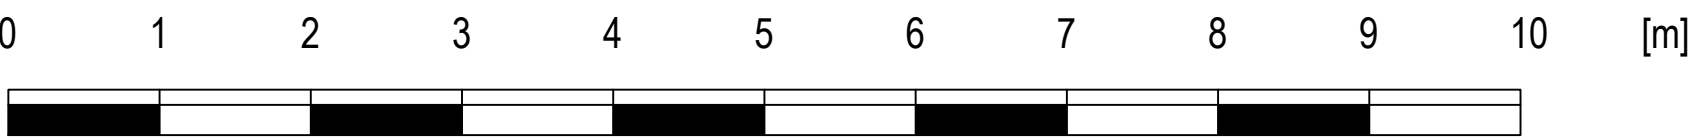

Note to Contractor: Contractor is recommended to carry out an intrusive site investigation prior to commencing works on site to ensure all details designed for this project are appropriate. Contractor to cross reference with Structural Calculations package for suitability, to assess site levels and confirm any design assumptions within the calculations package prior to works commencing on site. If the Contractor requires any additional information, please send a Request For Information to hello@planituk.co.uk before ordering materials and starting the works - requests will be acknowledged and responded to as soon as possible. Please ensure that the drawings have been submitted to Building Control for a Full Plans submission and the compliance report has been discharged before starting works on site. All dimensions must be checked and verified on site by the contractor prior to the commencement of any works. Any discrepancies or variations must be reported to Plan It UK immediately. Drain location is an estimated location, contractor to investigate on site and allow a time and cost contingency for adjustments to drainage if required.

Drawn by:
FD

Title Number
MX22195

Project:
69 Hatherleigh Road, HA4 6AX

Date:
17.07.2026

No.:
26-0899


Rev:
01

Page:
D06

Client:
Kieran Murphy

Drawing Title:
EXISTING ELEVATIONS

Scale:
1:50 @A1, 1:100 @A3

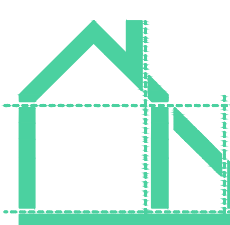


Plan It UK
Architectural Services


7 Leigh House, Bexleyheath, DA7 4QP
Enquiries@planituk.co.uk
Engineer: se@planituk.co.uk

PROPOSED

Proposed Materials:
All new drainage to match material of existing drainage

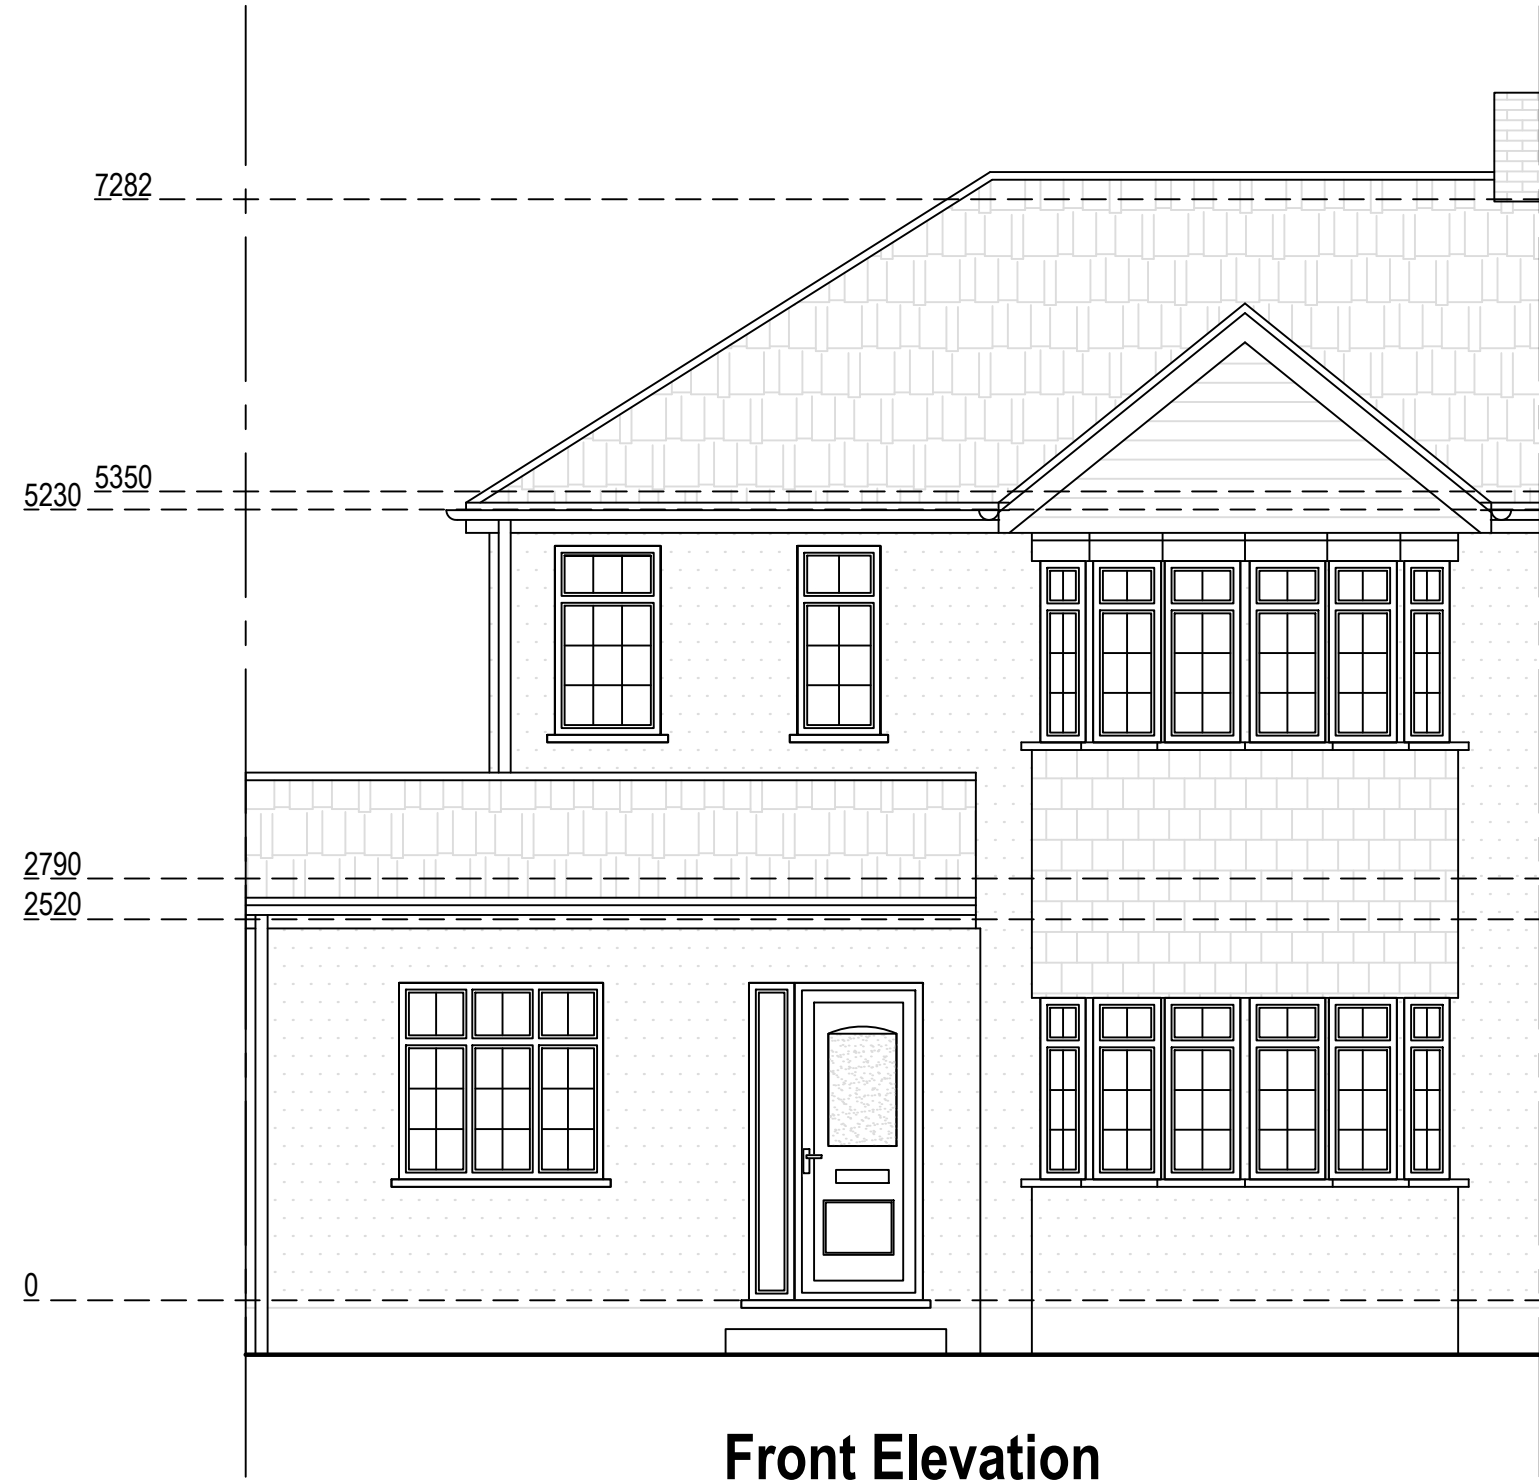


Front Elevation

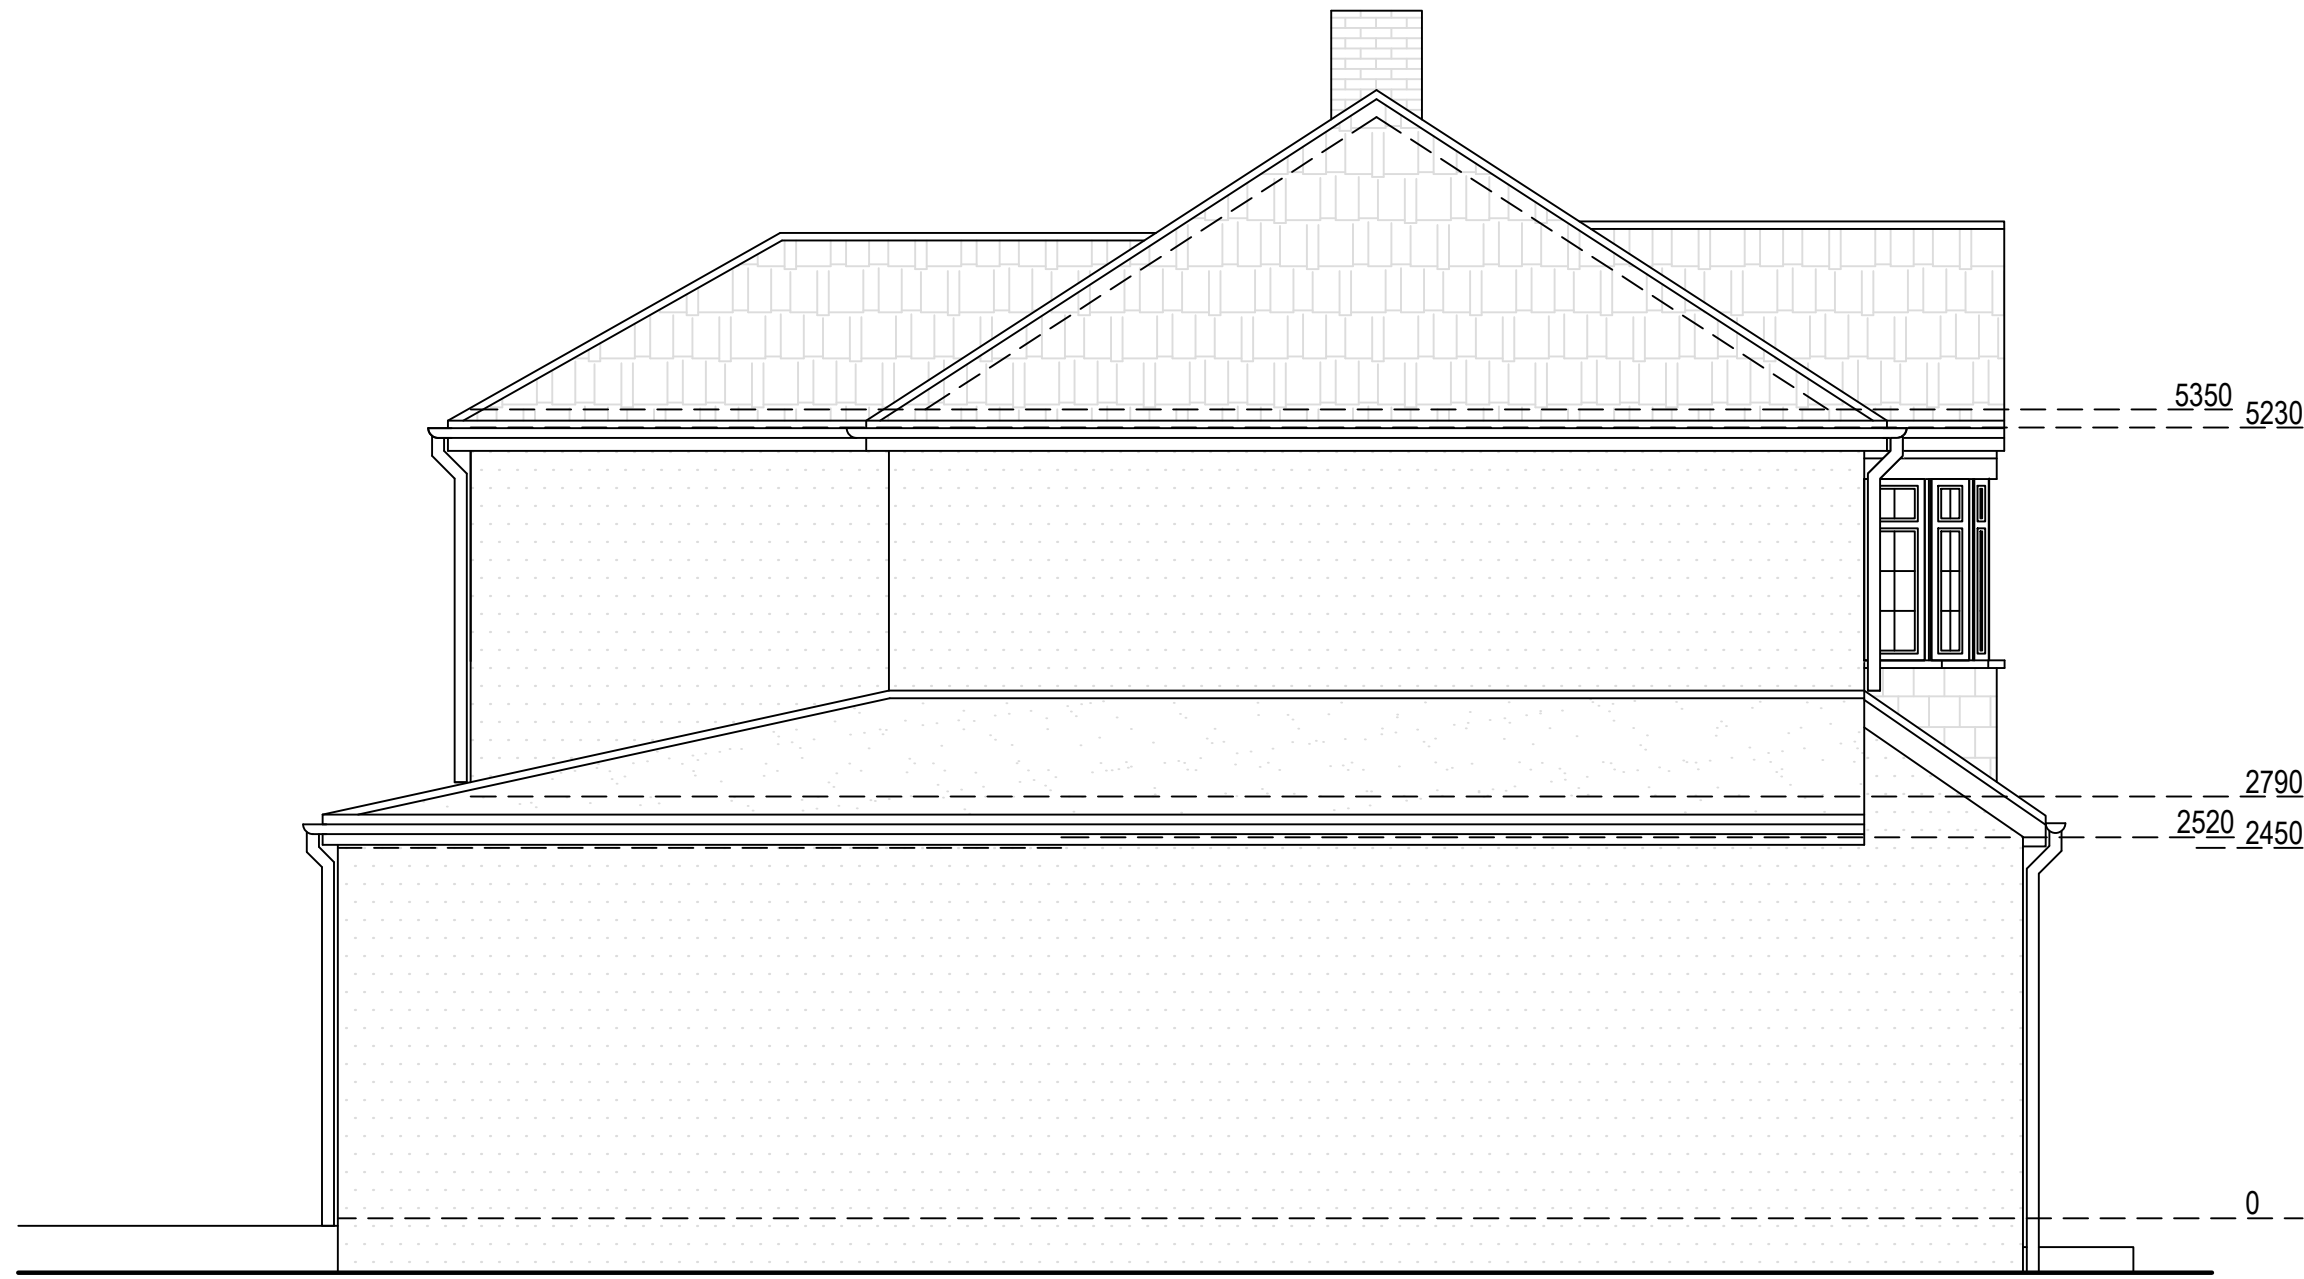


Left Side Elevation



Rear Elevation

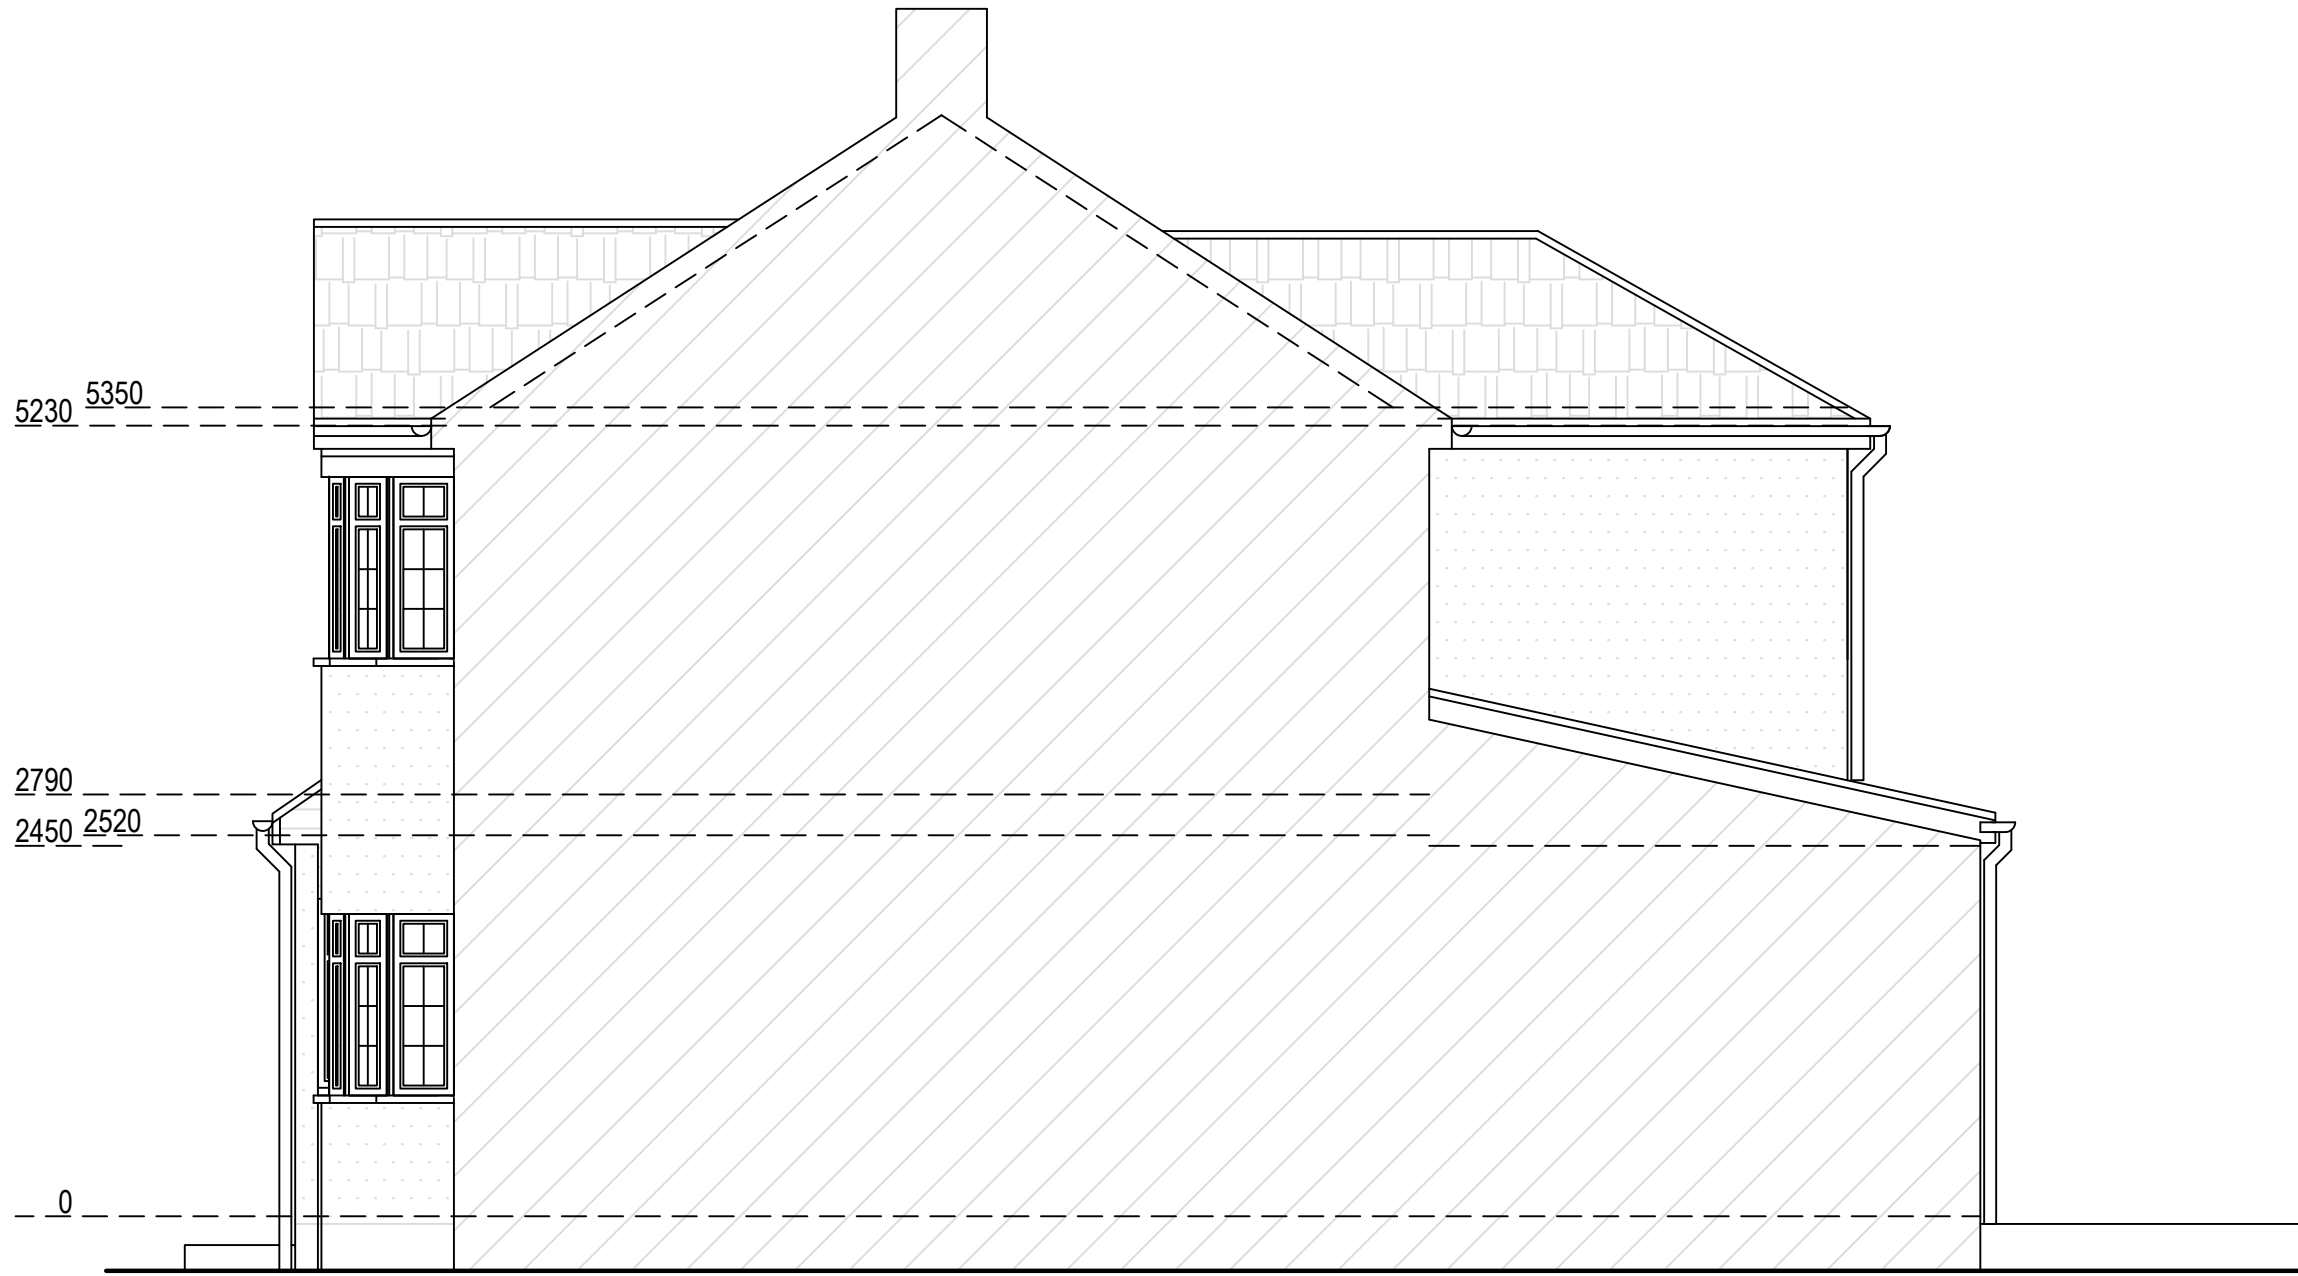

Right Side Elevation

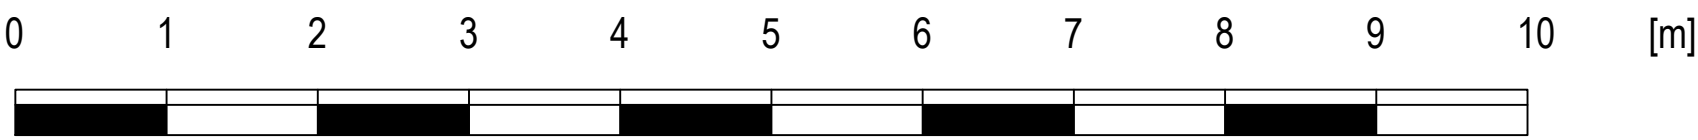

Note to Contractor: Contractor is recommended to carry out an intrusive site investigation prior to commencing works on site to ensure all details designed for this project are appropriate. Contractor to cross reference with Structural Calculations package for suitability, to assess site levels and confirm any design assumptions within the calculations package prior to works commencing on site. If the Contractor requires any additional information, please send a Request For Information to hello@planituk.co.uk before ordering materials and starting the works - requests will be acknowledged and responded to as soon as possible. Please ensure that the drawings have been submitted to Building Control for a Full Plans submission and the compliance report has been discharged before starting works on site. All dimensions must be checked and verified on site by the contractor prior to the commencement of any works. Any discrepancies or variations must be reported to Plan It UK immediately. Drain location is an estimated location, contractor to investigate on site and allow a time and cost contingency for adjustments to drainage if required.

Drawn by:
FD

Title Number
MX22195

Project:
69 Hatherleigh Road, HA4 6AX

Date:
17.07.2026

No.:
26-0899


Rev:
01

Page:
D07

Client:
Kieran Murphy

Drawing Title:
PROPOSED ELEVATIONS

Scale:
1:50 @A1, 1:100 @A3

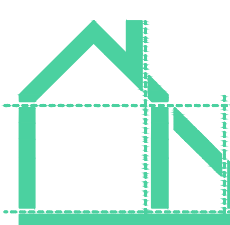

Plan It UK
Architectural Services

7 Leigh House, Bexleyheath, DA7 4QP
Enquiries@planituk.co.uk
Engineer: se@planituk.co.uk