

CDM DESIGNER RISK INFORMATION
IN ADDITION TO THE HAZARDS/RISKS NORMALLY
ASSOCIATED WITH THE TYPES OF WORK DETAILED
ON THIS DRAWING:-
NOTE THE FOLLOWING:-
CONSTRUCTION
MAINTENANCE/CLEANING
DECOMMISSIONING/DEMOLITION
FURTHER INFORMATION CAN BE FOUND ON
DESIGNER RISK ASSESSMENT NUMBER:-
IT IS ASSUMED THAT ALL WORKS WILL BE CARRIED
OUT BY A CONTRACTOR COMPETENT UNDER CDM
2015 WORKING TO AN APPROVED METHOD
STATEMENT



D SERIES 0/1 LUMINAIRE



DENVER iD WALL LUMINAIRE

Notes



- DO NOT SCALE THIS DRAWING.
- ALL DIMENSIONS ARE IN MILLIMETERS UNLESS OTHERWISE STATED.
- THIS DRAWING IS TO BE READ IN CONJUNCTION WITH ALL OTHER RELEVANT DRAWINGS AND SPECIFICATIONS.

Label						
Symbol	Label	Quantity	Catalog Number	Description	Lumens Per Lamp	Wattage
	AW	8	DSX1.2.LA224.FW	Wall Mounted @ 9.5m	24252	200
	B1	2	DSX0.1.LA064.FW	Column Mounted @ 6m	5989	45
	BW	1	DSX0.1.LA064.FW	Wall Mounted @ 8m	5989	45
	C1	9	DSX0.1.LA114.NR	Column Mounted @ 8m	11674	88
	DW	14	DWL-1.LA034.HN.W018	Wall Mounted @ 4m	2481	18

Statistics				
Description	Symbol	Avg	Min	Min/Avg
Building Perimeter	+	13 lux	6 lux	0.46
Car Park	+	15 lux	6 lux	0.40
Cycle / Pedestrian Entrance	+	30 lux	18 lux	0.60
Cycle Shelter / Circulation	+	15 lux	6 lux	0.40
Entrance Roadway / Turning	+	30 lux	13 lux	0.43
Pathway	+	13 lux	8 lux	0.62
Pathway	+	23 lux	22 lux	0.96
Seating Area	+	10 lux	7 lux	0.70
Shared HGV Turn	+	34 lux	29 lux	0.85
Substation Access	+	22 lux	15 lux	0.68
Unit 110 Loading Bays	+	30 lux	18 lux	0.60
Unit 110 Yard	+	30 lux	12 lux	0.40
Unit 120 Loading Bays	+	36 lux	32 lux	0.89
Unit 120 Yard	+	35 lux	20 lux	0.57
Unit 130 Loading Bays	+	37 lux	31 lux	0.84
Unit 130 Yard	+	33 lux	16 lux	0.48
Unit 140 Loading Bays	+	40 lux	36 lux	0.90
Unit 140 Yard	+	35 lux	17 lux	0.49

Description			
Description	Symbol	Max	Min
Simpson Way Vertical	+	0 lux	0 lux
Bath Road Vertical	+	2 lux	0 lux

Statistics				
Description	Symbol	Avg	Min	Min/Avg
Entrance Roadway / Turning LANDLORDS ONLY	+	20 lux	8 lux	0.40

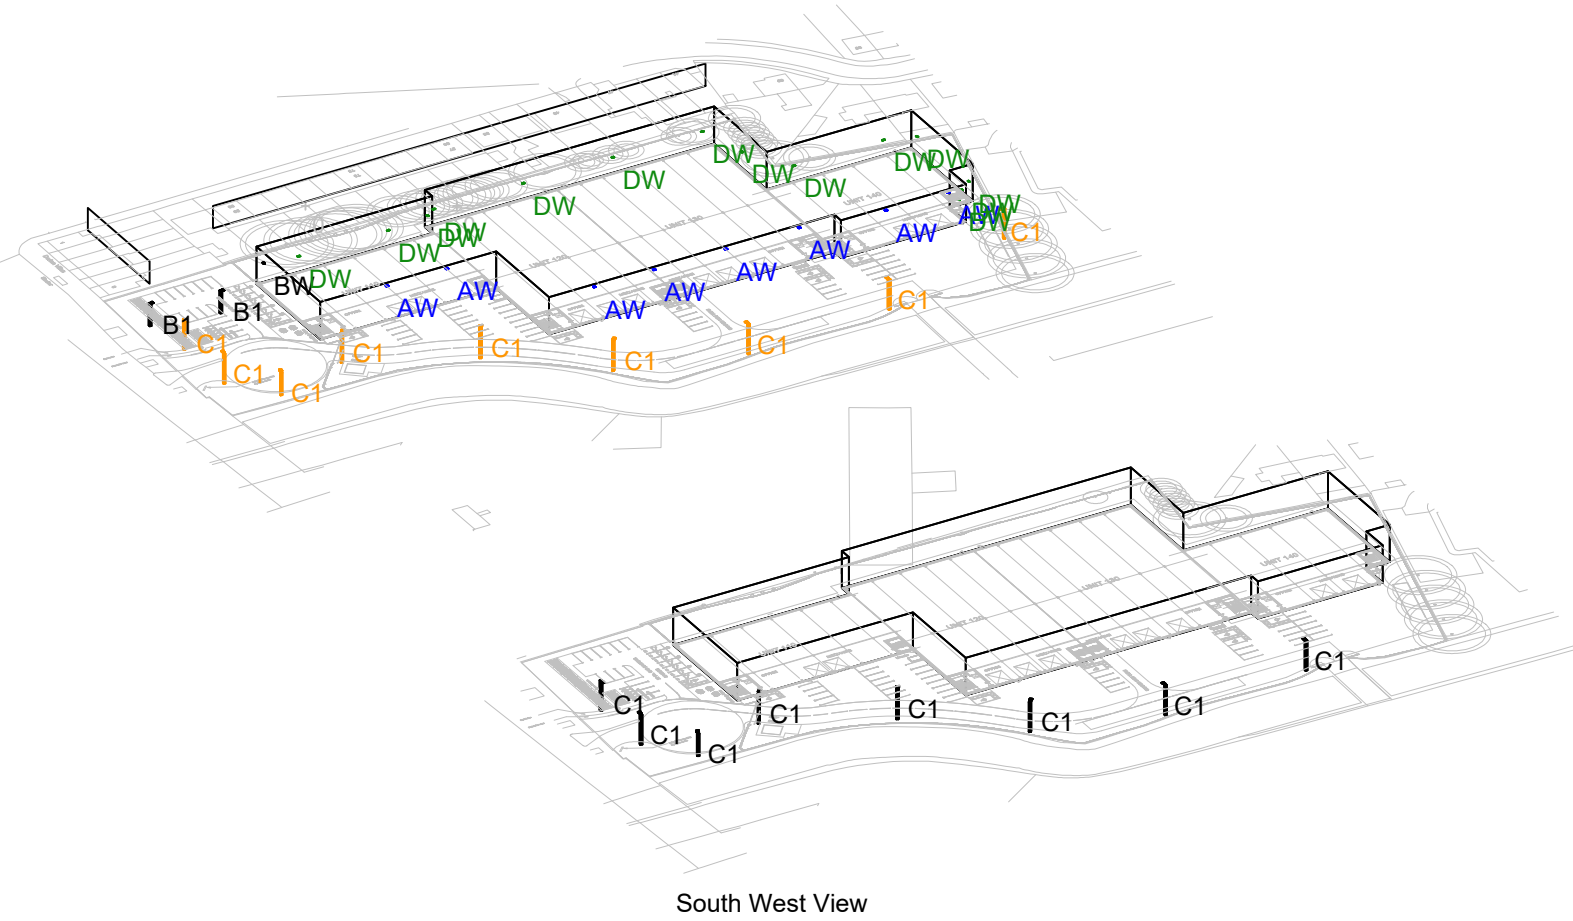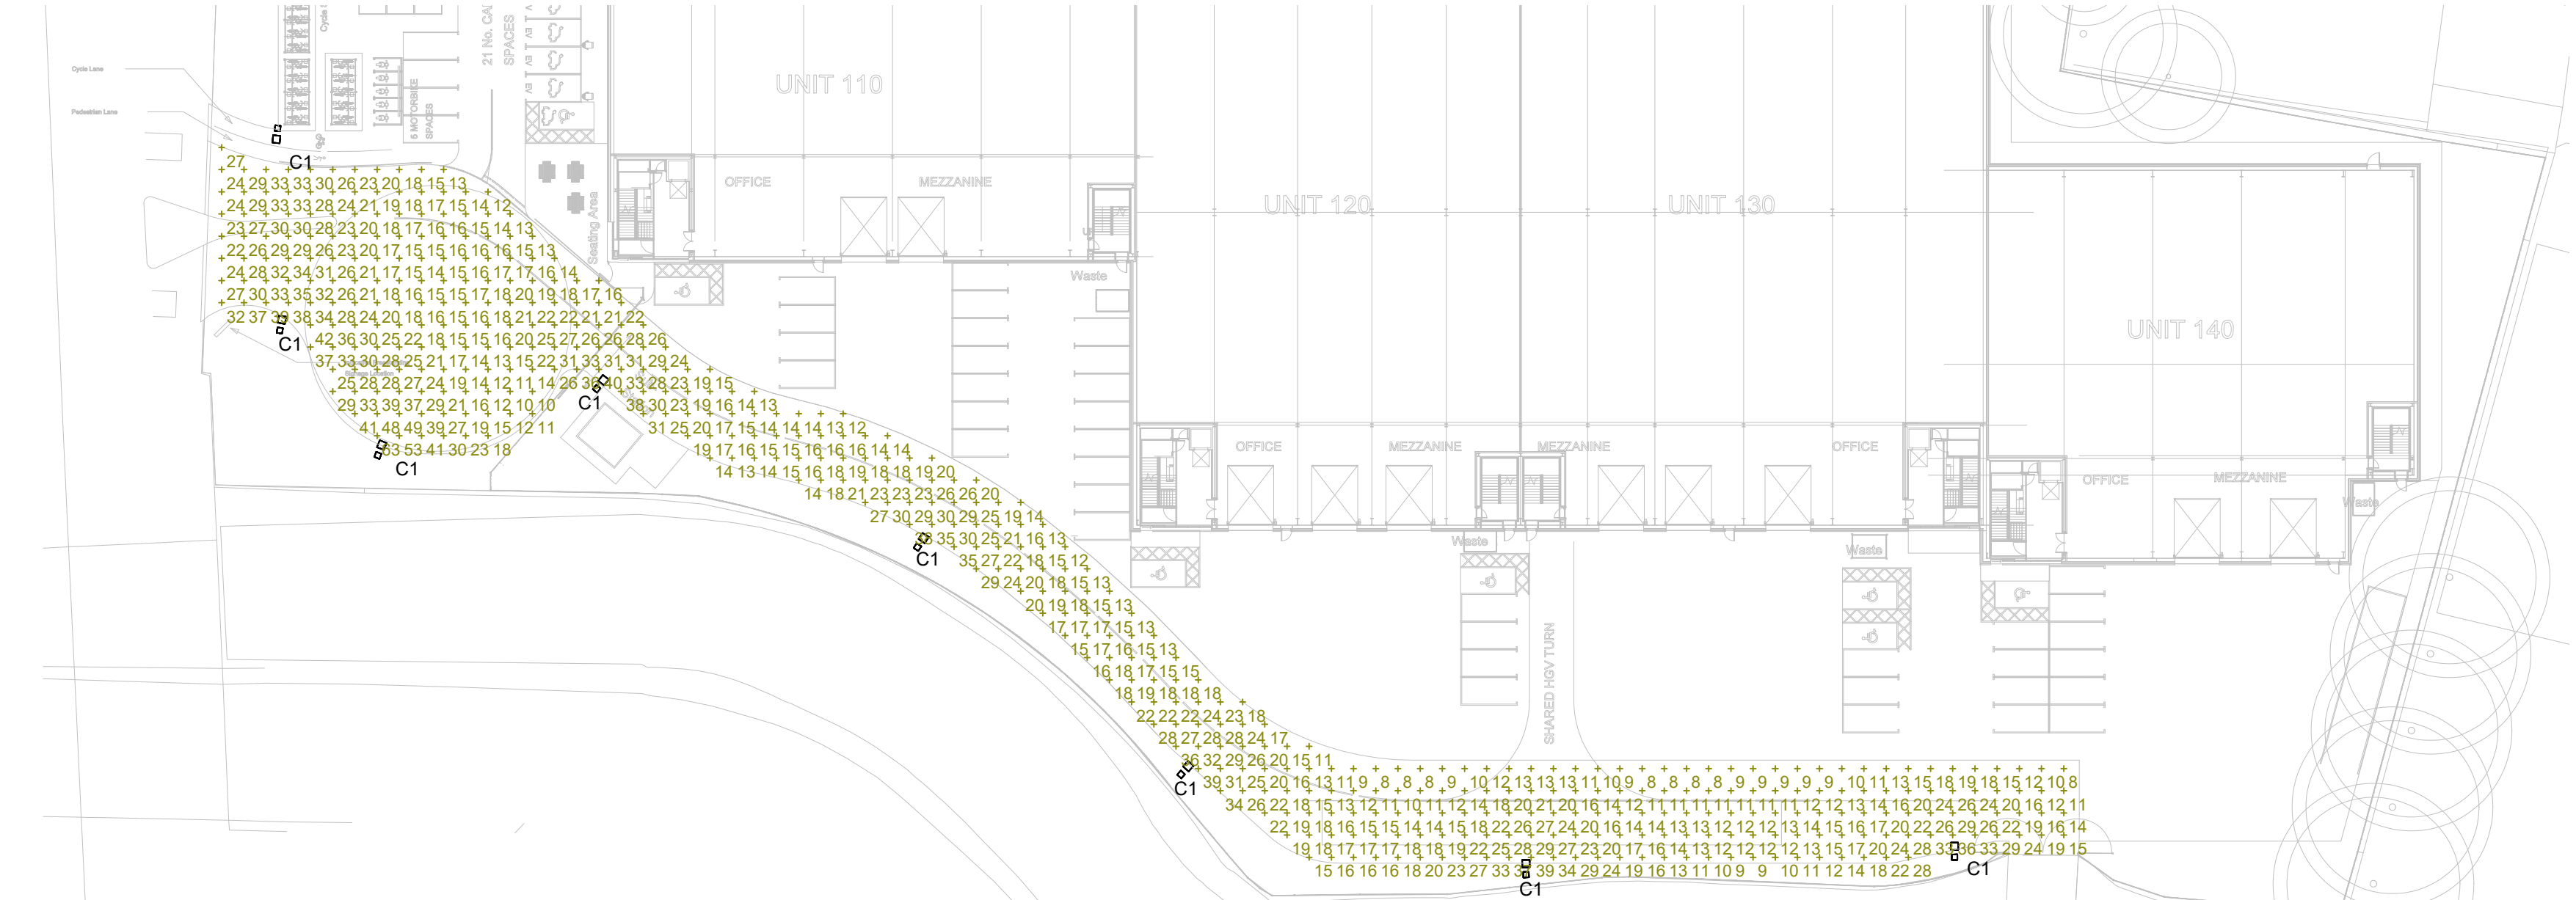

PL3 18.05.2023	RE-ISSUED FOR PLANNING	BT
PL2 08.07.2022	RE-ISSUED FOR PLANNING	BT
PL1 07.07.2022	ISSUED FOR PLANNING	BT

REV: DATE: AMENDMENTS: APPRD:

Maple House, Woodlands Business Park,
Lindford Wood West, Milton Keynes MK14 6FG
Telephone: +44 (0) 1908 320 099
Email: enquiries@mba-consultants.co.uk
Web: www.mba-consultants.co.uk

CLIENT: HEATHORW NCP PROPERTY LIMITED
PROJECT: NCP FLIGHTPATH HEATHROW

TITLE: INDICATIVE EXTERNAL LIGHTING LAYOUT

DRAWING NUMBER: 22-112-EX-001

PROJECT NUMBER: 22-112

REV: PL3	STATUS: PLANNING	DESIGNED BY: BT
----------	------------------	-----------------

SCALE: 1:500@A1	DATE: JULY 2022	DRAWN BY: JEG
-----------------	-----------------	---------------