


CDM DESIGNER RISK INFORMATION
IN ADDITION TO THE HAZARDS/RISKS NORMALLY
ASSOCIATED WITH THE TYPES OF WORK DETAILED
ON THIS DRAWING:-
NOTE THE FOLLOWING:-
CONSTRUCTION
MAINTENANCE/CLEANING
DECOMMISSIONING/DEMOLITION
FURTHER INFORMATION CAN BE FOUND ON
DESIGNER RISK ASSESSMENT NUMBER:-
IT IS ASSUMED THAT ALL WORKS WILL BE CARRIED
OUT BY A CONTRACTOR COMPETENT UNDER CDM
2015 WORKING TO AN APPROVED METHOD
STATEMENT

Notes

- DO NOT SCALE THIS DRAWING.
- ALL DIMENSIONS ARE IN MILLIMETERS UNLESS OTHERWISE STATED.
- THIS DRAWING IS TO BE READ IN CONJUNCTION WITH ALL OTHER RELEVANT DRAWINGS AND SPECIFICATIONS.

Label					
Symbol	Label	Quantity	Catalog Number	Description	Lumens Per Lamp
	AW	8	DSX1.2.LA224.FW	Wall Mounted @ 9.5m	24252
	B1	3	DSX0.1.LA064.FW	Column Mounted @ 6m	5989
	BW	1	DSX0.1.LA064.FW	Wall Mounted @ 8m	5989
	C1	8	DSX0.1.LA064.AY	Column Mounted @ 8m	5823
	DW	14	DWL.1.LA034.HN.W018	Wall Mounted @ 4m	2481



Statistics				
Description	Symbol	Avg	Min	Min/Avg
Building Perimeter	+	13 lux	6 lux	0.46
Car Park	+	13 lux	4 lux	0.31
Estate Road	+	22 lux	12 lux	0.55
Shared HGV Turn	+	33 lux	29 lux	0.88
Spill	+	1 lux	0 lux	0.00
Unit 110 Loading Bays	+	32 lux	22 lux	0.69
Unit 110 Yard	+	28 lux	12 lux	0.43
Unit 140 Loading Bays	+	37 lux	34 lux	0.92
Unit 140 Yard	+	31 lux	13 lux	0.42
Path	+	22 lux	15 lux	0.68
Path	+	14 lux	9 lux	0.64
Path	+	10 lux	5 lux	0.50
Cycle Store	+	15 lux	11 lux	0.73
Substation Access	+	13 lux	10 lux	0.77
Unit 120 Loading Bays	+	36 lux	32 lux	0.89
Unit 120 Yard	+	35 lux	20 lux	0.57
Unit 130 Loading Bays	+	37 lux	32 lux	0.86
Unit 130 Yard	+	32 lux	17 lux	0.53

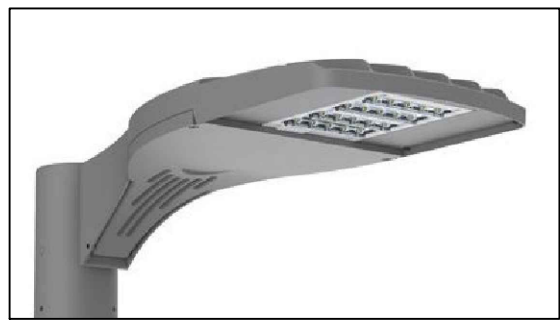

D SERIES O LUMINAIRE



DENVER iD WALL LUMINAIRE

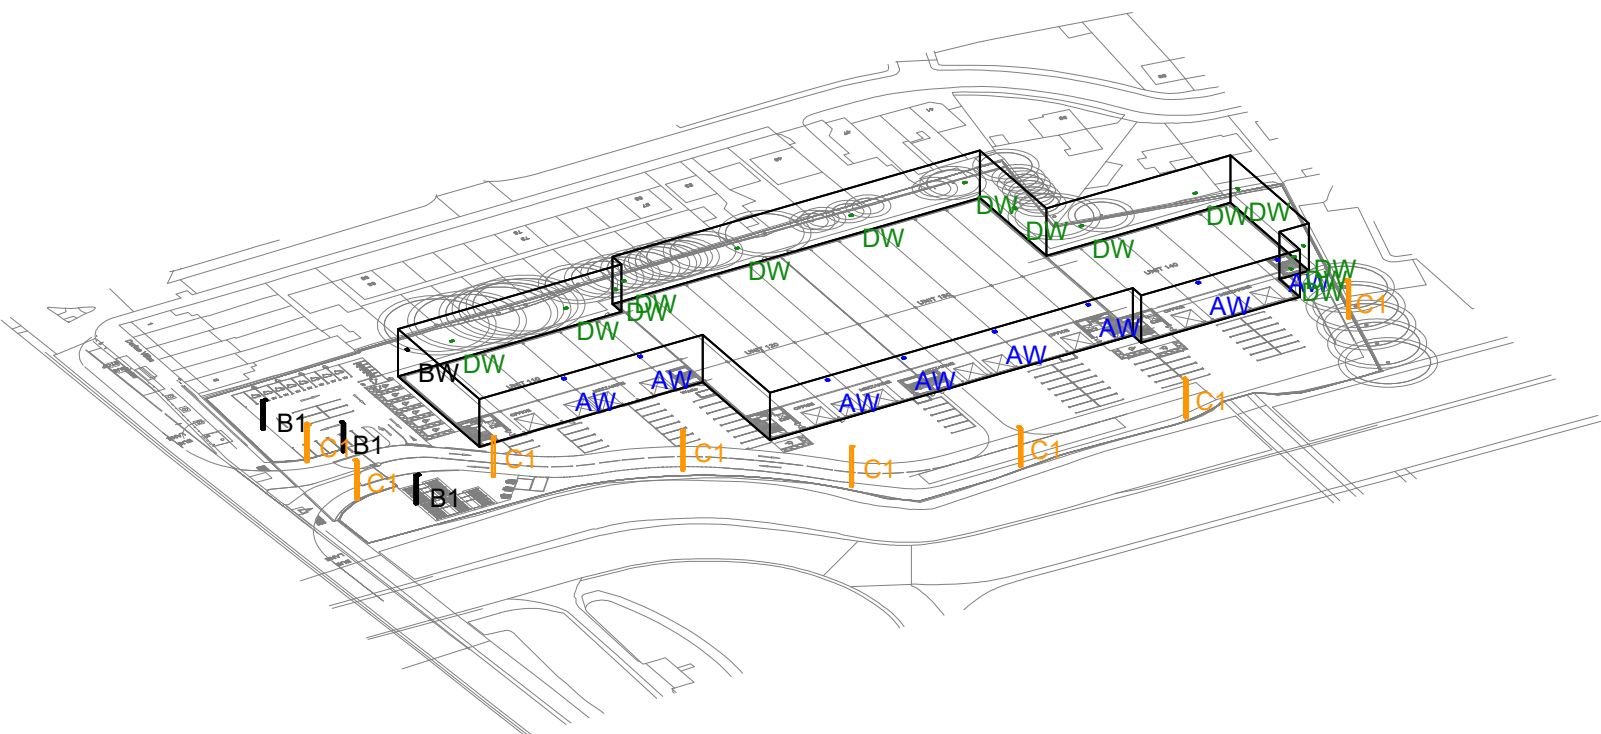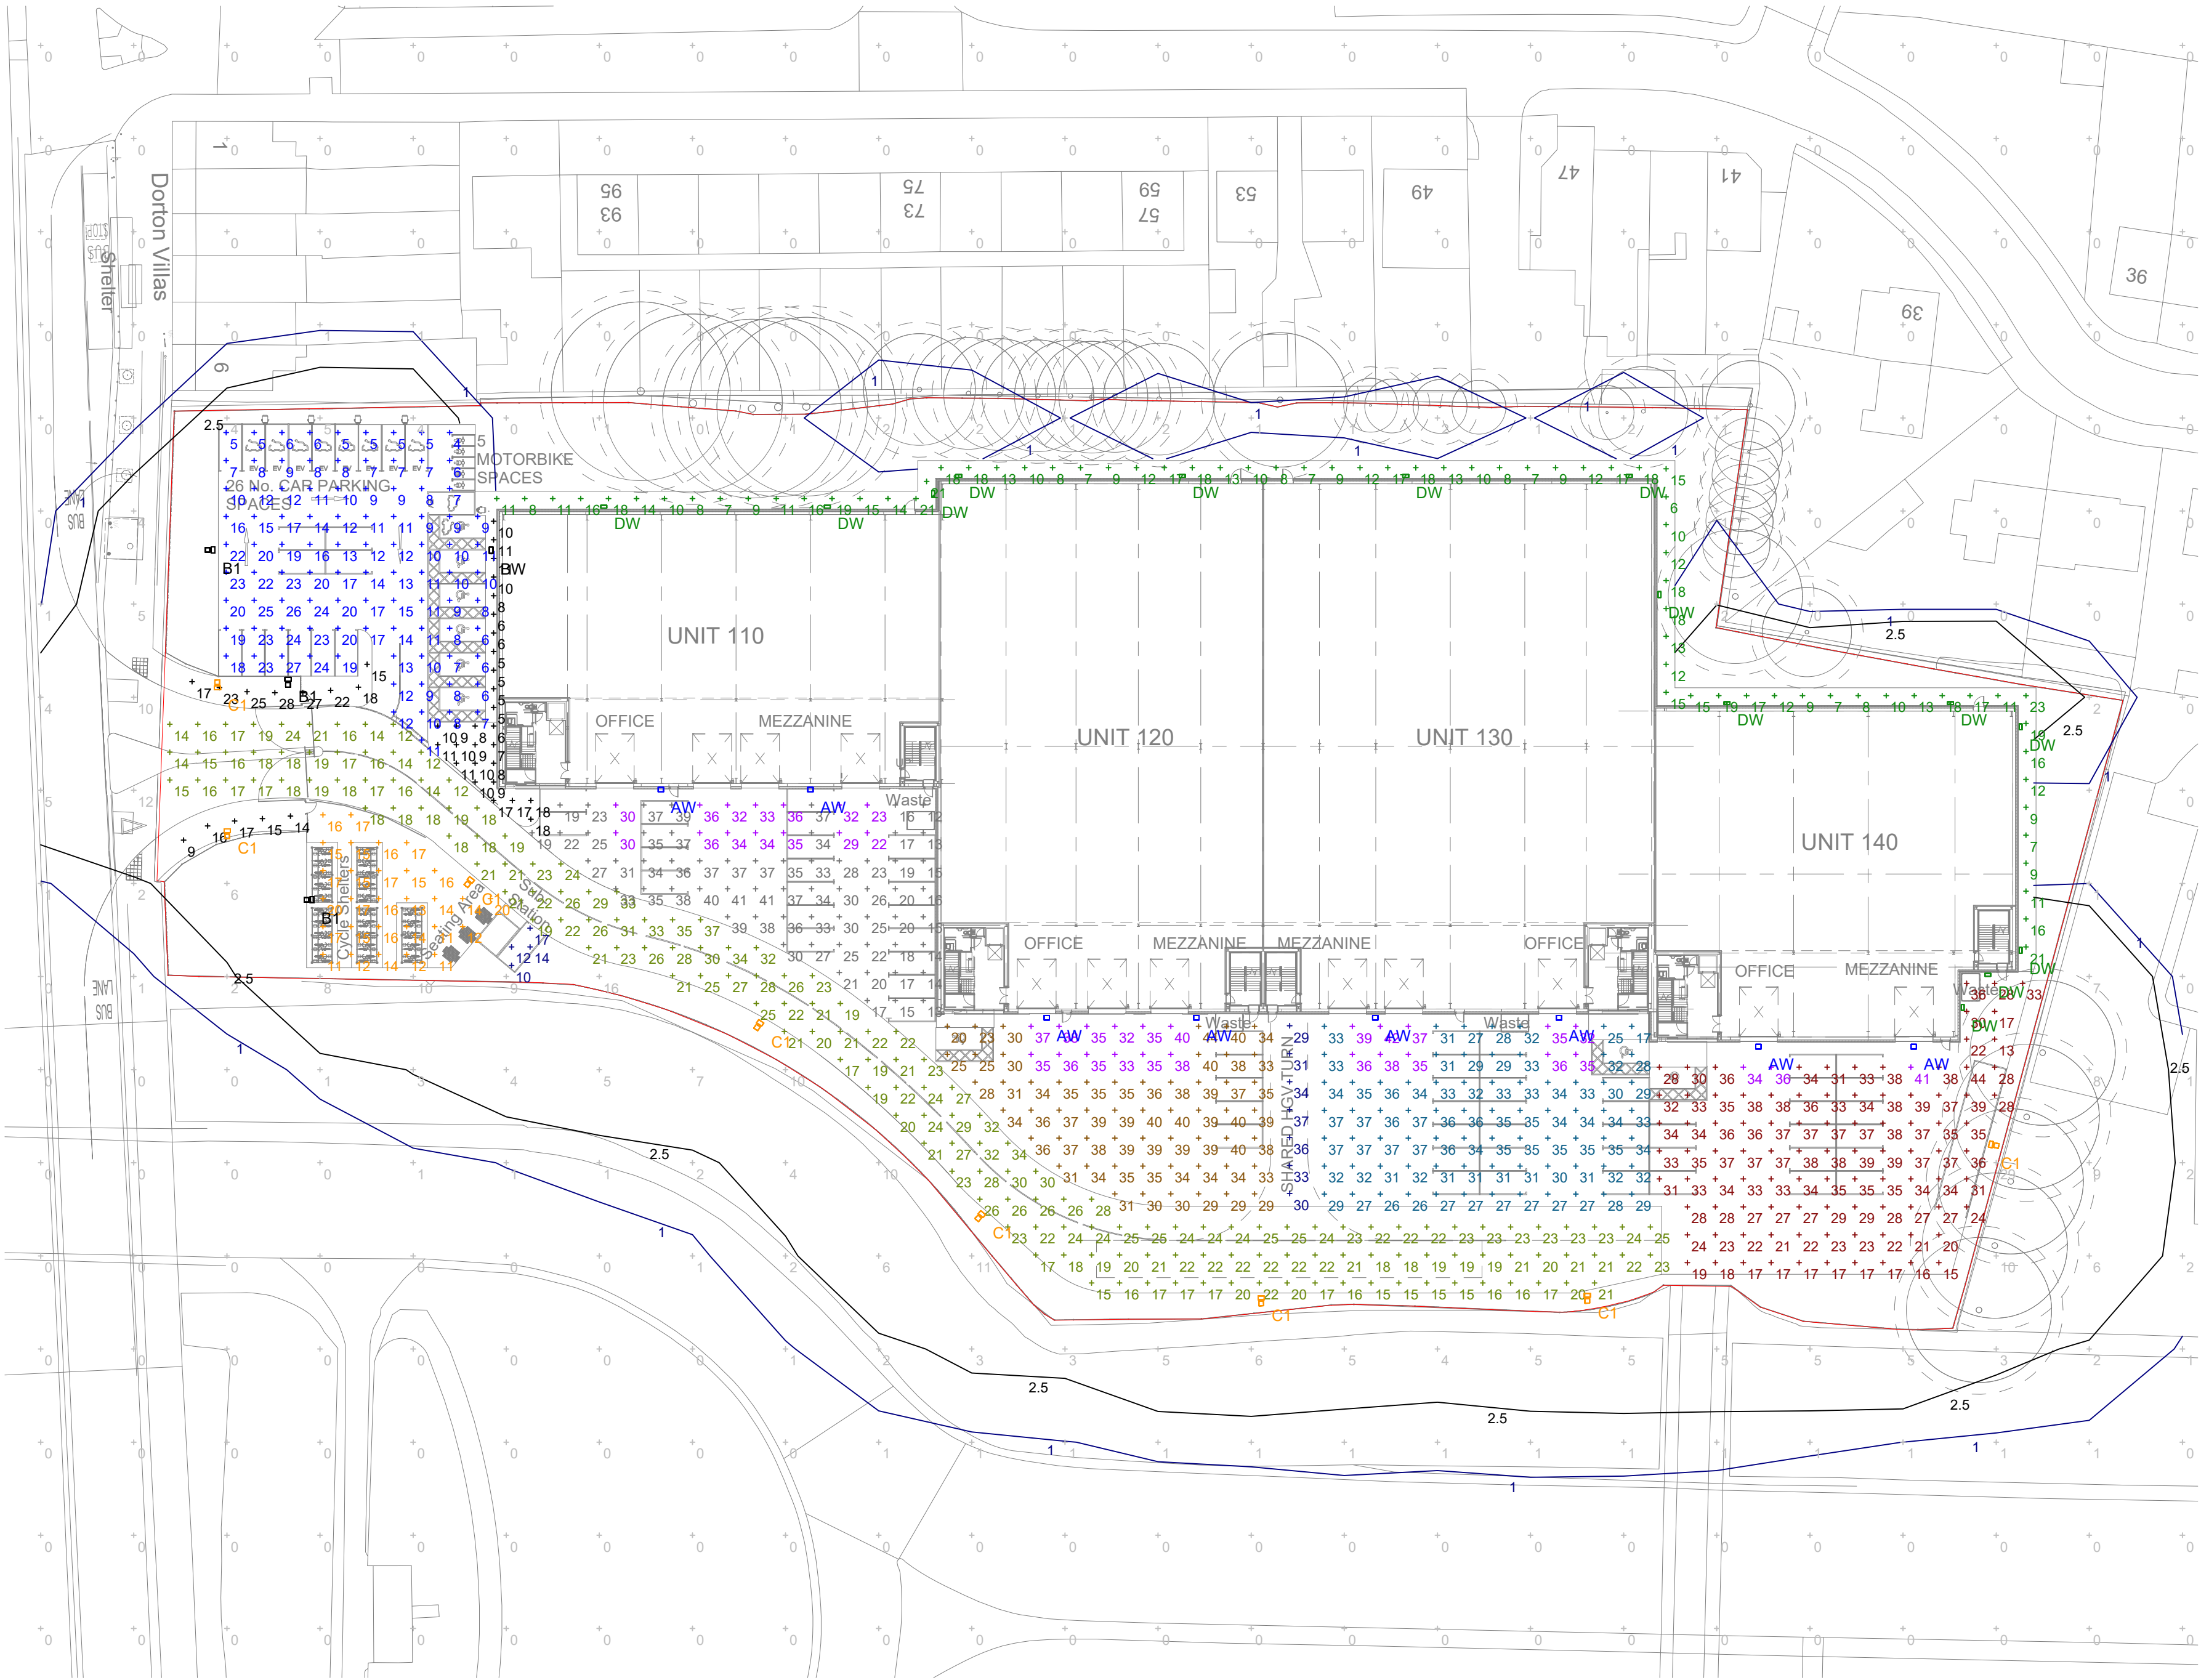

ISOMETRIC LAYOUT
NTS

P1 07.07.22 ISSUED FOR PLANNING INITIALS

REV: DATE: AMENDMENTS: APPROD:



Maple House, Woodlands Business Park,
Limford Wood West, Milton Keynes MK14 6FG

Telephone: +44 (0)1908 320 099

Email: enquiries@mba-consultants.co.uk

Web: www.mba-consultants.co.uk

CLIENT: HEATHORW NCP PROPERTY LIMITED
PROJECT: NCP FLIGHTPATH HEATHROW

TITLE: INDICATIVE EXTERNAL LIGHTING LAYOUT

DRAWING NUMBER: 22-112-EX-001

PROJECT NUMBER: 22-112

REV: P1 STATUS: PLANNING DESIGNED BY: BT

SCALE: 1:500@A1 DATE: JULY 2022 DRAWN BY: JEG