

1 Existing Ground Floor

1 : 50

GENERAL NOTES:

1. ALL DIMENTIONS ARE IN MILLIMETER.
2. VERIFY ALL DIMENSIONS AND CONDITIONS BEFORE BUILDING OR STARTING CONSTRUCTION.
3. NOTIFY THE DESIGNER IMMEDIATELY OF ANY DISCREPANCY OR VARIATION.
4. ALL WORK TO COMPLY WITH CURRENT BUILDING REGULATIONS AND CODES OF PRACTICE.



Art @ Rooshika
NISARG@HOTMAIL.COM
+44 - 7951491310

PROJECT	58 Blackthorn Ave West Drayton UB7 9EX
SHEET	Existing Ground Floor Plan


CLIENT		Ms B K Malhi	
Date	Project number	Scale (@ A3)	
Issue Date	Project Number		
Drawn by	DRWAING NUMBER		REV
Author	A101		C
Checked by			
Checker			



1 Existing Rear_Elevation
1 : 100

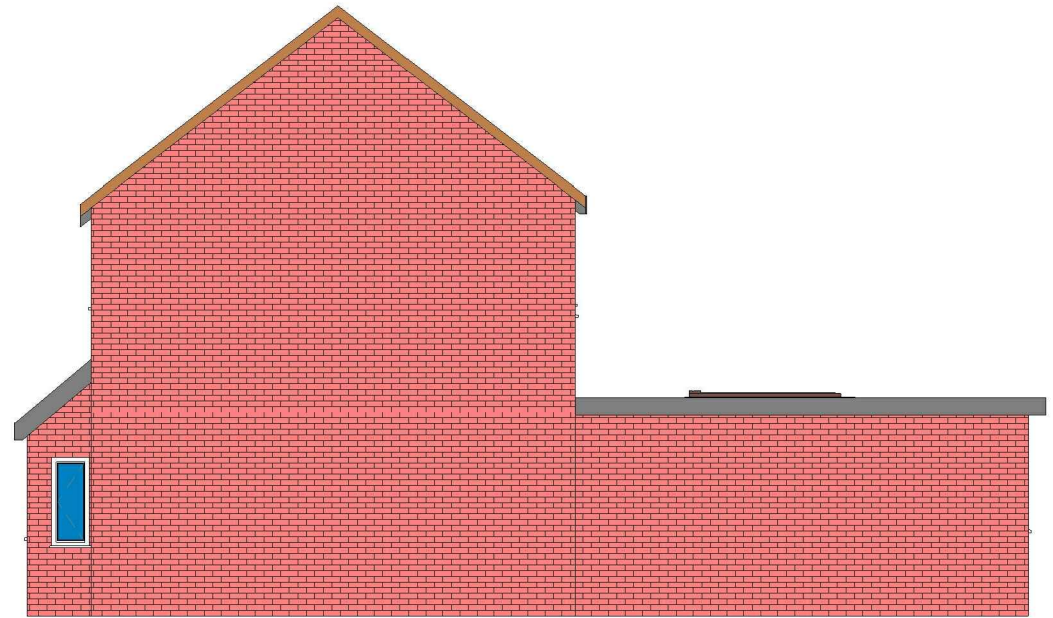

2 Existing Side 01_Elevation
1 : 100

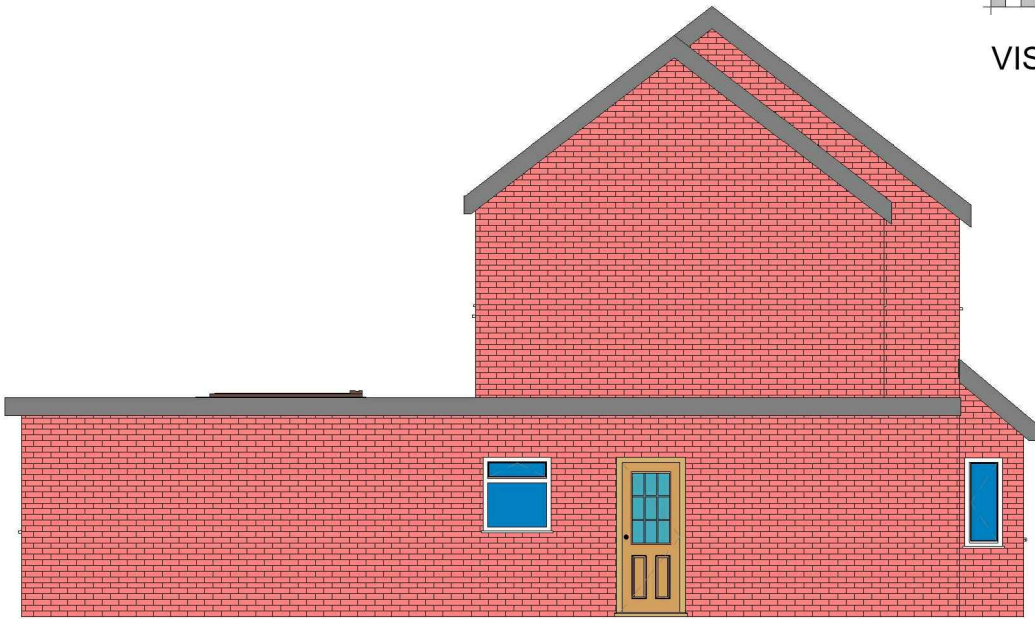

4 Existing Side 02_Elevation
1 : 100



3 Existing Front_Elevation
1 : 100

GENERAL NOTES:

1. ALL DIMENTIONS ARE IN MILLIMETER.
2. VERIFY ALL DIMENSIONS AND CONDITIONS BEFORE BUILDING OR STARTING CONSTRUCTION.
3. NOTIFY THE DESIGNER IMMEDIATELY OF ANY DISCREPANCY OR VARIATION.
4. ALL WORK TO COMPLY WITH CURRENT BUILDING REGULATIONS AND CODES OF PRACTICE.



Art @ Rooshika

NISARG@HOTMAIL.COM

+44 - 7951491310

PROJECT

58 Blackthorn Ave West Drayton UB7 9EX

SHEET

Existing Elevations

CLIENT

Ms B K Malhi

Date

Issue Date

Drawn by

Author

Checked by

Checker

Project number

Project Number


DRWAING NUMBER

A102

Scale (@ A3)

REV

C

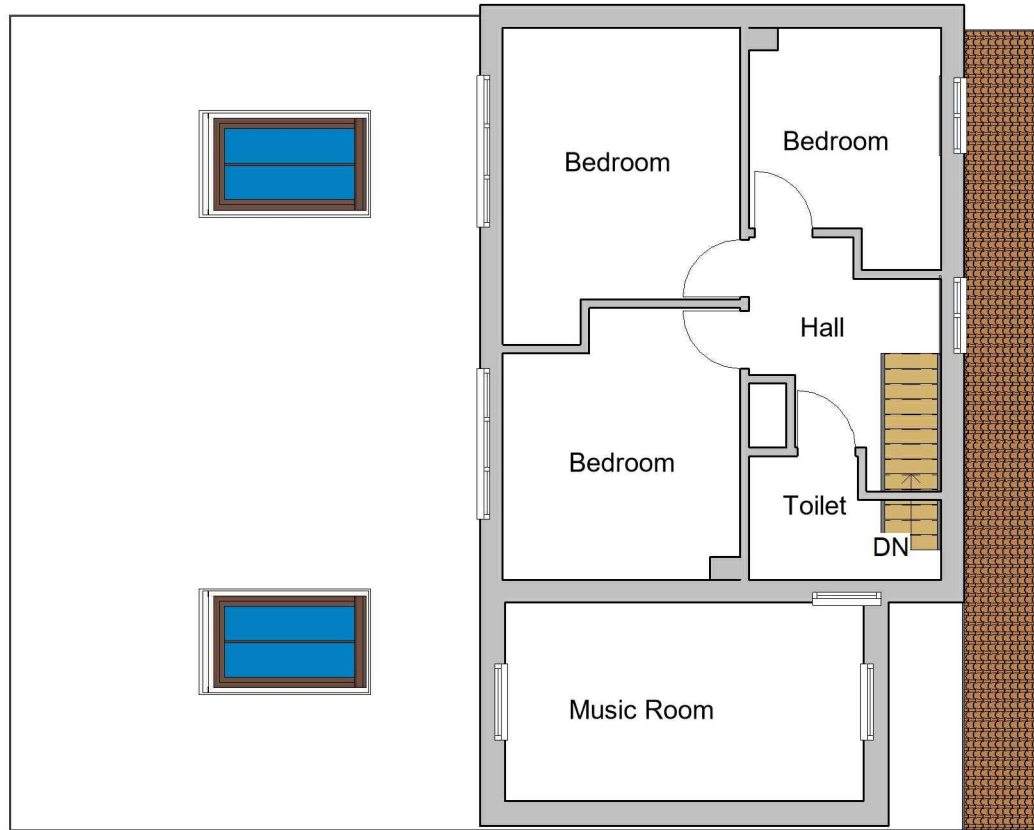

- Assembly Point
- Foam 6 litre foam spray
- Call Point

2 Existing First Floor

1 : 100


1 Proposed First Floor

1 : 75

- Fire Alarm System comply with BS 5839:Part 1:2017
- FIRE EXIT Fire Exit Sign Comply with BS 5499
- CM Carbon Monoxide Detector
- Extract Vent
- FD 30 Fire check doors 30 min fire resistance with smoke seal and self closing
- HD Heat Detector comply with BS 5466 2:2016
- Smoke alarm/detector to comply with BS EN14604
- EL Emergency lights To be Installed in Accordance with BS5266: 2016

The existing partitions forming the protected staircase must provide half-hour fire resistance. They must be lined with 12.5mm plasterboard and skim

The doors to Bedrooms and any habitable rooms and the final exit door must not be fitted with a key on the inside. Thumb turns are acceptable

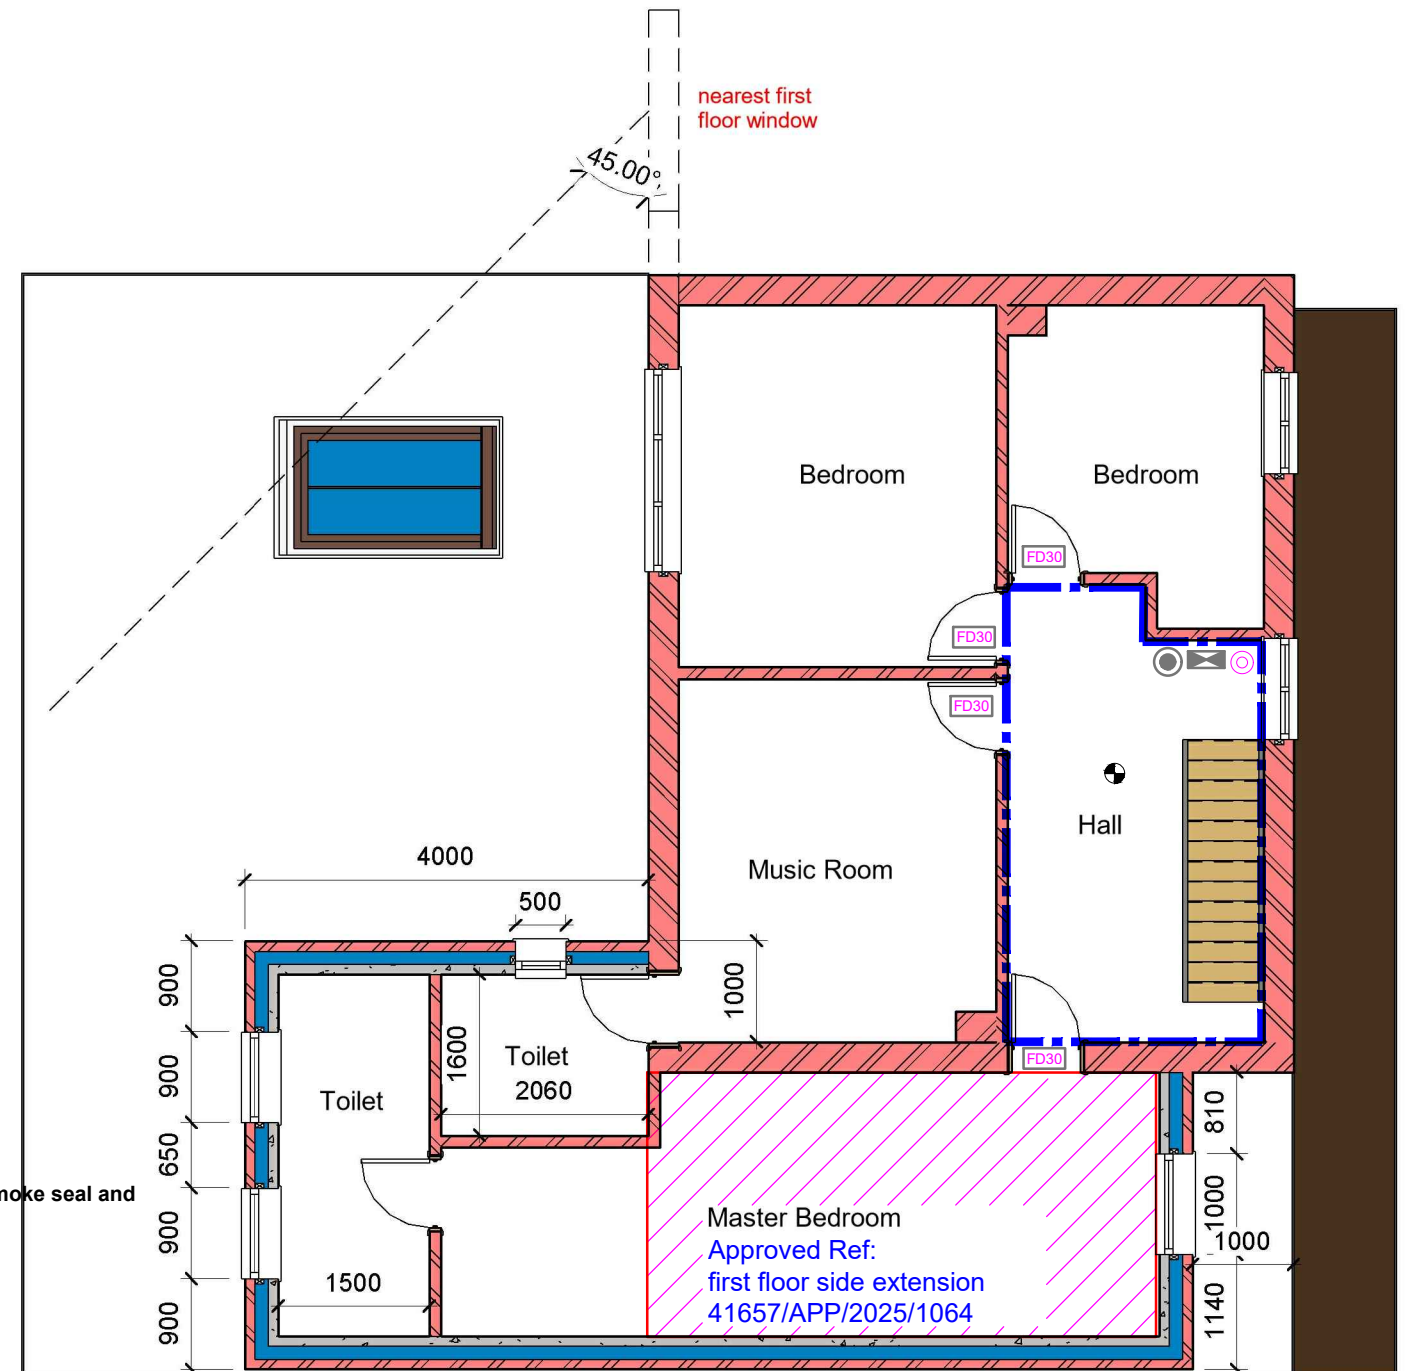

GENERAL NOTES:

- ALL DIMENTIONS ARE IN MILLIMETER.
- VERIFY ALL DIMENSIONS AND CONDITIONS BEFORE BUILDING OR STARTING CONSTRUCTION.
- NOTIFY THE DESIGNER IMMEDIATELY OF ANY DISCREPANCY OR VARIATION.
- ALL WORK TO COMPLY WITH CURRENT BUILDING REGULATIONS AND CODES OF PRACTICE.



NISARG@HOTMAIL.COM

+44 - 7951491310

PROJECT

58 Blackthorn Ave West Drayton UB7 9EX

SHEET

Existing & Proposed First Floor

CLIENT


Ms B K Malhi

Date	Project number	Scale (@ A3)
Issue Date	Project Number	
Drawn by	DRWAING NUMBER	
Author		
Checked by		
Checker		

A103

REV

C

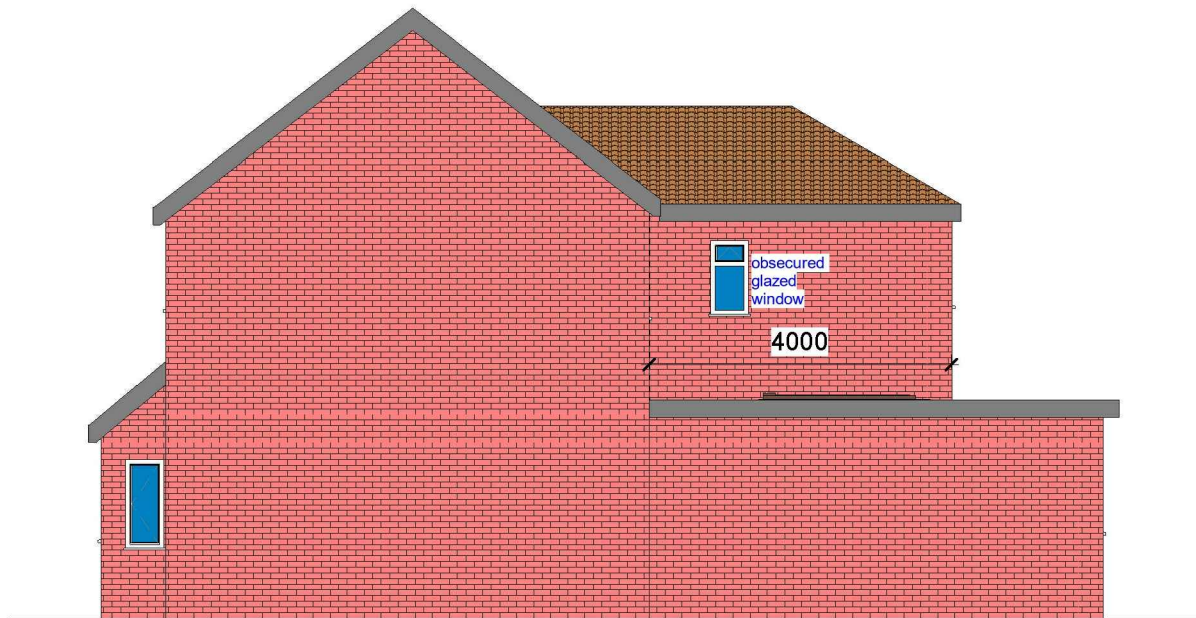


1 Proposed Side 01_Elevation
1 : 100




2 Proposed Rear_Elevation
1 : 100

 
ALL PROPOSED MATERIALS/FINISHED TO MATCH WITH EXISTING.



VISUAL SCALE 1:100 @ A3

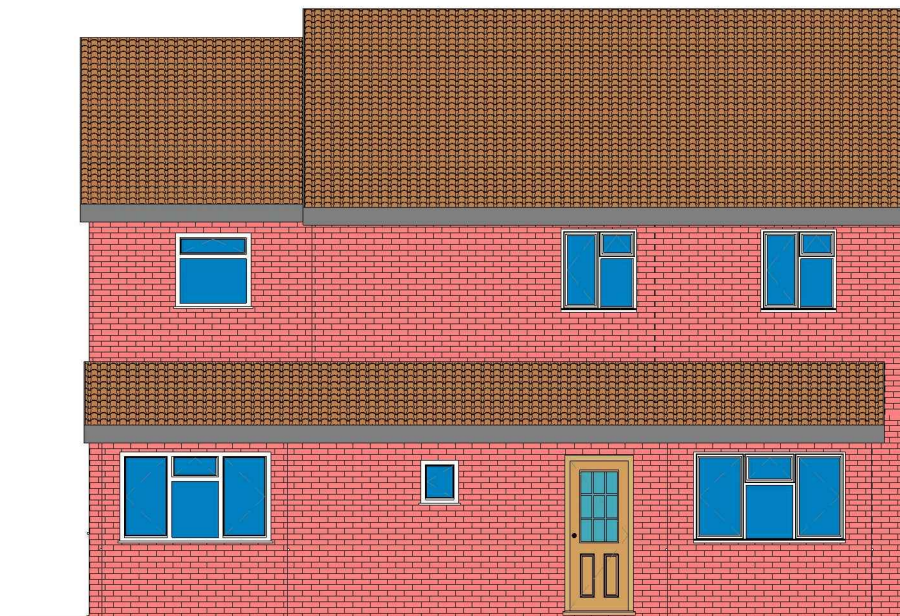

3 Proposed Front_Elevation
1 : 100

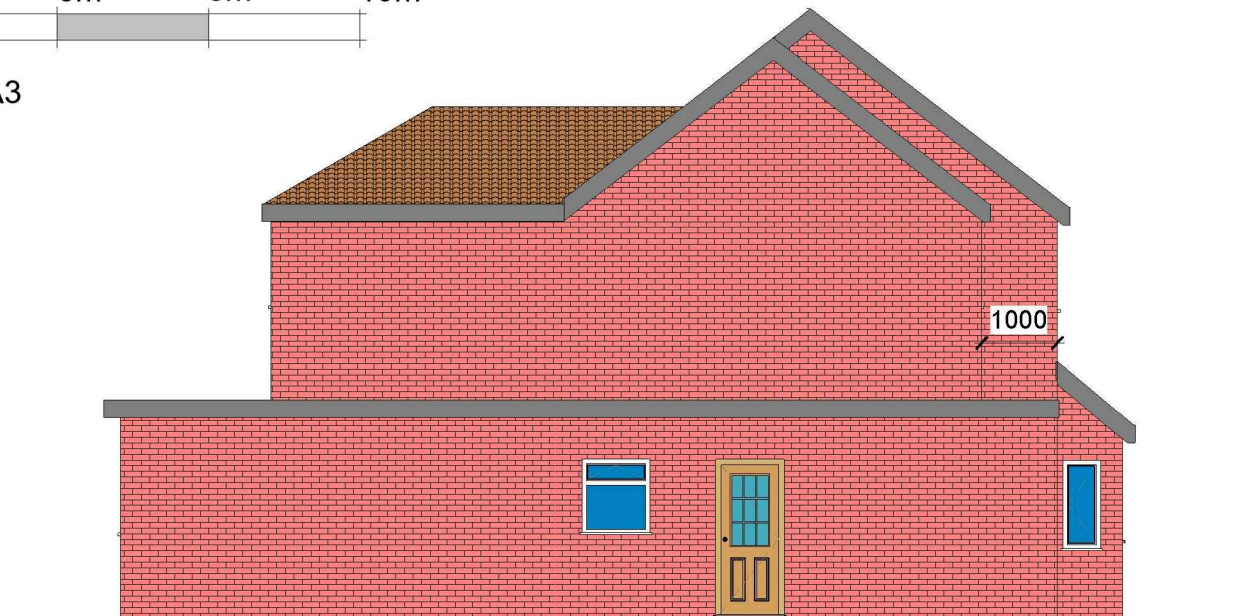

4 Proposed Side 02_Elevation
1 : 100

GENERAL NOTES:

1. ALL DIMENSIONS ARE IN MILLIMETER.
2. VERIFY ALL DIMENSIONS AND CONDITIONS BEFORE BUILDING OR STARTING CONSTRUCTION.
3. NOTIFY THE DESIGNER IMMEDIATELY OF ANY DISCREPANCY OR VARIATION.
4. ALL WORK TO COMPLY WITH CURRENT BUILDING REGULATIONS AND CODES OF PRACTICE.



Art @ Rooshika

NISARG@HOTMAIL.COM

+44 - 7951491310

PROJECT

58 Blackthorn Ave West Drayton UB7 9EX

SHEET

Proposed Elevations

CLIENT

Ms B K Malhi

Date

Issue Date

Drawn by

Author

Checked by

Checker

Project number

Project Number




DRWAING NUMBER

A104

Scale (@ A3)


REV

C

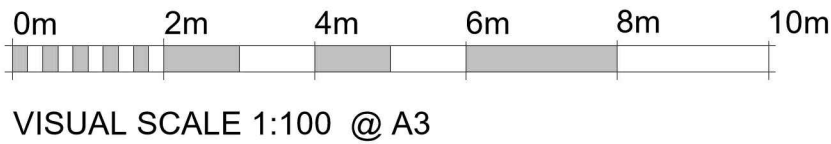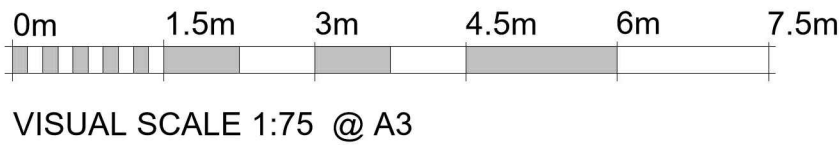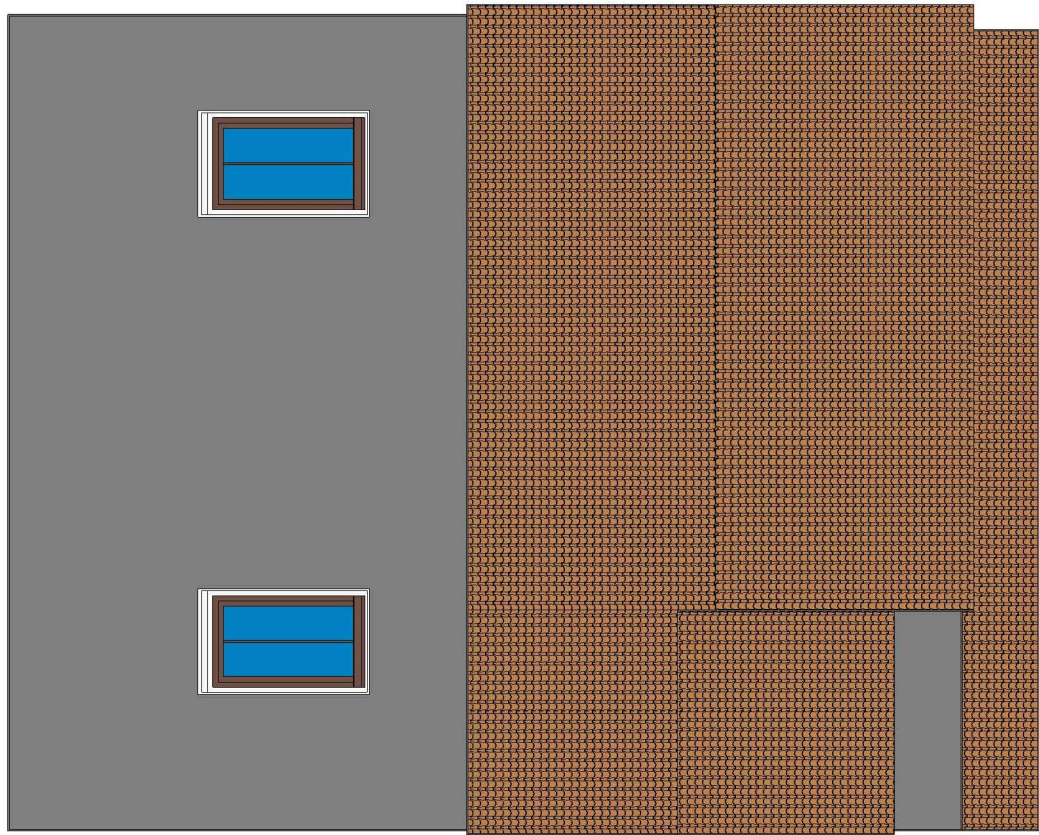

1 Existing Roof
1 : 100

2 Proposed Roof
1 : 75

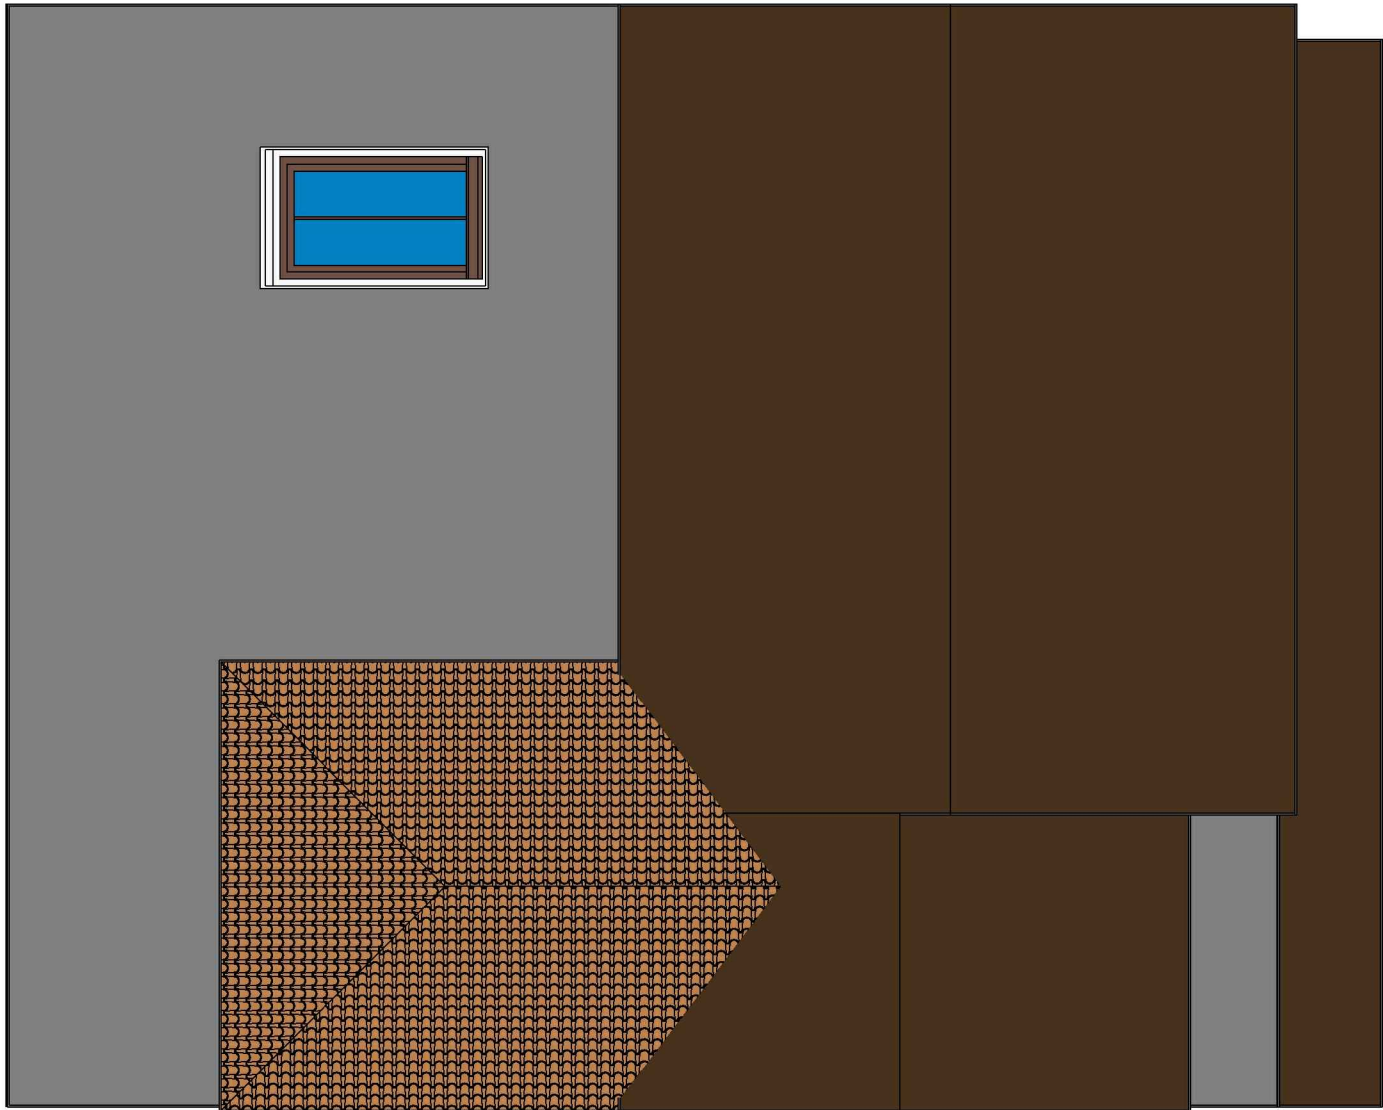

GENERAL NOTES:

1. ALL DIMENTIONS ARE IN MILLIMETER.
2. VERIFY ALL DIMENSIONS AND CONDITIONS BEFORE BUILDING OR STARTING CONSTRUCTION.
3. NOTIFY THE DESIGNER IMMEDIATELY OF ANY DISCREPANCY OR VARIATION.
4. ALL WORK TO COMPLY WITH CURRENT BUILDING REGULATIONS AND CODES OF PRACTICE.



Art @ Rooshika

NISARG@HOTMAIL.COM

+44 - 7951491310

PROJECT

58 Blackthorn Ave West Drayton UB7 9EX

SHEET

Existing & Proposed Roof Plan

CLIENT

Ms B K Malhi


Date
Issue Date
Drawn by
Author
Checked by
Checker

Project number
Project Number
DRWAING NUMBER
A105


Scale (@ A3)

REV

C

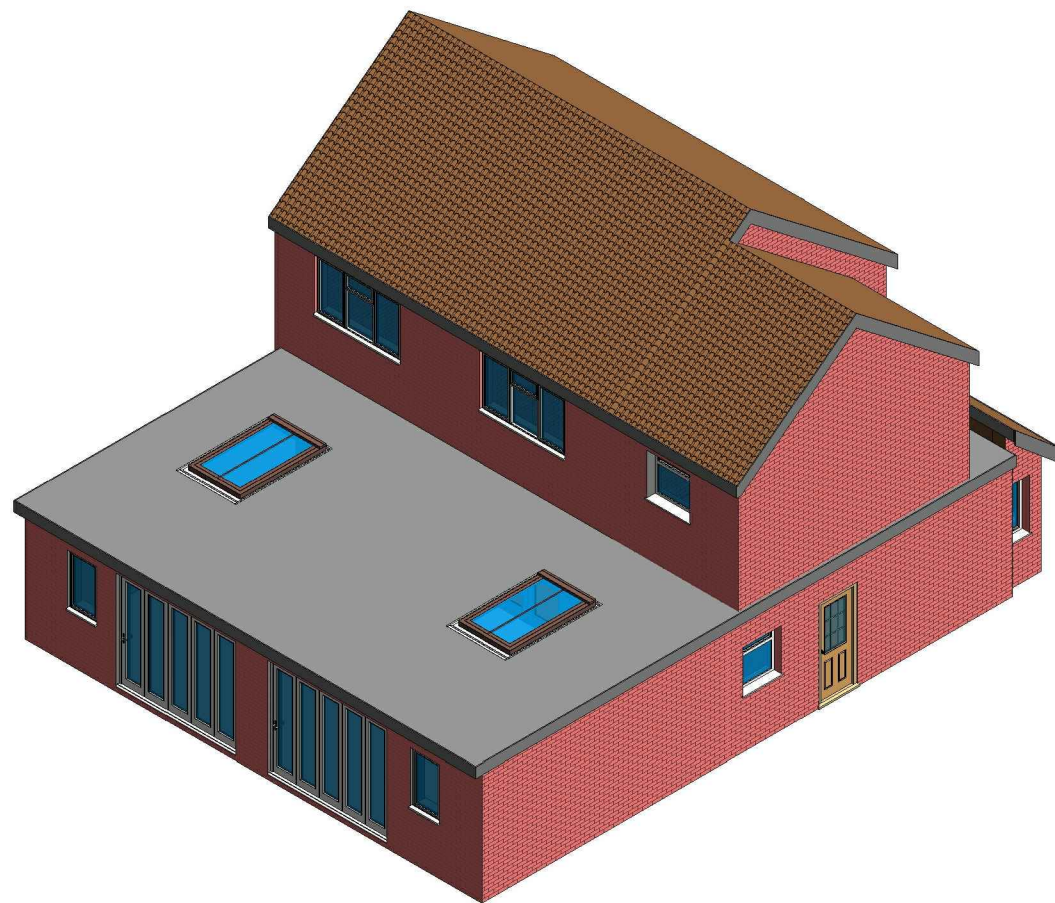

1 3D View 02 Existing

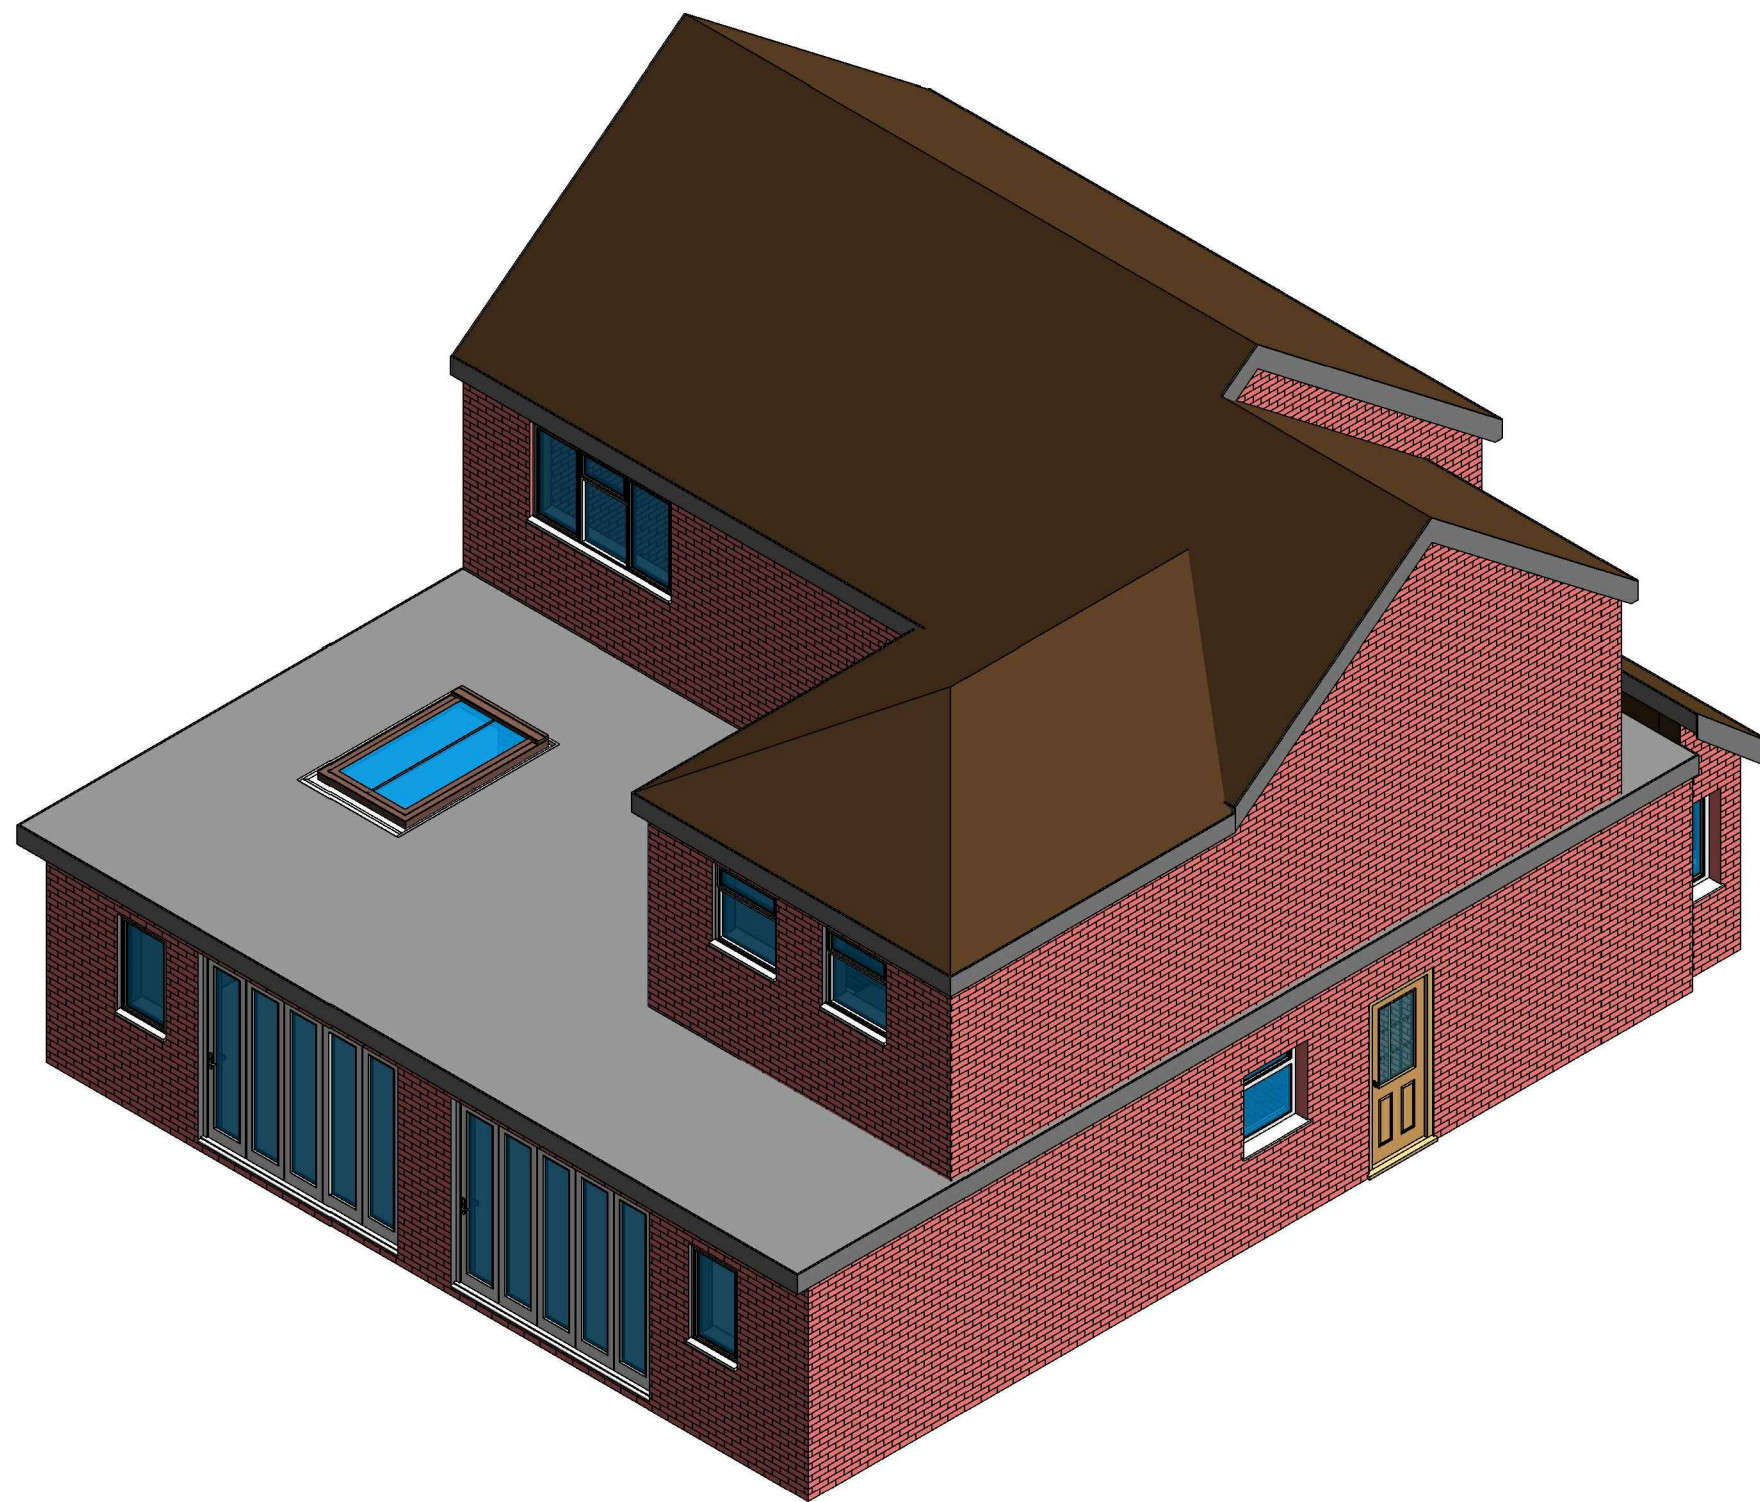

2 3D View 03 Proposed

GENERAL NOTES:

1. ALL DIMENTIONS ARE IN MILLIMETER.
2. VERIFY ALL DIMENSIONS AND CONDITIONS BEFORE BUILDING OR STARTING CONSTRUCTION.
3. NOTIFY THE DESIGNER IMMEDIATELY OF ANY DISCREPANCY OR VARIATION.
4. ALL WORK TO COMPLY WITH CURRENT BUILDING REGULATIONS AND CODES OF PRACTICE.



Art @ Rooshika

NISARG@HOTMAIL.COM

+44 - 7951491310

PROJECT

58 Blackthorn Ave West Drayton UB7 9EX

SHEET

Existing & Proposed 3D View

CLIENT

Ms B K Malhi

Date	Project number	Scale (@ A3)
Issue Date	Project Number	
Drawn by	DRWAING NUMBER	
Author	A106	
Checked by		
Checker		

REV

C