


NOTES

GENERAL

1. ALL DIMENSIONS ARE IN MILLIMETRES UNLESS NOTED OTHERWISE.
2. ALL LEVELS RELATE TO ORDNANCE DATUM UNLESS NOTED OTHERWISE.
3. DO NOT SCALE FROM THIS DRAWING. USE FIGURED DIMENSIONS ONLY.
4. ANY DISCREPANCIES TO BE REPORTED IMMEDIATELY TO THE ENGINEER.
5. THIS DRAWING TO BE READ IN CONJUNCTION WITH ALL RELEVANT ARCHITECTS, SUBCONTRACTORS AND SPECIALISTS DRAWINGS AND SPECIFICATIONS.
6. THIS DRAWING IS COPYRIGHT © PROPERTY OF SHEAR DESIGN LIMITED.

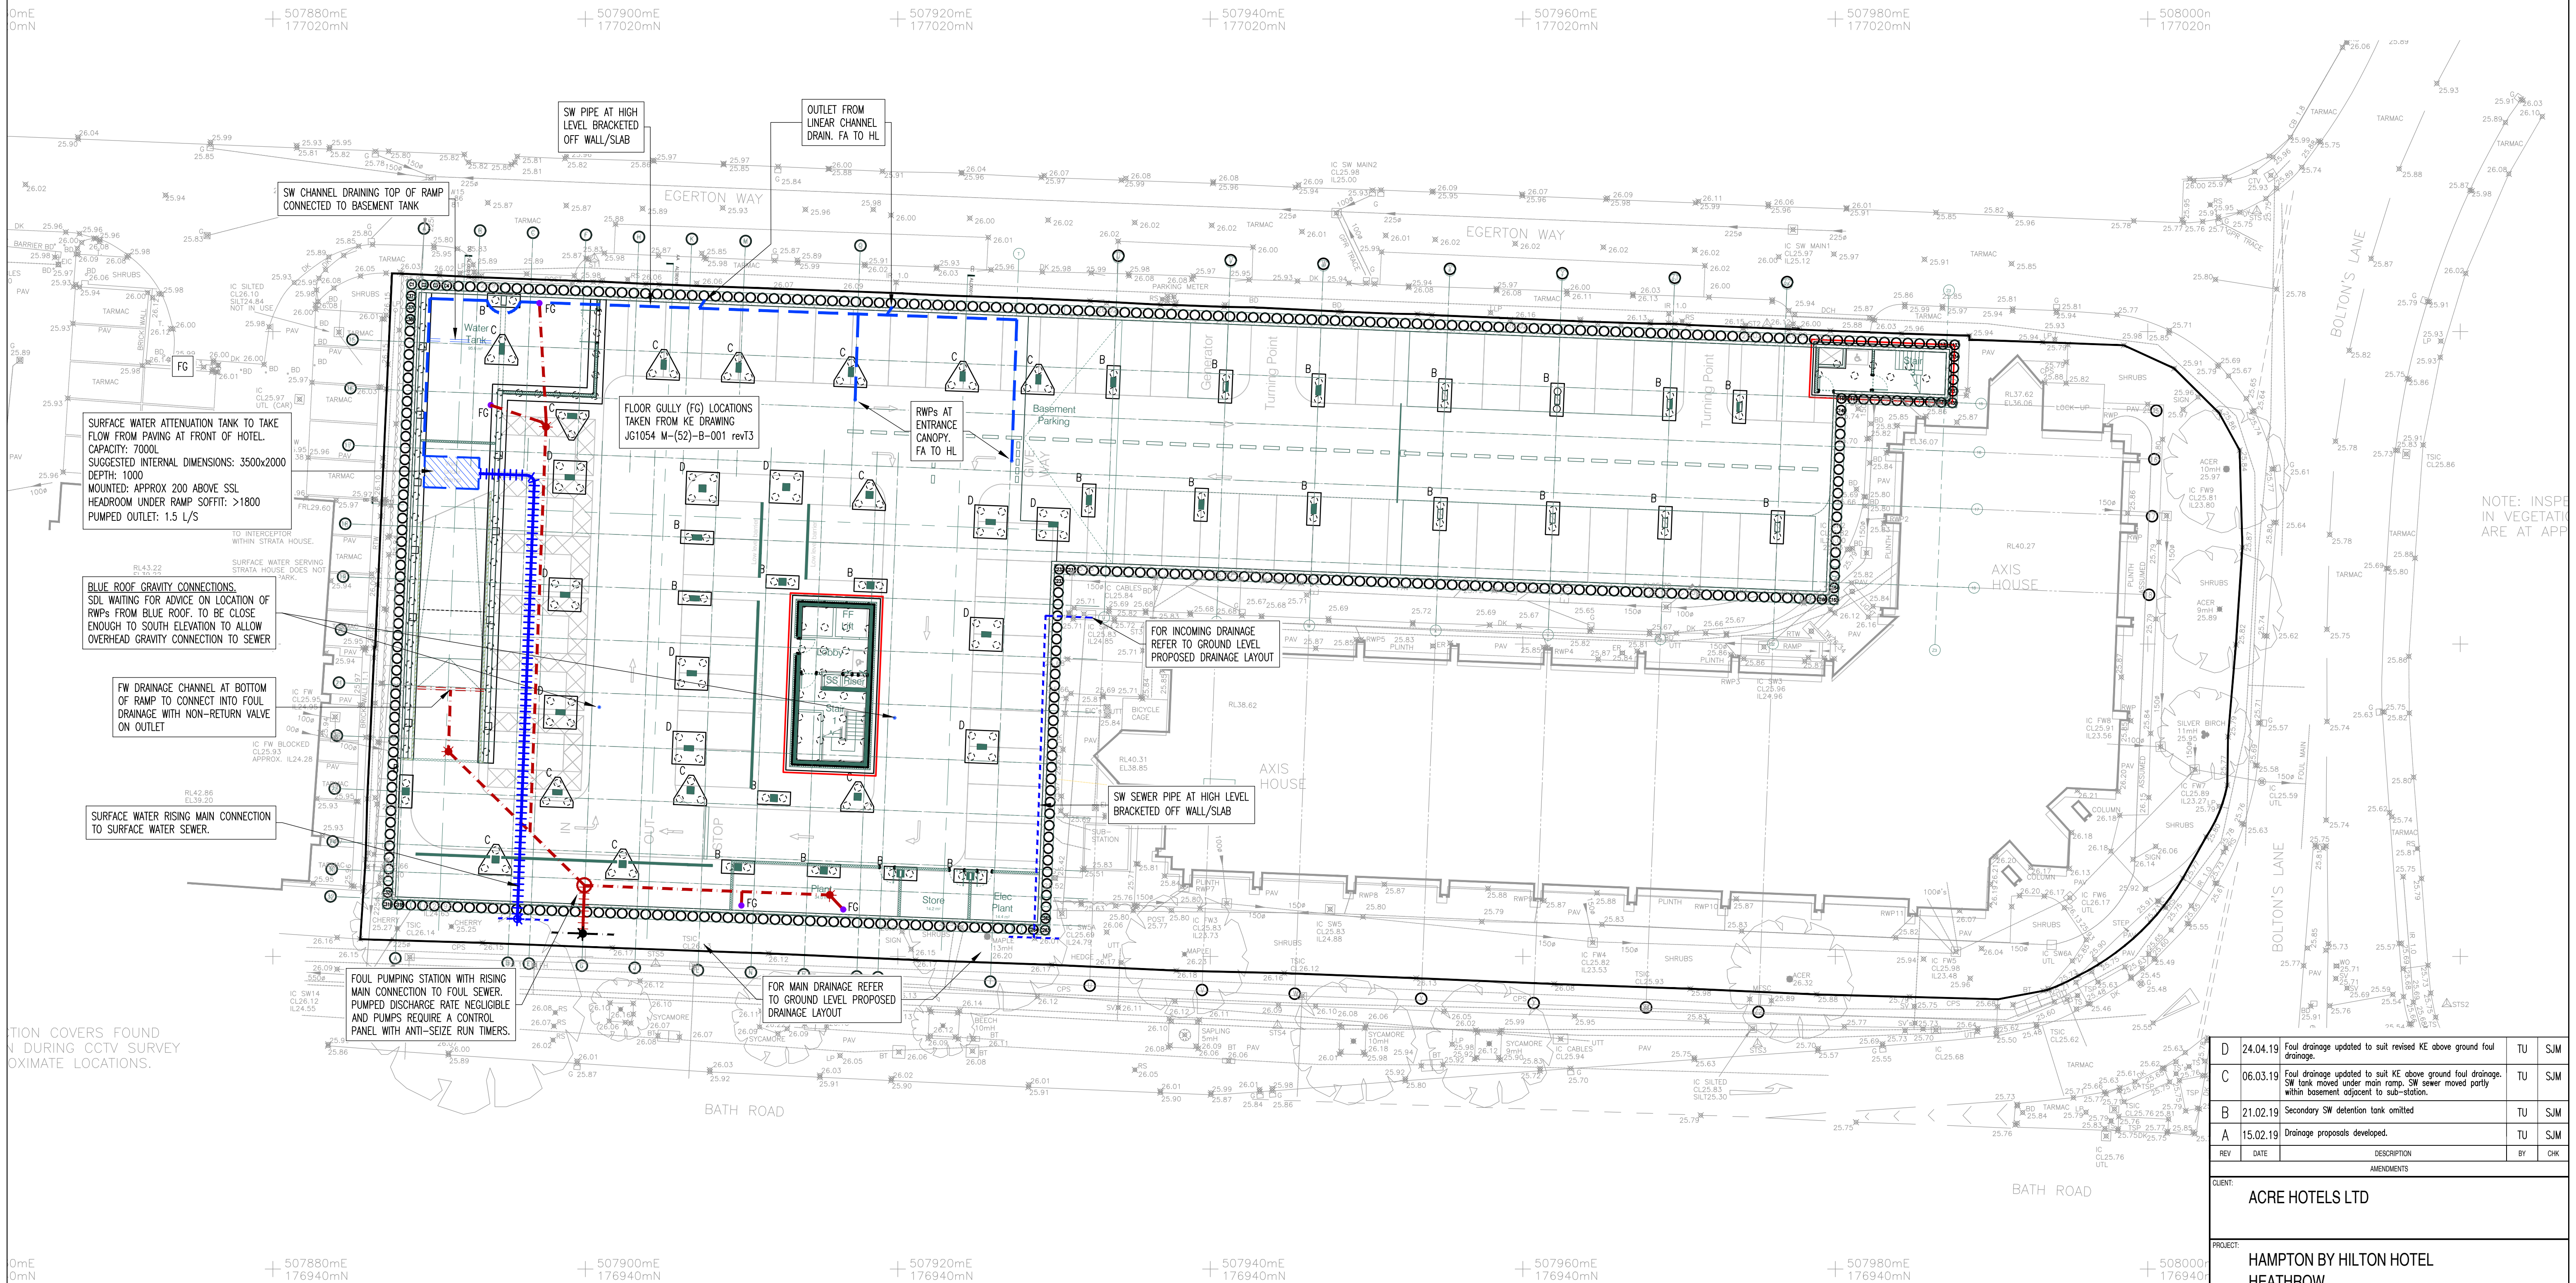

NOTE: INSPECTION ARE AT APP

D	24.04.19	Foul drainage updated to suit revised KE above ground foul drainage.	TU	SJM
C	06.03.19	Foul drainage updated to suit KE above ground foul drainage. SW tank moved under main ramp. SW sewer moved partly within basement adjacent to sub-station.	TU	SJM
B	21.02.19	Secondary SW detention tank omitted	TU	SJM
A	15.02.19	Drainage proposals developed.	TU	SJM
REV	DATE	DESCRIPTION	BY	CHK

CLIENT:	ACRE HOTELS LTD
PROJECT:	HAMPTON BY HILTON HOTEL HEATHROW
TITLE:	PROPOSED DRAINAGE LAYOUT BASEMENT LEVEL



Consulting Civil and Structural Engineers

7 Ashtree Court - Woody Close - Cardiff Gate Business Park - Cardiff - CF23 8RW
Tel: 029 2054 7000 - Fax: 029 2054 7001 - www.shear-design.com - enquiries@shear-design.com

DRAWN:	TU	CHECKED:	SJM	DATE:	JAN 2019	SCALE:	1:200 @ A1
STATUS KEY:	I = INFORMATION	P = PRELIMINARY	A = APPROVAL	CO = CONTRACT	TENDER	AB = AS-BUILT	REVISION
STATUS:	T	DRAWING NUMBER:	16084-113	REVISION:	D		