


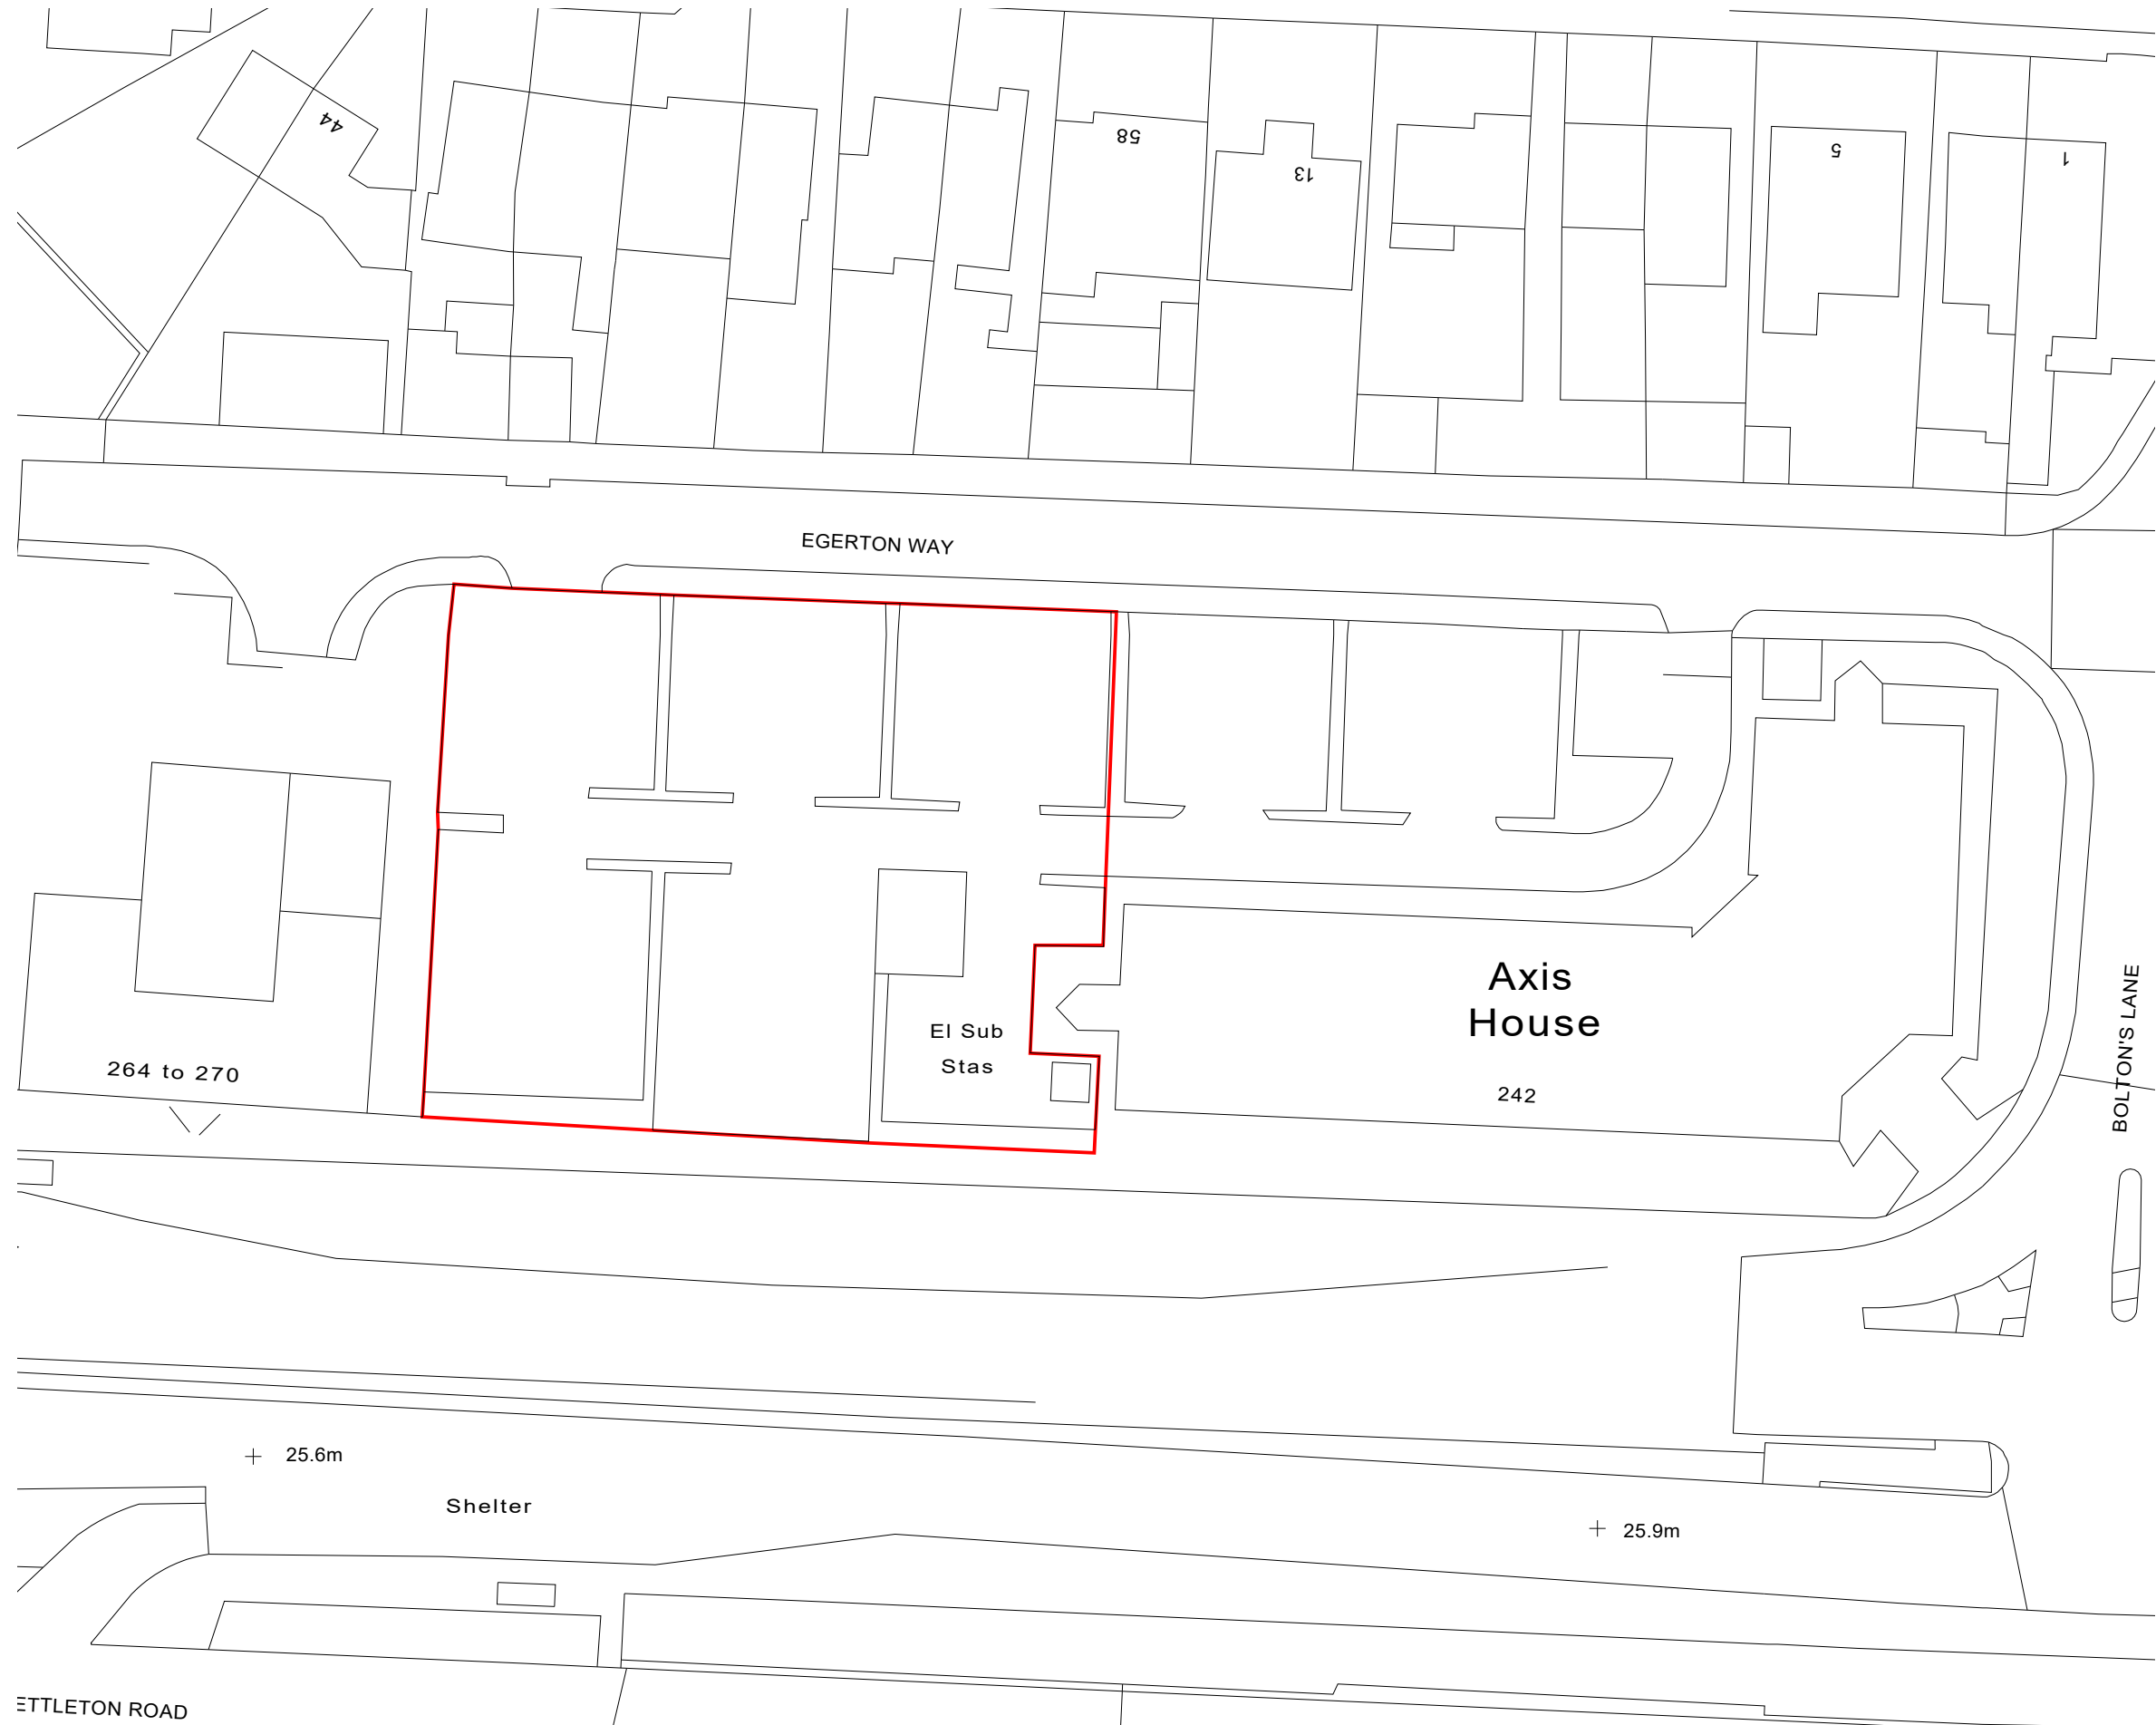


Rev	Date	Description

**Fluent**[®]
ARCHITECTURAL DESIGN SERVICES

FLUENT
ARCHITECTURAL DESIGN SERVICES
69-71 WINDMILL ROAD, SUNBURY,
MIDDLESEX, TW15 7DT
TEL: 0800 0438838
E-MAIL: INFO@FLUENT-ADS.CO.UK
WEB: FLUENT-ADS.CO.UK

Bath Road, Heathrow

 Existing Site Plan



Scale 1:500 @ A3	Dwg No. FLU.1347.02
Date 07.11.20	Rev A
Drawn N.Millin	