


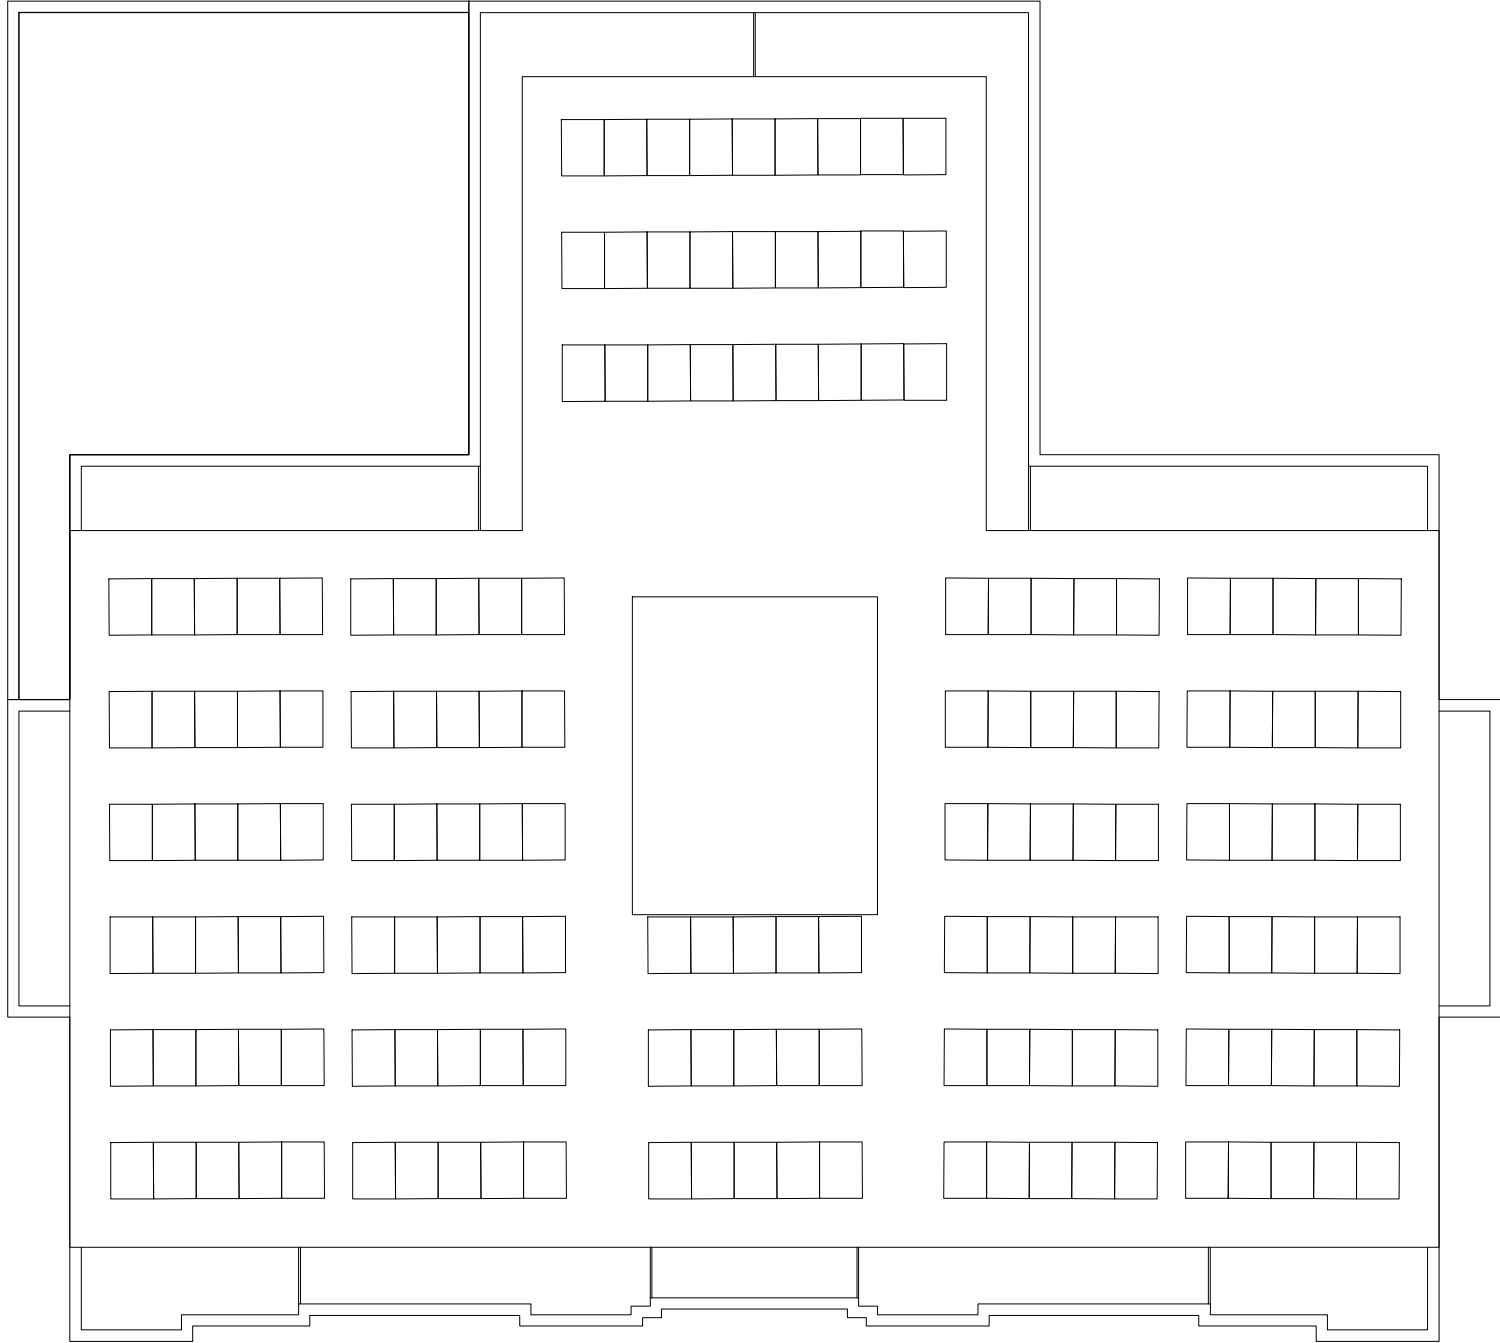

Rev	Date	Description

 


FLUENT
ARCHITECTURAL DESIGN SERVICES

69-71 WINDMILL ROAD, SUNBURY,
MIDDLESEX, TW16 7DT
TEL: 0800 0438838
E-MAIL: INFO@FLUENT-ADS.CO.UK
WEB: FLUENT-ADS.CO.UK

Bath Road, Heathrow

Proposed Roof Plan



--

Scale 1:200 @ A3	Dwg No. FLU.1347.13
Date 07.11.20	Rev
Drawn N.Millin	B