
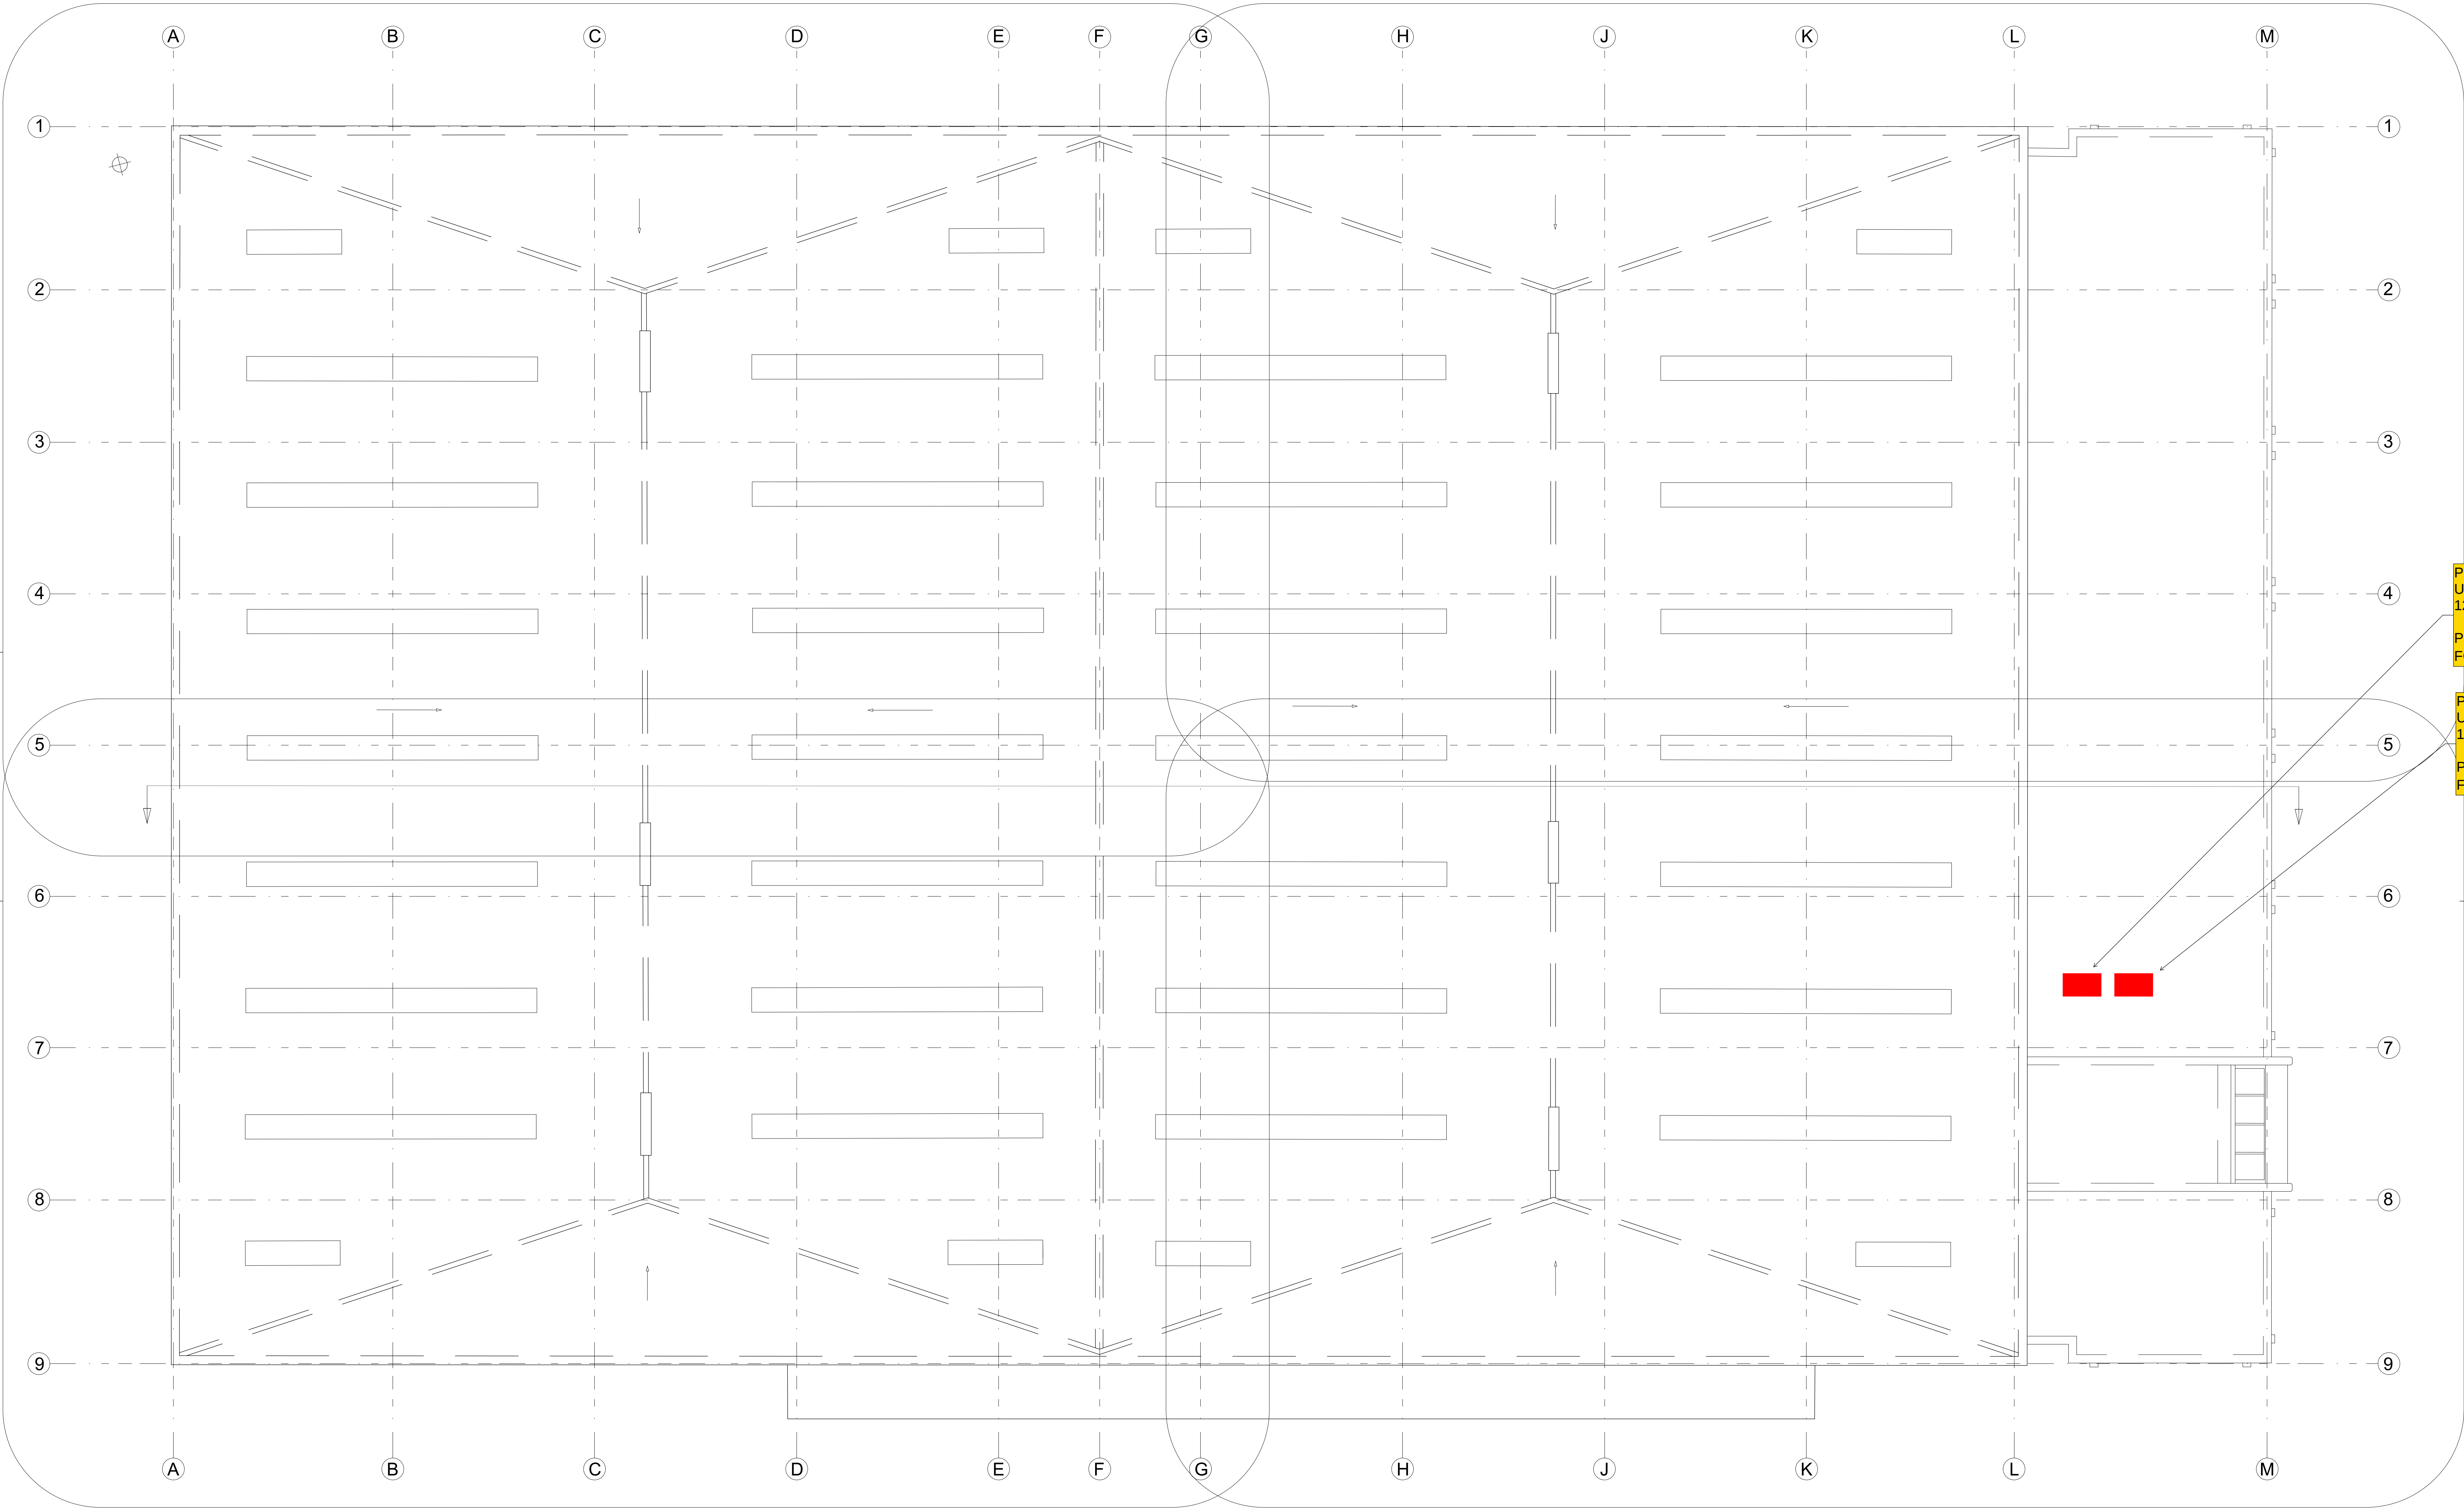


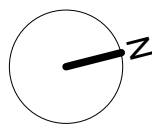

PROPOSED AC CONDENSER
UNIT
1240x740x1858H, 275kg
POSITIONED ON NEW 'BIG
FOOT' SUPPORT SYSTEM
013

PROPOSED AC CONDENSER
UNIT
1240x740x1858H, 275kg
POSITIONED ON NEW 'BIG
FOOT' SUPPORT SYSTEM
012

Rev.	Description	Date	Check by
1.	Do not scale this drawing. The Contractor is to verify all dimensions & conditions on site and report any discrepancies to the Architect before proceeding.		
2.	This drawing is to be read in conjunction with all relevant project documentation.		
3.	This drawing is subject to the approval of the appropriate Statutory Authorities.		

PERSEVERANCE ARCHITECTS
PERSEVERANCE ARCHITECTS LTD
The Bree Eagle House
163 City Road
London EC1Y 1NR
+44 (0) 20 3773 8880
mail@perseverancearchitects.co.uk
www.perseverancearchitects.co.uk

Project:
**UNIT 5 SWALLOWFIELD WAY
HAYES
UB3 1DQ**

Title:
**ROOF PLAN 01
PROPOSED LAYOUT**

Scale: 1:100 @AO Date: 07 04 26

Drawn by: MF Checked by: MW

Drawing No.: 2602_220_011 Revision: /

Status:
INFORMATION
©PERSEVERANCE ARCHITECTS LTD