



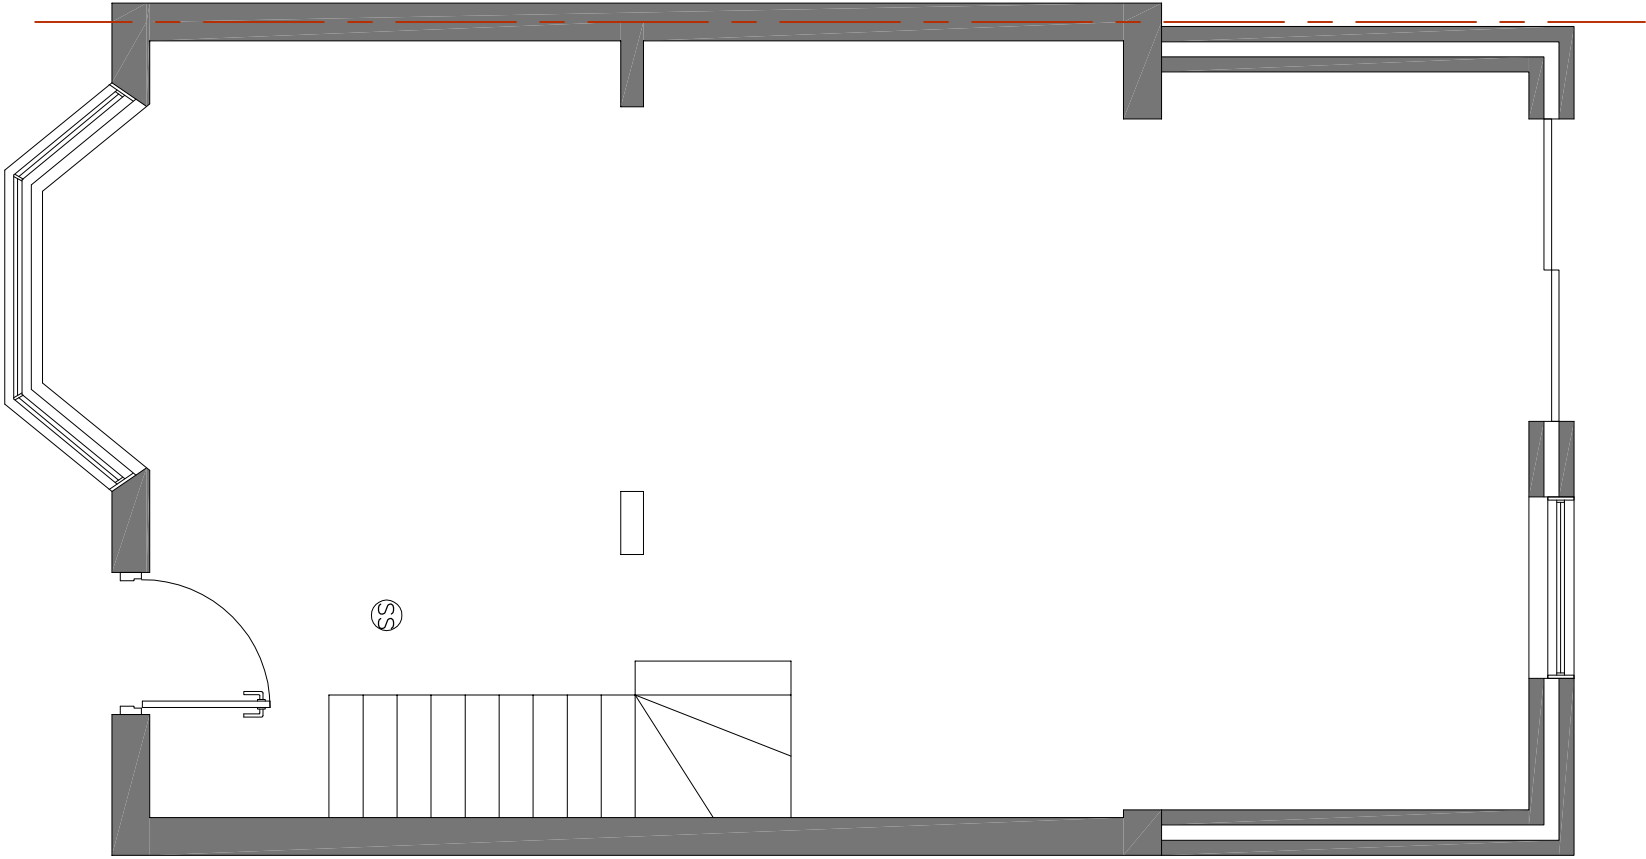

PROPOSED GROUND FLOOR PLAN


SCALE 1:50

- S9 Domestic sprinkler system only in the living room area only. (To be design, detail, installed & maintain by specialist sprinkler system contractor.)
- FD30 Door to be 1/2 hour fire resistant self closing FD30 with 25mm min. rebates.
- S9 Position of mains operated interconnected smoke alarms to BS 5446:Part 1:1990 to circulation areas at all levels, as required by Approved document Part B

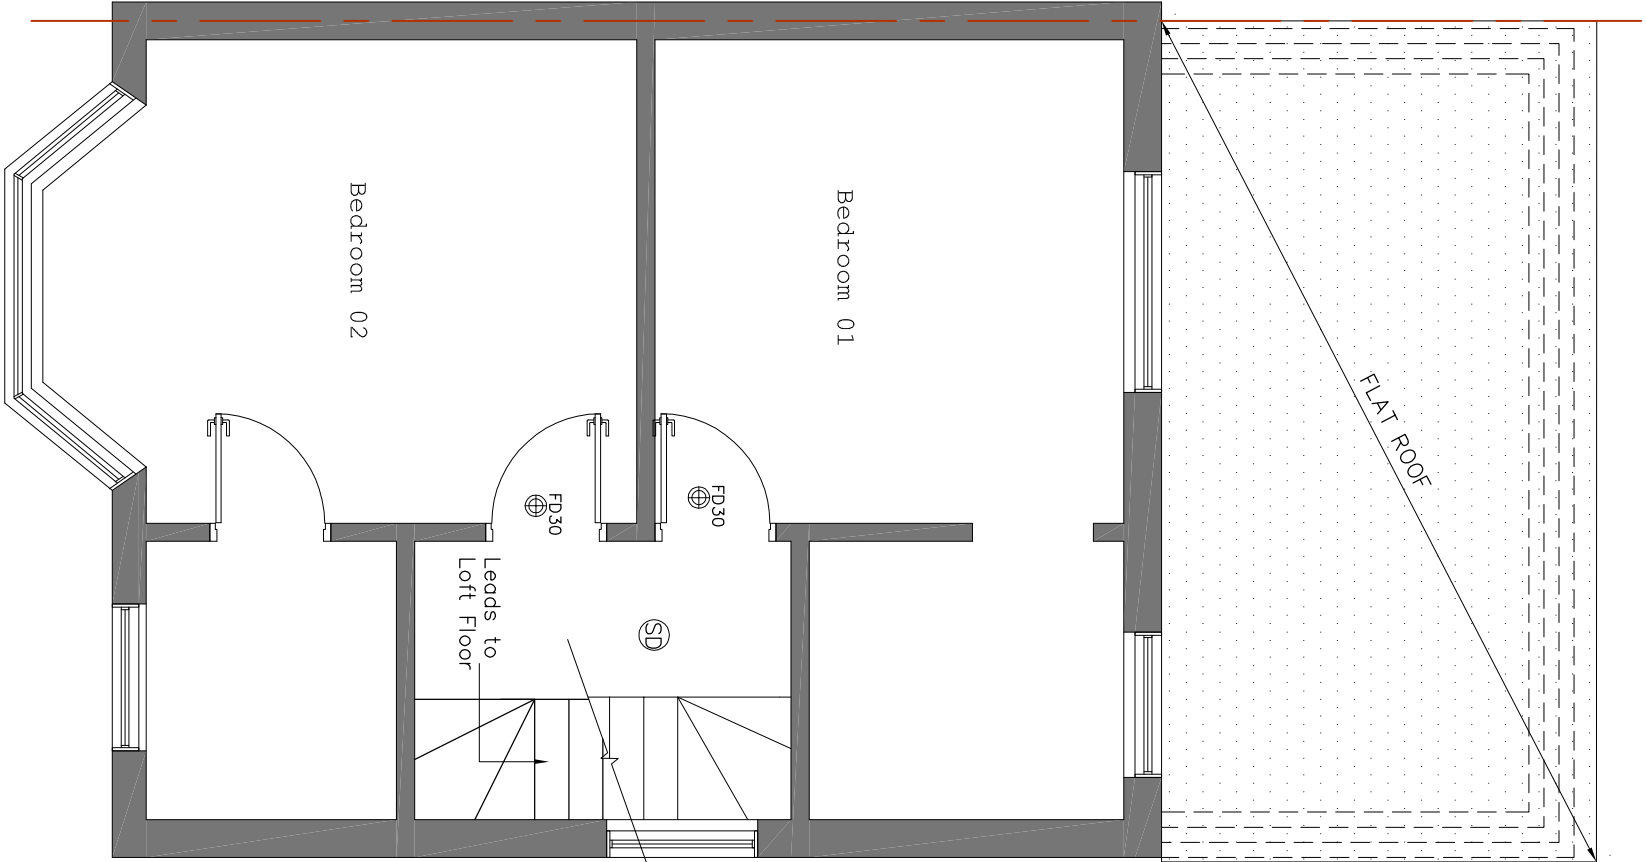


PROPOSED FIRST FLOOR PLAN

SCALE 1:50

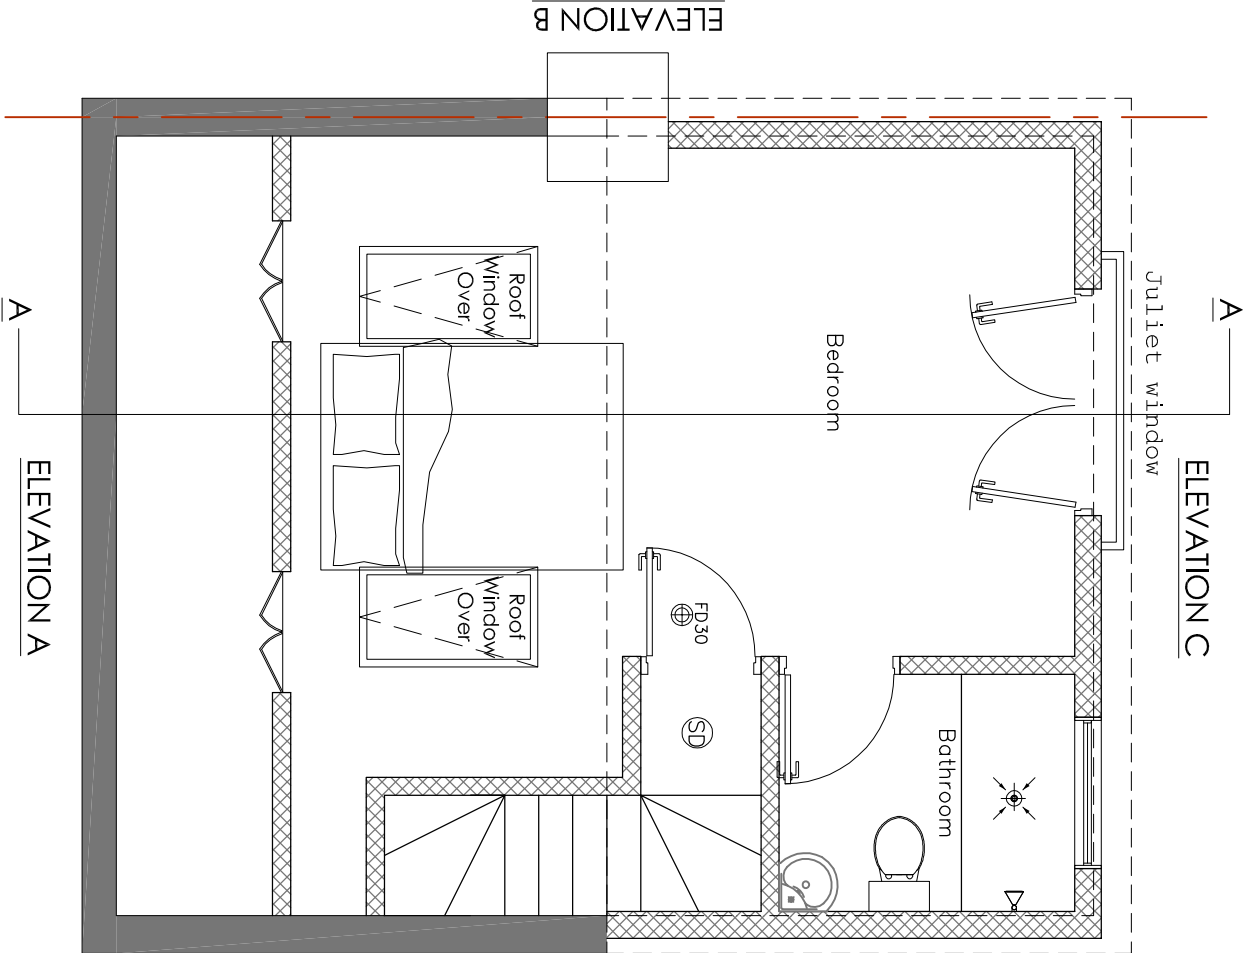


PROPOSED LOFT FLOOR PLAN

SCALE 1:50

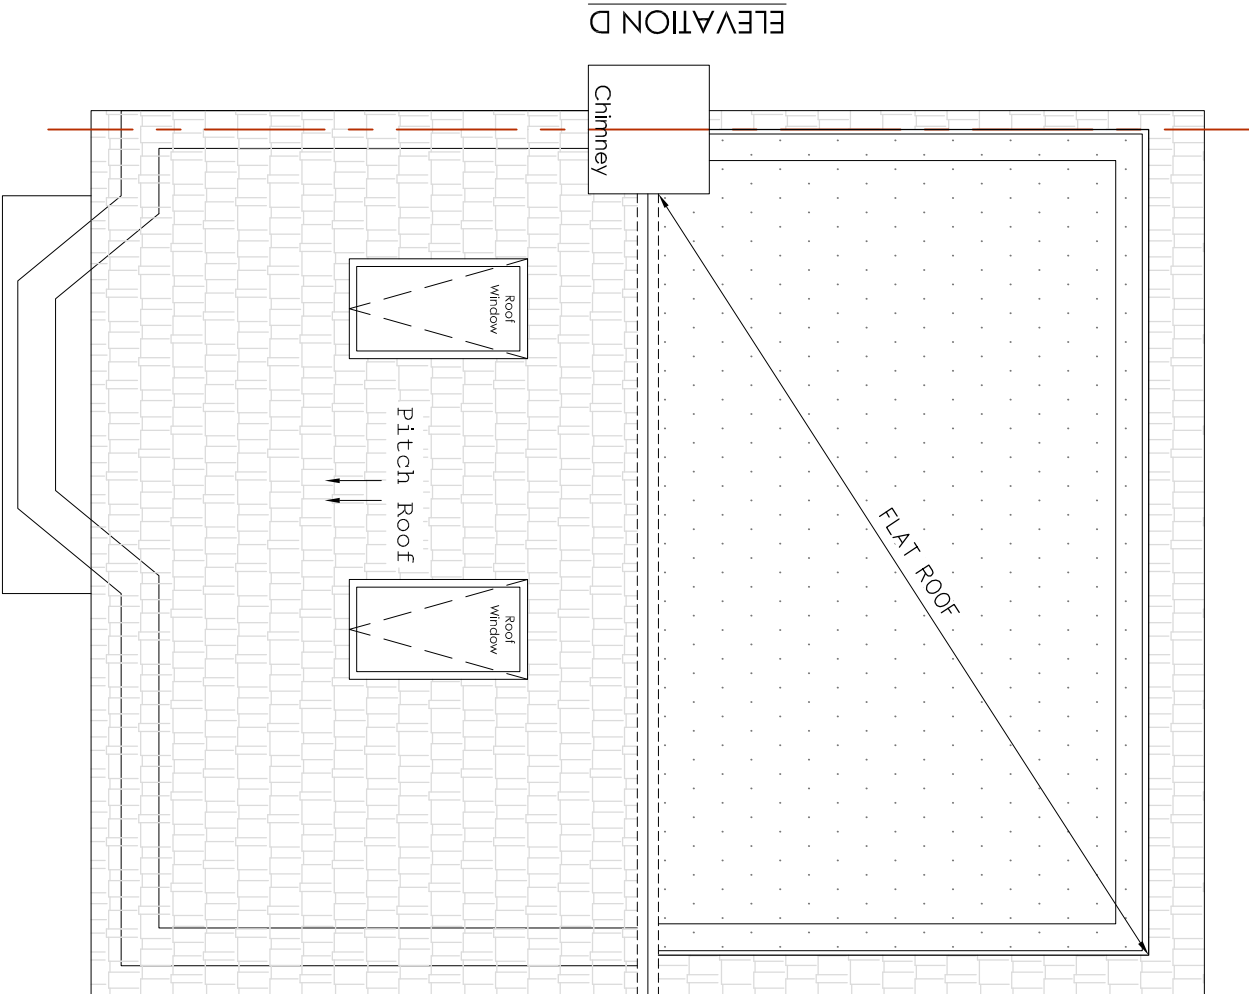

PROPOSED ROOF PLAN

 SCALE 1:50



Do not scale off the drawings (scale only for planning purposes).

 www.mdaltbydesign.com 02037 462 100 074 6610 3263		ARCH./CLIENT		Drawn BC	
Project Title 28 BERKELEY ROAD UXBRIDGE UB10 9DX		Drawing Title PROPOSED FLOOR AND ROOF PLANS		Checked	
Drawing Title PROPOSED FLOOR AND ROOF PLANS		Scale 1:50		Size A2	
Project No. 2222		Drawing No. D-02		Rev. —	

Demolition line