


- Mini AC Cassette Unit
- 3 No. Ducted AC Units
- 600x600 Kitchen Extract To Above
- Ø200 General Extract To Above
- Ø200 WC Extract To Above
- 600x600 Supply From Above

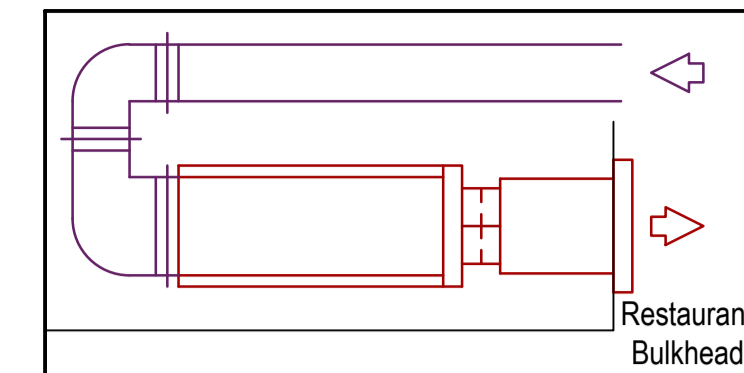

Return Air Section

No.	Date	Rev. By	Revision Description
A	04/03/26	JJ	AC relocated

Client: **Nando's**

Project:  
Nandos,  
Lombardy Retail Park,  
Hayes,  
UB3 3EX

Drawing Title:  
Proposed Ground Floor  
HVAC Layout

Drawing No.:	Rev:
002-321-01	A
Scale: 1:50 @ A1 1:100 @ A3	
Drawn By: JJ	Date: 24/02/26

**chapman ventilation**  
 15-20 Woodfield Road, Welwyn Garden City  
 Hertfordshire AL7 1JQ  
 Tel: 01707 372658 Fax: 01707 325001  
 E-mail: info@chapmanventilation.co.uk  
 Web: www.chapmanventilation.co.uk

Copyright of this drawing resides with Chapman Ventilation Limited ©

