

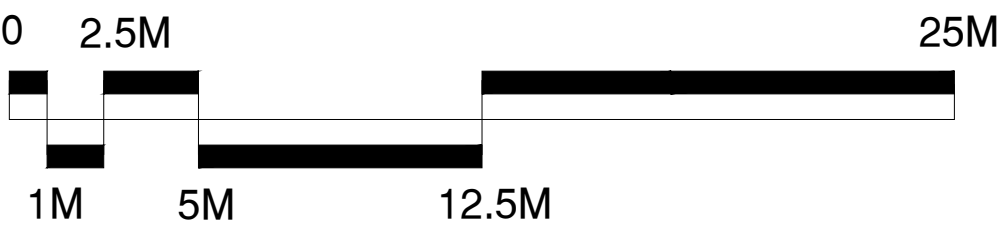


Uxbridge FC
Artificial Turf Pitch

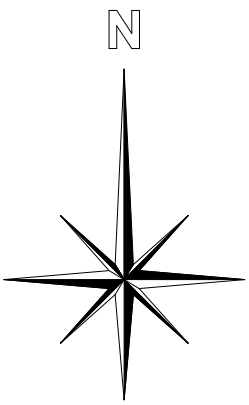


CONSULTANTS
Surfacing Standards LTD
Surfacing Standards Ltd
Surfacing Standards Ltd
01582 400 012

1. DO NOT SCALE FROM DRAWING. ALL DIMENSIONS TO BE CHECKED ON SITE PRIOR TO COMMENCEMENT OF WORKS.
2. THIS DRAWING IS COPYRIGHT TO SURFACING STANDARDS LTD.
3. ALL PERSONNEL SHOULD BE AWARE OF THE HEALTH AND SAFETY PLAN WHICH IS RETAINED IN THE SITE MANAGERS OFFICE.

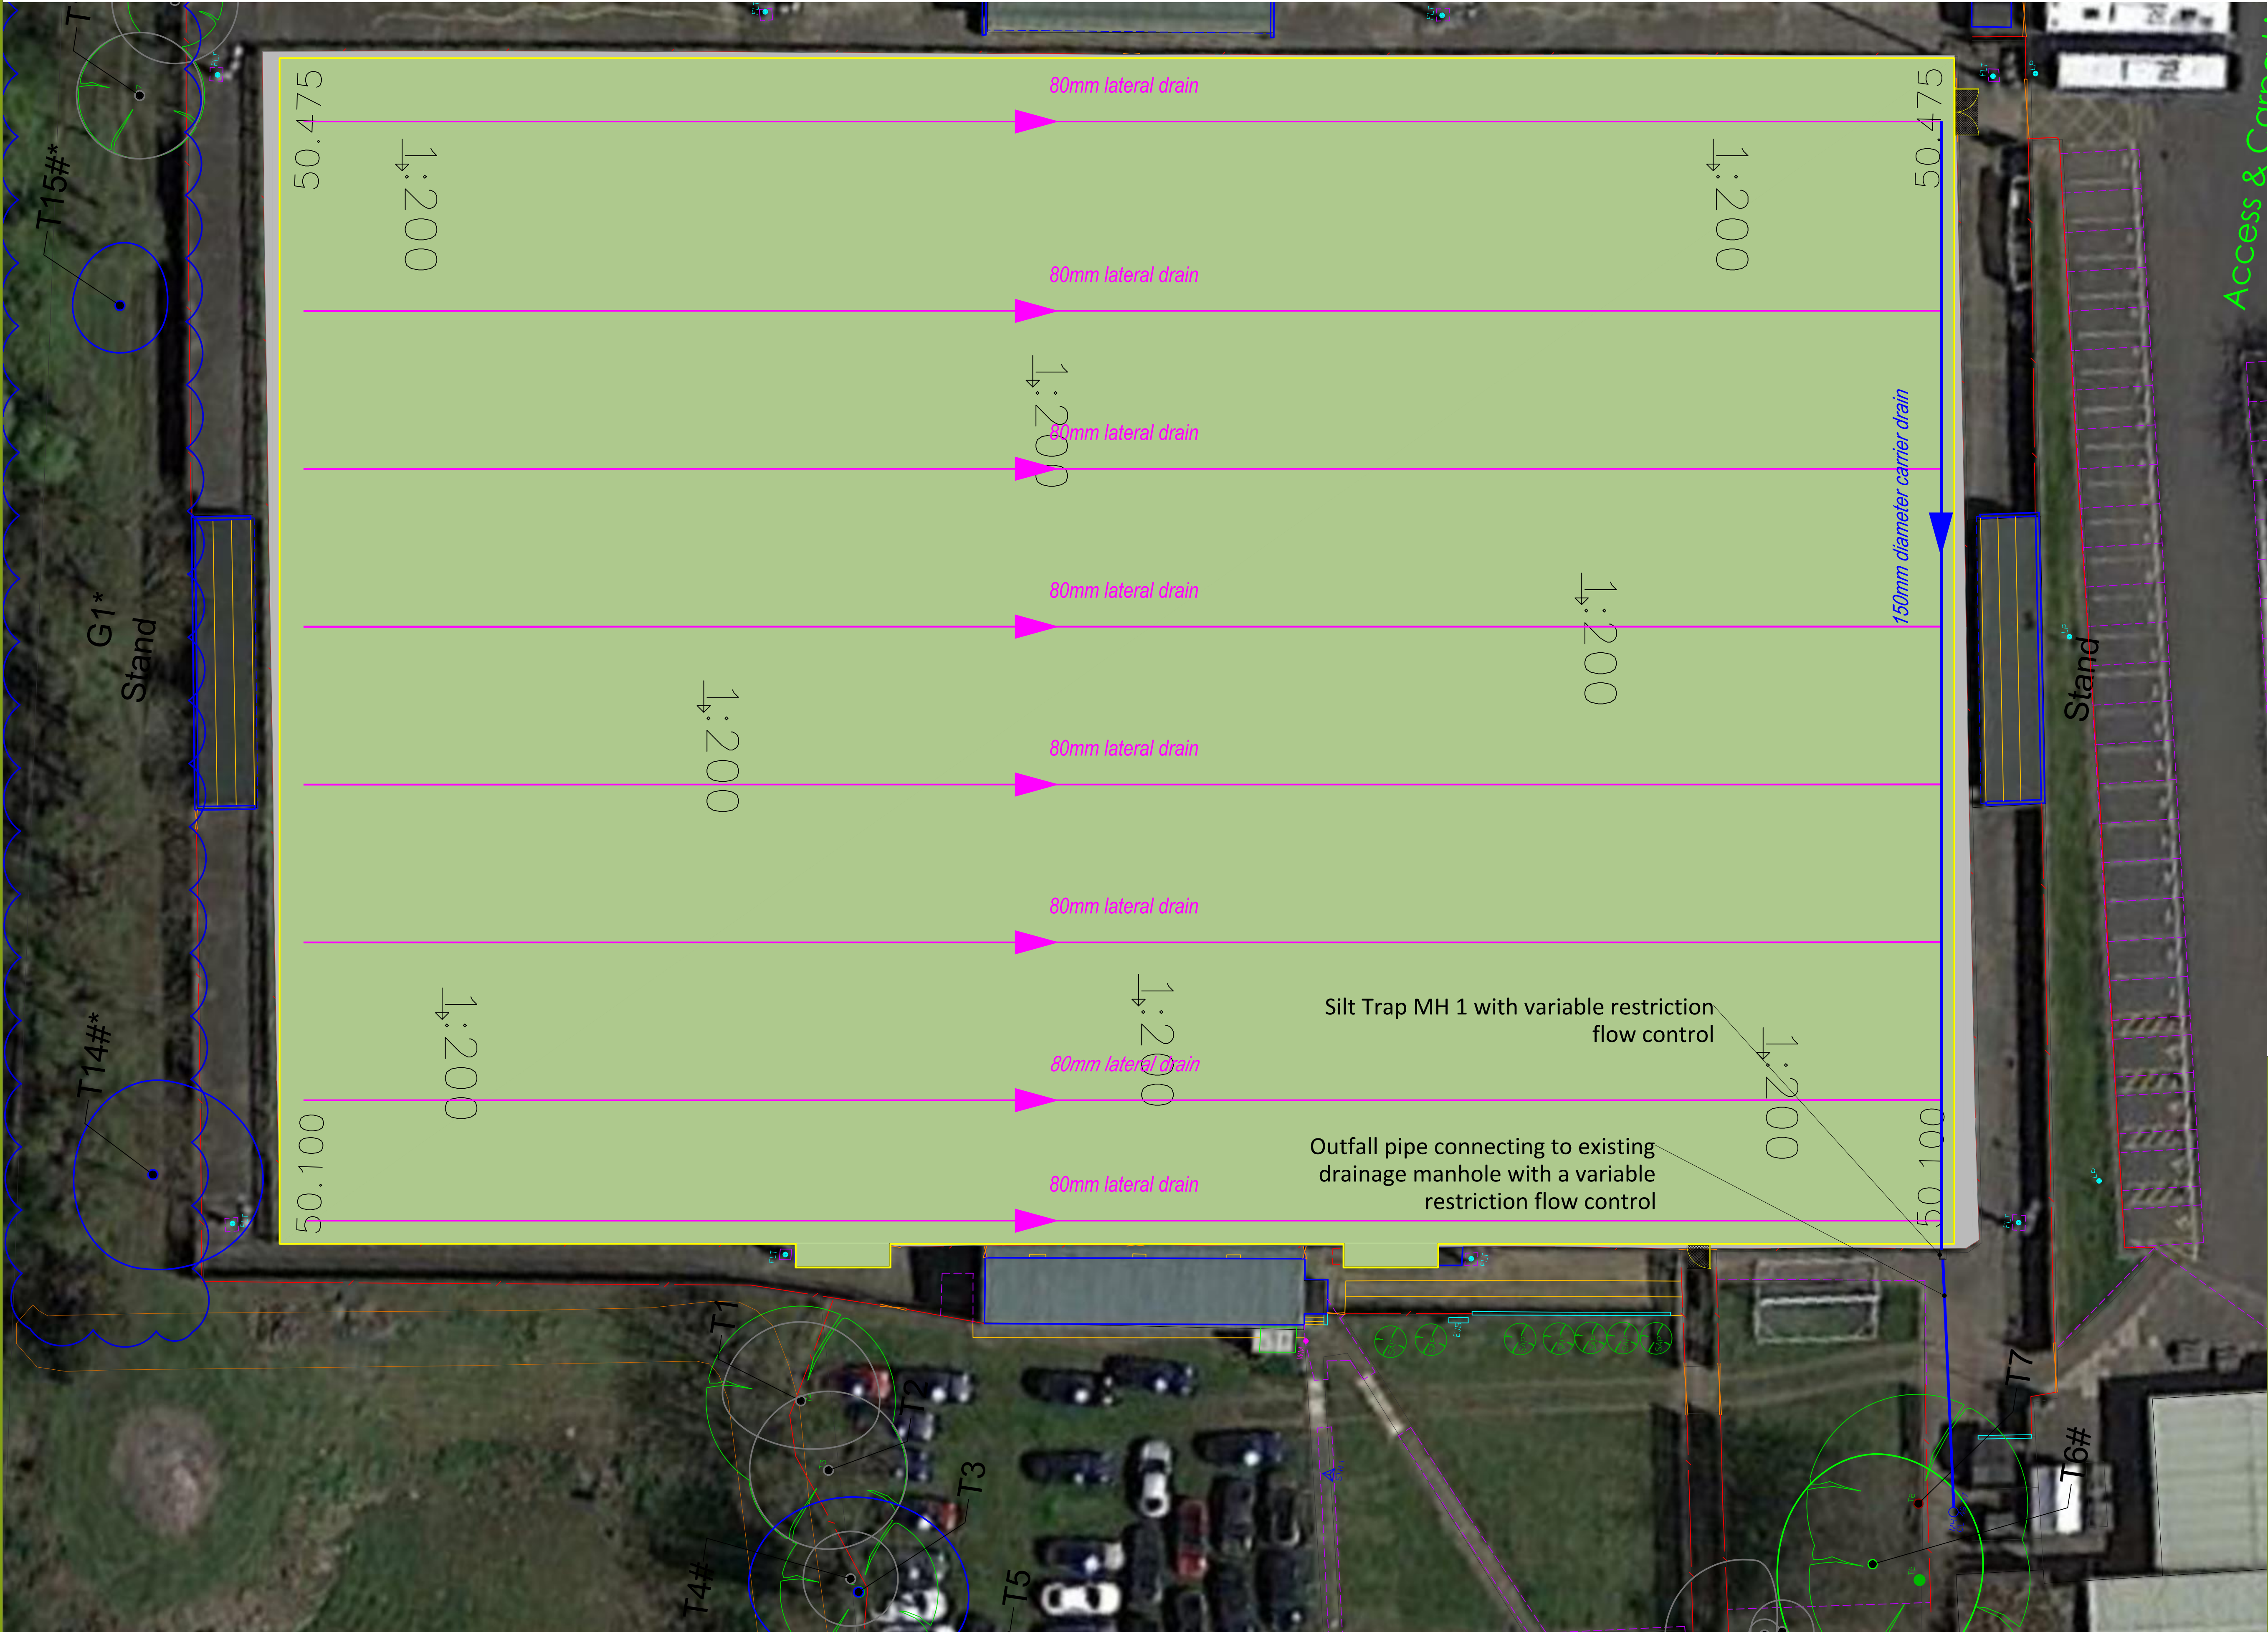

00	PLANNING ISSUE	ME	WB	29.03.23
REV	DESCRIPTION	REV	CK	DATE

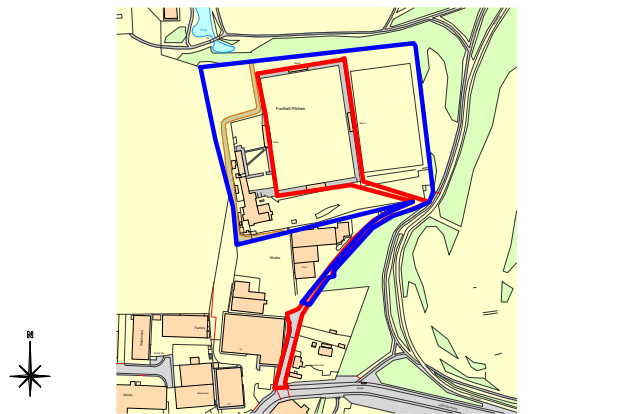

AUTHOR
ME

TITLE
Uxbridge FC
Artificial Turf Pitch
Proposed AGP Drainage Layout

PROJECT	SSL2475	SCALE	1:200	SIZE	A1
DRAWING No	08	REVISION	00		