

AS BUILT
DRAWING

ISSUED

SIGNED:
on behalf of: SDS (STRUCTURAL DESIGN SOLUTIONS) LTD
Date:

ACCEPTED



Ltd PM:
on behalf of: Lidl UK GmbH
Date:

LEGEND - SITE SERVICES

ELEMENT	SHOWN AS
FOUL SEWER	---
FOUL SEWER RISING MAIN	-----
PROPOSED SURFACE WATER PIPELINE	---
'CLASS 0400' MANHOLES (FOUL & SURFACE)	⊗
MANHOLES (FOUL & SURFACE)	□
RAIN WATER DOWN PIPE	• DP
SOIL VENT PIPE	• SVP
INSPECTION CHAMBER	• IC
BOLLARD TYPE VII, 100mm HIGH STAINLESS, CONCRETE FILLED, DOMED TOP	• B
LEVELS	↗ 35.08
LEVELS	+ 5.653
ROAD GULLY	⊞ ExG
ROAD GULLY IS FOR HEAVY DUTY, SUITABLE FOR HEV LOADING. ALL GULLY OUTLETS ARE 150mm Ø PIPES	⊞
LAMP POST	• LP

SITE AREAS

ELEMENT	AREA / NO.
SITE AREA (m ²)	9479
BUILDING AREA INC EXTERNAL WALLS PROPOSED (m ²)	2636
GIA (m ²)	2778
TROLLEY BAY AREA (m ²)	76
LOADING BAY & PLANT AREA (m ²)	180
LANDSCAPED AREA (m ²)	180
PAVED AREA (m ²)	795
CAR PARK SPACES AREA (m ²)	5043
NUMBER OF BICYCLE PARKING SPACES	48
NUMBER OF REGULAR CAR PARKING SPACES	96
NUMBER OF DISABLED CAR PARKING SPACES	13
NUMBER OF BROWN BADGE CAR PARKING SPACES	7
NUMBER OF PARENT & CHILD CAR PARKING SPACES	4
NUMBER OF CAR CHARGE SPACES	2
TOTAL NUMBER OF CAR PARKING SPACES	122
TOTAL NUMBER OF MOTORCYCLE PARKING SPACES	8

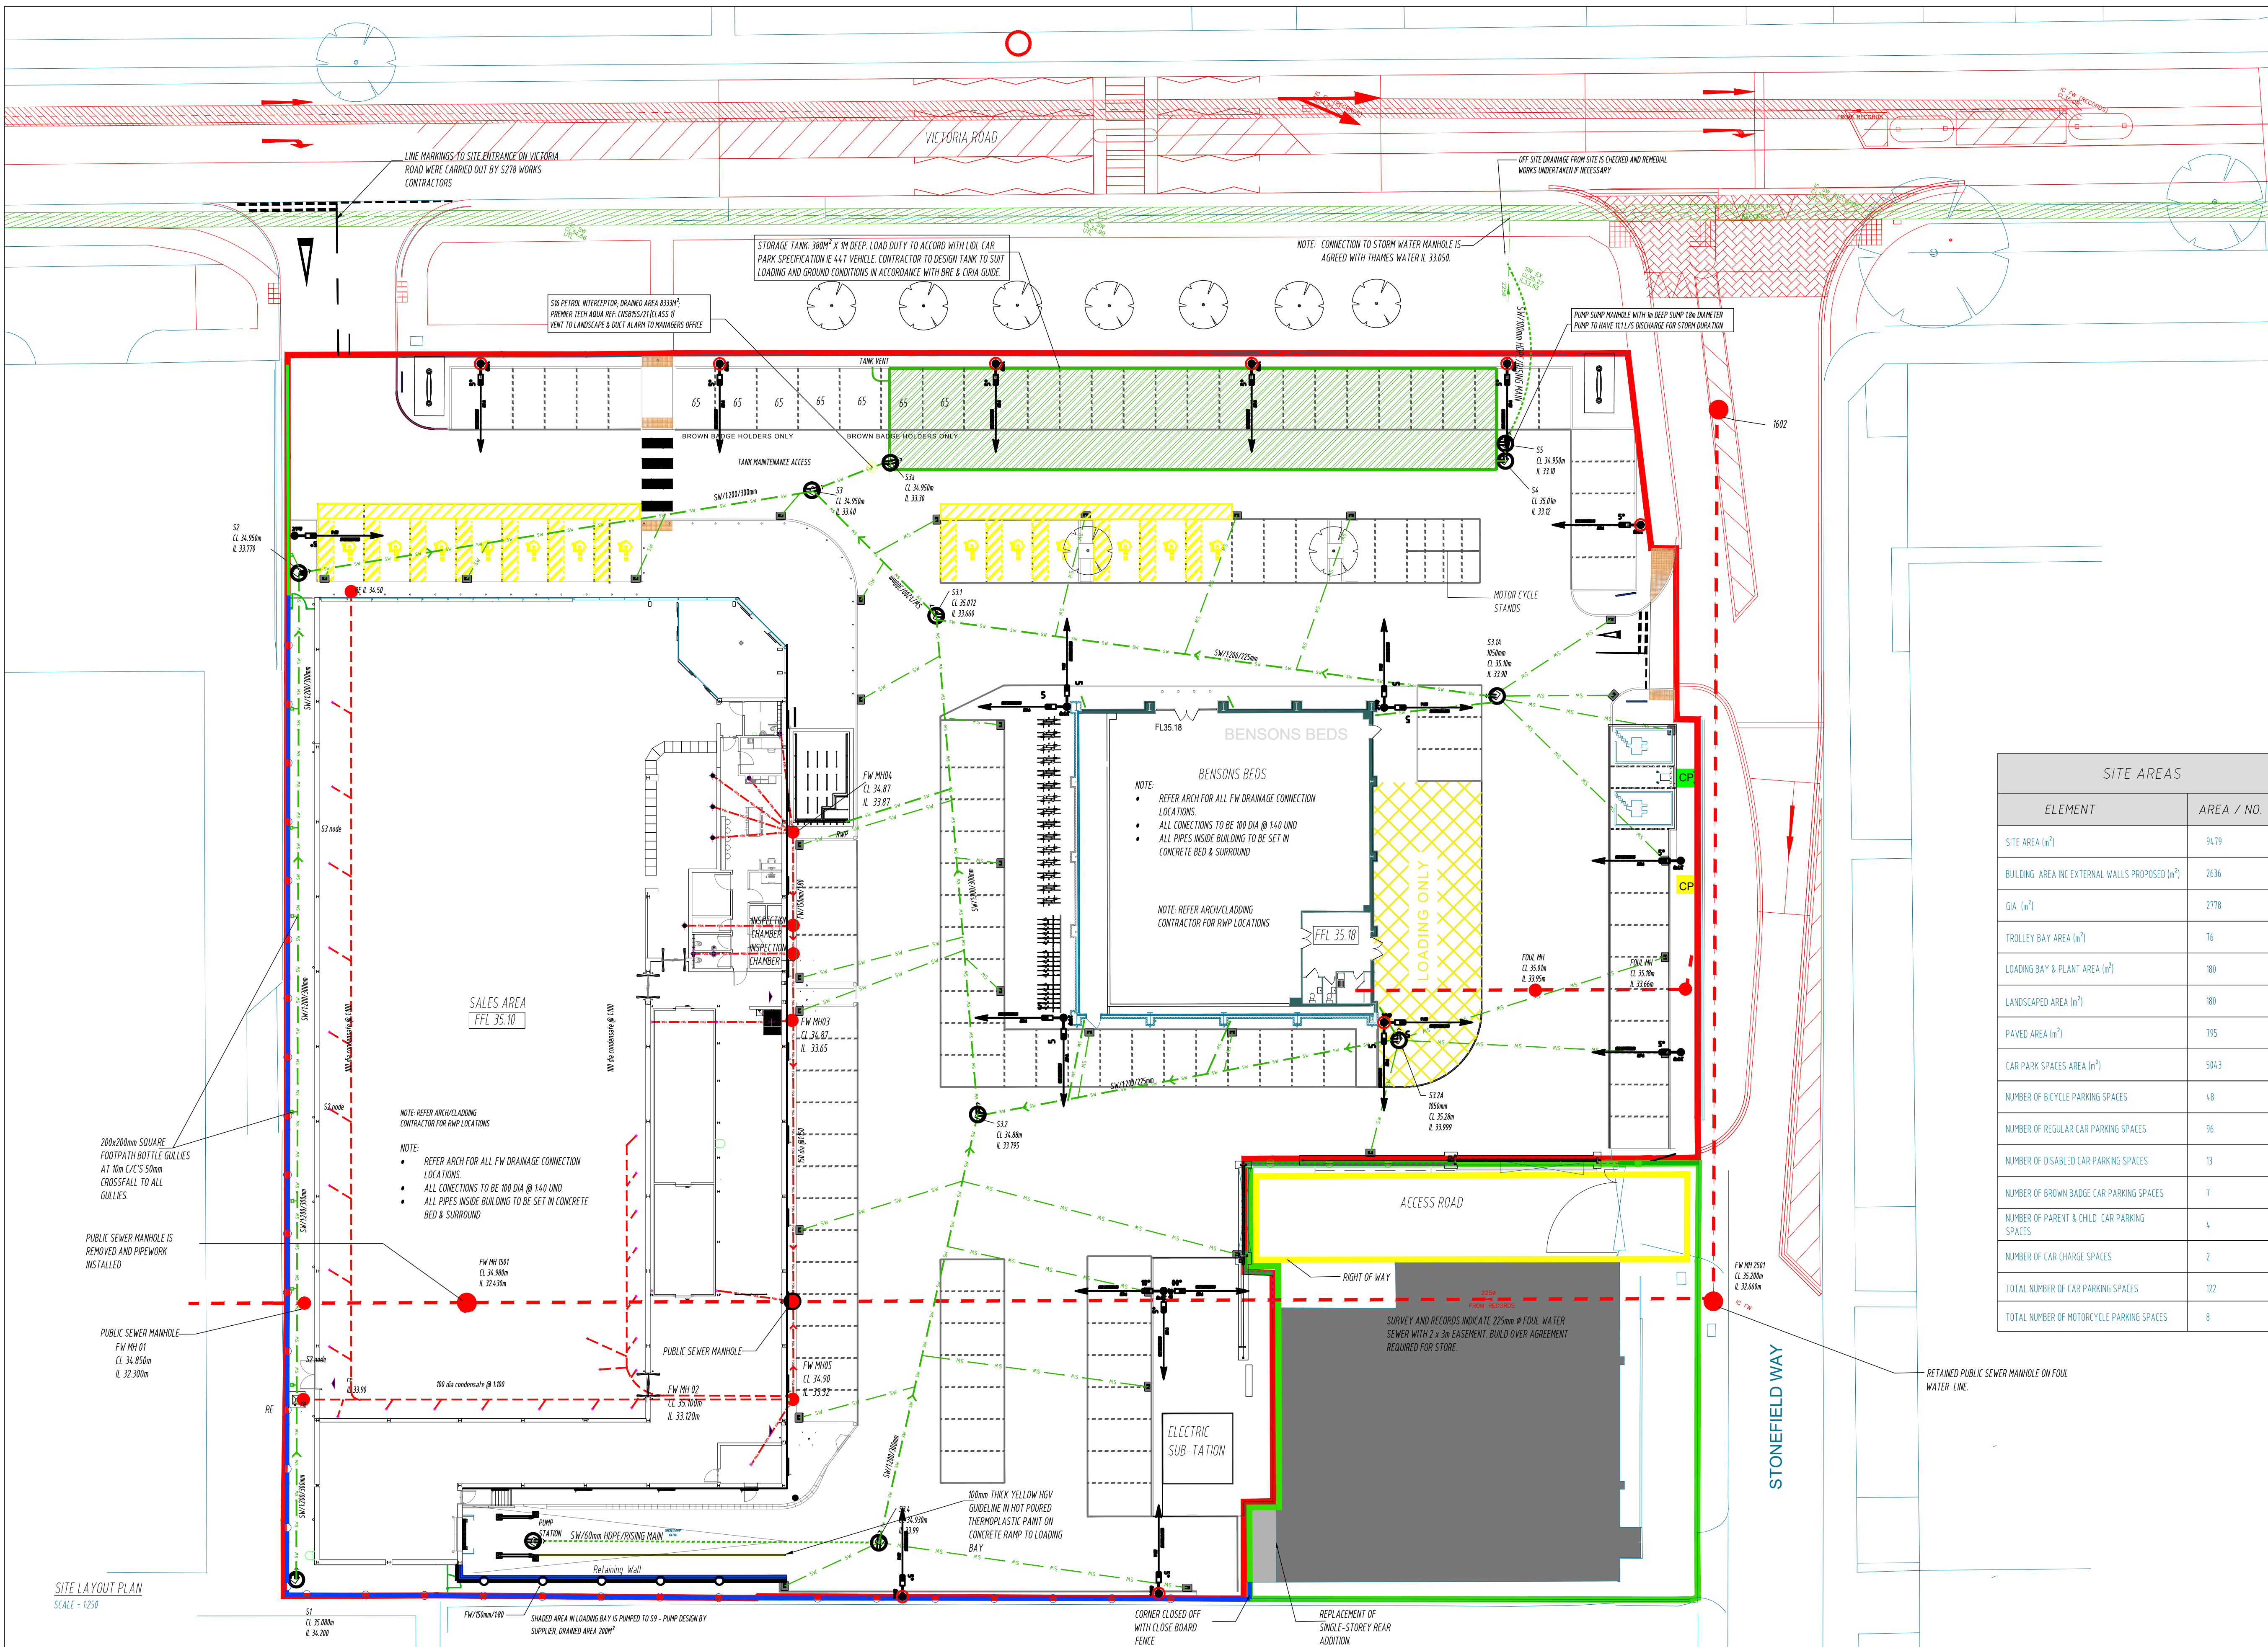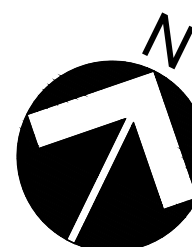

DRAWING NOTES: This drawing, the design and contents contained herein are copyright & may not be used without express permission of the authors. No part hereof may be copied or reproduced partially or wholly in any form whatsoever or stored in any retrieval system of any nature without the prior written consent of the copyright owners SDS (Structural Design Solutions) Ltd / SDS-UK (Structural Design Solutions) Ltd. NOTES: 1. This Drawing is to be read in conjunction with the relevant Specifications & other Architectural & Engineering Drawings. 2. Do Not Scale from this Drawing. - Metric Figured Dimension only to be used. 3. All dimensions to be checked on site prior to work commencing. 4. Engineers to be informed immediately of any discrepancies before work proceeds. 5. It is the Contractors responsibility to ensure that all works are carried out in accordance with the requirements of the current Building Regulations and all other statutory documents relevant to this project. 6. All details are standard, and are not project specific unless clearly stated otherwise. 7. Wherever a particular product is specified by name, the term "Or equivalent" subject to approval" is deemed inferred. The Contractor is obliged to ensure any and all products incorporated into a project are certified to the relevant National Standards (where necessary), are fit for their intended purpose and will provide adequate performance subject to manufacturers' warranties. 8. SDS (Structural Design Solutions) Ltd / SDS-UK (Structural Design Solutions) Ltd bear no liability for unilateral changes/modifications made during the course of construction based on the drawing prepared without prior consultation and confirmation of acceptance of revision by SDS (Structural Design Solutions) Ltd / SDS-UK (Structural Design Solutions) Ltd. 9. This drawing is to be read in conjunction with all relevant Architects drawings and Specifications. Any discrepancies identified are to be reported to the Engineers before proceeding

SDS-UK (Structural Design Solutions) Ltd,
BRIDGE HOUSE, 25-27 THE BRIDGE,
WEALDSTONE, HARROW, HA3 5AB.
Tel: +353 (0)94 9034914 Fax: +353 (0)94 9034698
E-mail: info@sdstructuraldesign.ie Web: www.sdstructuraldesign.ie

SDS
SDS-UK (Structural Design Solutions) Ltd,

AB2	27.02.2018	KM	REVISED TO COMMENT & ISSUED AS-BUILT
AB1	18.01.2018		ISSUED AS-BUILT
Rev.	Date:	By:	Description:

TINNELY CONSTRUCTION

Project Title
LIDL STORE AT
VICTORIA ROAD, SOUTH RUISLIP, LONDON.

Drawing Title
SITE LAYOUT
DRAINAGE LAYOUT SURFACE WATER AND FOUL SEWERS

Scale	1:250	Page Size	@ A1	Status	AS-BUILT
Drawn by	CD	Date	APR 2017	Checked	MM
Project No.	17080	Drawing No.	3021	Revision	AB2