


KEY:

- Existing trees
- Site boundary
- Foul pump chamber
- Rainwater pump chamber
- Manhole connection to foul pump chamber
- Manhole connection to rainwater pump chamber
- 70kVA electric point for proposed building
- Gas connection
- Main water connection
- Sprinkler water connection
- Rainwater connection
- Manhole
- Manhole

SCALE
0m 2m 4m 6m 8m 10m 12m

1/250 A3
EXISTING SITE PLAN

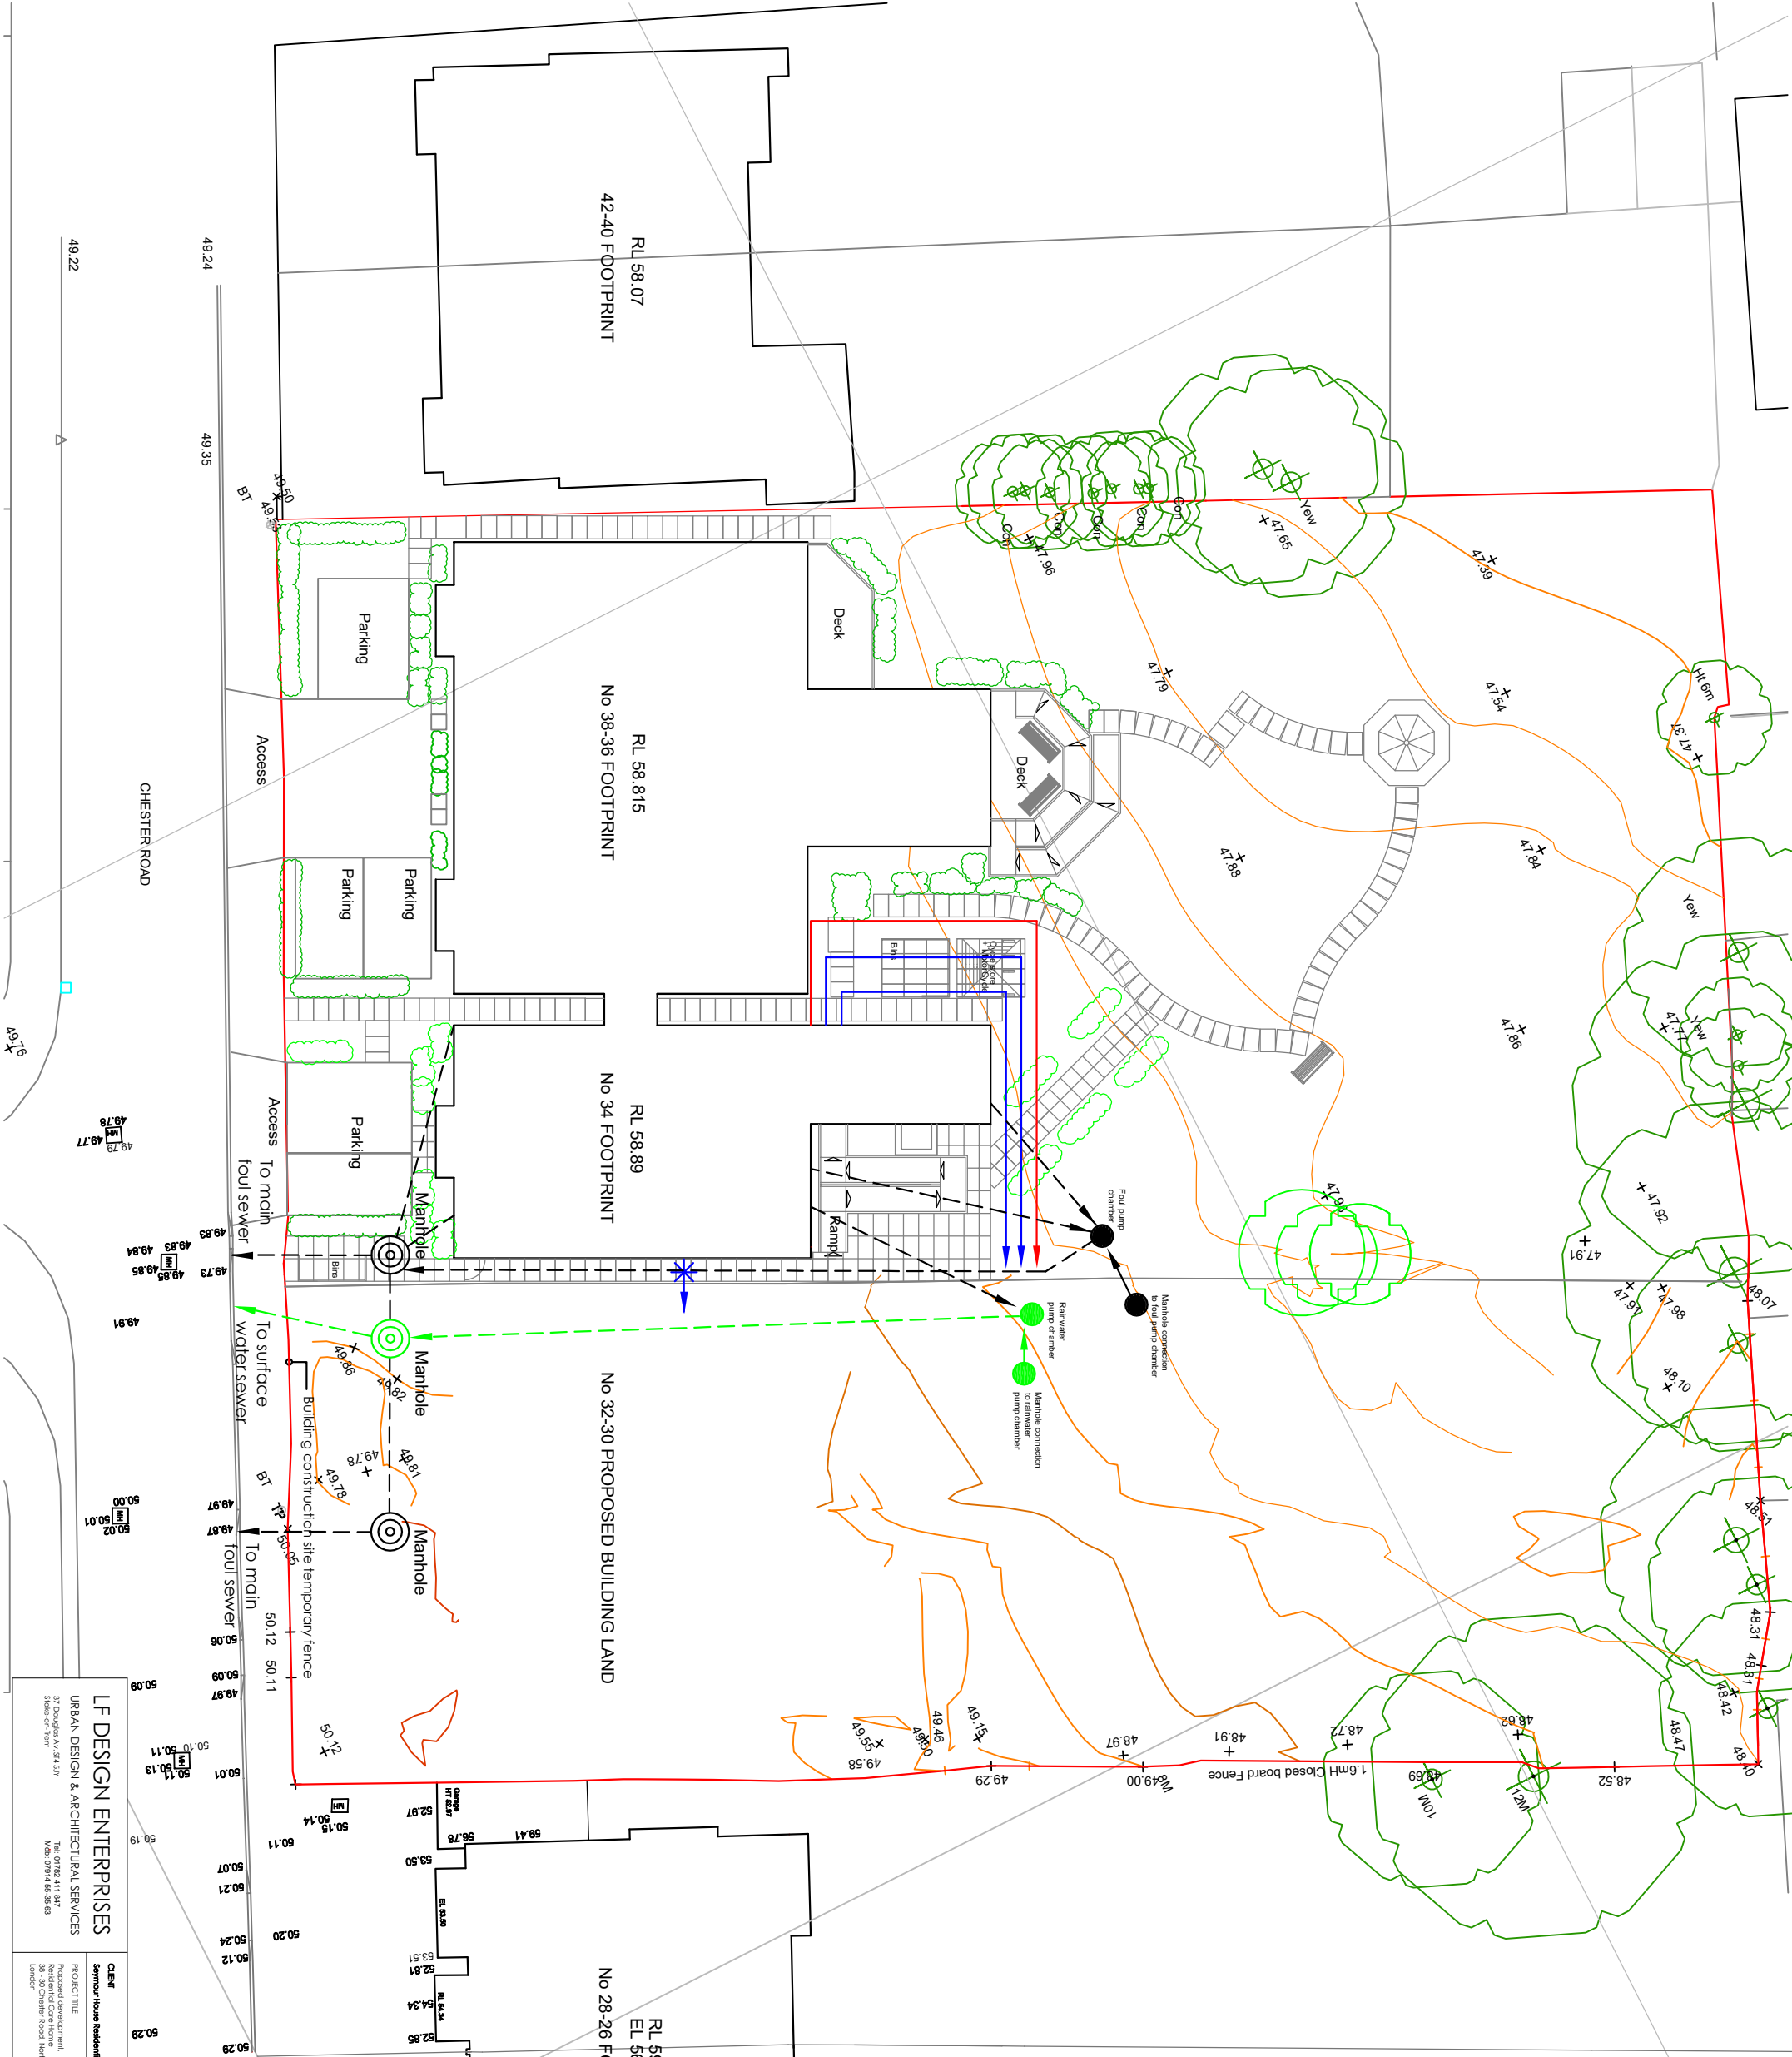

LF DESIGN ENTERPRISES URBAN DESIGN & ARCHITECTURAL SERVICES 37 Doughty Ave, St. Asaph Stoke-on-Trent	CLIENT Seymour House Residential Care Homes Ltd	PROJECT TITLE Proposed development, Residential Care Home, Seymour House, Stoke-on-Trent, Staffordshire	PROJECT NUMBER	DATE
			DRAWING TITLE	SCALE
			DRAWING NUMBER	REV.