



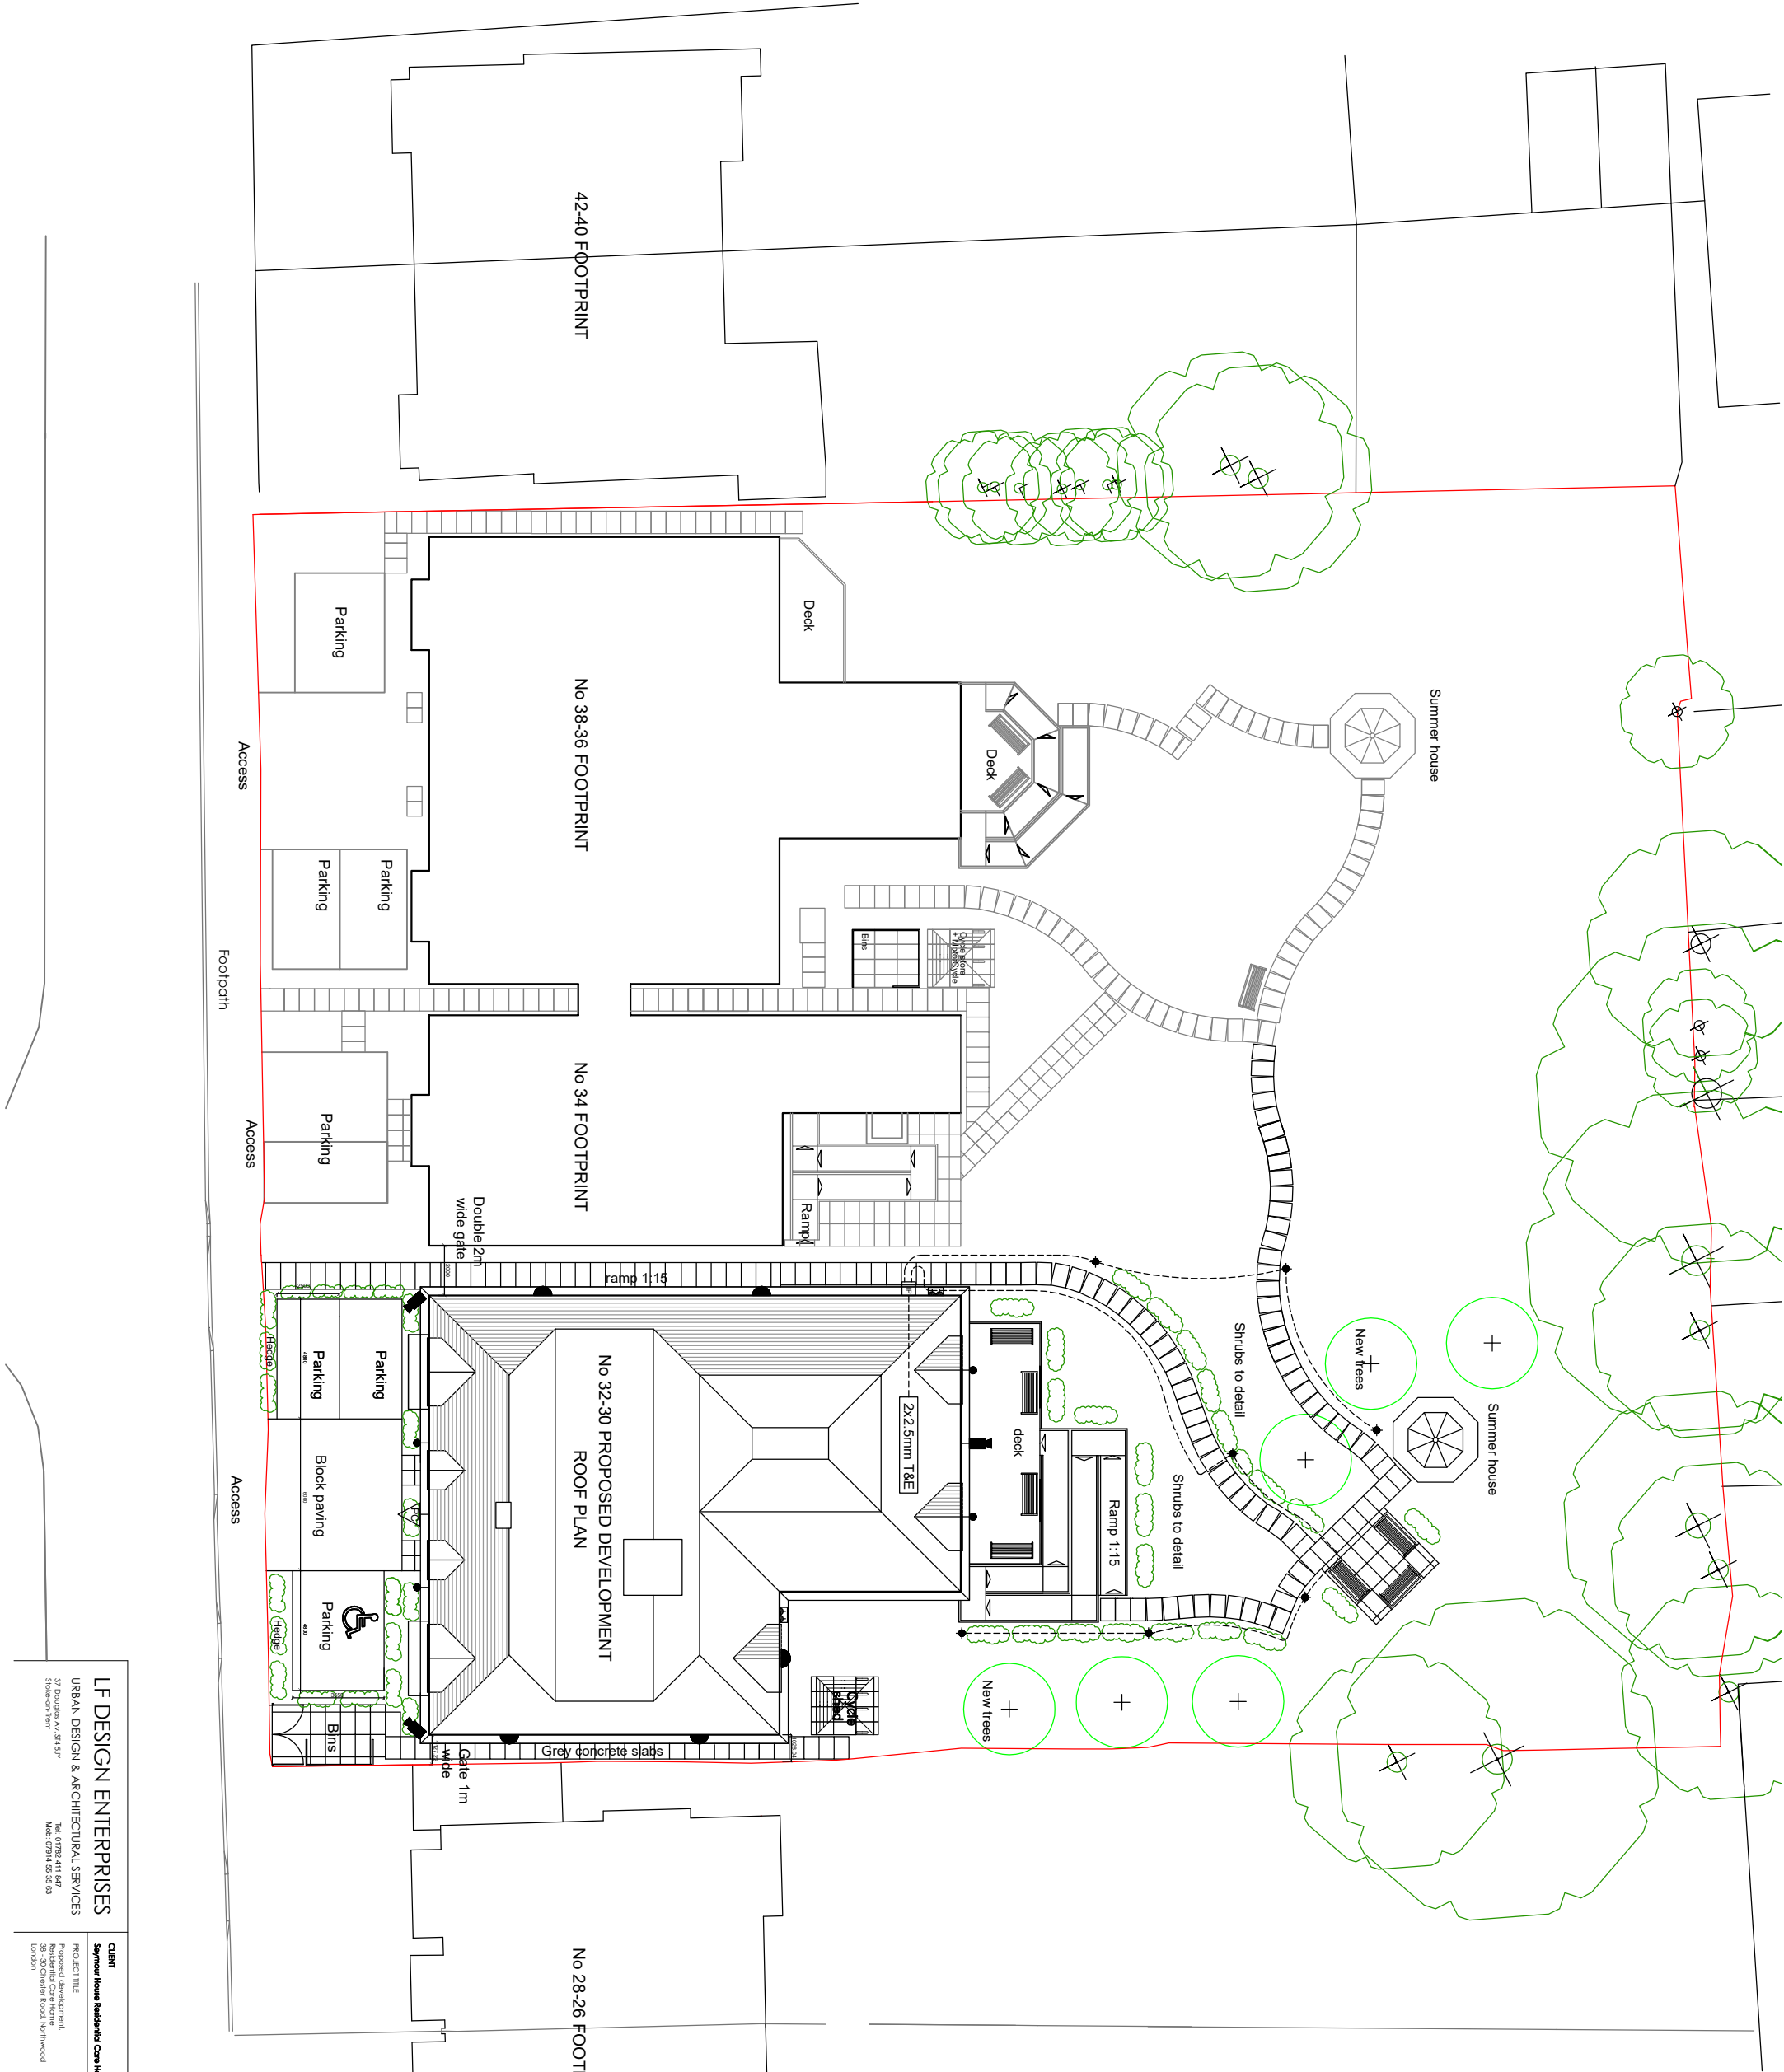

KEY:

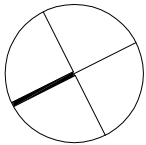

+ NEW TREES

EXISTING RETAINED TREES

NEW SHRUBS

PATHWAYS, Natural grey concrete paving slabs generally 600x900mm

Decking

Site boundary

Disabled parking

External double switched socket

 
External building mounted fitting

Static CCTV camera

1 arm wall fitting

Bollard fitting

Photocell dusk dawn sensor



1/250 A3

SITE PLAN - GROUNDS
LIGHTING&CCTV LAYOUT

LF DESIGN ENTERPRISES URBAN DESIGN & ARCHITECTURAL SERVICES 37 Doughty Ave, St. Giles Stoke-on-Trent	CLIENT Seymour House Residential Care Home Ltd PROJECT TITLE Proposed development, Residential Care Home, 38-40 Seymour Road, Netherwood London	PROJECT NUMBER	101/2022
		DRAWING TITLE	SCALE
		Site Plan Ground Lighting & CCTV layout 28-30 Chatterwood	A3 (1/250)
		DRAWING No: SC001/2531	