

Copyright. This drawing and design and all the information contained therein is the sole copyright of 360 International Group, and reproduction in any form is forbidden unless permission is obtained in writing.
No dimensions to be scaled from this drawing. All Contractors must visit site and be responsible for taking and checking all dimensions relative to this work. The Designer must be advised of any discrepancies in writing.

ELECTRICAL LEGEND

	Decorative pendant fitting
	Table Light
	Standard Lamp
	Ceiling rose
	Pendant on hook and chain
	Recessed Downlighter, Allow for smoke hoods where applicable
	Wall lights
	Twin Wall lights
	Picture lights
	Fluorescent Tube
	Surface mounted spotlight
	Bulkhead ceiling fitting
	AR111 Fitting, Single or double fitting
	Track Lighting
	Double plug socket
	Fused Spur
	Speakers
	Security Sensor
	Pool Light
	Recessed LED colour changing rope light

FIRE PRECAUTIONS LEGEND


	Maintained Exit sign to B.S.
	Non maintained emergency lighting unit to be fitted with LED indicating healthy supply. The units are to incorporate battery back up for three hours
	Maintained emergency lighting unit to be fitted with LED indicating healthy supply. The units are to incorporate battery back up for three hours
	Non-maintained Fire Exit sign
	Heat or smoke detector
	Heat or smoke detector together with integrated Fire Alarm sounder (of at least 75 dB(A) as well as an integrated visual beacon
	Fire Alarm sounder (of at least 75 dB(A) as well as an integrated visual beacon
	Visual Beacon
	Fire alarm push button
	Fire alarm sounder
	One hour fire resisting doors fitted with closer and intumescent smoke seals
	Half hour fire door with intumescent strips, non-self closing
	Half hour fire resisting doors fitted with closer and intumescent smoke seals
	Push Bar
	Water extinguisher
	CO2 extinguisher
	Fire Blanket
	Foam Extinguisher
	Dry Powder Extinguisher
	Wet Chemical Extinguisher
	Doors which are to be free from all fastenings (other than a ball or roller fastening or lever handled latch)
	Security Lock (to be left unlocked during trading hours)
	Doors which are to be fitted with a push pad with a manual override fitted externally
	Doors that are to have a simple fastening which is immediately operable by a person on their way out.

Rev.A. 17Oct17. External levels to rear added; previously unsurveyed FF areas added; existing fixtures and fittings, ceiling heights indicated. SRC.
Rev. Date. Notes. Amended by.


360 International Group
DISCOVER : DESIGN : DELIVER

99a Mews Street, St Katharine Docks, London. E1W 1UG
Tel: 020 7112 7548 www.360IntGroup.com


Job title	Crown & Treaty 90 Oxford Road Uxbridge. UB8 1LU.	
Drawing title	Plans as Existing.	
Scale	1:100@A1	Drawing No.
Date	31May17	920/02A
Drawn by	Steve Curtis	

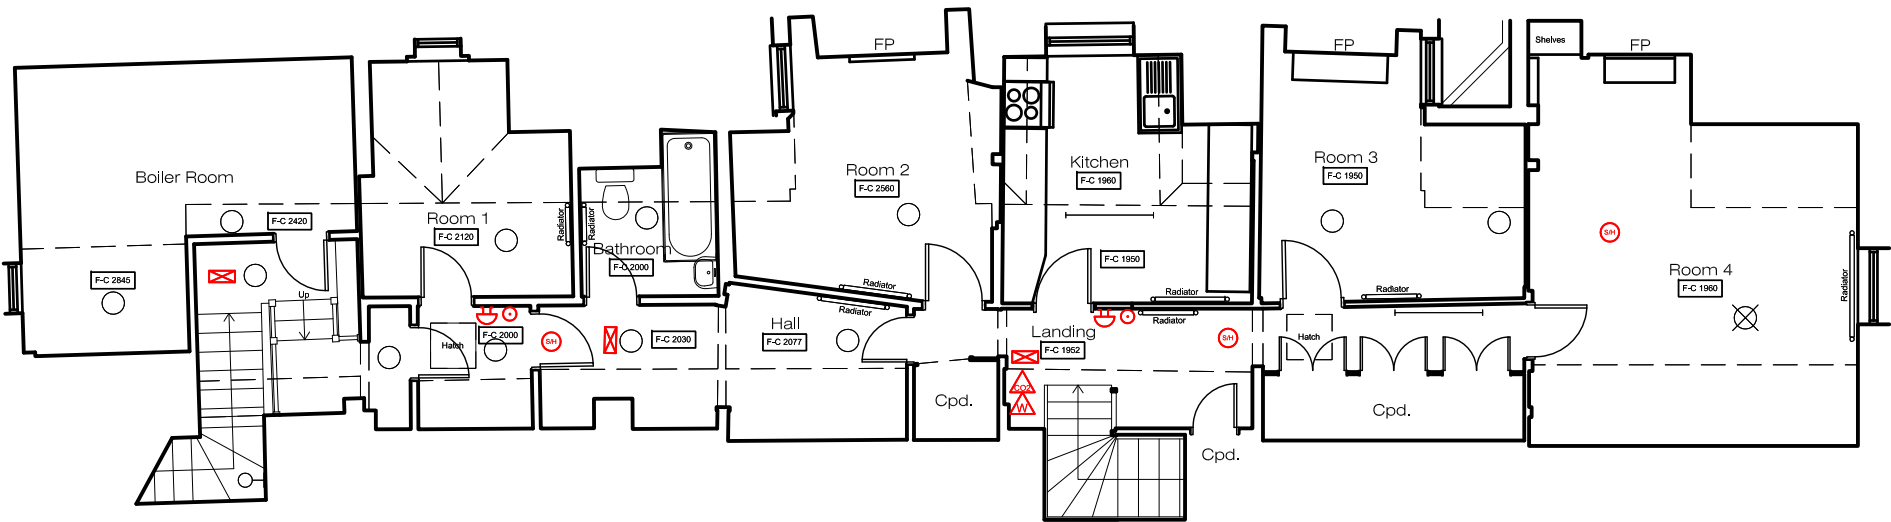



EXISTING SECOND FLOOR PLAN

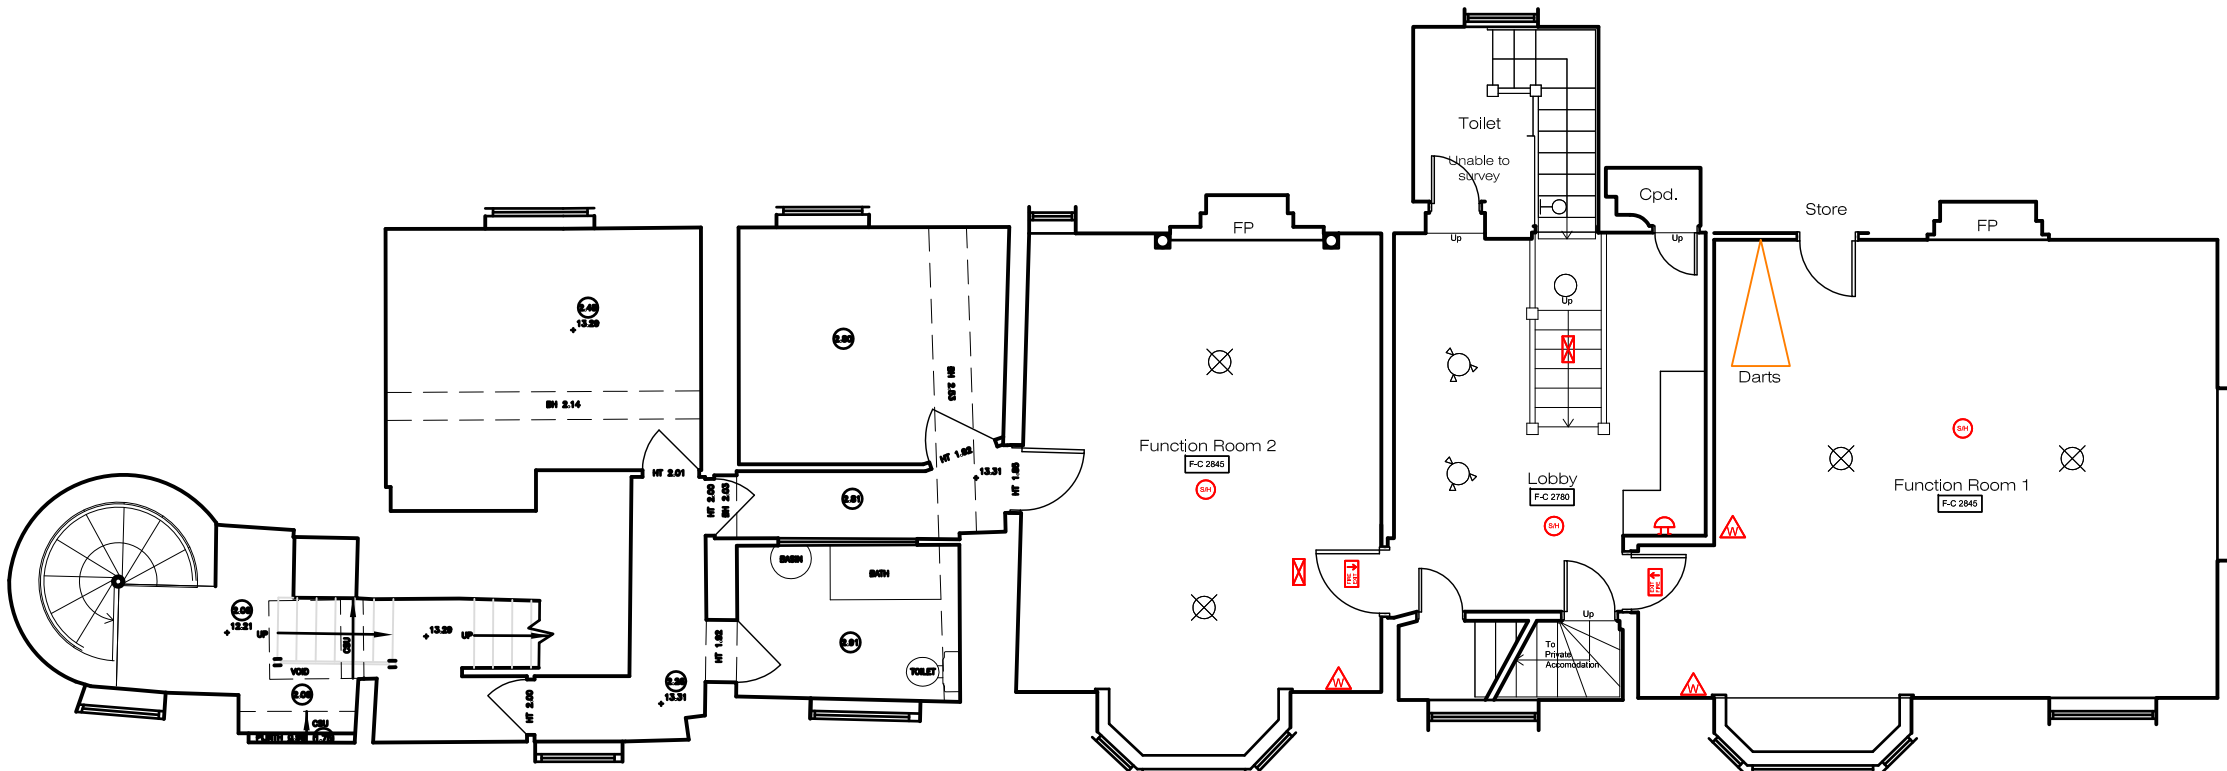

EXISTING FIRST FLOOR PLAN

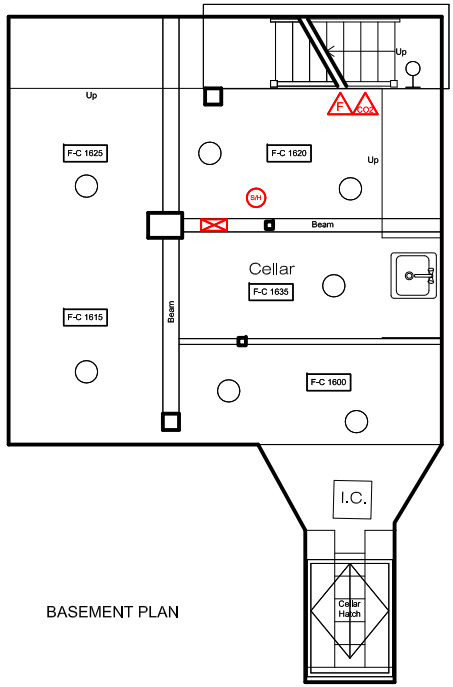

BASEMENT PLAN

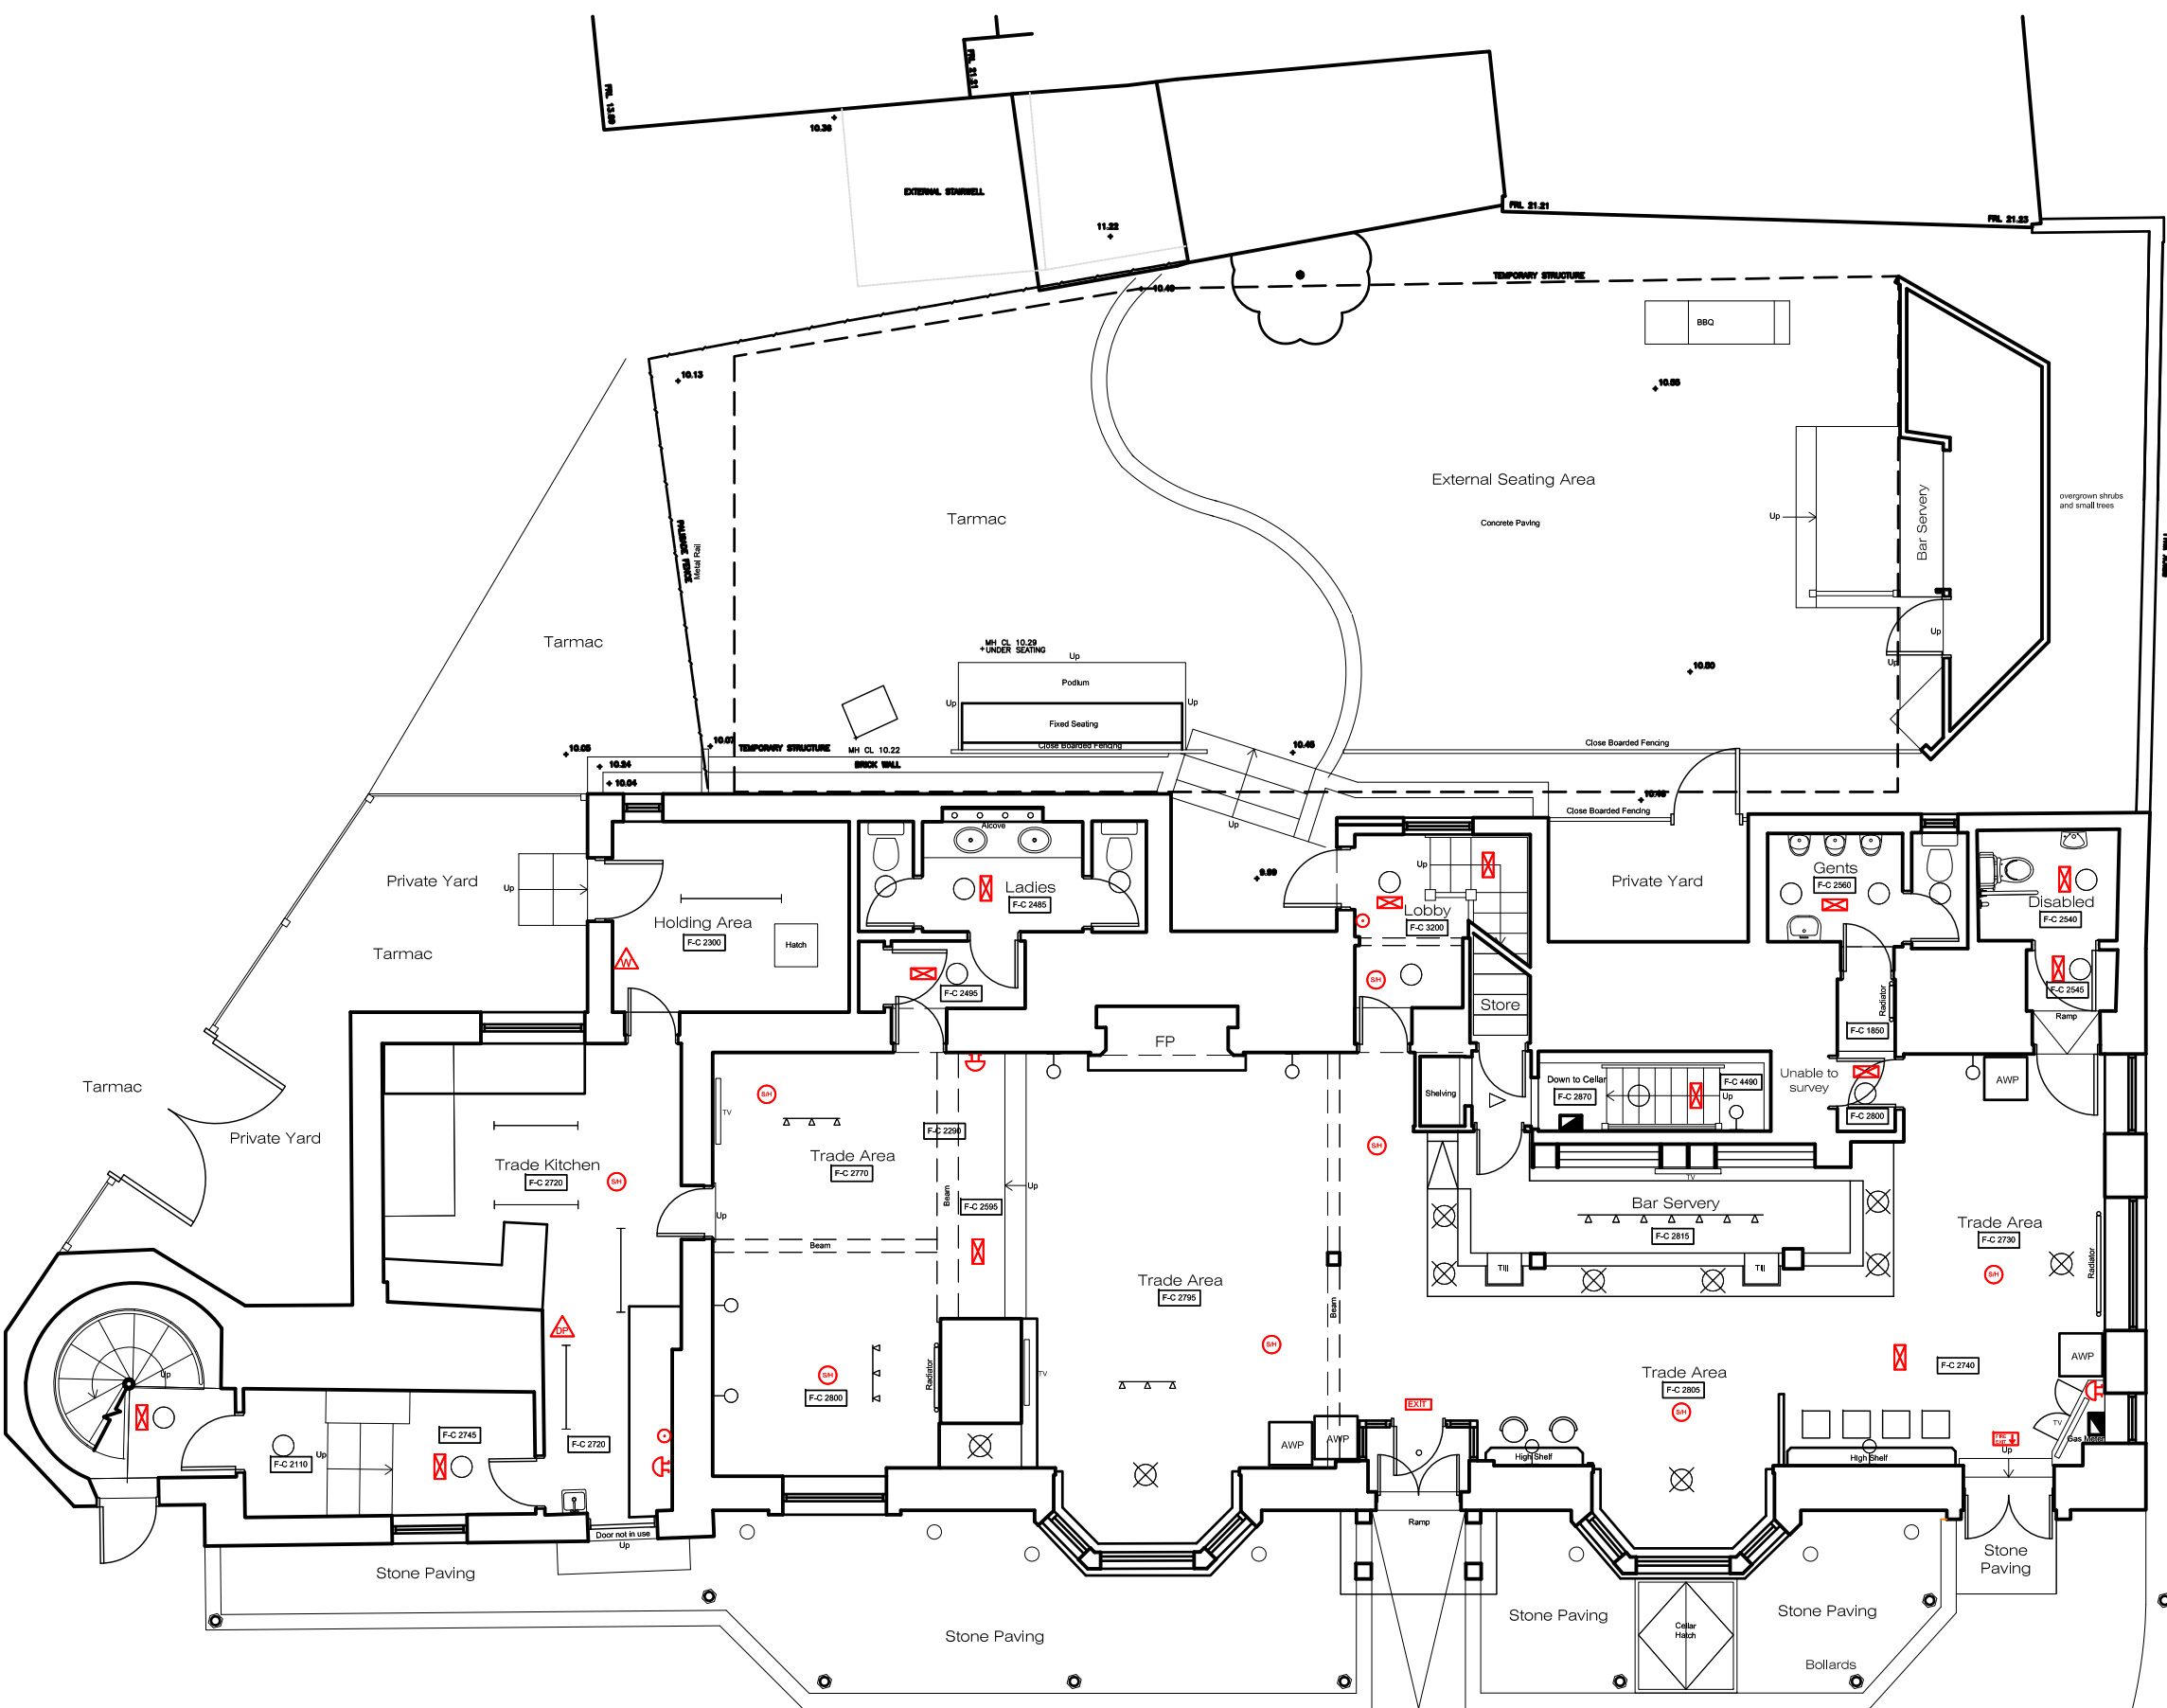 

EXISTING GROUND FLOOR PLAN

