 



© COPYRIGHT RESERVED
Do Not Scale From Paper Copies



This survey is related to OSGB36(10) coordinate system by
GPS rapid static methods. No scale factor has been
applied to the survey information. All horizontal distances
taken from this drawing are ground distances.

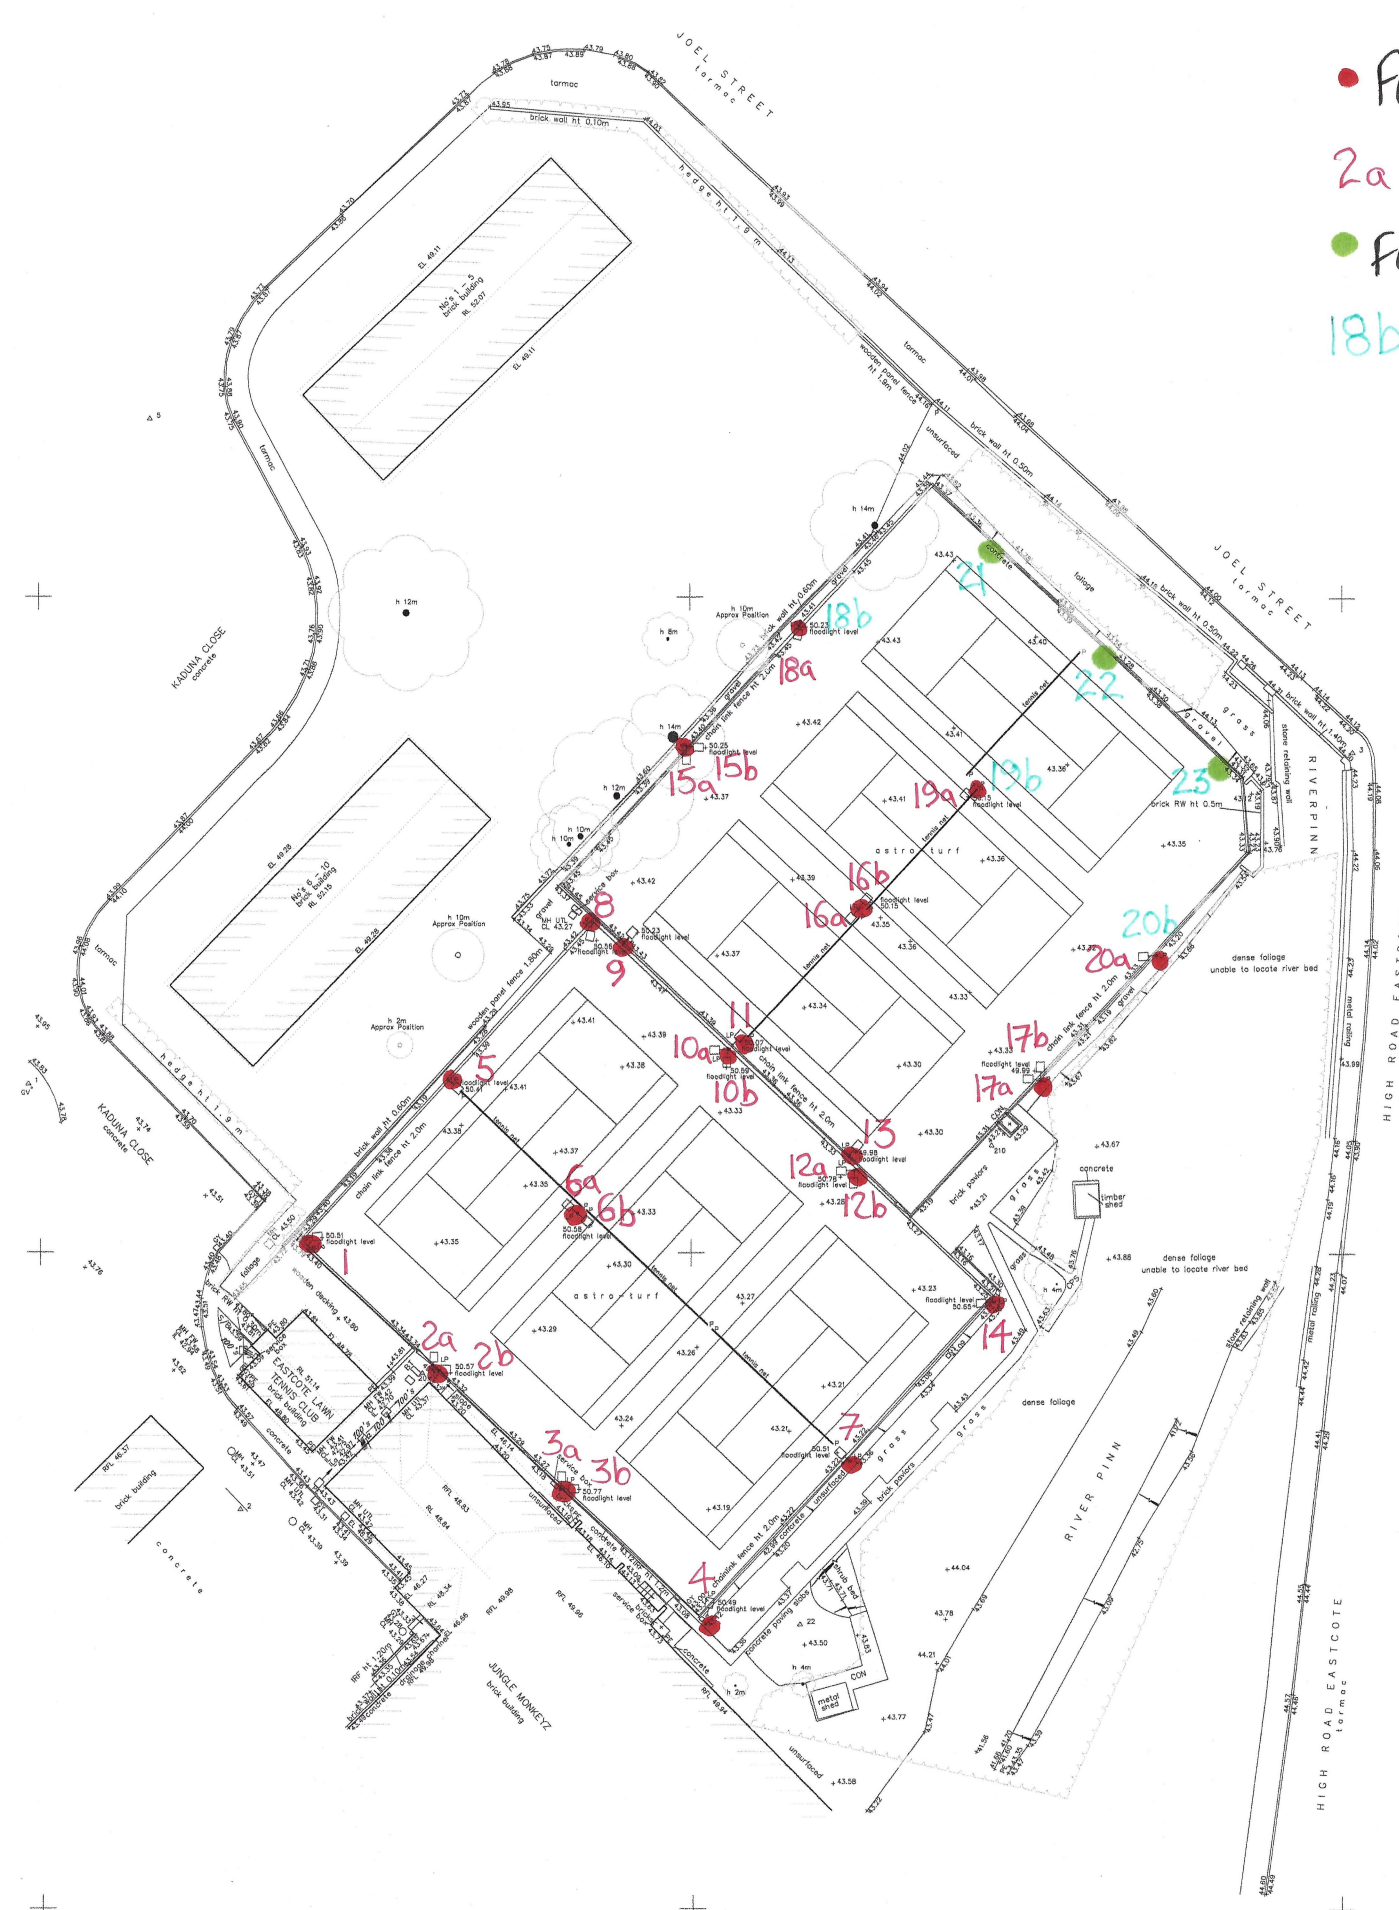

- FLOODLIGHT STANDARD ~ EXISTING
- 2a EXISTING LAMP
- FLOODLIGHT STANDARD ~ PROPOSED
- 18b PROPOSED LAMP


Co-ordinate Table			
Station	Eastings	Northings	Level
1	510499.105	188712.838	43.976
2	510505.261	188680.353	43.558
3	510500.803	188708.221	44.274
4	510545.183	188852.331	43.885
5	510508.542	188763.555	43.928
20	510528.259	188690.179	43.380
21	510562.882	188653.171	43.413
22	510528.290	188671.627	43.481
23	510566.706	188664.087	43.729
30	510608.612	188672.600	44.603
210	510573.113	188708.219	43.237
211	510594.422	188724.563	43.740
2100	510582.720	188700.321	43.960

All levels related to Ordnance Survey active OPB network, at
survey station 5.

DISCLAIMERS

Every effort has been made to confirm tree species on
site, yet it is advised to confirm these details with an
arborist before proceeding with any design.

Every effort has been made to confirm drainage run, type and size on
site, yet it is advised to check these details against statutory authority
information before proceeding with any design.

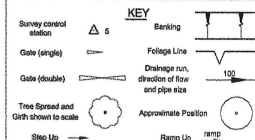

ABBREVIATIONS

Air Handling Unit	Water Meter	WM
Belted Season	Water Level	BL
Bulb	Ridge Level	RL
Burial	Roof Level	RFL
BT Inspection Cover	Soft Level	SPL
Cable Television Cover	Top of Wall Level	TWL
Drainage Channel	Parapet Wall Level	PWL
Electricity Cover	Finished Floor Level	PFL
Electricity Pole	Head Level	HL
Earth Rod	SB Level	SL
Fire Hydrant	Core Level	CL
Gas Valve	Invert Level	IL
Gate Post	GP - No Visible Pipes	NVP
Gully	Unstable to L1	U1L
Inspection Cover	IC	IC
Inspection Box	JB	JB
Kids Outlet	KO	KO
Lamp Post	LP	LP
Manhole	Concrete	CON
Marker Post	Concrete Paving Stone	CPB
Post	P - Flower Bed	PB
Pipe	Shrub Bed	SB
Road Sign	RS	RS
Roofing Eye	RE	RE
Marker Post	MC	MC
Sign Post	SP	SP
Stop Valve	SV	SV
Stop Tap	ST	ST
Telegraph Pole	TP	TP
Turf Light	TL	TL
Vent Pipe	VP - Post and Chain Fence	PCF
Wooden Panel Fence	WPF	WPF

Client
EASTCOTE LAWN TENNIS CLUB

Project
**12 KADUNA CLOSE
PINNER, HA5 2PZ**

Title
TOPOGRAPHICAL SURVEY

Drawing Number
TS22-298-1-RevA

Revision	Description	Rev. By	Date
A	Topographic survey and site plan	NEM	04/07/22
B	Amendments made at clients request	NEM	04/09/22

Scale 1:200@A0 Sheet 1 of 1

Drawn by JJS Checked by PG Date of Survey JUNE 2022

