



NOTE:
EXISTING SINGLE PHASE 100A SUPPLY TO BE UPGRADED TO
3 PHASE 100A SUPPLY WITHIN MK5 CABINET. EXISTING BT &
TX EQUIPMENT TO BE RELOCATED WITHIN MK5 CABINET

Antenna Aperture ID	Proposed 4G/5G Bearing	Operator: Shared/ EE/H3G
A1	0°	H3G
A2	0°	EE
A3	0°	EE/H3G
A4	0°	EE/H3G
B1	120°	H3G
B2	120°	EE
B3	120°	EE/H3G
B4	120°	EE/H3G
C1	240°	H3G
C2	240°	EE
C3	240°	EE/H3G
C4	240°	EE/H3G

NOTES:
1. ALL DIMENSIONS IN MM UNLESS OTHERWISE NOTED.

Master:	MBNL / EE / H3G:	Project:	Purpose of Issue:	Issue:
M003	MBNL	T&A	Planning	C
Date:	14/04/2020	Revision / Upgrade Description:		
Drawn:	K. Soper	Amends to site topography		
Checked:	T. Clifford			
Approved:	M. Venner			
Master:	MBNL / EE / H3G:	Project:	Purpose of Issue:	Issue:
M002	MBNL	T&A	Planning	B
Date:	21/02/2020	Revision / Upgrade Description:		
Drawn:	K. Naveen	Site Location Change		
Checked:	T. Clifford			
Approved:	M. Venner			
Master:	MBNL / EE / H3G:	Project:	Purpose of Issue:	Issue:
M001	MBNL	T&A	Planning	A
Date:	01/08/2019	Revision / Upgrade Description:		
Drawn:	R. Manikandan	First Issue		
Checked:	T. Clifford			
Approved:	M. Venner	ACQ		



Hutchison 3G UK Limited
Star House, 20 Grenfell Road
Maidenhead, SL6 1EH
Tel: 01628 765 500
Fax: 01628 765 501

H3G Base Station Information line:
0845 6043000
Available 8am-6pm Monday to Friday



Hatfield Business Park
Hatfield
Hertfordshire
AL10 9BW

Tel: 01707 315000
Fax: 01707 319001



Mobile Broadband Network Limited
Sixth Floor, Thames Tower, Station Road, Reading, RG1 1LX



 
UNIT E3 PITTS CLEAVE INDUSTRIAL ESTATE, TAVISTOCK, DEVON, PL19 0PW
sales@beaconcomms.co.uk
Tel: +44 (0)1822 610610

Site Name:		HUME WAY			
Site ID:		732715			
Address:		HUME WAY RUISLIP HILLINGDON LONDON HA4 8DY			
Title:		216 MAX CONFIGURATION SITE PLAN - SHEET 2			
Project:		T & A			
Purpose of Issue:		GENERAL ARRANGEMENT			
EE Cell ID:	70284	MBNL Cell ID:	HGN032	3UK Cell ID:	HA0072
Master Drawing No:					Issue:
732715_HGN032_70284_HA0072_M003					C

SITE CAPACITY & LEAD OPERATOR			
A	B	C	LEAD
HS2	HS2	HS2	H3G

100mm
50mm
10mm

PROPOSED MAX CONFIGURATION SITE PLAN



ELEVATION A

PROPOSED PAVING SLABS INSTALLED AT FOOT
OF CABINET DOORS ON GRASS AREA FOR
HEALTH AND SAFETY OF WORKERS ON SITE

PROPOSED 1No. MK5 LINK AC CABINET TO BE
INSTALLED ON PROPOSED ROOT FOUNDATION

PROPOSED 1No. POGONA CABINET TO BE
INSTALLED ON PROPOSED ROOT FOUNDATION

PROPOSED 1No. APM5930 CABINET TO BE
INSTALLED ON PROPOSED ROOT FOUNDATION

PROPOSED 2No. HUAWEI CABINETS TO BE
INSTALLED ON PROPOSED ROOT FOUNDATION

PROPOSED 12No. ANTENNA APERTURES TO BE
INSTALLED ON PROPOSED STREETWORKS MONOPOLE

PROPOSED 20m HIGH STREETWORKS MONOPOLE,
TO BE INSTALLED APPROXIMATELY 85.5m FROM THE
EXISTING LOCATION AT NGR E: 510152 N: 188088


PROPOSED DIPLEXER CABINET TO BE INSTALLED ON
PROPOSED ROOT FOUNDATION

PROPOSED 1No. HUAWEI CABINET TO BE
INSTALLED ON PROPOSED ROOT FOUNDATION


PROPOSED 1No. WILTSHIRE CABINET TO BE
INSTALLED ON PROPOSED ROOT FOUNDATION

HUME WAY

NOTE:
EXISTING SINGLE PHASE 100A SUPPLY TO BE UPGRADED TO
3 PHASE 100A SUPPLY WITHIN MK5 CABINET. EXISTING BT &
TX EQUIPMENT TO BE RELOCATED WITHIN MK5 CABINET

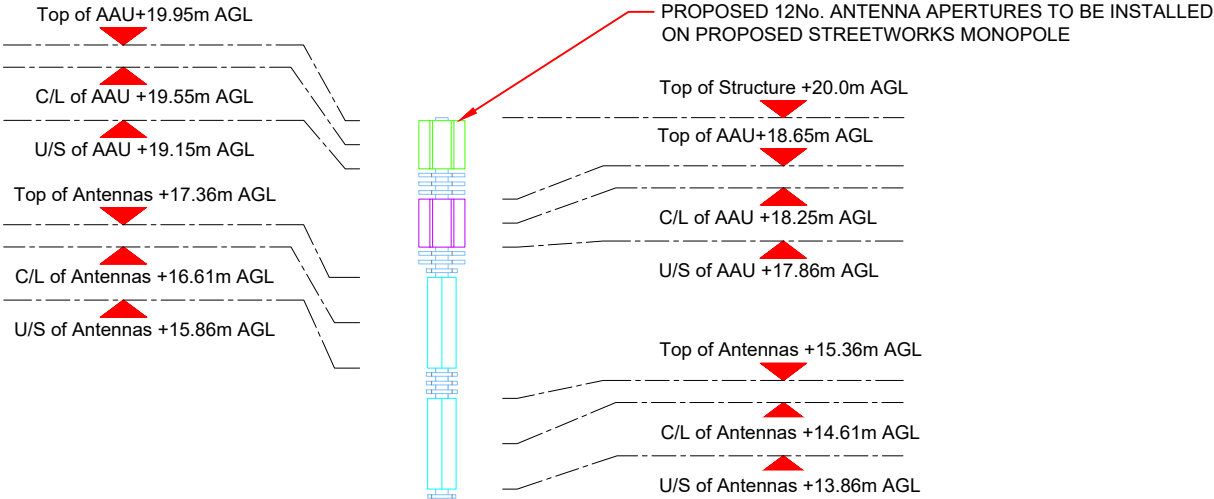


PROPOSED 20m HIGH STREETWORKS MONOPOLE,
TO BE INSTALLED APPROXIMATELY 85.5m FROM THE
EXISTING LOCATION AT NGR E: 510152 N: 188088

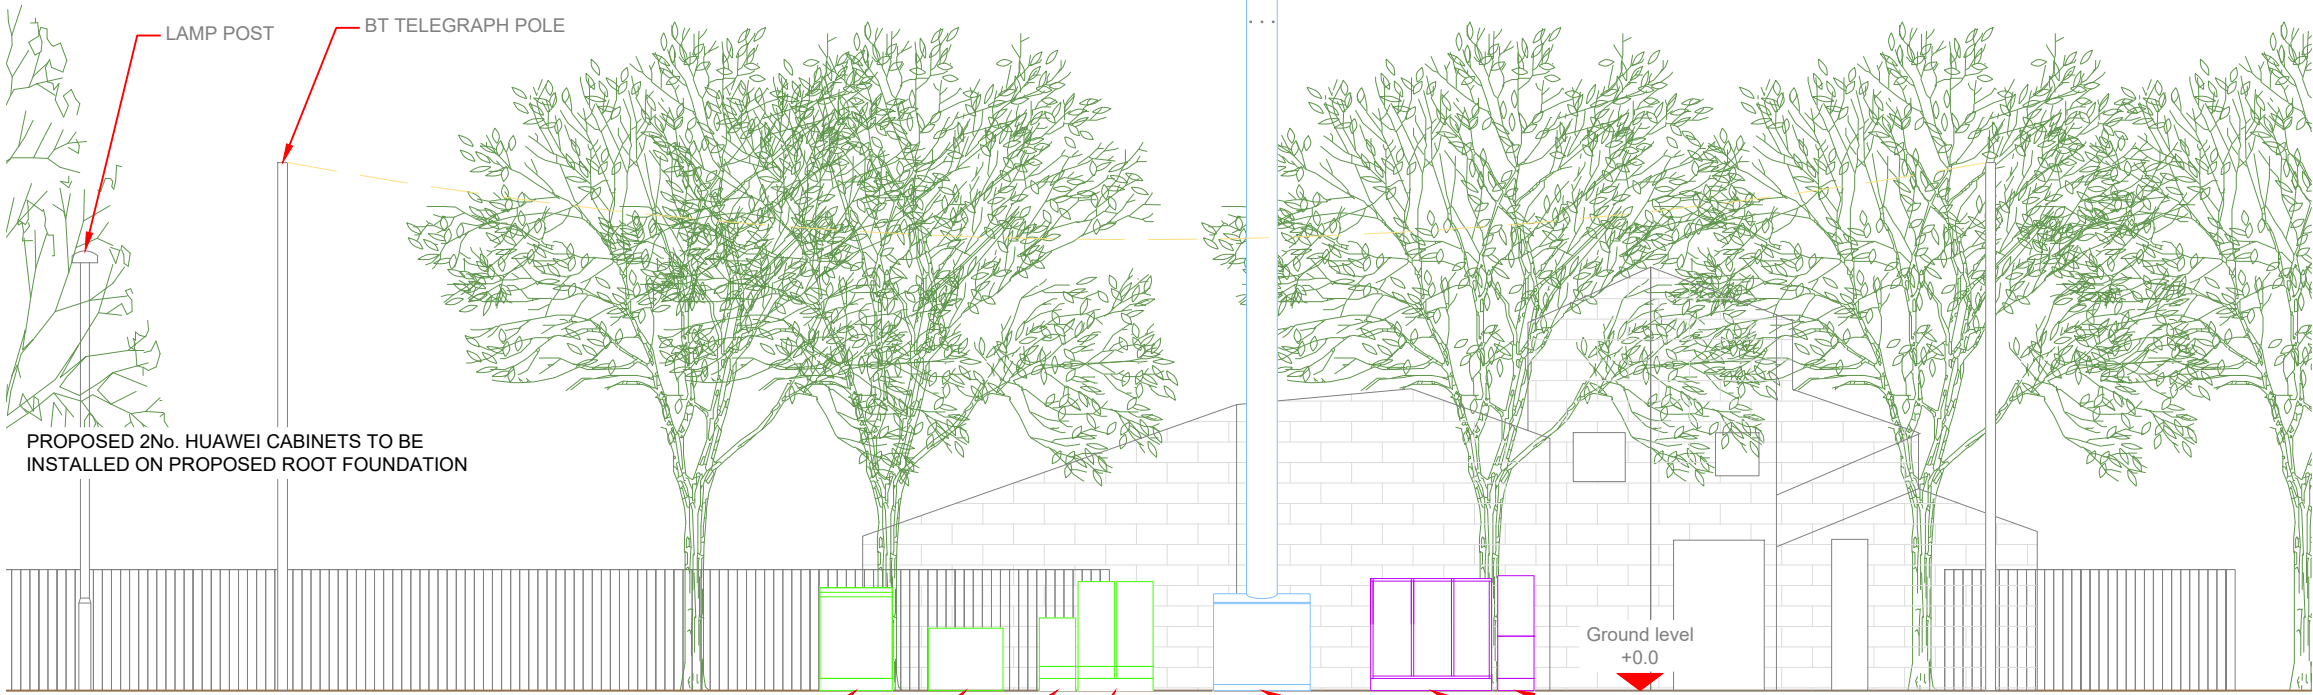

- PROPOSED 1No. MK5 LINK AC CABINET TO BE
INSTALLED ON PROPOSED ROOT FOUNDATION
- PROPOSED 1No. POGONA CABINET TO BE
INSTALLED ON PROPOSED ROOT FOUNDATION
- PROPOSED 1No. APM5930 CABINET TO BE
INSTALLED ON PROPOSED ROOT FOUNDATION
- PROPOSED 2No. HUAWEI CABINETS TO BE INSTALLED ON
PROPOSED ROOT FOUNDATION
- PROPOSED 1No. HUAWEI CABINET TO BE
INSTALLED ON PROPOSED ROOT FOUNDATION
- PROPOSED 1No. WILTSHIRE CABINET TO BE
INSTALLED ON PROPOSED ROOT FOUNDATION
- PROPOSED DIPLEXER CABINET TO BE
INSTALLED ON PROPOSED ROOT FOUNDATION

 PROPOSED MAX CONFIGURATION ELEVATION



Antenna Aperture ID	Proposed 4G/5G Bearing	Operator: Shared/ EE/H3G
A1	0°	H3G
A2	0°	EE
A3	0°	EE/H3G
A4	0°	EE/H3G
B1	120°	H3G
B2	120°	EE
B3	120°	EE/H3G
B4	120°	EE/H3G
C1	240°	H3G
C2	240°	EE
C3	240°	EE/H3G
C4	240°	EE/H3G

NOTES:
1. ALL DIMENSIONS IN MM UNLESS OTHERWISE NOTED.

Master:	MBNL / EE / H3G:	Project:	Purpose of Issue:	Issue:
M003	MBNL	T&A	Planning	C
Date:	14/04/2020	Revision / Upgrade Description:		
Drawn:	K. Soper	Amends to site topography		
Checked:	T. Clifford			
Approved:	M. Venner			
Master:	MBNL / EE / H3G:	Project:	Purpose of Issue:	Issue:
M002	MBNL	T&A	Planning	B
Date:	21/02/2020	Revision / Upgrade Description:		
Drawn:	K. Naveen	Site Location Change		
Checked:	T. Clifford			
Approved:	M. Venner			
Master:	MBNL / EE / H3G:	Project:	Purpose of Issue:	Issue:
M001	MBNL	T&A	Planning	A
Date:	01/08/2019	Revision / Upgrade Description:		
Drawn:	R. Manikandan	First Issue		
Checked:	T. Clifford			
Approved:	M. Venner			



Hutchison 3G UK Limited
Star House, 20 Grenfell Road
Maidenhead, SL6 1EH
Tel: 01628 765 000
Fax: 01628 765 001
H3G Base Station Information line:
0845 6043000
Available 8am-8pm Monday to Friday



Hatfield Business Park
Hatfield
Hertfordshire
AL10 9BW
Tel: 01707 315000
Fax: 01707 319001



Mobile Broadband Network Limited
Sixth Floor, Thames Tower, Station Road, Reading, RG1 1LX



BEACONCOMMS

UNIT E3 PITTS CLEAVE INDUSTRIAL ESTATE, TAVISTOCK, DEVON, PL19 0PW
sales@beaconcomms.co.uk Tel: +44 (0)1822 610610

Site Name:	HUME WAY		
Site ID:	732715		
Address:	HUME WAY RUISLIP HILLINGDON LONDON HA4 8DY		
Title:	266 MAX CONFIGURATION ELEVATION - SHEET 2		
Project:	T & A		
Purpose of Issue:	GENERAL ARRANGEMENT		
EE Cell ID:	70284	MBNL Cell ID:	HGN032
3UK Cell ID:	HA0072		
Master Drawing No:	732715_HGN032_70284_HA0072_M003		
Issue:	C		

SITE CAPACITY & LEAD OPERATOR			
A	B	C	LEAD
HS2	HS2	HS2	H3G