


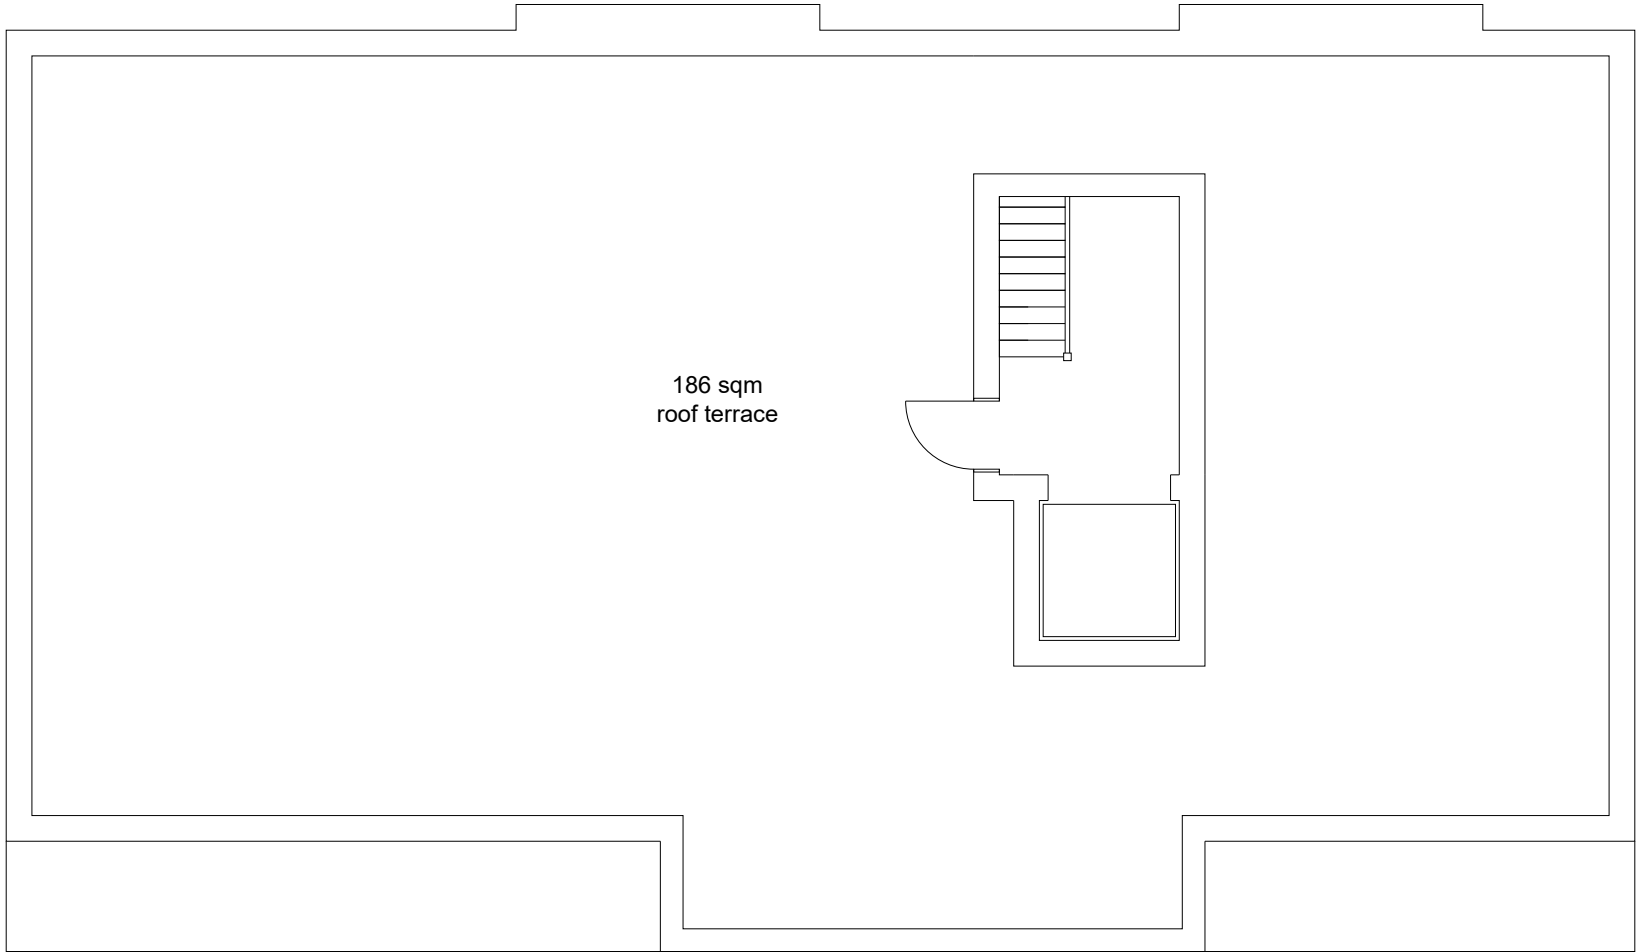



Fluent[®]
ARCHITECTURAL DESIGN SERVICES


FLUENT
ARCHITECTURAL DESIGN SERVICES

69-71 WINDMILL ROAD, SUNBURY,
MIDDLESEX, TW16 7DT
Tel: 0800 0438838
E-MAIL: INFO@FLUENT-ADS.CO.UK
WEB: FLUENT-ADS.CO.UK

Joel Street, Northwood
Third Floor Plan

Rev	Date	Description

 1 : 100 @ A3



Scale 1:100 @ A3	Dwg No. FLU.653.06
Date 05.01.18	Rev J
Drawn N.Millin	