



Surface Water Branch 1

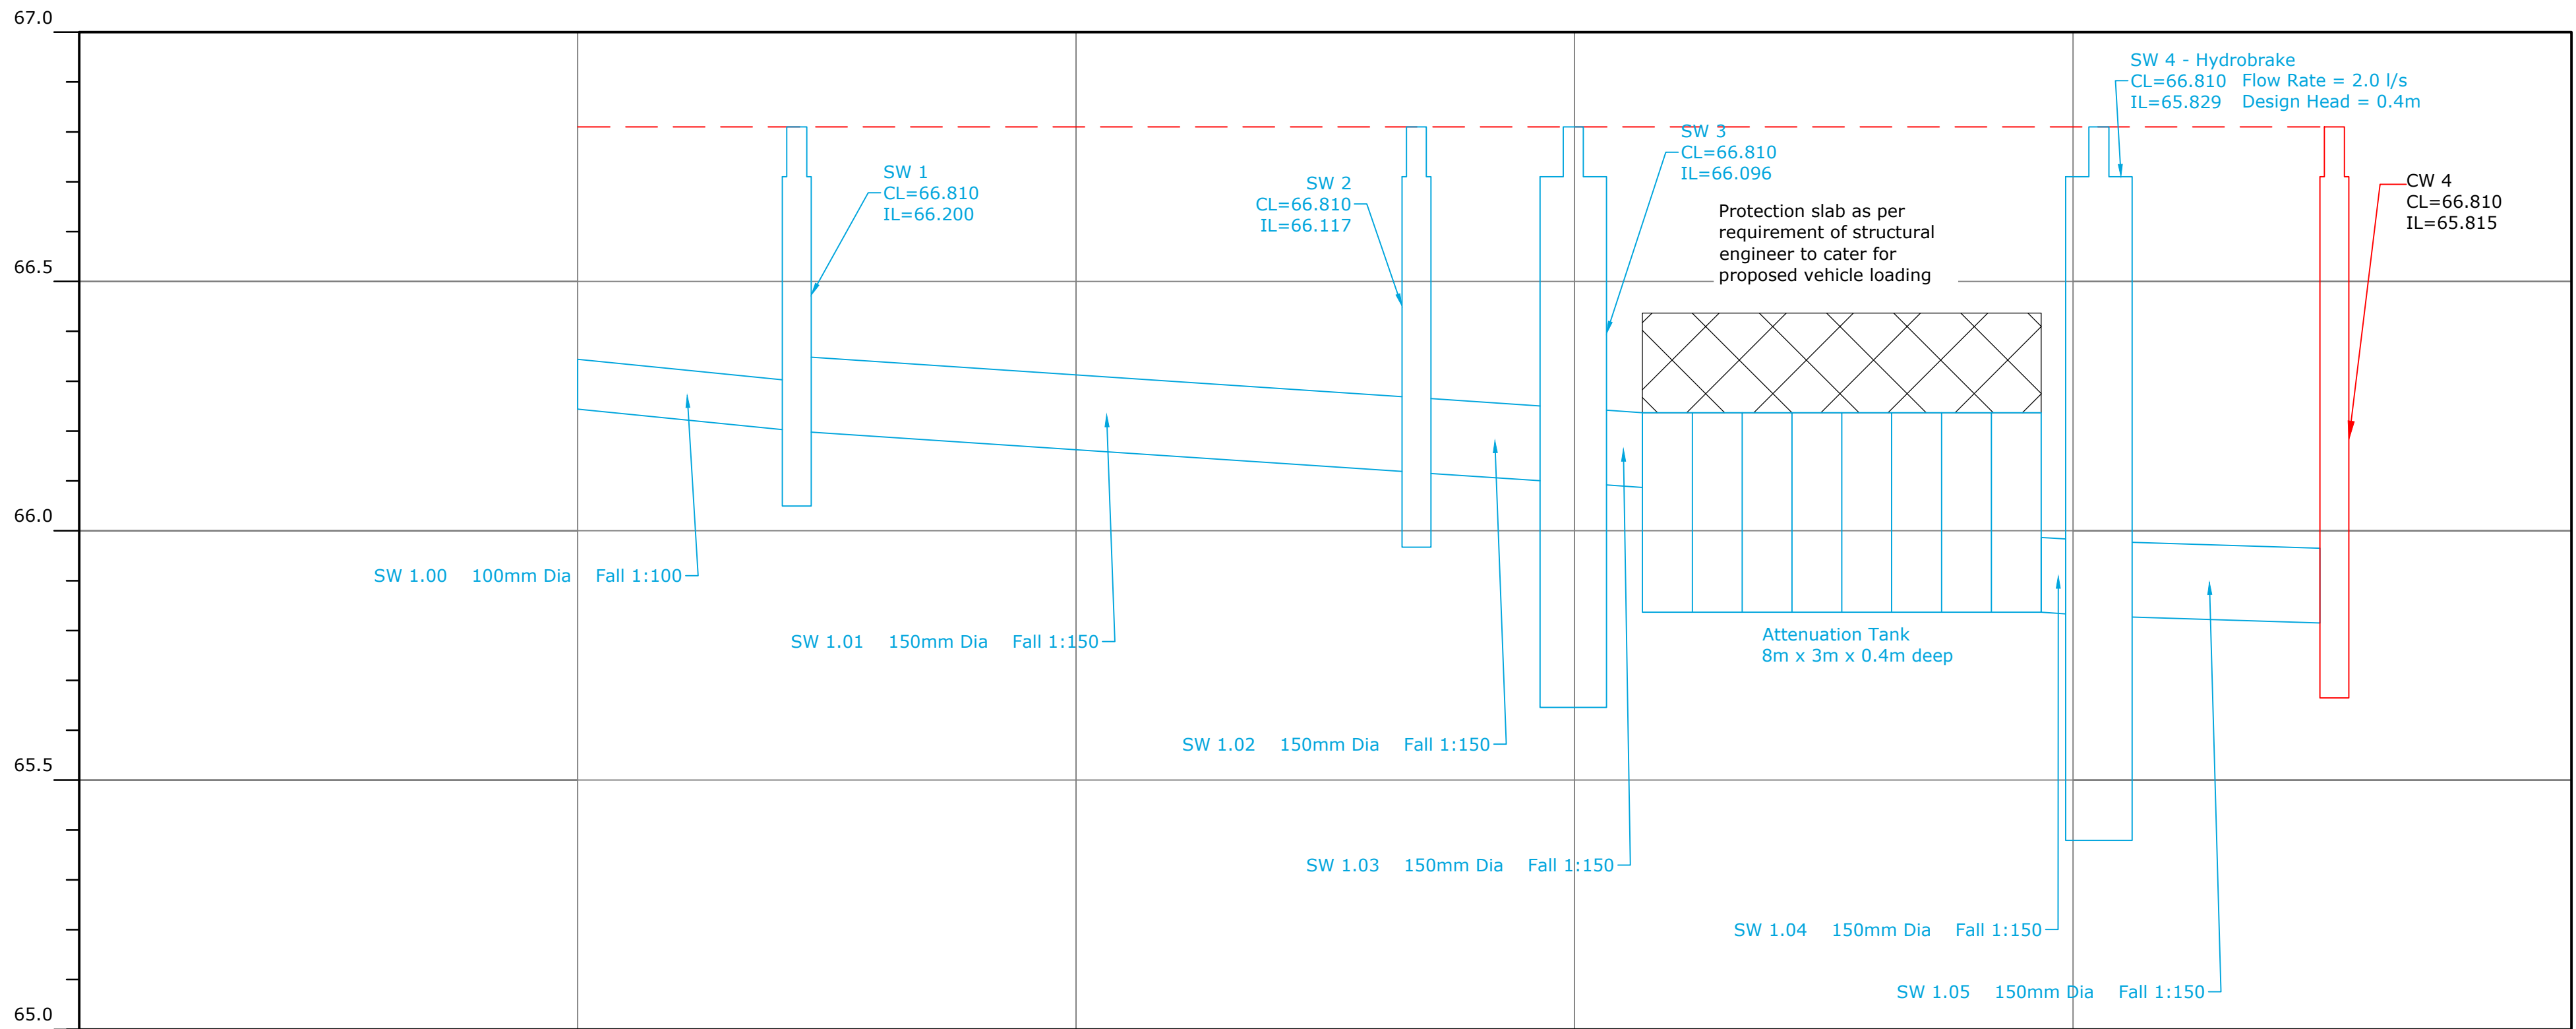

Foul Water Branch 1

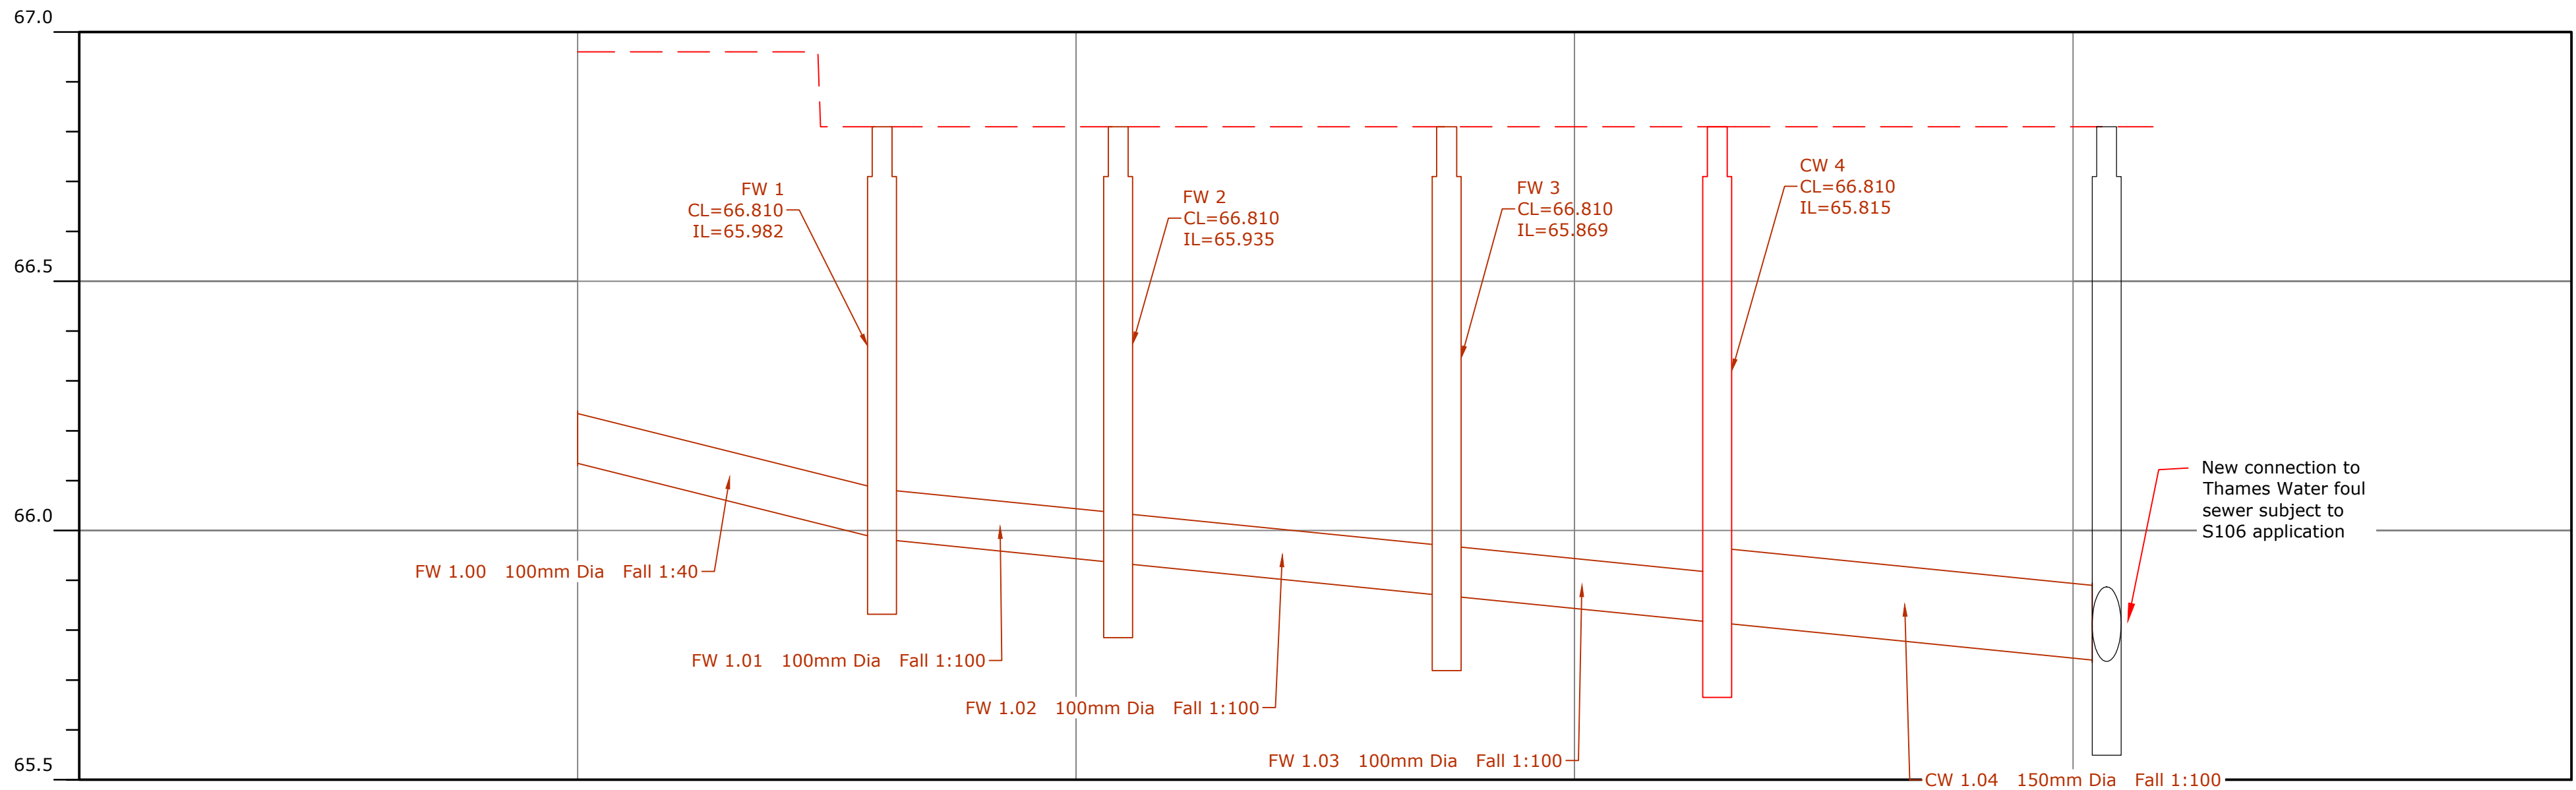

NOTES

Rev	Amendment	Drawn	Checked	Approved	Date

LANMOR Consulting
Civil Engineers & Transport Planning
Thorogood House, 34 Tolworth Close, Surbiton, Surrey, KT6 7EW
Telephone: 0208 339 7899 Fax: 0208 339 7898
e-mail: info@lanmor.co.uk
www.lanmor.co.uk

Joel Street
Northwood Hills
Drainage Layout
Foul and Surface Sewer Long Sections

2 of 3

DRAWN	MK	CHECKED	RS	APPROVED	KBL
DATE	Oct-18	DATE	Oct-18	DATE	Oct-18
SCALE	1:100	PRJ No.	181099	SIZE	REV
DWG No.	181099-520-01			A1	-