

 
 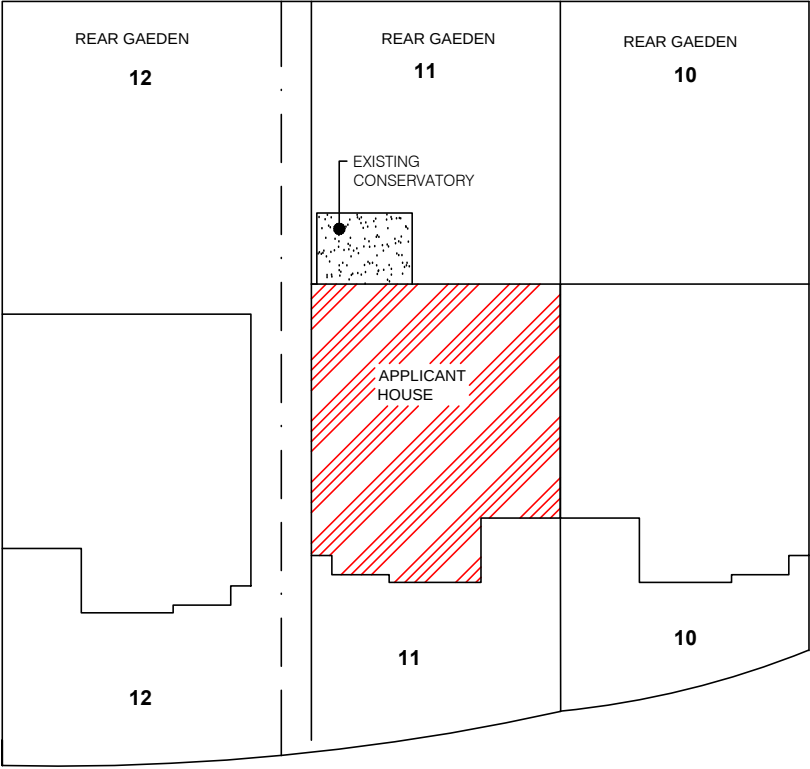


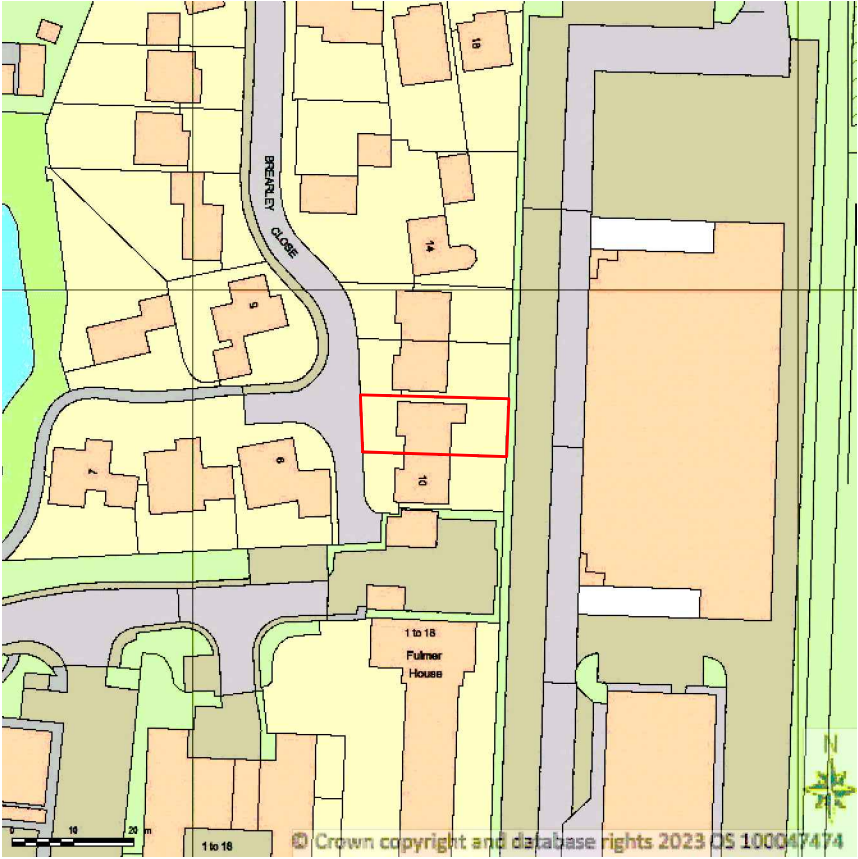

EXISTING - BLOCK PLAN
SCALE 1:250



LOCATION MAP
SCALE 1:1250



- NOTES**
- 1- ALL DIMENSIONS ARE IN MM
 - 2- THE CONTRACTORS SHALL CHECK ALL THE DIMENSIONS PRIOR TO COMMENCEMENT OF CONSTRUCTION AND REPORT ANY DISCREPANCY TO THE CLIENT.
 - 3- THE MATERIALS FOR NEW CONSTRUCTION SHALL BE SIMILAR TO THE EXISTING SO THAT THE NEW WORK SHALL BLEND INTO EXISTING.
 - 4- EXISTING AND PROPOSED DRAINAGE LAYOUT IS ONLY BASED ON LIMITED SITE INSPECTION. THE CONTRACTOR SHALL INVESTIGATE THIS FURTHER DURING CONSTRUCTION AND PROVIDE ADEQUATE SYSTEM TO CATER FOR ALL FACILITIES AND APPLIANCES.
 - 5- THESE DRAWINGS ARE ONLY FOR LOCAL AUTHORITY OR STATUTORY APPROVALS SUCH AS PLANNING PERMISSION, ETC.
 - 6- THE CLIENT RESPONSIBLE IN SERVING ALL THE APPROPRIATE PARTY WALL NOTICES UNDER PARTY WALL ACTS.

PROJECT: CONVERSION OF GARAGE AND SINGLE STOREY REAR EXTENSION	
DRAWN BY: IBRAHIM SHAIKH	CHECKED BY:
CLIENT: MR MANSOORALI GULAM ABBASS	
SITE ADDRESS: 11 BREARLEY CLOSE UXBRIDGE UB8 1JJ	
DRAWING TITLE: LOCATION MAP AND EXISTING BLOCK PLAN	
SCALE: AS SHOWN	DATE: JUNE 2023
DRAWING NO: 23/BC11/001	REV: