

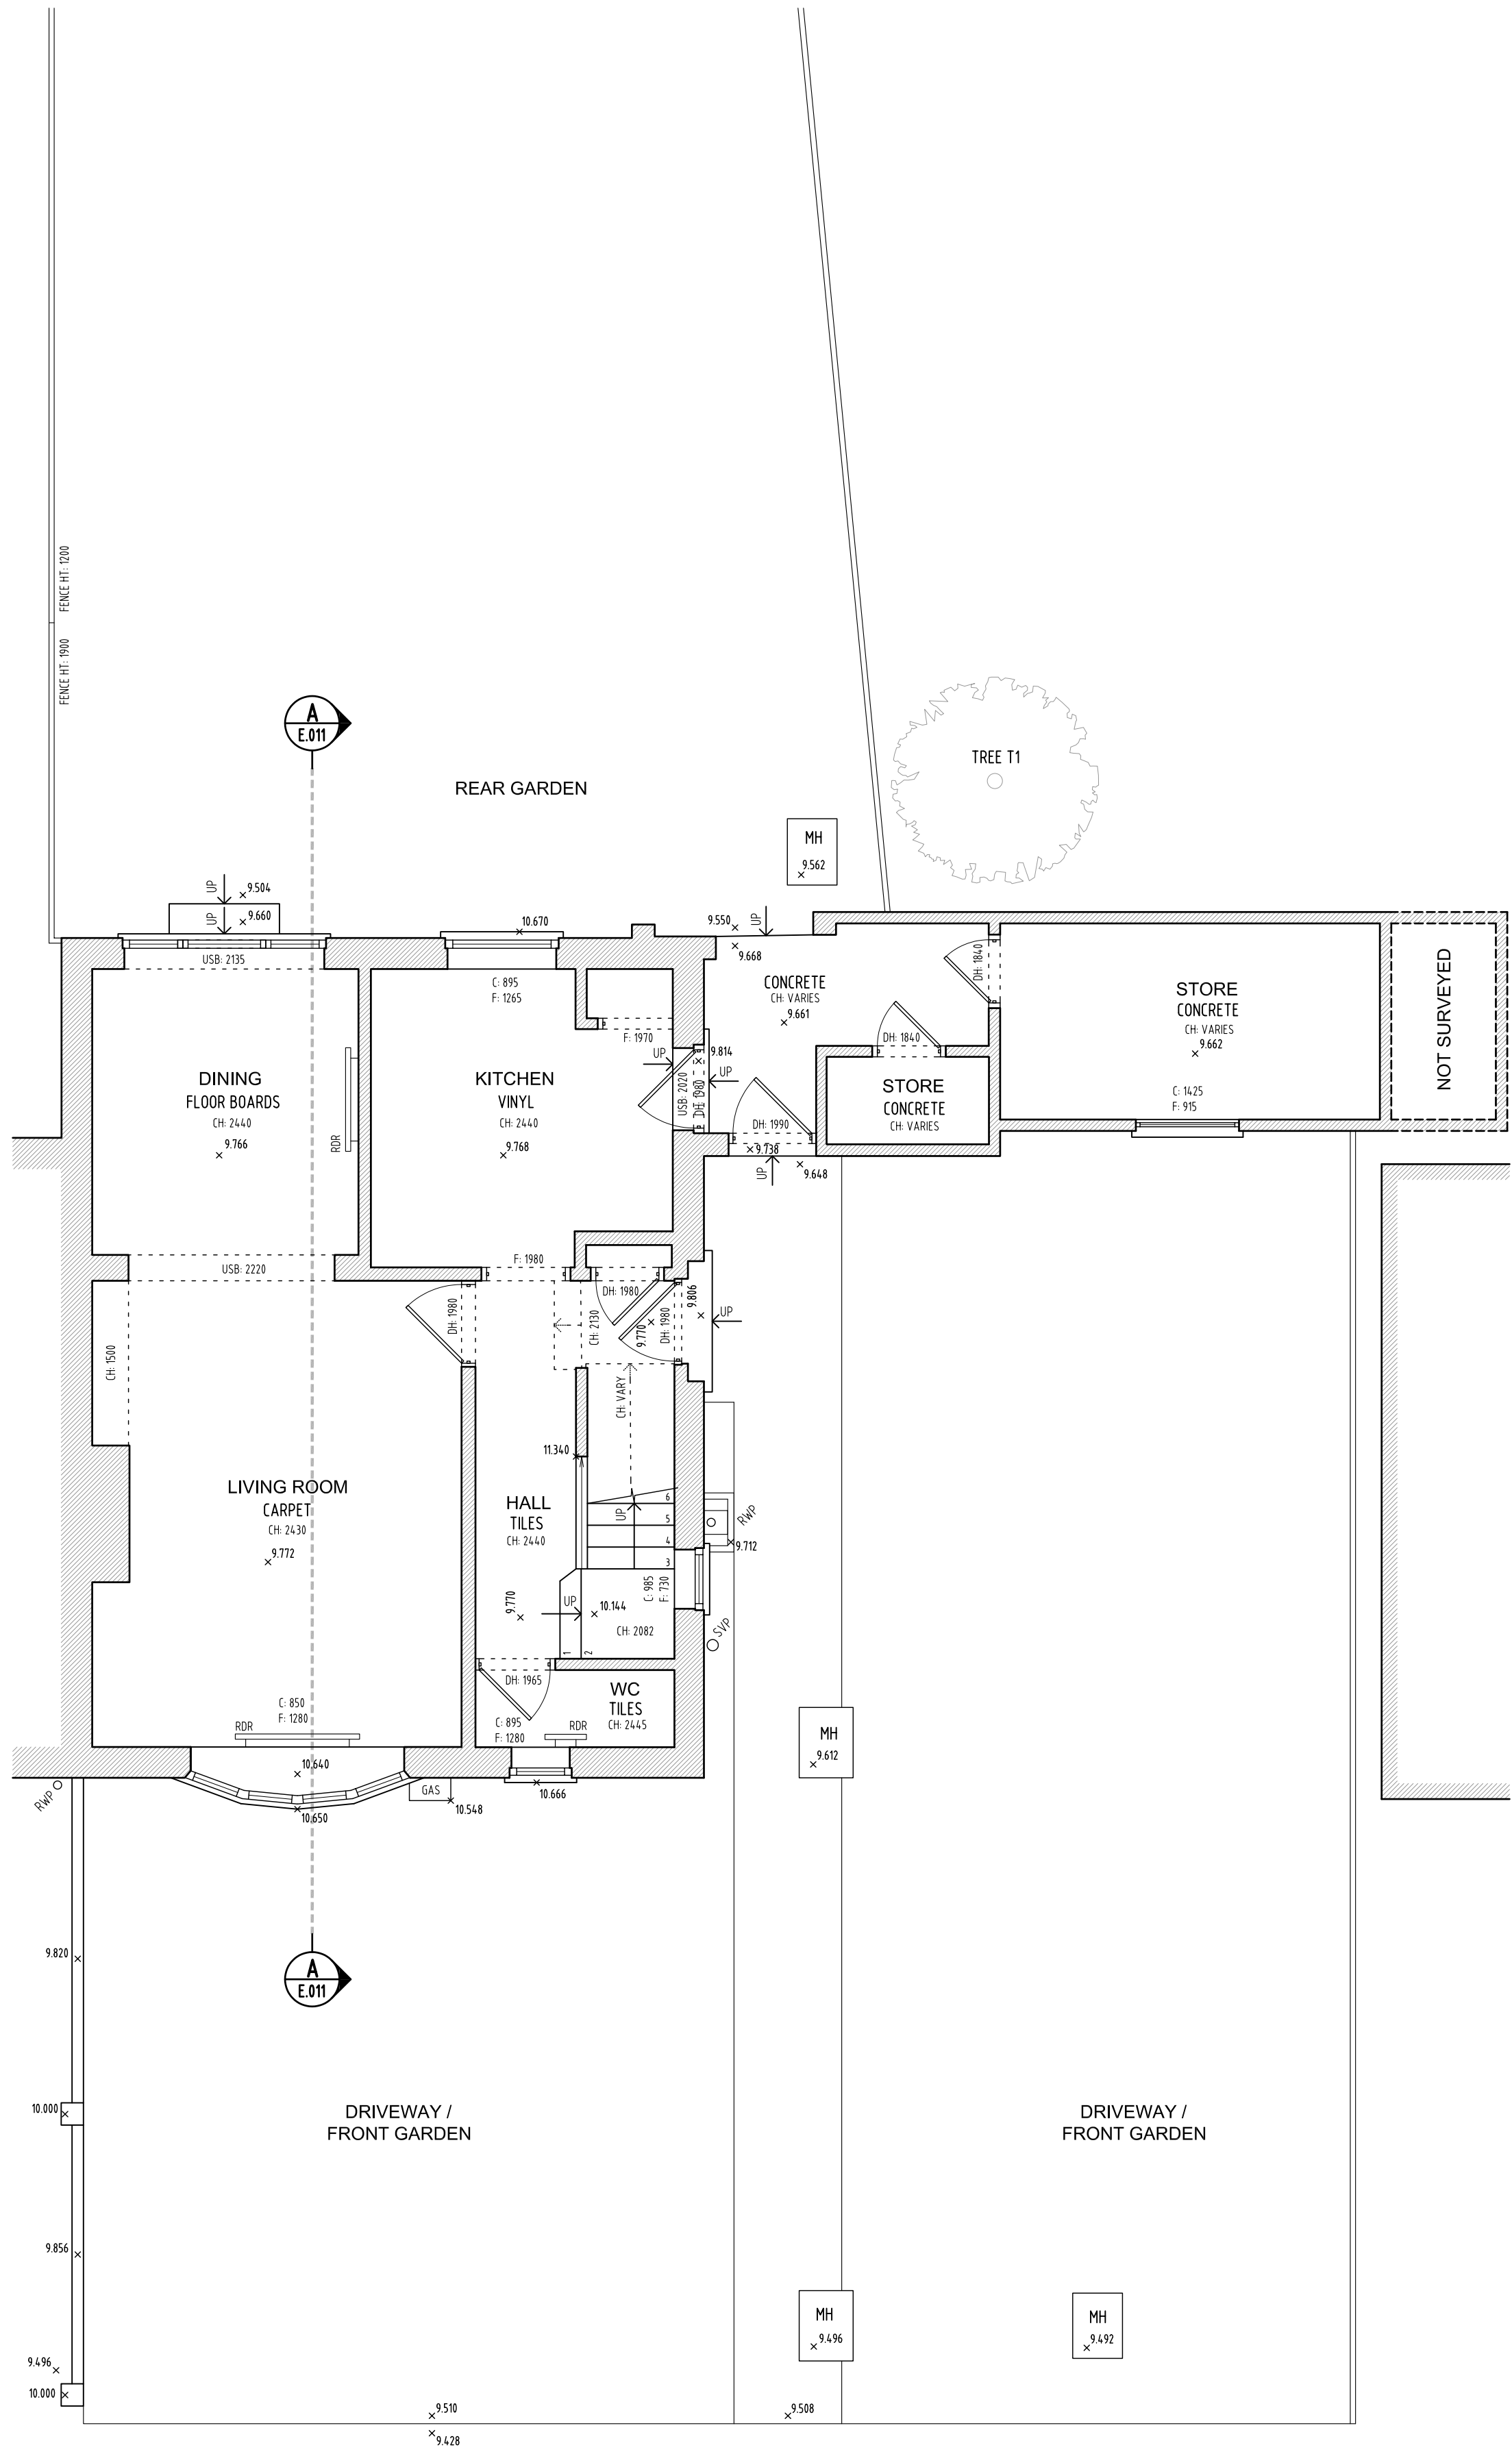


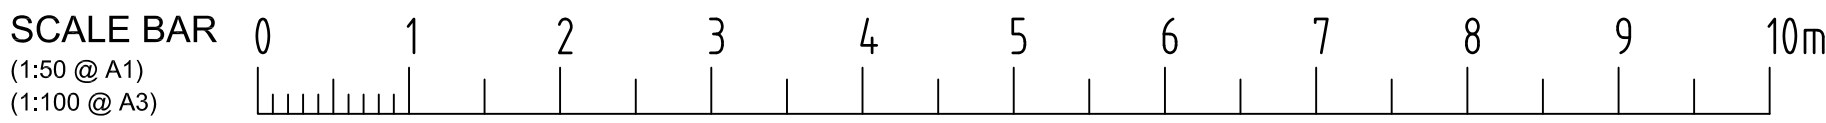


EXISTING GROUND FLOOR PLAN

SCALE 1:50

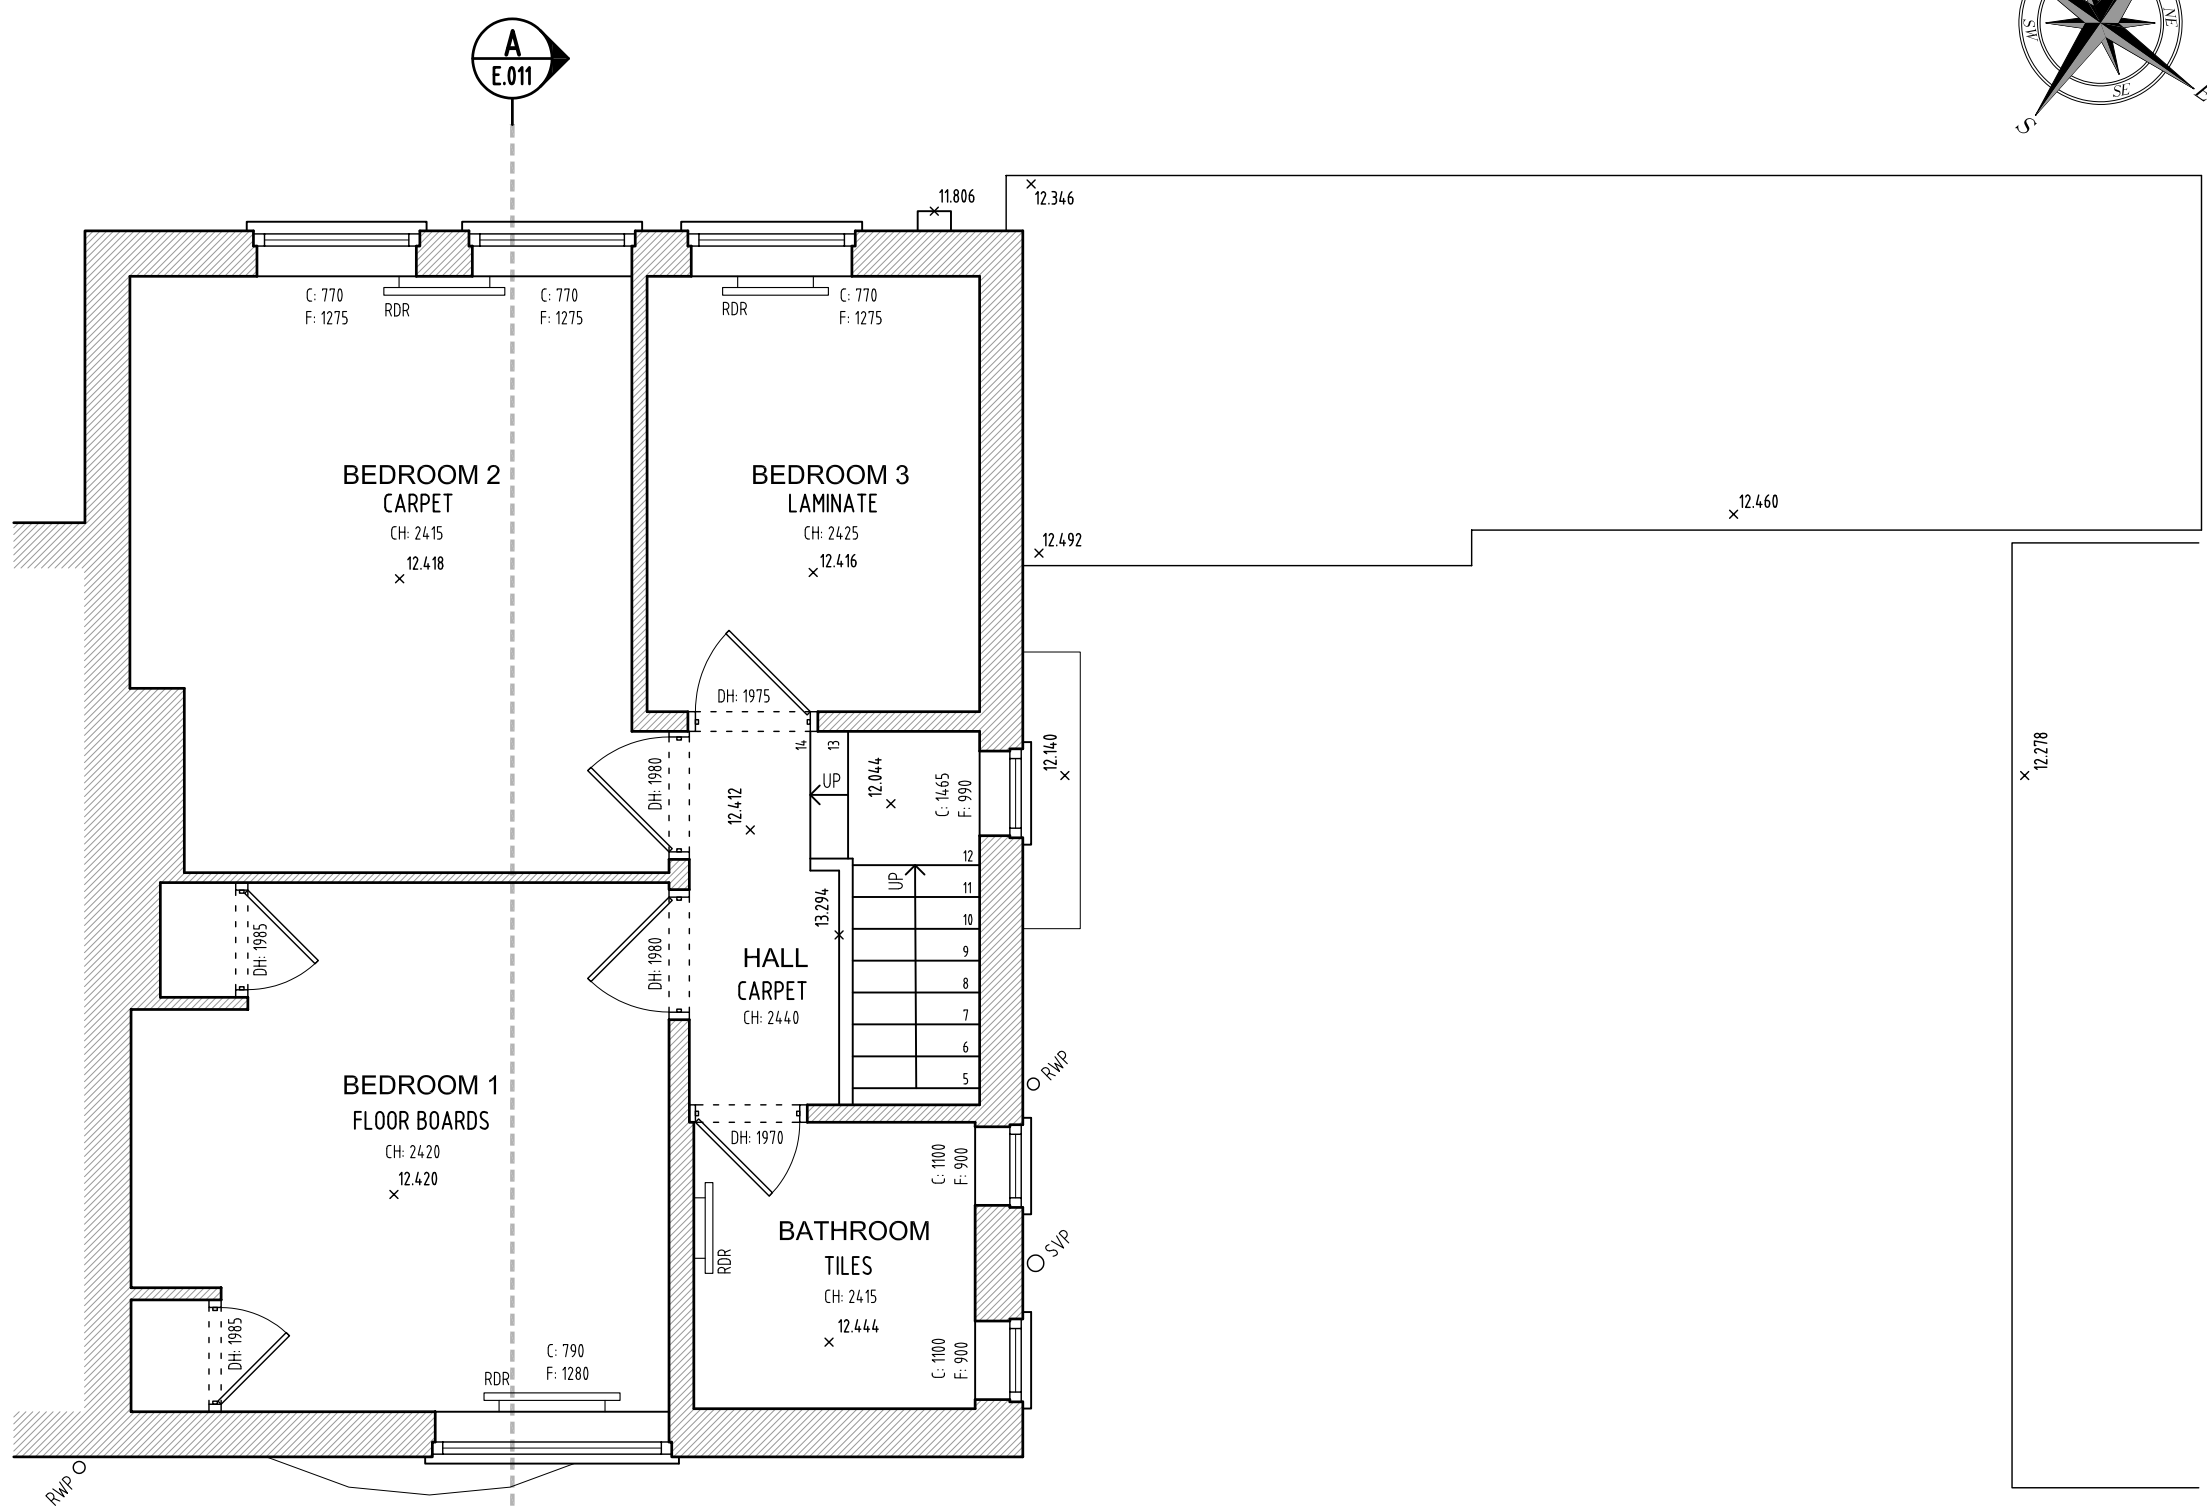

EXISTING FIRST FLOOR PLAN

SCALE 1:50

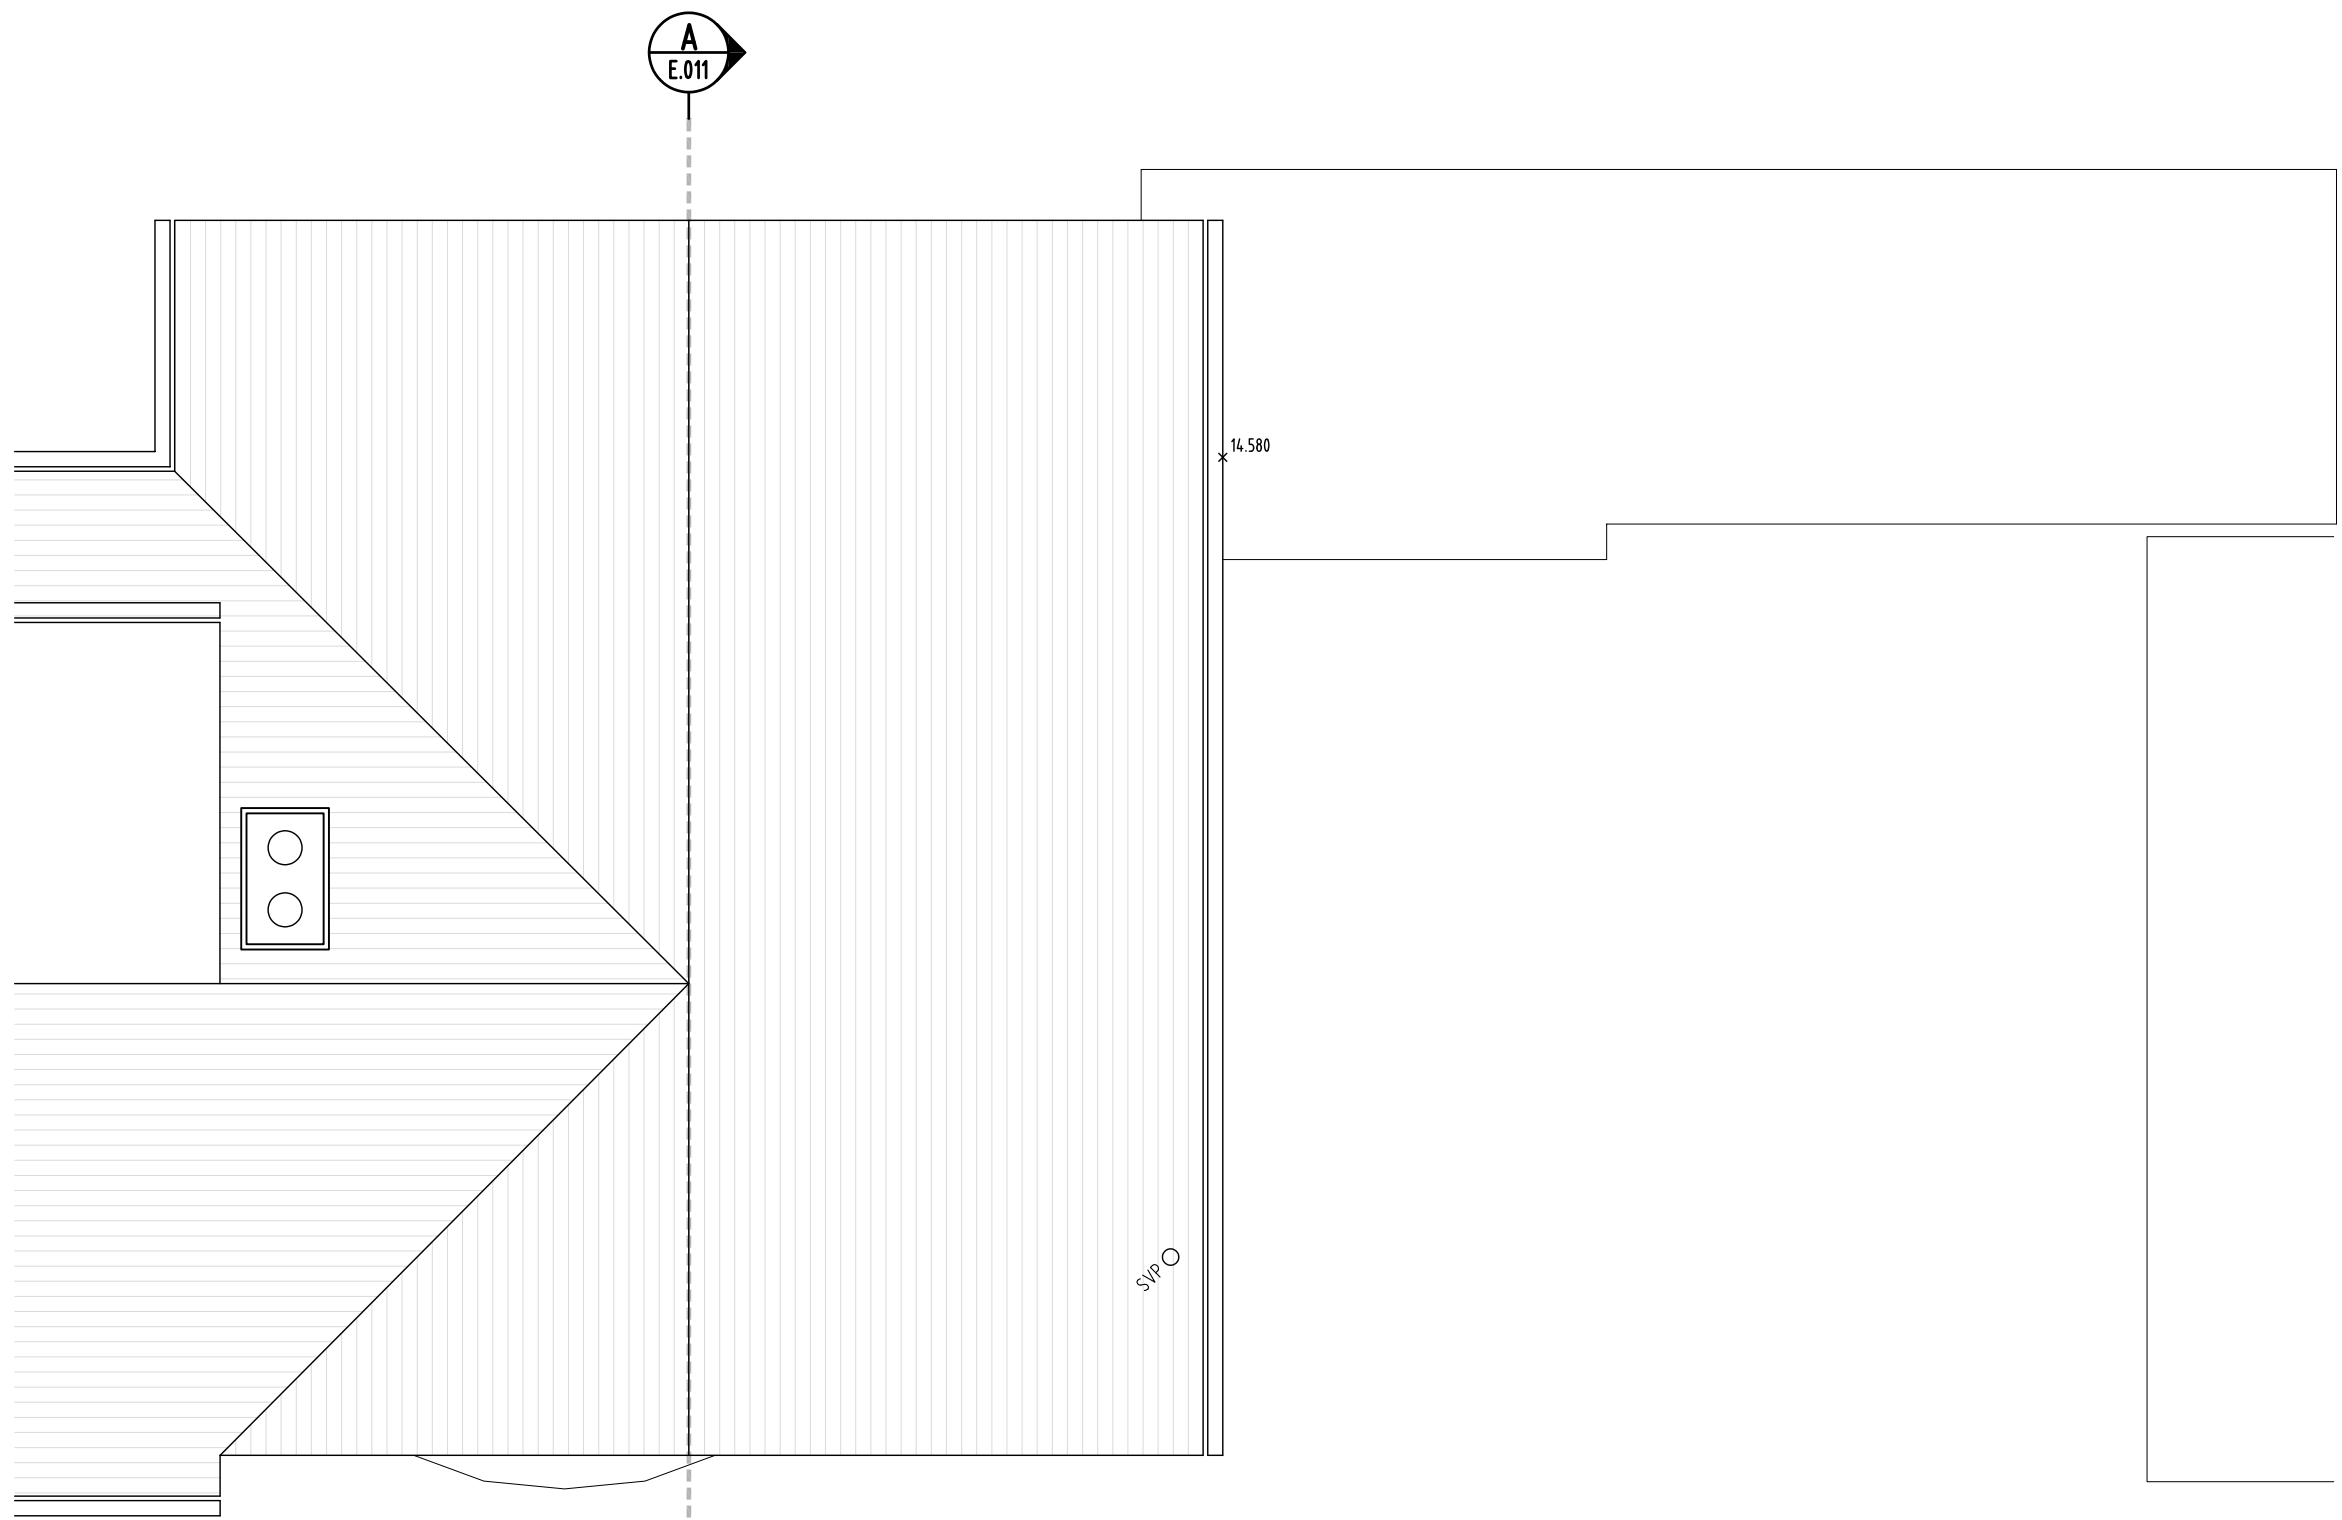

EXISTING ROOF PLAN

SCALE 1:50

NOTES

1. GENERAL:

- DO NOT SCALE FROM THIS DRAWING. CHECK ALL DIMENSIONS AND CONDITIONS ON SITE.
- ALL WORKS TO BE CARRIED OUT IN ACCORDANCE WITH CURRENT HEALTH & SAFETY (INCLUDING CDM) REGULATIONS. ALL WORKS TO COMPLY WITH CURRENT BRITISH STANDARDS, CODES OF PRACTICE, BUILDING REGULATIONS AND APPROPRIATE EUROPEAN STANDARDS.
- ALL STRUCTURAL WORK IS TO BE CARRIED OUT IN ACCORDANCE WITH THE STRUCTURAL ENGINEER'S DETAILS AND CALCULATIONS.
- PRECISE POSITIONS OF ALL FIXTURES AND FITTINGS IS SUBJECT TO CONFIRMATION ON SITE.
- THIS DRAWING IS PRODUCED FOR PLANNING APPLICATION ONLY AND SHOULD NOT BE USED FOR ANY OTHER PURPOSES.

2. SURVEY NOTES:

- THE SURVEY HAS BEEN COMPUTED ON AN ARBITRARY GRID.
- ALL LEVELS ARE IN METRES AND RELATED TO AN ARBITRARY SITE DATUM.
- ALL LEVELS ARE TAKEN WITH ZIPLEVEL 25 AND ARE $\pm 5mm$.
- ALL DIRECTION ARROWS INDICATE 'UP' UNLESS OTHERWISE STATED.
- DRAINAGE PIPE SIZES (WHERE SHOWN) HAVE BEEN GAUGED FROM THE SURFACE (FOR SAFETY REASONS) AND SHOULD BE REGARDED AS APPROXIMATE ONLY.
- VISIBLE FEATURES IN THE VICINITY OF ANY BOUNDARIES, AS SHOWN ON THE SURVEY, MAY NOT REPRESENT THE EXTEND OF LEGALLY CONVEYED OWNERSHIP.
- WHILST EVERY EFFORT HAS BEEN MADE TO DETERMINE WALL MATERIALS, NO GUARANTEE IS GIVEN. MATERIALS SHOULD BE REGARDED AS ASSUMED UNLESS VERIFIED BY A QUALIFIED THIRD PARTY.

STANDARD ABBREVIATIONS:

ACU AIR CONDITIONING UNIT
AH ACCESS HATCH
CH CEILING HEIGHT
C CILL HEIGHT
DH DOOR HEAD HEIGHT
F FRAME HEIGHT
HWT HOT WATER TANK
MH MANHOLE
NTS NOT TO SCALE
RDR RADIATOR
RL ROOF LIGHT
RWP RAIN WATER PIPE
SVP SOIL VENT PIPE
USB UNDER SIDE BEAM
WHT WALL HEIGHT
WP WASTE WATER PIPE

REV	DATE	DESCRIPTION	BY
-----	------	-------------	----

DRG STATUS **PLANNING**

DRAWN BY **ISP DRAWING SOLUTIONS**

JOB TITLE **10 PADDOCK ROAD
RUISLIP, HA4 0QX**

DRG TITLE **EXISTING GROUND, FIRST FLOOR
AND ROOF PLANS**

ISP
Drawing
Solutions

ISP DRAWING SOLUTIONS
21 MONKS CLOSE
MIDDLESEX, HA4 0HX
TEL: 0044 7886116912
EMAIL: info@ispdrawingsolutions.co.uk
www.ispdrawingsolutions.co.uk

JOB NO	DRG NO	REV	SCALE	DATE
1234	E.001	/	1:50 @ A1 1:100 @ A3	03/2022