


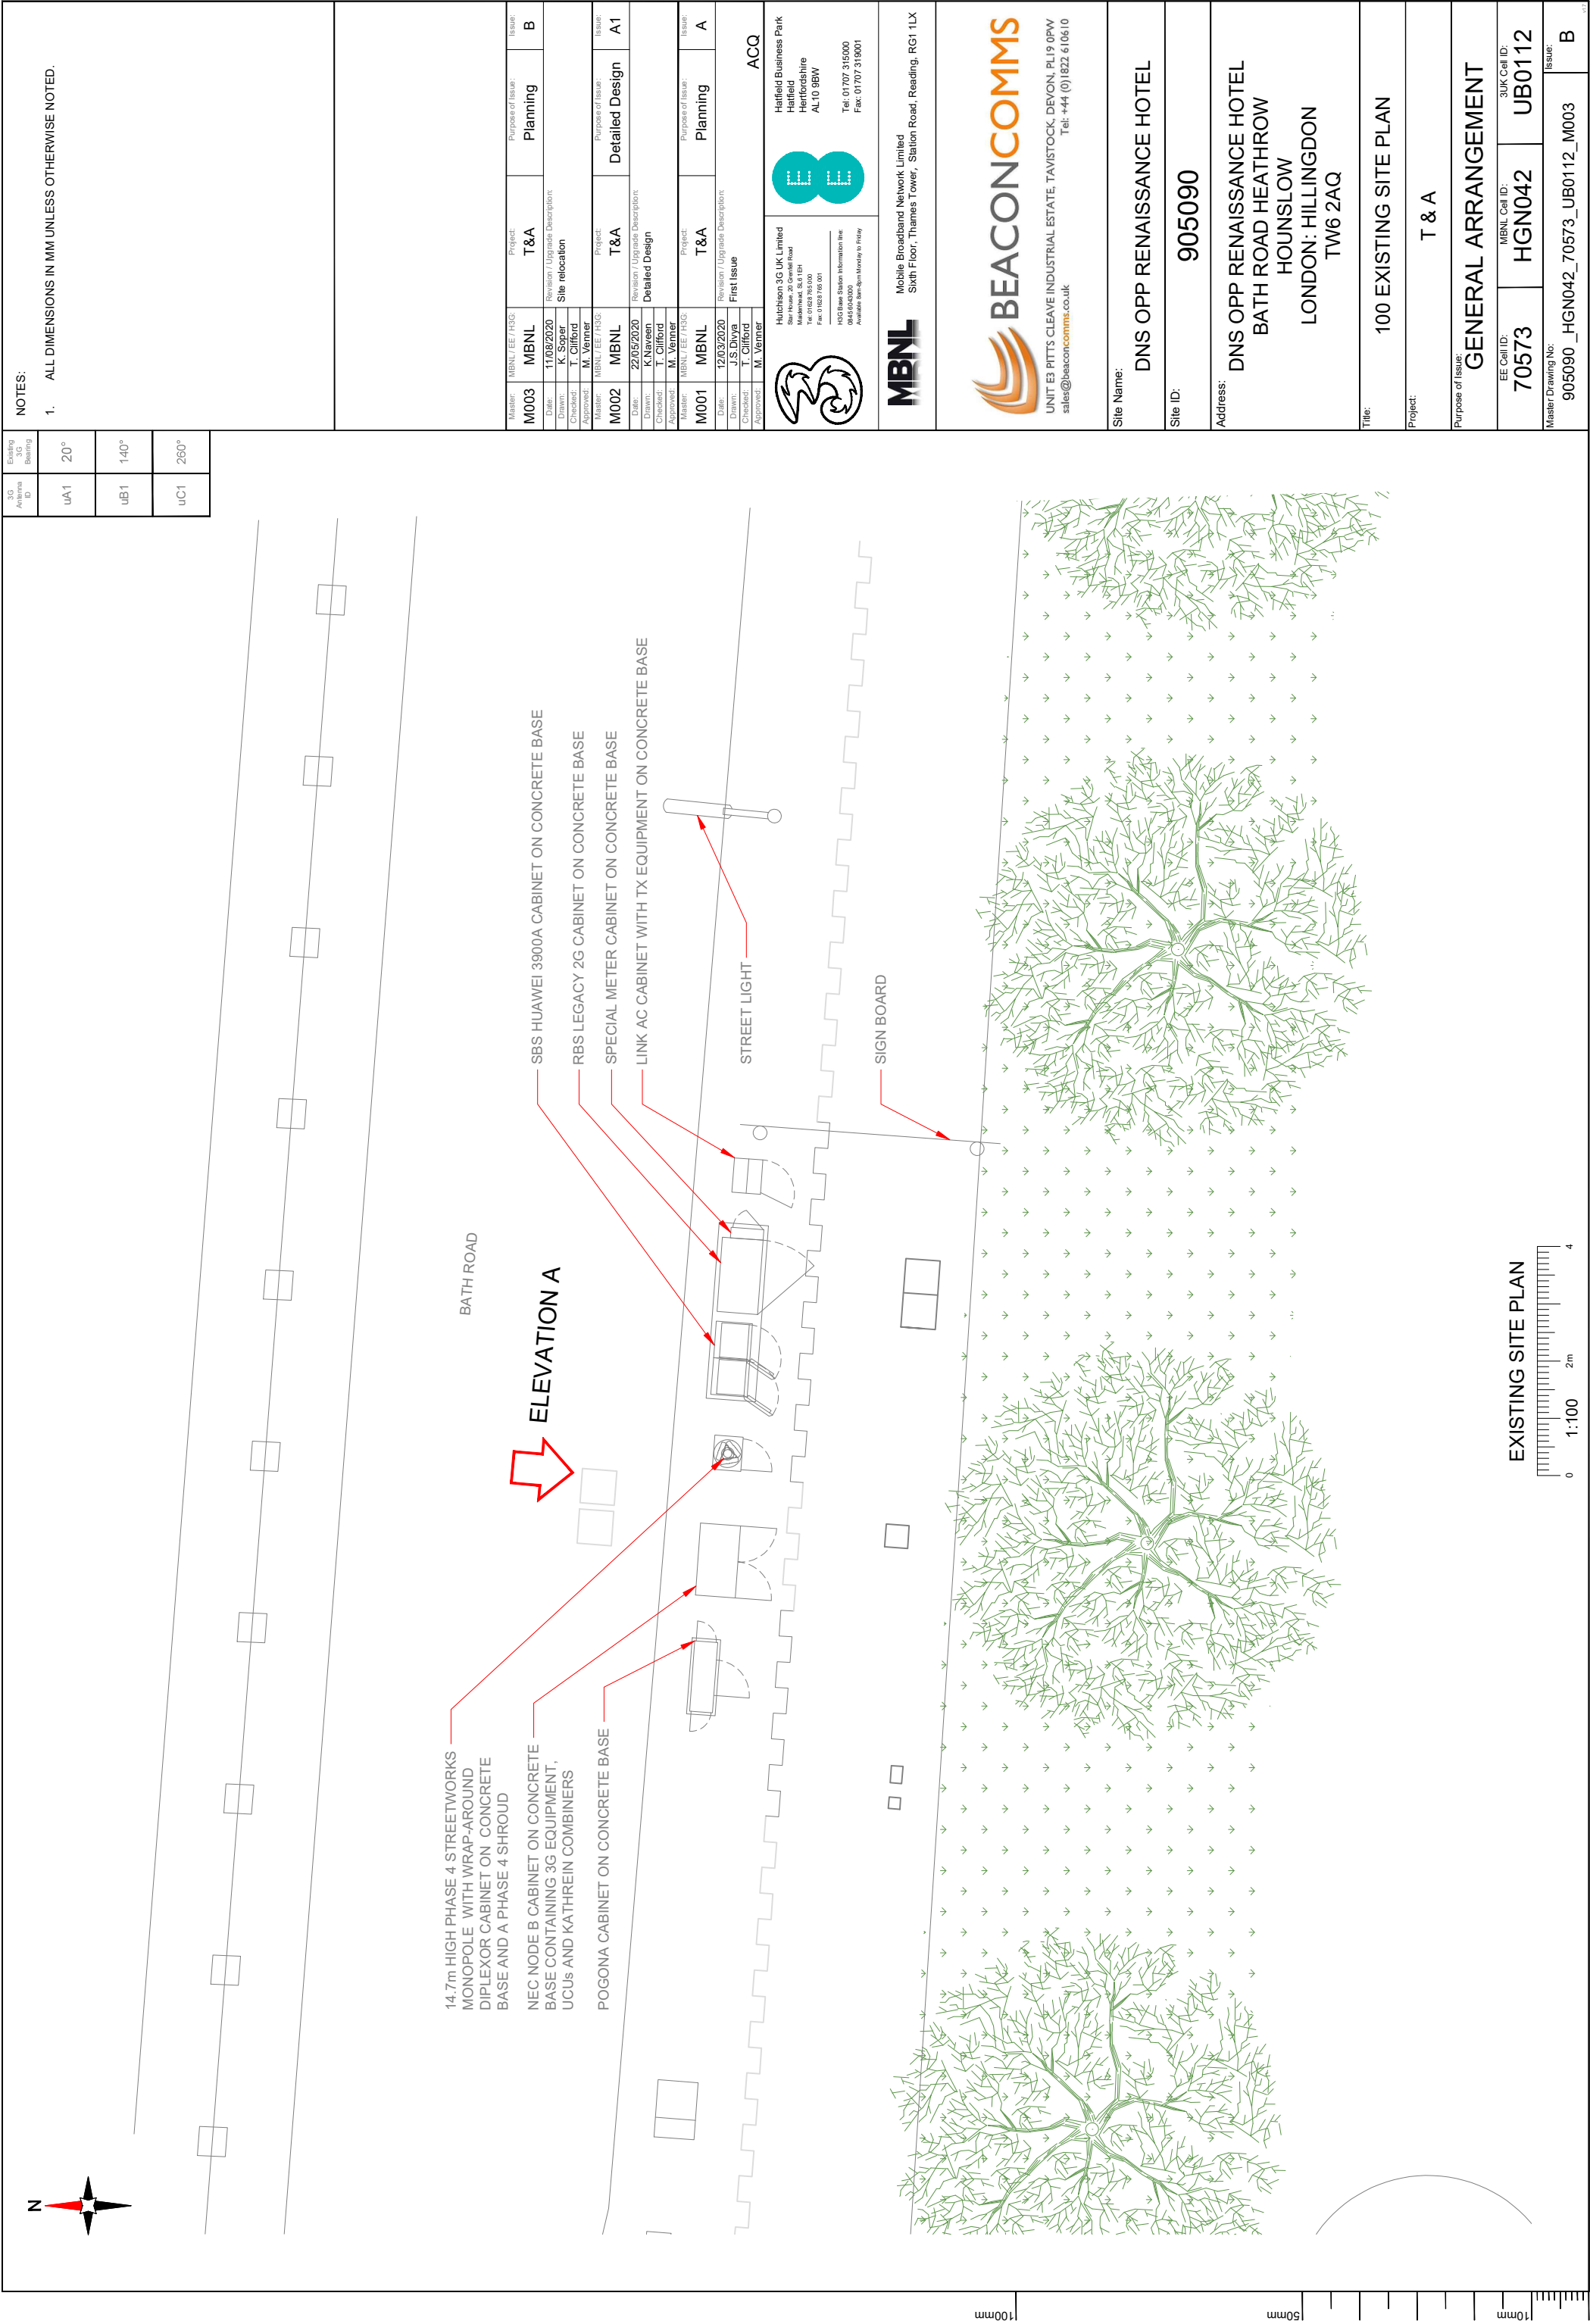

3G Antenna ID	Existing 3G Bearing
uA1	20°
uB1	140°
uC1	260°

NOTES:

1. ALL DIMENSIONS IN MM UNLESS OTHERWISE NOTED.

Master:	MBNL / EE / H3G	Project:	T&A	Purpose of Issue:	Planning	Issue:	B
M003	MBNL	T&A					
Date:	11/08/2020	Revision / Upgrade Description:	Site relocation				
Drawn:	K. Soper						
Checked:	T. Clifford						
Approved:	M. Venner						
Master:	MBNL / EE / H3G	Project:	T&A	Purpose of Issue:	Detailed Design	Issue:	A1
M002	MBNL	T&A					
Date:	22/05/2020	Revision / Upgrade Description:	Detailed Design				
Drawn:	K.Naveen						
Checked:	T. Clifford						
Approved:	M. Venner						
Master:	MBNL / EE / H3G	Project:	T&A	Purpose of Issue:	Planning	Issue:	A
M001	MBNL	T&A					
Date:	12/03/2020	Revision / Upgrade Description:	First Issue				
Drawn:	J.S. Divya						
Checked:	T. Clifford						
Approved:	M. Venner						



Hutchison 3G UK Limited
Sixth Floor, Thames Tower,
Station Road, Reading, RG1 1LX
Tel: 01707 315000
Fax: 01707 319001



Hatfield Business Park
Hatfield
Hertfordshire
AL10 9BW
Tel: 01707 315000
Fax: 01707 319001



 
Mobile Broadband Network Limited
Sixth Floor, Thames Tower, Station Road, Reading, RG1 1LX


100mm

50mm

10mm

EXISTING SITE PLAN



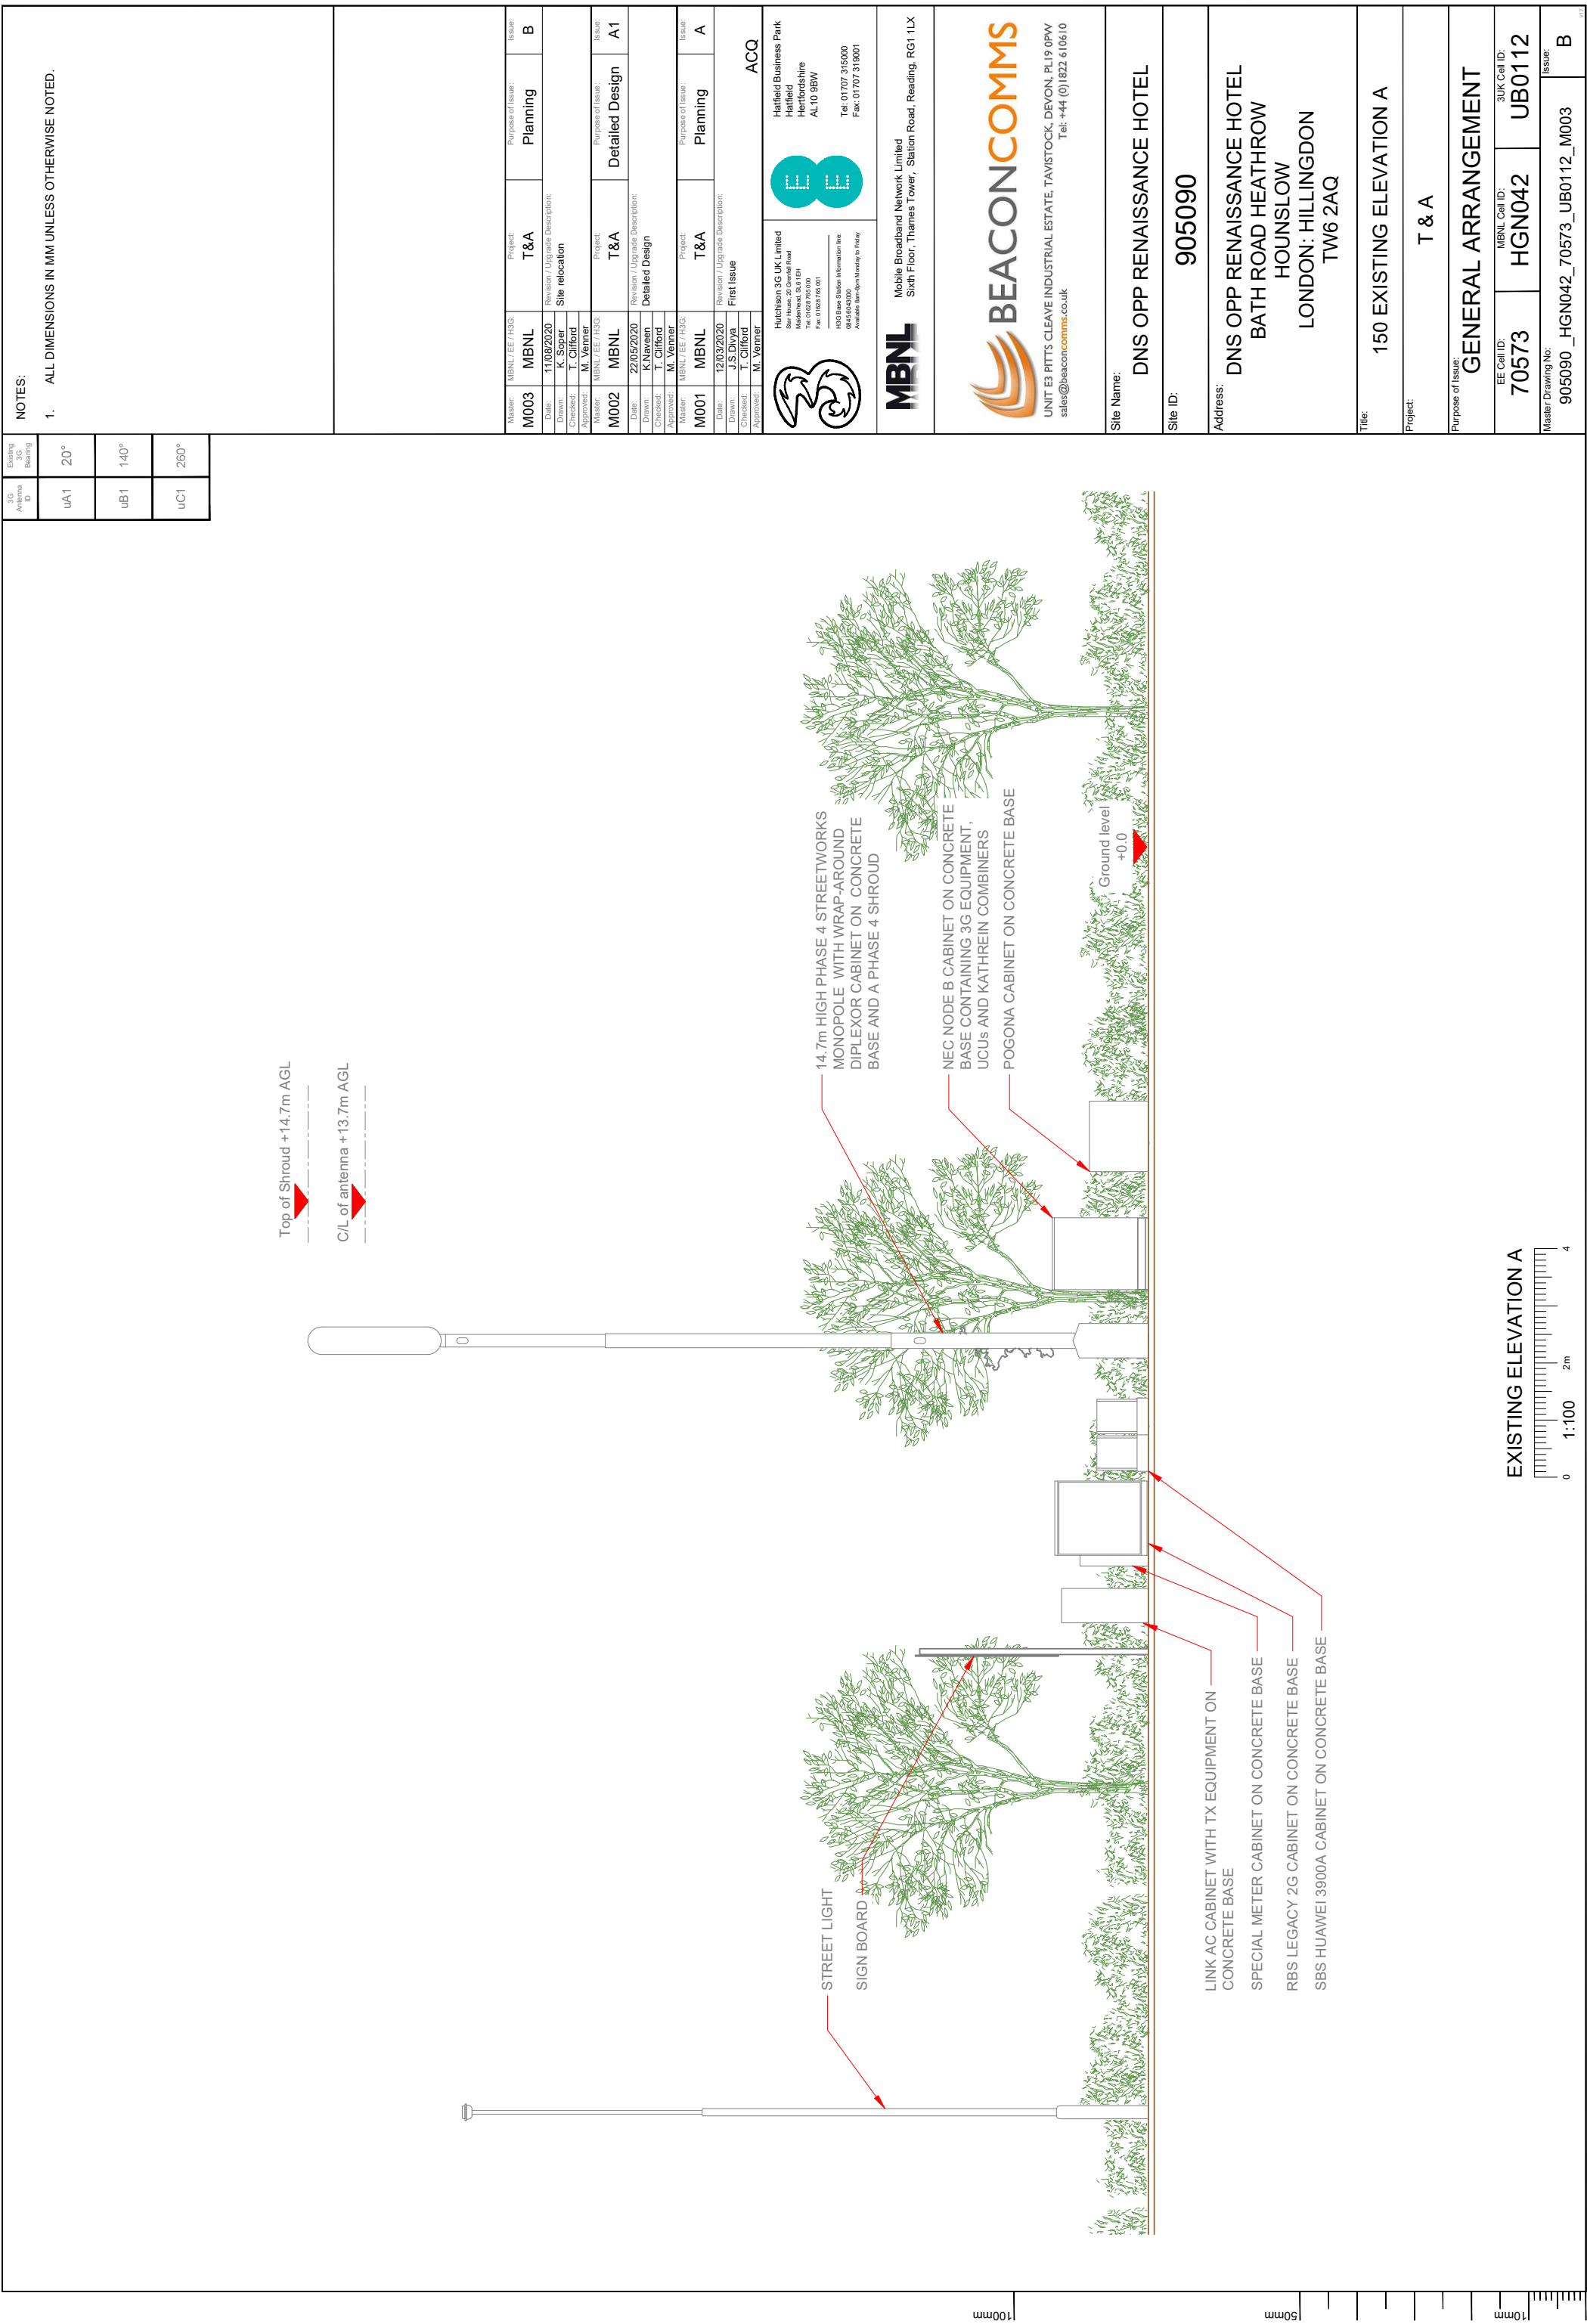

NOTES:

1. ALL DIMENSIONS IN MM UNLESS OTHERWISE NOTED.

Master:	MBNL / EE / H3G:	Project:	T&A	Purpose of Issue:	Planning	Issue:	B
M003	MBNL						
Date:	11/08/2020	Revision / Upgrade Description:					
Drawn:	K. Soper	Site relocation					
Checked:	T. Clifford						
Approved:	M. Venner						
Master:	MBNL / EE / H3G:	Project:	T&A	Purpose of Issue:	Detailed Design	Issue:	A1
M002	MBNL						
Date:	22/05/2020	Revision / Upgrade Description:					
Drawn:	K.Naveen	Detailed Design					
Checked:	T. Clifford						
Approved:	M. Venner						
Master:	MBNL / EE / H3G:	Project:	T&A	Purpose of Issue:	Planning	Issue:	A
M001	MBNL						
Date:	12/03/2020	Revision / Upgrade Description:					
Drawn:	J.S Divya	First Issue					
Checked:	T. Clifford						
Approved:	M. Venner						

Hutchison 3G UK Limited
Sixth Floor, Thames Tower, Station Road, Reading, RG1 1LX
Hatfield Business Park
Hatfield
Hertfordshire
AL10 9BW
Tel: 01707 315000
Fax: 01707 319001

EE

MBNL
Mobile Broadband Network Limited
Sixth Floor, Thames Tower, Station Road, Reading, RG1 1LX

BEACONCOMMS
UNIT E3 PITTS CLEAVE INDUSTRIAL ESTATE, TAVISTOCK, DEVON, PL19 0PW
sales@beaconcomms.co.uk
Tel: +44 (0)1822 610610

Site Name:	DNS OPP RENAISSANCE HOTEL	
Site ID:	905090	
Address:	DNS OPP RENAISSANCE HOTEL BATH ROAD HEATHROW HOUNSLOW LONDON: HILLINGDON TW6 2AQ	
Title:	150 EXISTING ELEVATION A	
Project:	T & A	
Purpose of Issue: GENERAL ARRANGEMENT		
EE Call ID:	MBNL Call ID:	3UK Call ID:
70573	HGN042	UB0112
Master Drawing No: 905090_HGN042_70573_UB0112_M003		Issue: B

A2	20°	H3G
A3	20°	EE/H3G
A4	20°	EE/H3G
B1	140°	EE
B2	140°	H3G
B3	140°	EE/H3G
B4	140°	EE/H3G
C1	260°	EE
C2	260°	H3G
C3	260°	EE/H3G
C4	260°	EE/H3G

C2	260°	H3G
C3	260°	EE/H3G
C4	260°	EE/H3G

PROPOSED DIPLEXER CABINET TO BE INSTALLED ON PROPOSED ROOT FOUNDATION

PROPOSED 1No. APM5930 CABINET TO BE INSTALLED ON PROPOSED ROOT FOUNDATION

PROPOSED 1No. BOWLER CABINET TO BE INSTALLED ON PROPOSED ROOT FOUNDATION

SBS HUAWEI 3900A CABINET ON CONCRETE BASE TO BE REMOVED

NEC NODE B CABINET ON CONCRETE BASE TO BE RETAINED

Ground level +0.0

Diagram illustrating a tree with a NEC Node B cabinet on its base to be retained. The tree is shown with a large, dense canopy. A red arrow points to the base of the tree, indicating the location of the NEC Node B cabinet. The ground level is marked as +0.0. The diagram shows the tree's base and the cabinet's position relative to the ground level.

GONA CABINET ON ROOT
 FOUNDATION TO BE REMOVED
 S LEGACY 2G CABINET ON
 NCRETE BASE TO BE REMOVED
 SPECIAL METER CABINET ON
 NCRETE BASE TO BE REMOVED
 K AC CABINET WITH TX EQUIPMENT
 CONCRETE BASE TO BE RETAINED

SPECIAL METER CABINET ON
 CONCRETE BASE TO BE REMOVED
 K AC CABINET WITH TX EQUIPMENT
 CONCRETE BASE TO BE RETAINED

Journal Pre-proof

SITE CAPACITY & LEAD OPERATOR				
	A	B	C	LEAD
	1,000	1,000	1,000	FF


Hutchison 3G UK Limited
 Registered in England
 Registered Office:
 Maidenhead, SL6 6EH
 Tel: 01235 785 000
 Fax: 01235 785 001
 H3G Base Station Information the
 H3G Base Station Information the
 Available from 9pm Monday to Friday

 **BEACONCOMMS**

UNIT E3 PITTS CLEAVE INDUSTRIAL ESTATE, TAVISTOCK, DEVON, PL19 0PW
Tel: +44 (0)1822 610610
sales@beaconcomms.co.uk

Site ID: 905090

Title: 265 MAX CONFIGURATION ELEVATION

Purpose of Issue:
GENERAL ARRANGEMENT

Master Drawing No: 905090_HGN042_70573_UB0112_M003	Issue: B
---	-------------