

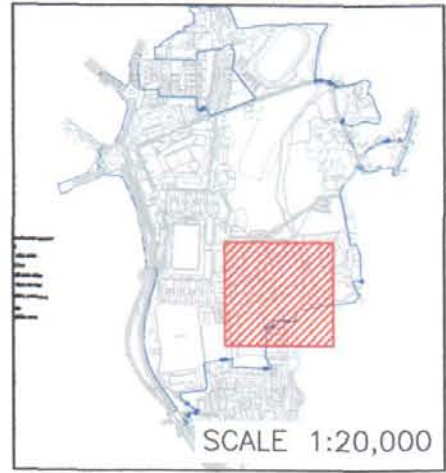


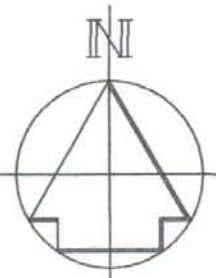

FOR CONTINUATION SEE SHEET 1 OF 5 (DRAWING 5105977/UXB/SR/0502)

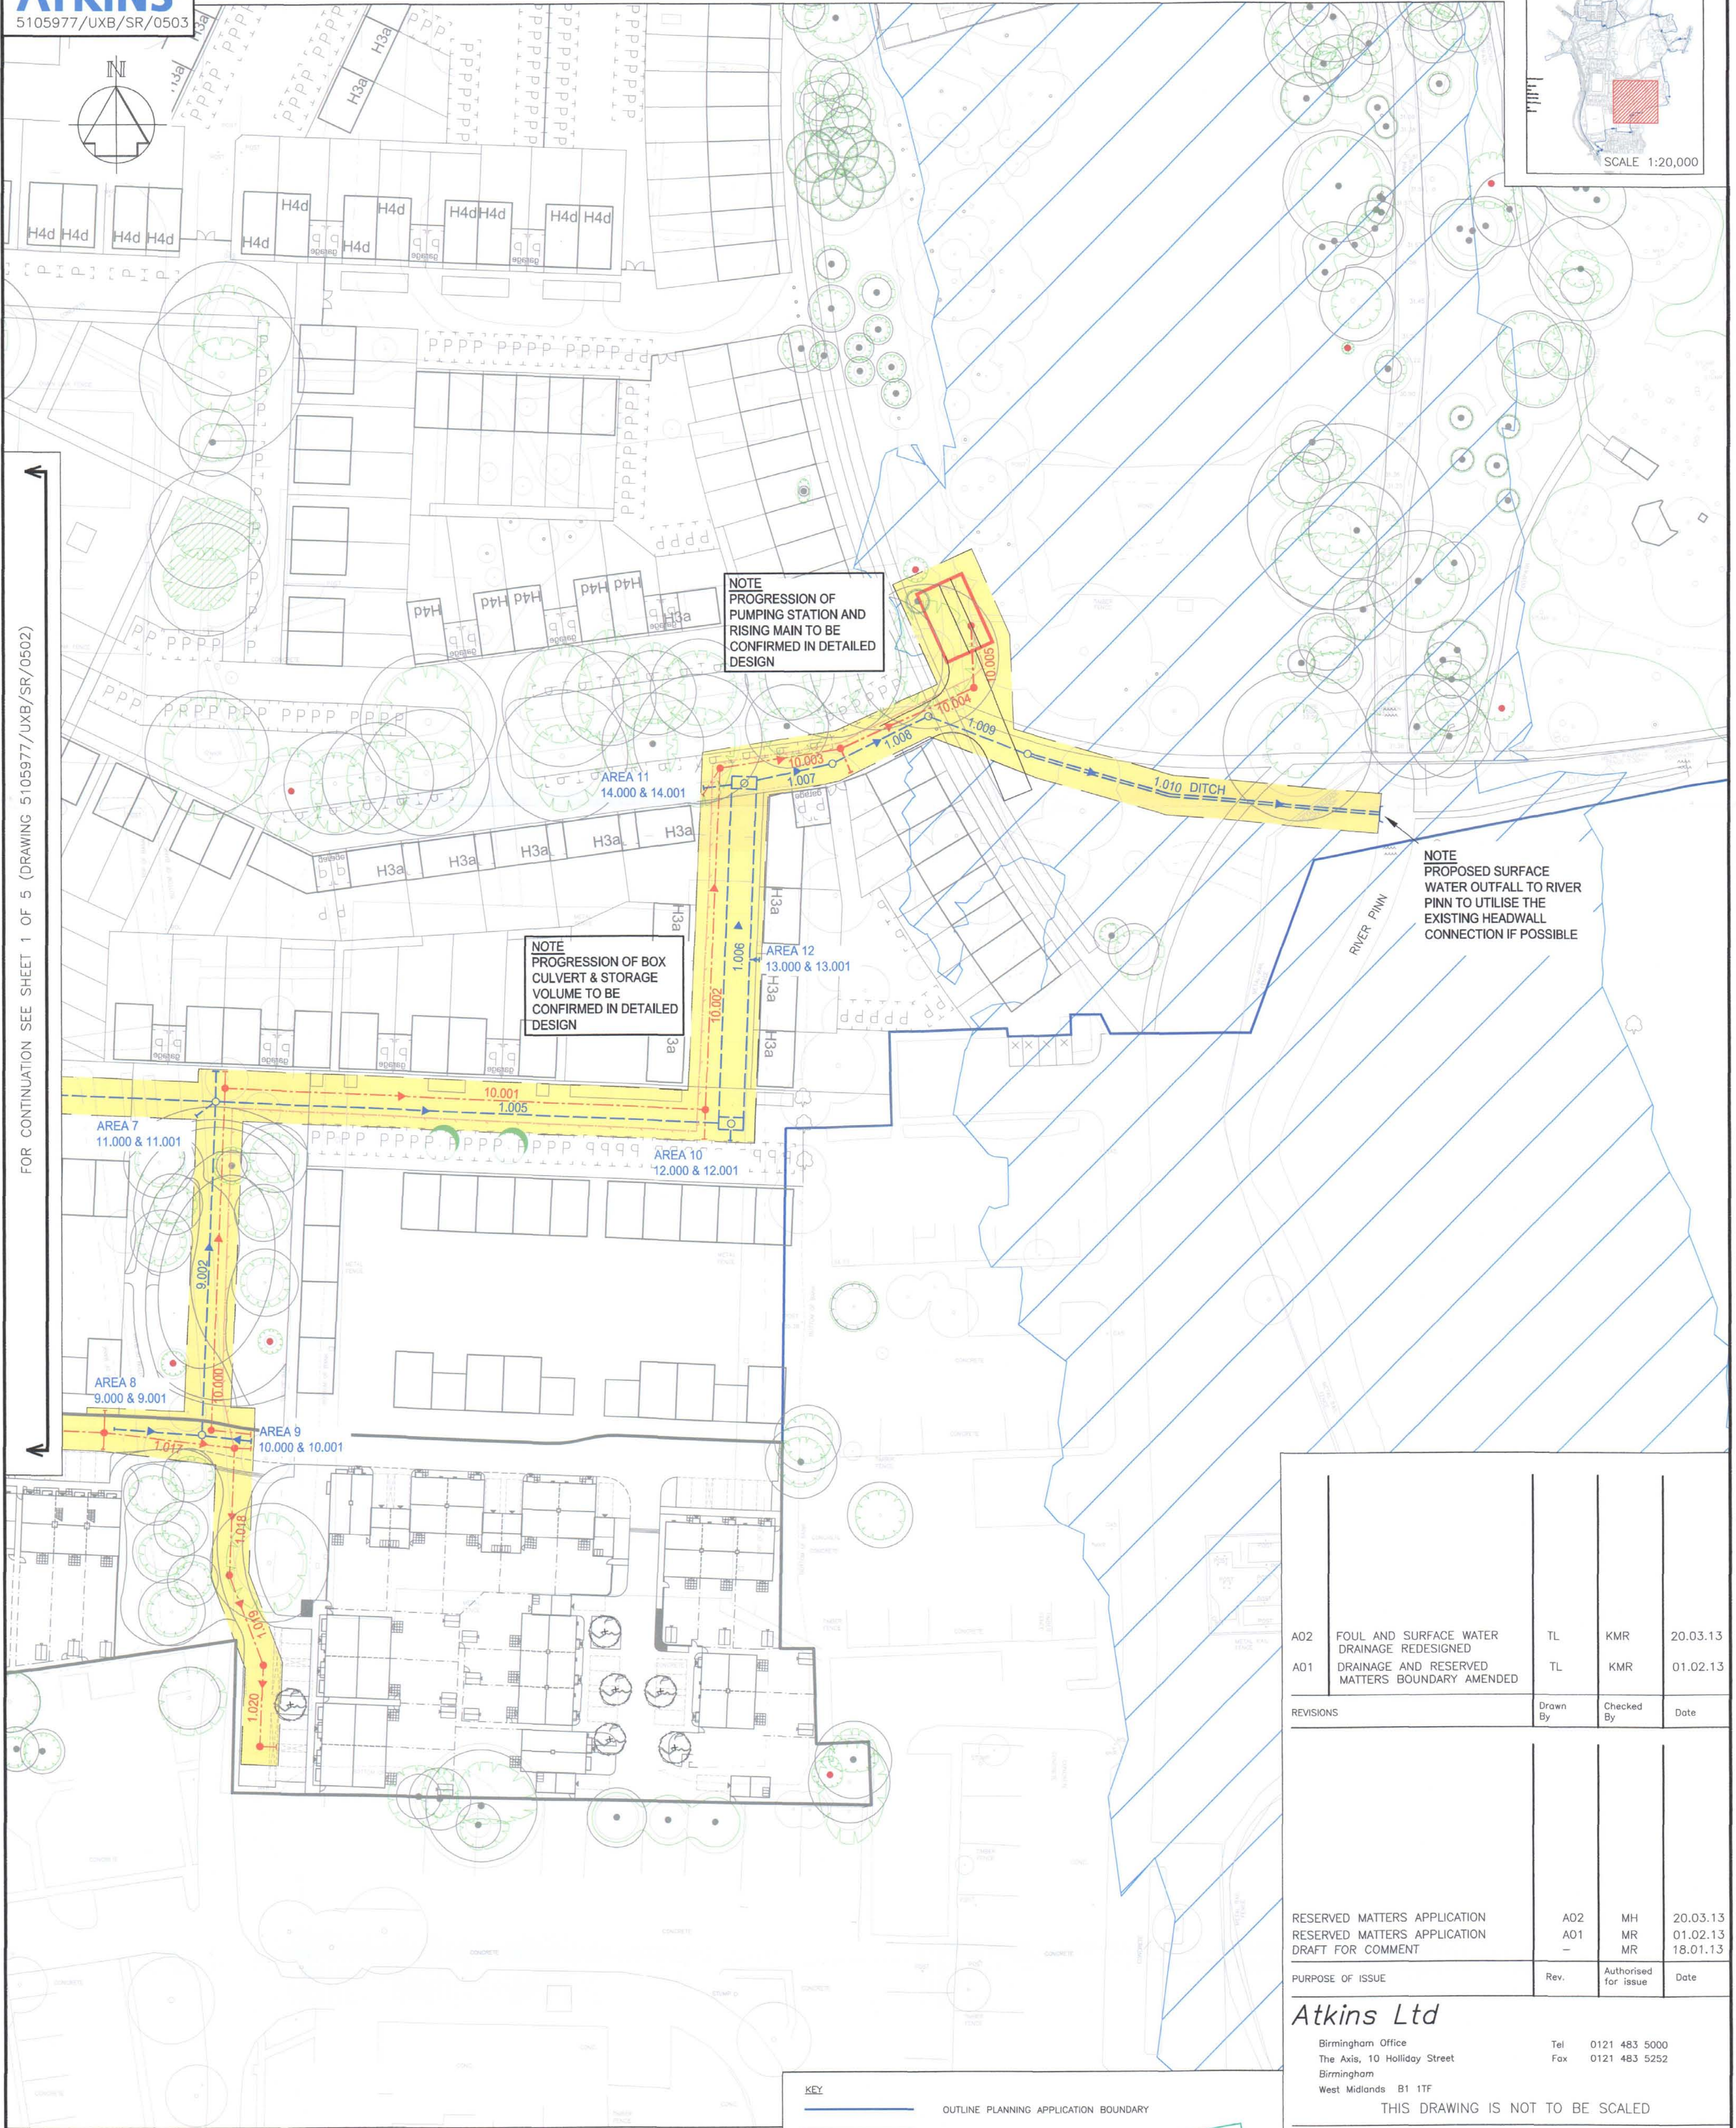

- KEY
- OUTLINE PLANNING APPLICATION BOUNDARY
 - PROPOSED SWALE
 - PROPOSED FOUL WATER SEWER
 - PROPOSED RISING MAIN
 - PROPOSED SURFACE WATER SEWER
 - PROPOSED ROAD GULLY AND LEAD
 - PROPOSED EASEMENT (APPROX 3m)
 - PROPOSED KERBING
 - PROPOSED PUMPING STATION (INDICATIVE ONLY)
 - FLOOD PLAIN (INDICATIVE ONLY)

LOW BOARD OF HILLINGDON
RECEIVED
11 APR 2013
PLANNING & TRANSPORTATION
GROUP

THIS MAP IS BASED ON ORDNANCE SURVEY MATERIAL WITH THE PERMISSION OF ORDNANCE SURVEY ON BEHALF OF THE CONTROLLER OF HER MAJESTY'S STATIONERY OFFICE © CROWN COPYRIGHT. UNAUTHORISED REPRODUCTION INFRINGES CROWN COPYRIGHT AND MAY LEAD TO PROSECUTION OR CIVIL PROCEEDINGS. AL 100018595 (2012).

NOTES

- ALL DIMENSIONS ARE IN METRES.
- TOPOGRAPHICAL SURVEY TAKEN FROM DRAWING NUMBER HAL125_2DT_RevE.dwg "RAF UXBRIDGE, MIDDLESEX UB10 0RZ - TOPOGRAPHICAL SURVEY 2D" BY MET SURVEYS LTD.
- PROPOSED HOUSING LAYOUT TAKEN FROM DRAWING NUMBERS:
 - 3300-10-101 Rev 0 BY SHEPPARD ROBSON (MASTERPLAN)
 - PERS120807-SL01 Rev A (St Andrews Park, Uxbridge - Phase 1C - Site Layout) BY TETLOW KING.
 - PERS120903-SL03 Rev E (St Andrews Park, Uxbridge - Phase 1D - Site Layout) BY TETLOW KING.
- FOR ROAD/SWALE CROSS SECTIONS, REFER TO DRAWING NUMBER 5105977/UXB/SR/0141 AND LANDSCAPE ARCHITECT DRAWINGS (BY ALLEN PYKE ASSOCIATES).

A02	FOUL AND SURFACE WATER DRAINAGE REDESIGNED	TL	KMR	20.03.13
A01	DRAINAGE AND RESERVED MATTERS BOUNDARY AMENDED	TL	KMR	01.02.13

REVISED	Drawn By	Checked By	Date
---------	----------	------------	------

RESERVED MATTERS APPLICATION	A02	MH	20.03.13
RESERVED MATTERS APPLICATION	A01	MR	01.02.13
DRAFT FOR COMMENT	-	MR	18.01.13

PURPOSE OF ISSUE	Rev.	Authorised for Issue	Date
------------------	------	----------------------	------

Atkins Ltd

Birmingham Office
The Axis, 10 Holliday Street
Birmingham
West Midlands B1 1TF

Tel 0121 483 5000
Fax 0121 483 5252

THIS DRAWING IS NOT TO BE SCALED

CLIENT
VSM ESTATES LTD

PROJECT
UXBRIDGE

DRAWING TITLE
SPINE ROAD
PROPOSED DRAINAGE LAYOUT
SHEET 2 OF 5

Scales	DRAWN	CHECKED	CO-ORD CHECK
1:500	TL	CN	KMR
DATE	DATE	DATE	DATE
17/12/12	17/12/12	17/12/12	17/12/12
SHEET	PLOT DATE	REV	REV
A1	20/03/13		A02

DRAWING NO
5105977/UXB/SR/0503