




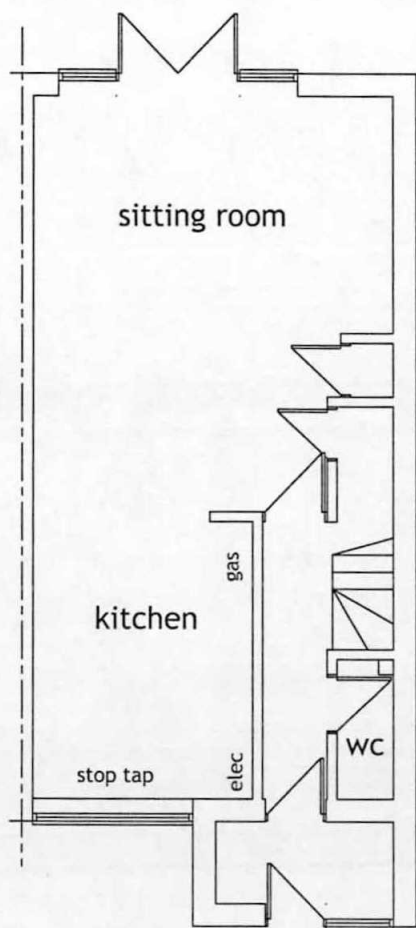


EXISTING GROUND FLOOR PLAN

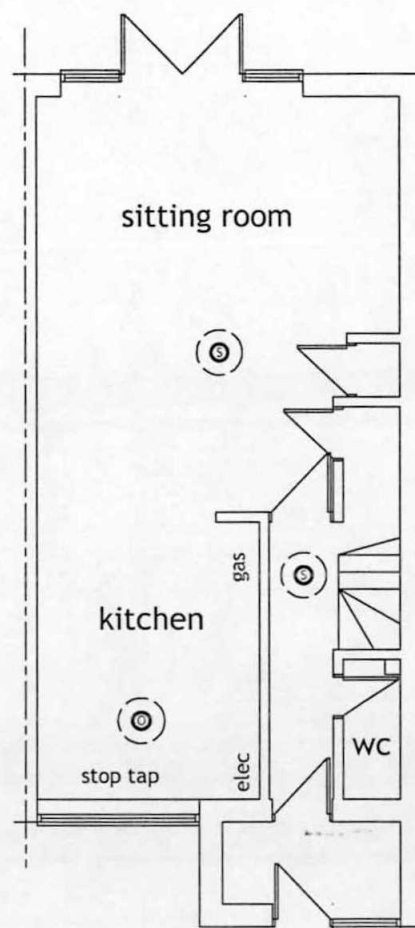

PROPOSED GROUND FLOOR PLAN

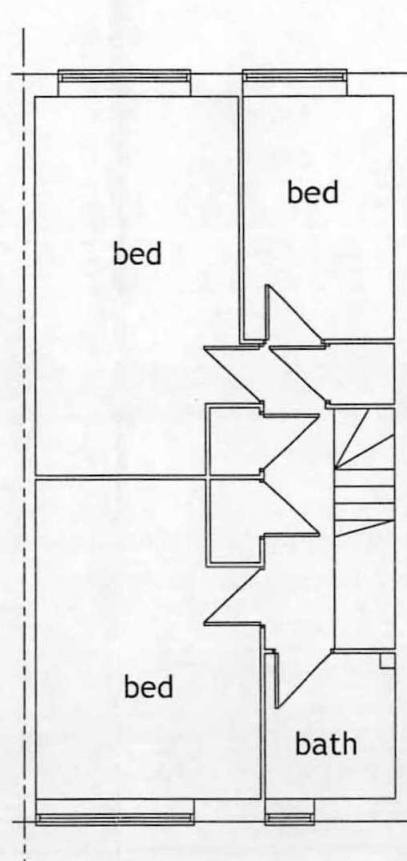

EXISTING FIRST FLOOR PLAN

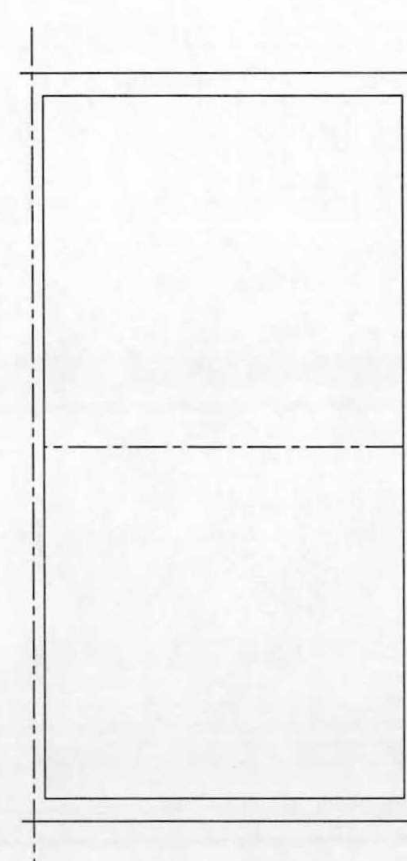

EXISTING ROOF PLAN



Interconnected mains operated smoke detector with battery back-up. 300mm min from any light fitting



Interconnected mains operated optical smoke detector with battery back-up. 300mm min from any light fitting

NOTE :  
LD2 GRADE D FIRE DETECTION & ALARM SYSTEM TO BE INSTALLED INCORPORATING DETECTORS IN ALL CIRCULATION SPACES THAT FORM PART OF THE ESCAPE ROUTES FROM THE DWELLING & IN ALL ROOMS THAT REPRESENT A HIGH RISK TO OCCUPANTS INCLUDING A N OPTICAL SMOKE DETECTOR IN THE KITCHEN

0 1m 2m 3m 4m 5m  
Scale - 1:100

Xtra Room Conversions Ltd  
Tel : 01283 567804

Mr & Mrs VINES

1 Morgan Close, Northwood,  
Middlesex. HA6 3NE

PROPOSED LOFT CONVERSION

SCALE : 1:100 on A3  
DATE : March 2016  
DRAWN : A. Lloyd  
SHEET : 1 of 5

Drawing number :  
2330 /3645

THIS DRAWING IS THE COPYRIGHT OF ADRIAN LLOYD AND MAY NOT BE COPIED BY ANY MEANS WITHOUT PRIOR WRITTEN CONSENT