



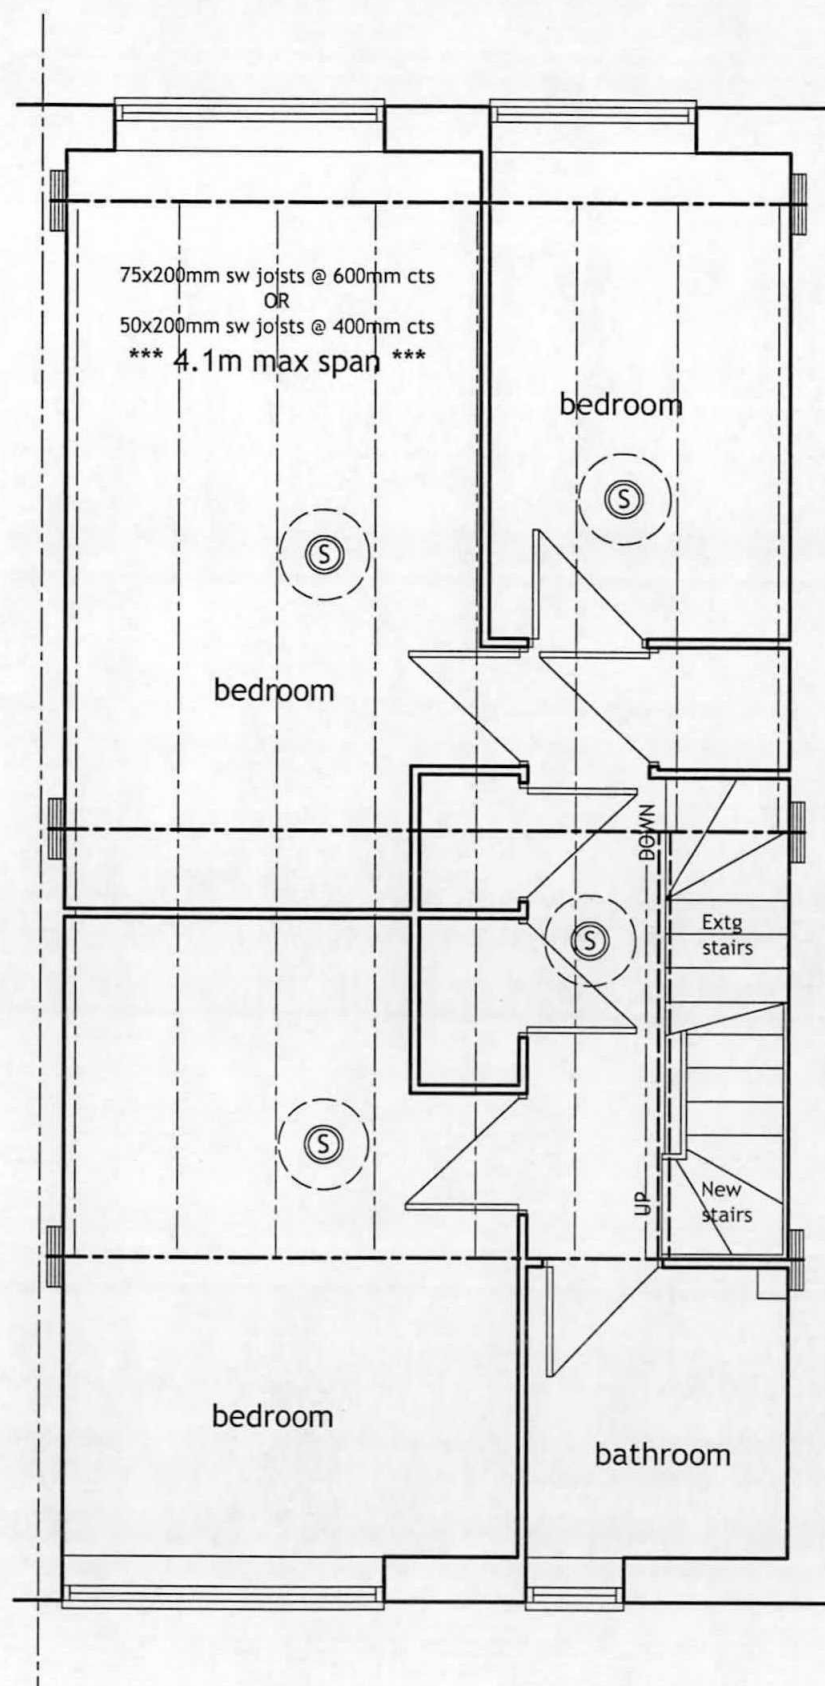

PROPOSED FIRST FLOOR PLAN

7.0m Approx

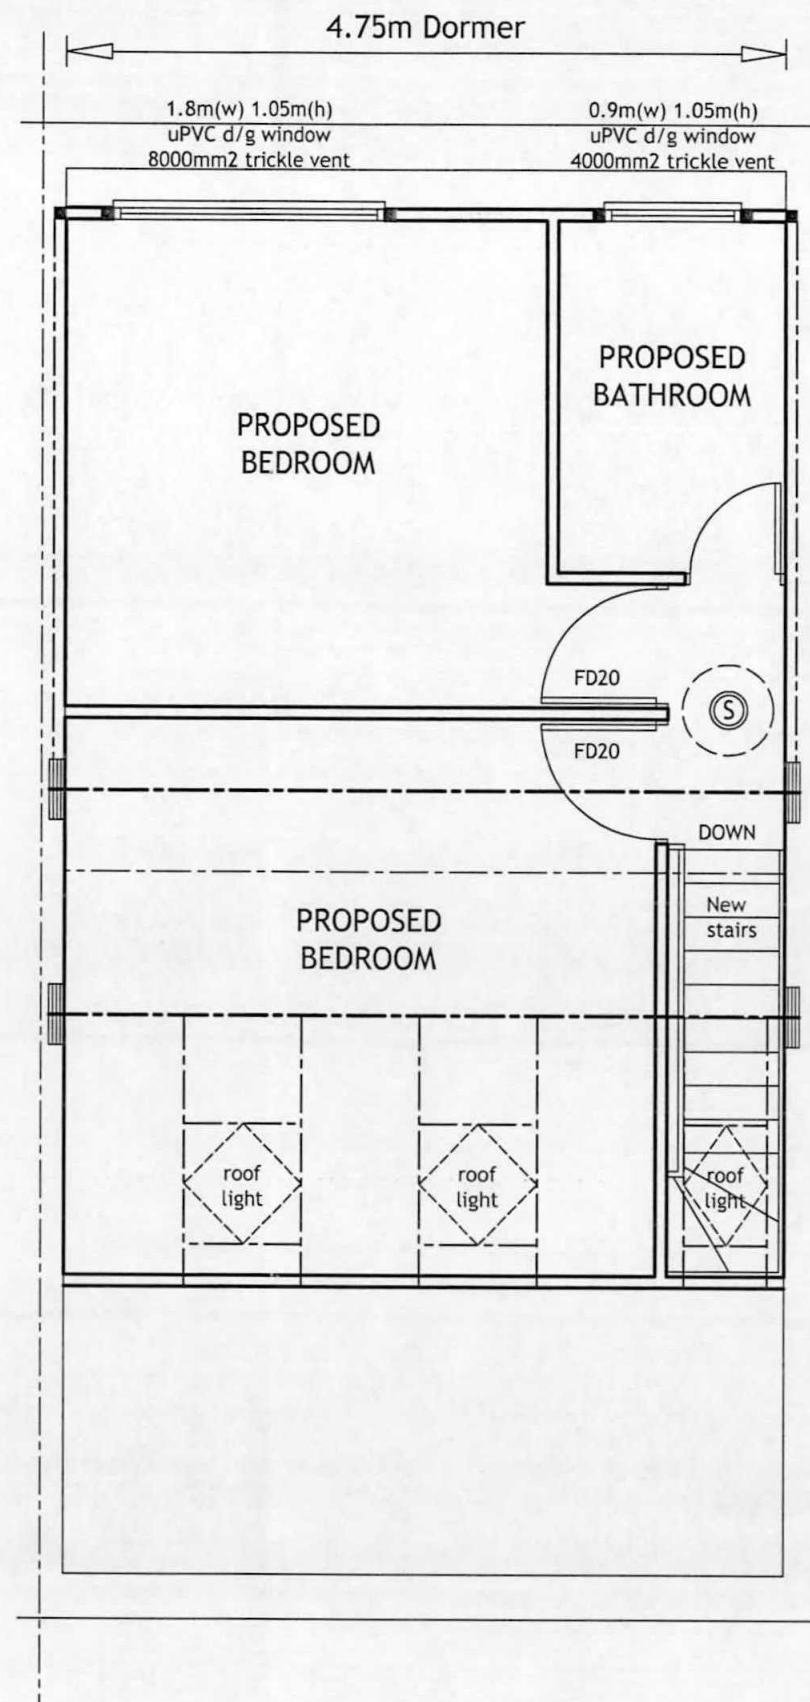

PROPOSED ROOF / SECOND FLOOR PLAN

0 1m 2m 3m 4m 5m

Scale - 1:50



Xtra Room Conversions Ltd
Tel : 01283 567804

Mr & Mrs VINES

1 Morgan Close, Northwood,
Middlesex. HA6 3NE

PROPOSED LOFT CONVERSION

SCALE : 1:50 on A3
DATE : March 2016
DRAWN : A. Lloyd
SHEET : 2 of 5

Drawing number :
2330 /3645

THIS DRAWING IS THE COPYRIGHT OF ADRIAN LLOYD AND MAY NOT
BE COPIED BY ANY MEANS WITHOUT PRIOR WRITTEN CONSENT

(S) Interconnected mains operated
smoke detector with battery back-up.
300mm min from any light fitting

(O) Interconnected mains operated optical
smoke detector with battery back-up.
300mm min from any light fitting

NOTE :
A2 GRADE D FIRE DETECTION & ALARM SYSTEM TO BE INSTALLED INCORPORATING DETECTORS IN ALL
CIRCULATION SPACES THAT FORM PART OF THE ESCAPE ROUTES FROM THE DWELLING & IN ALL ROOMS
THAT REPRESENT A HIGH RISK TO OCCUPANTS INCLUDING A OPTICAL SMOKE DETECTOR IN THE KITCHEN