

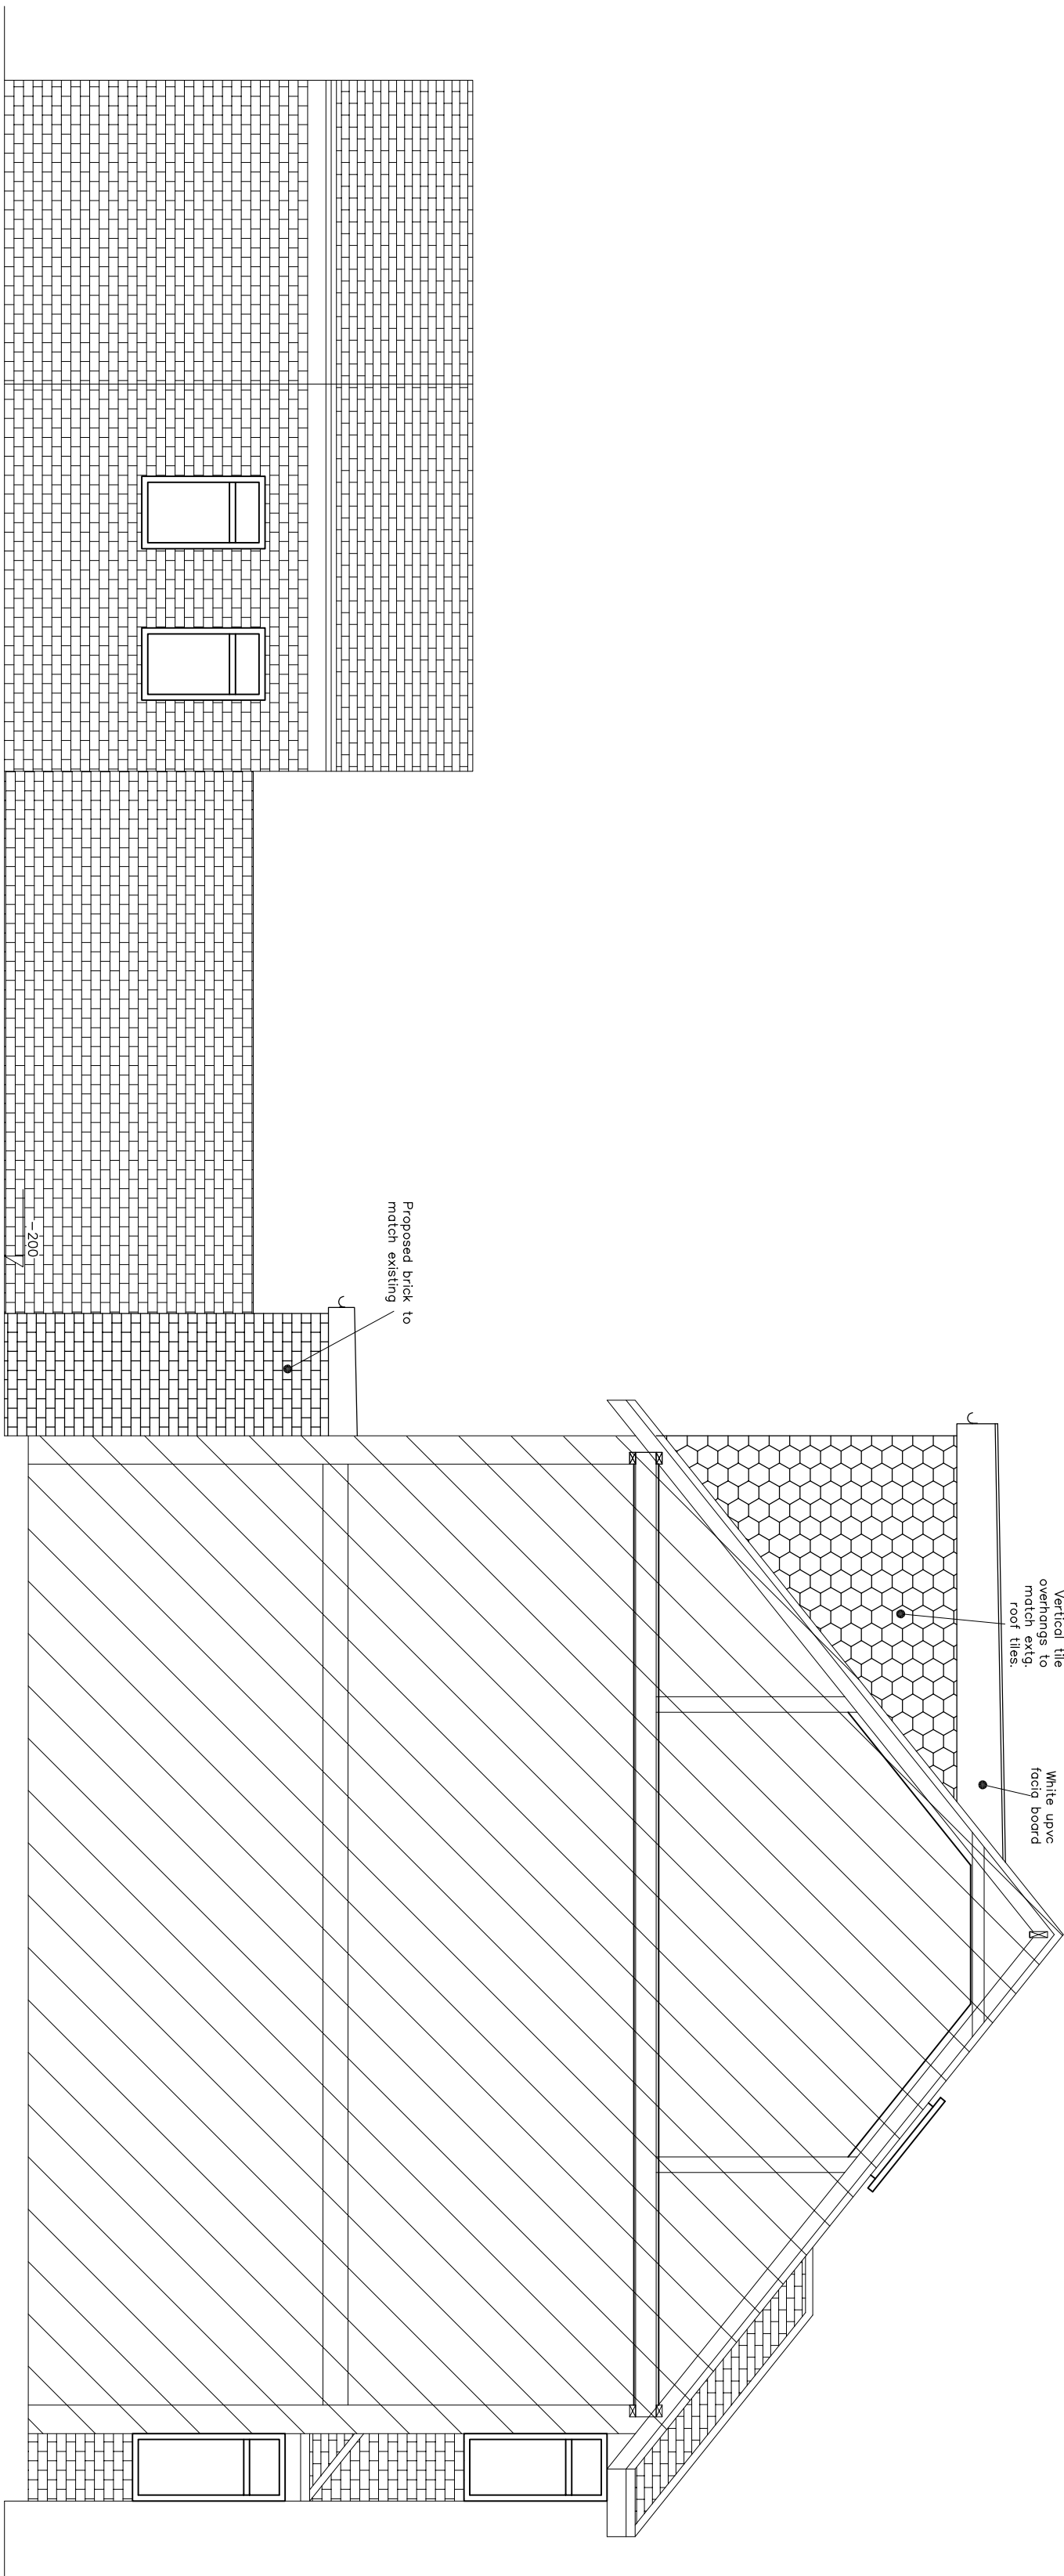
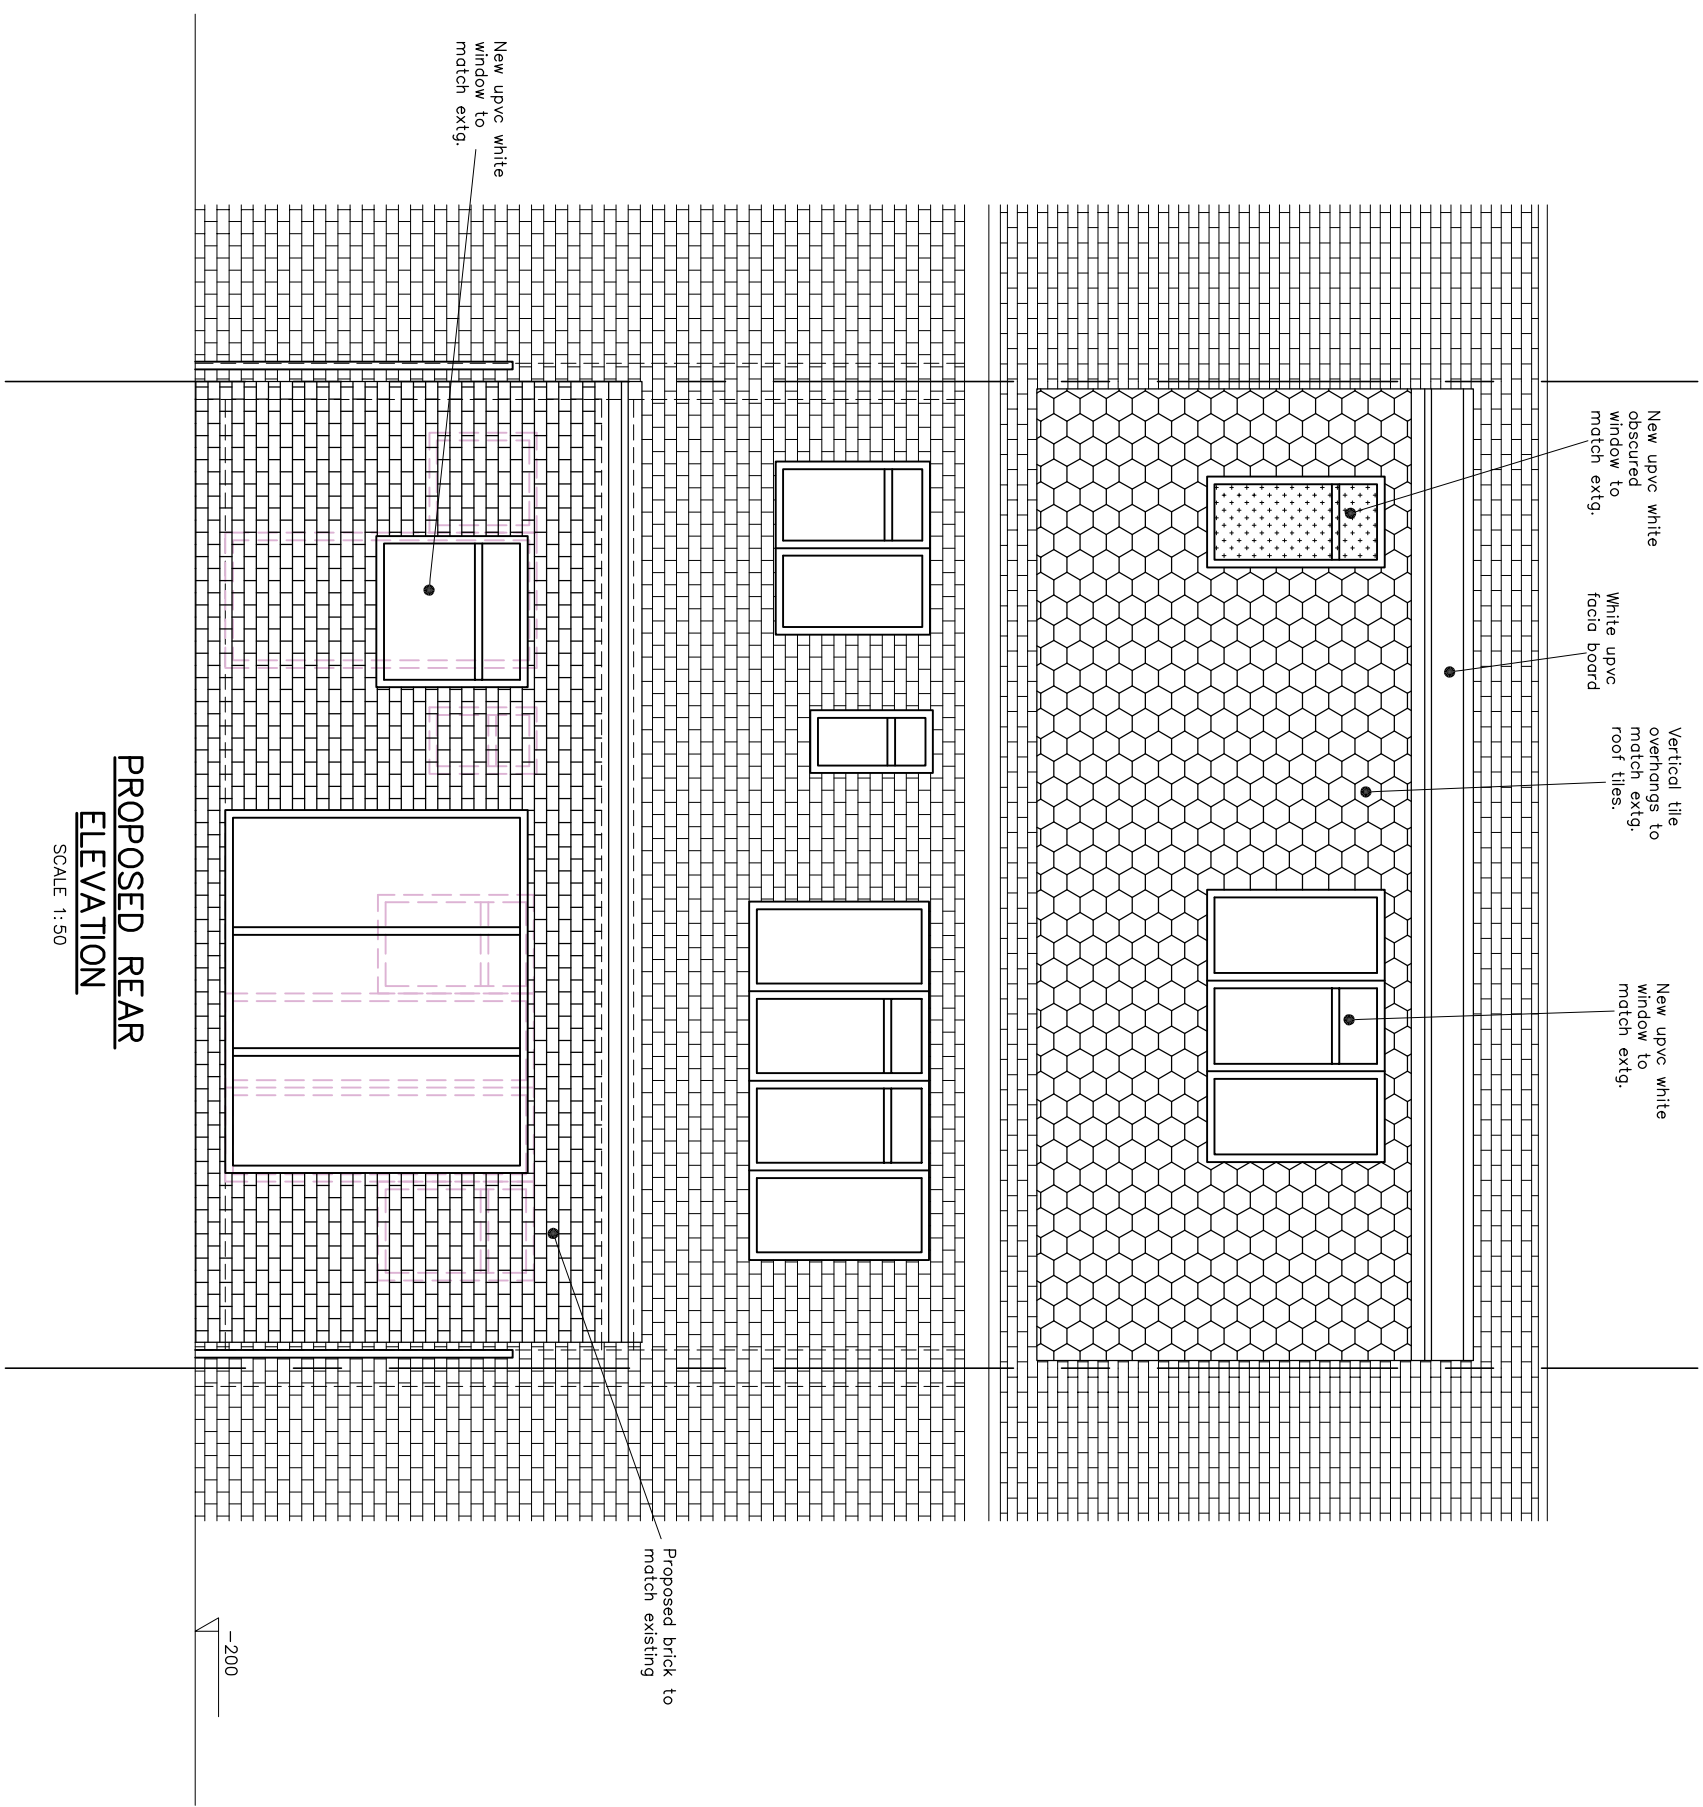
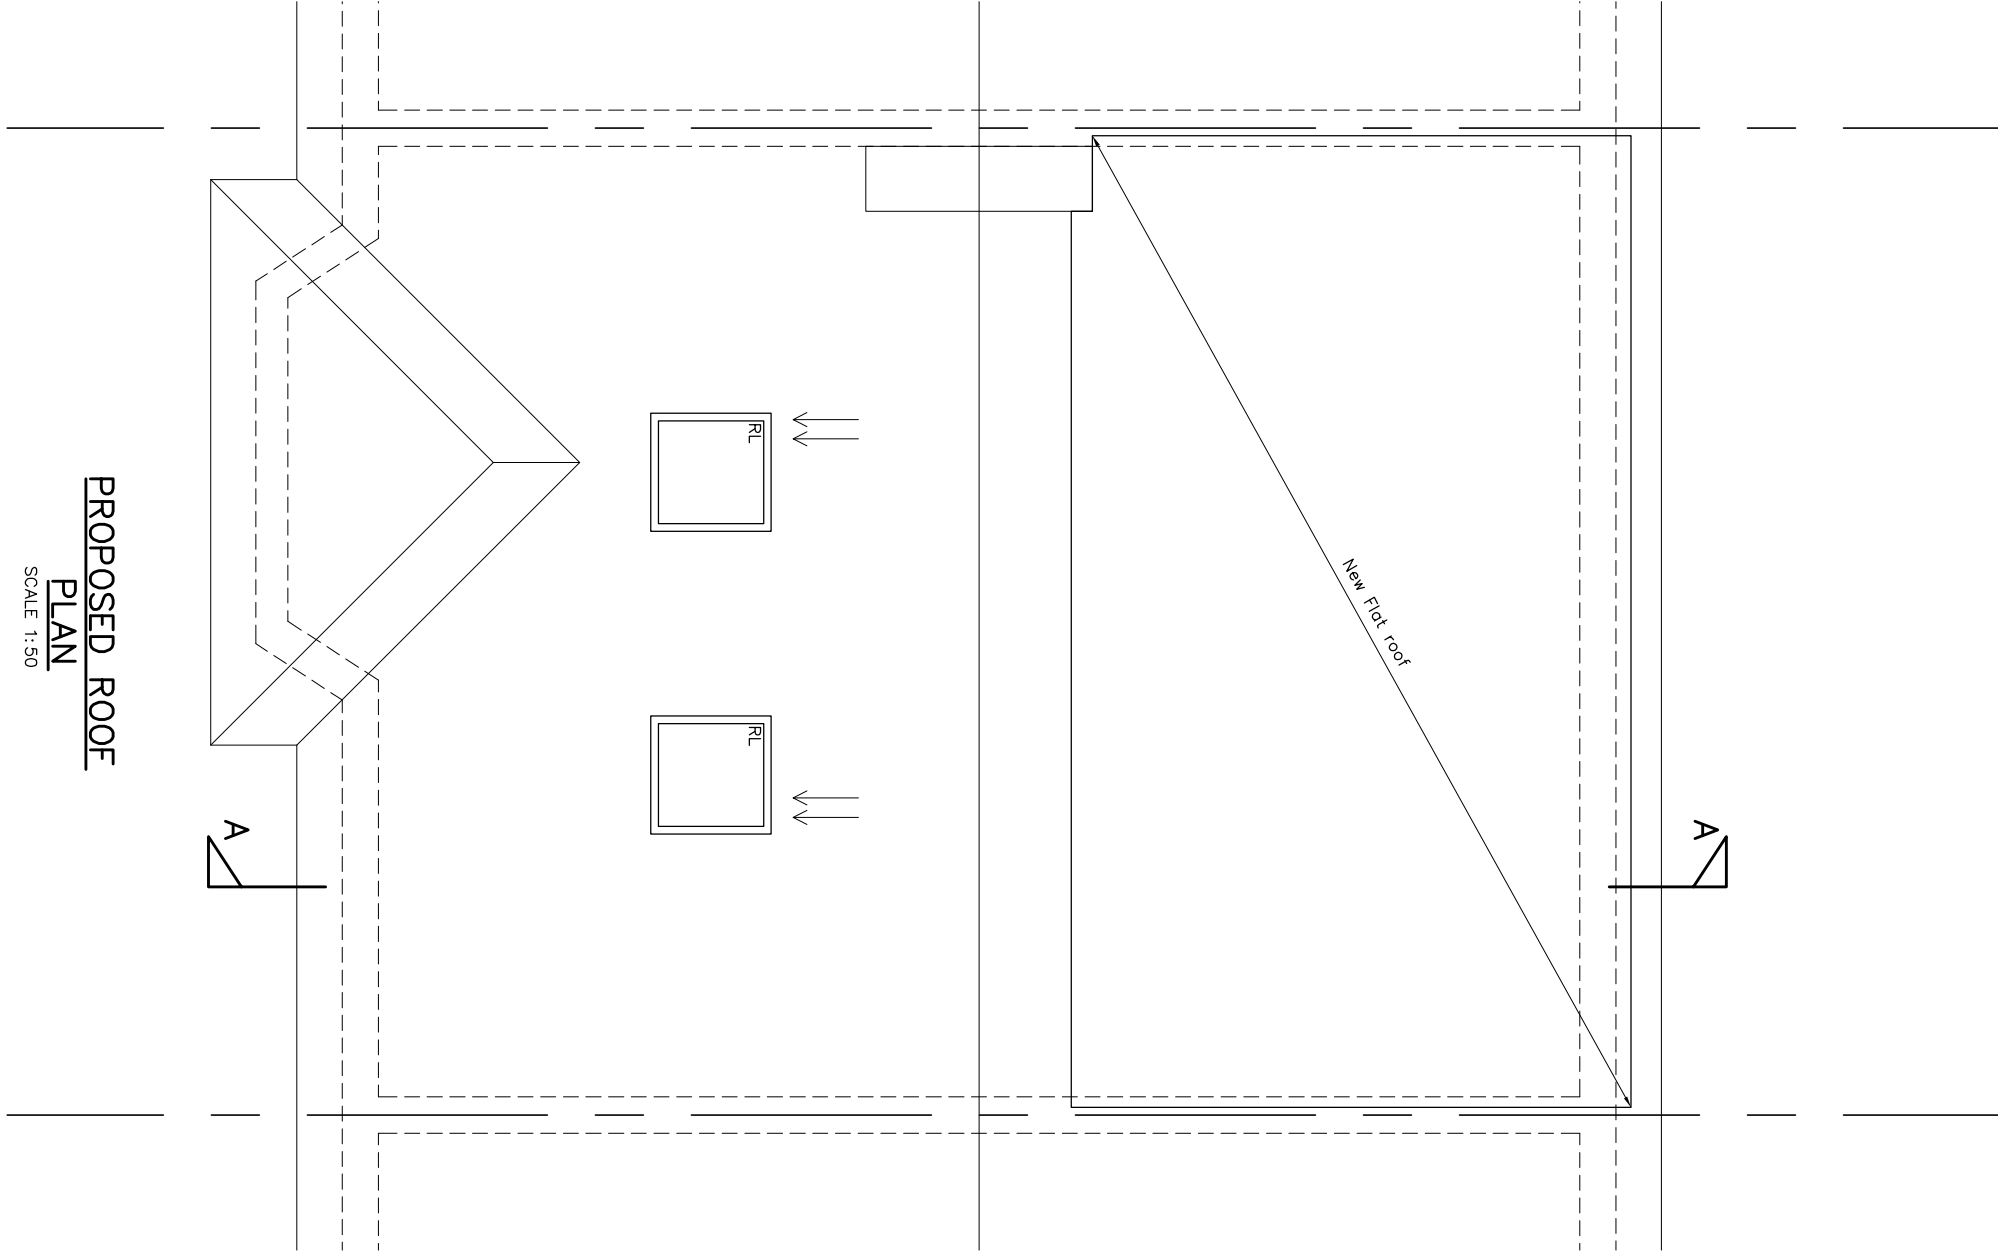
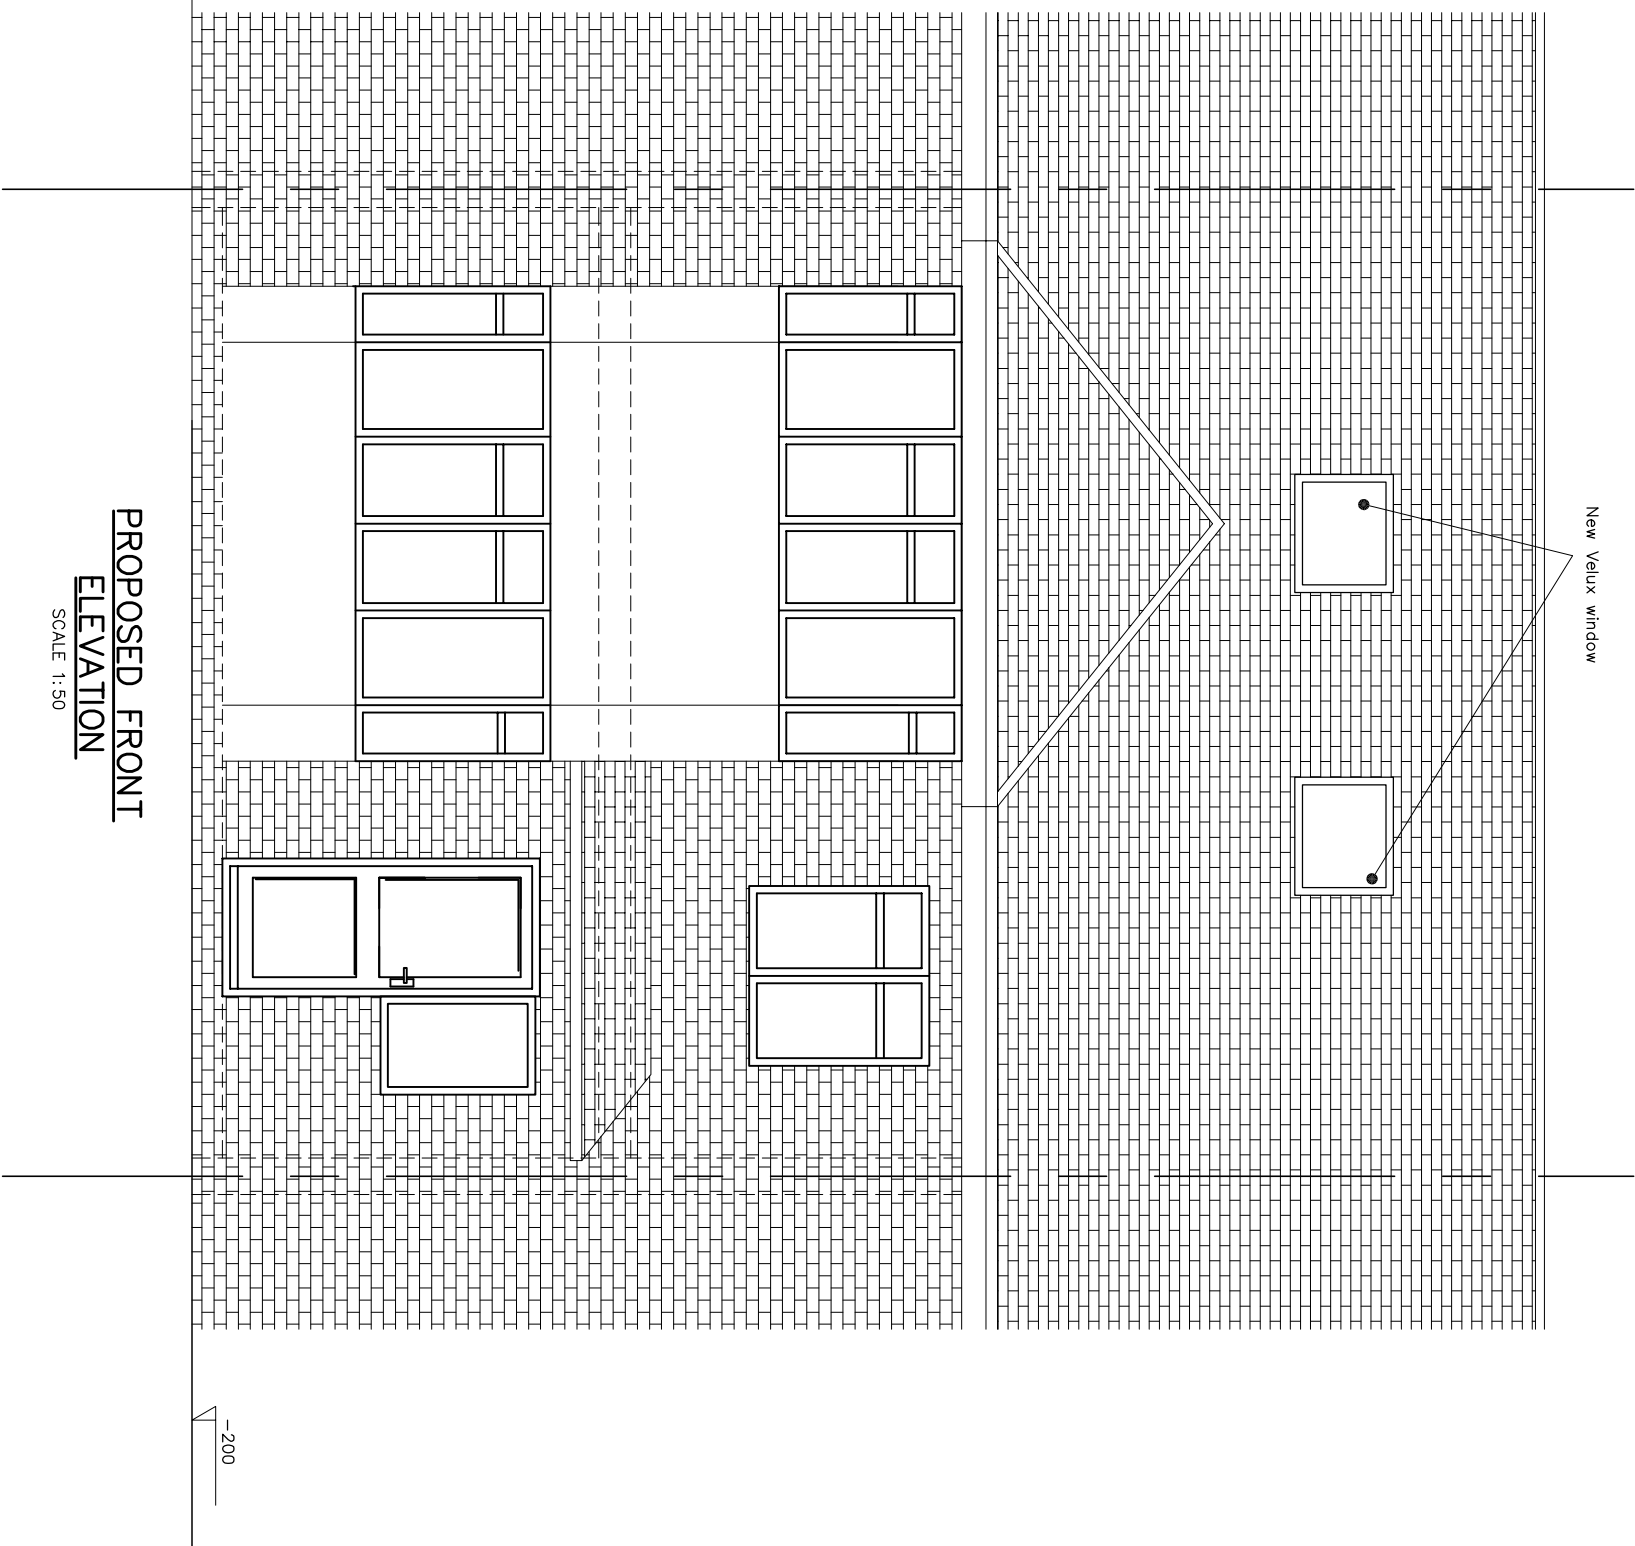
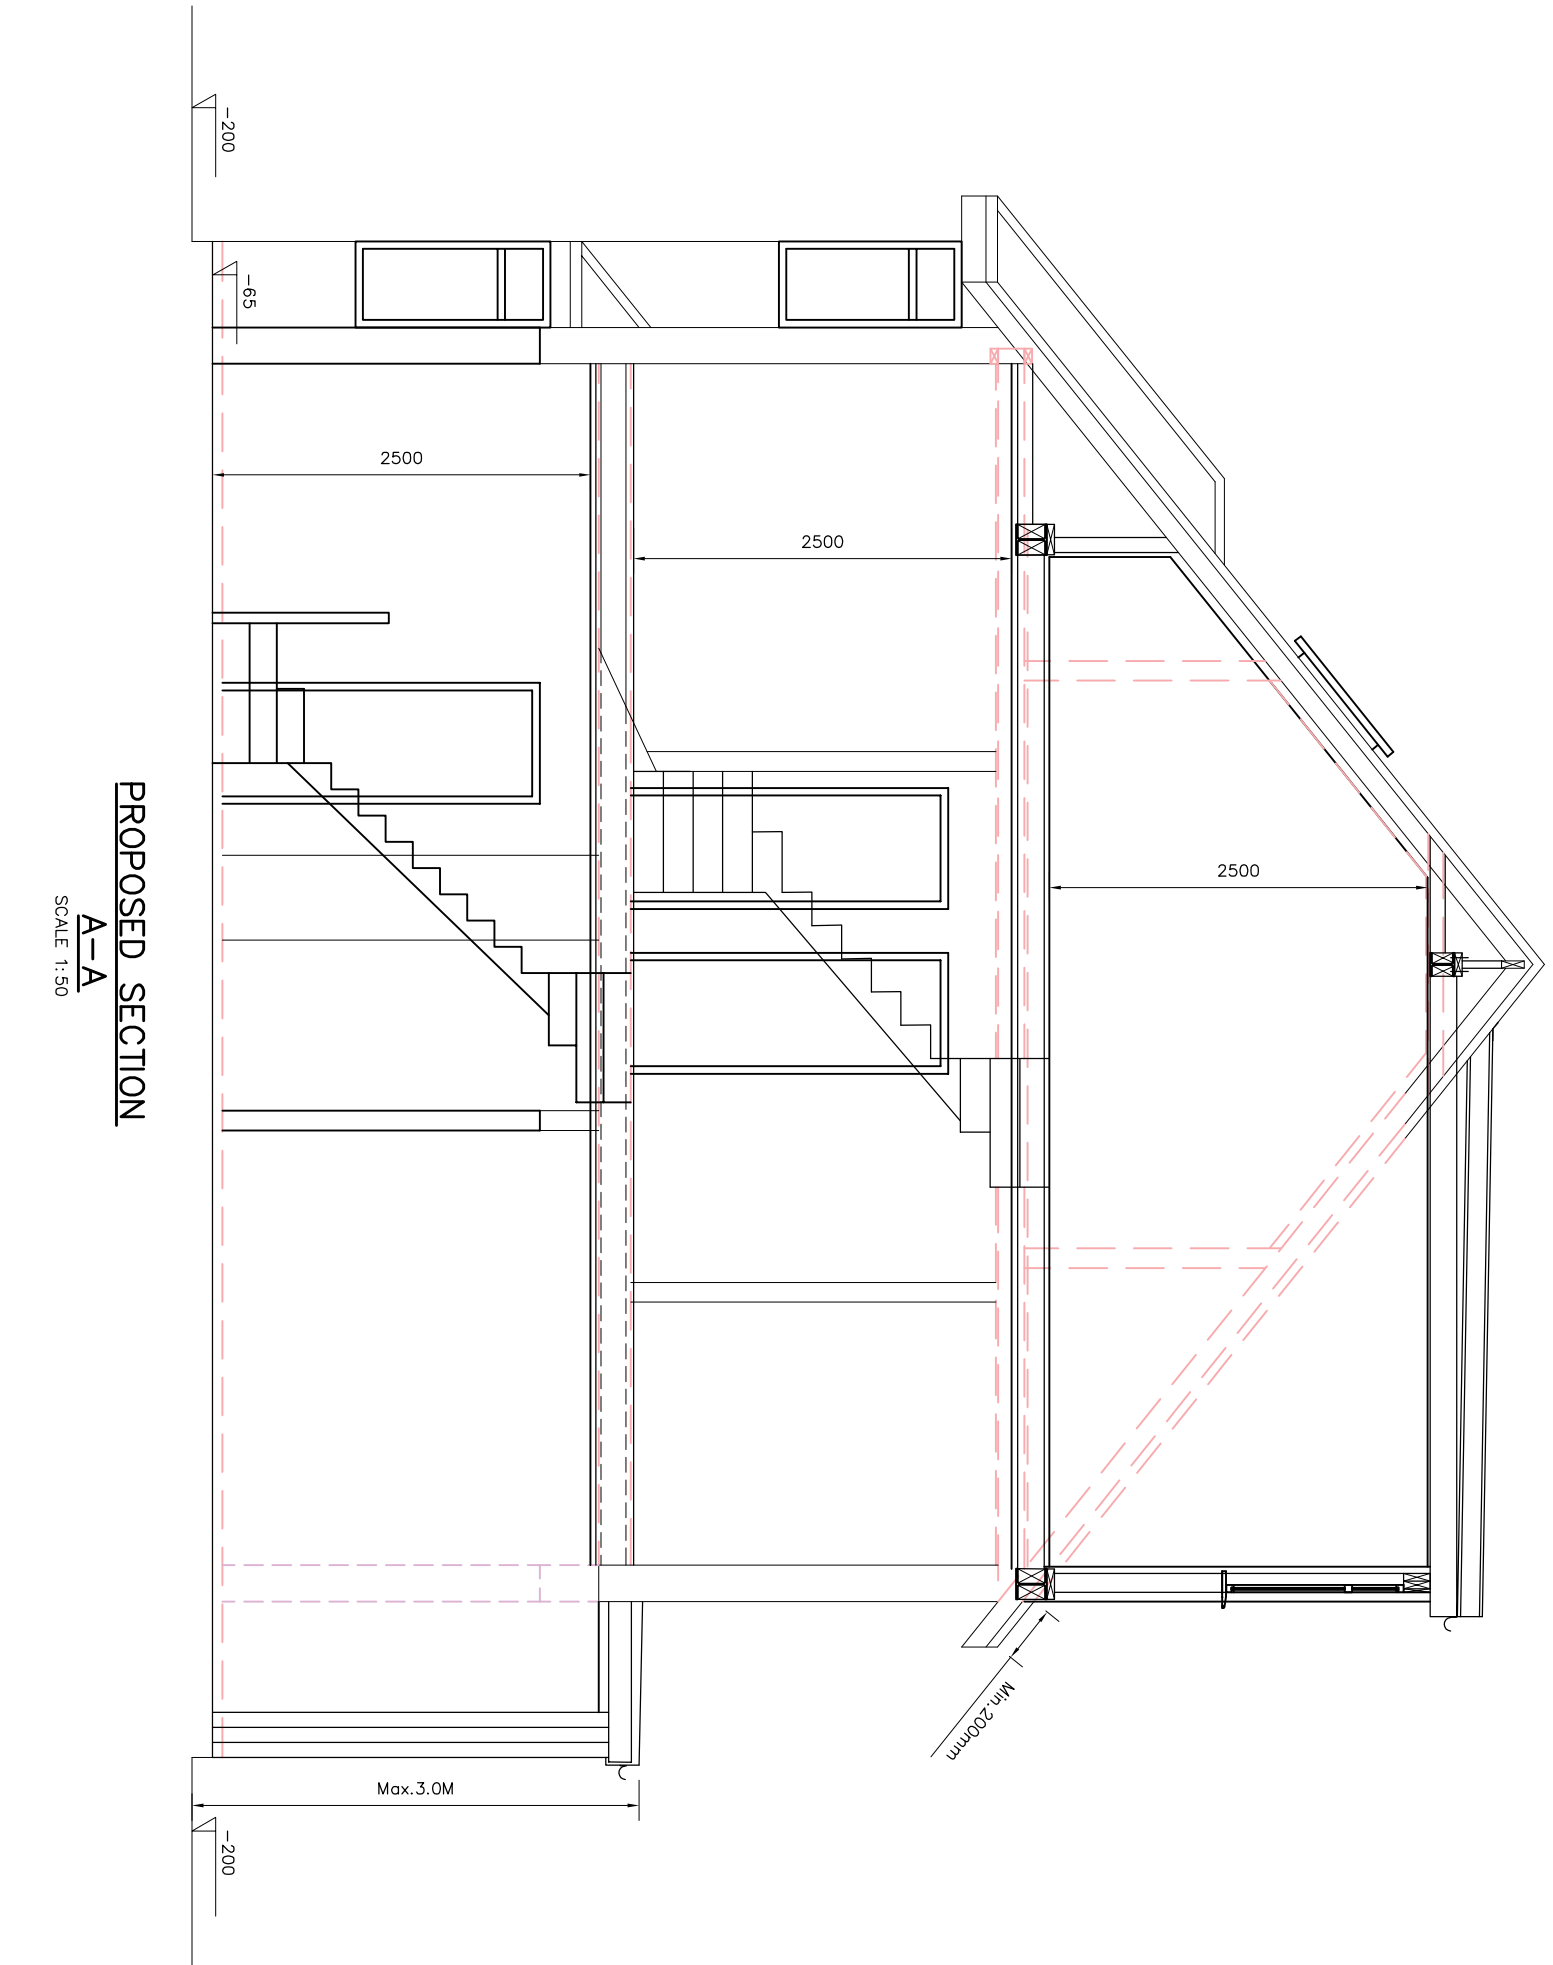


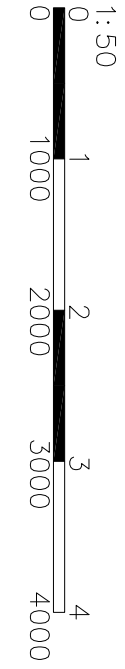

VOLUME CALCULATION

NOT TO SCALE

Dormer volume $V_2 = A \times L$
 $= 361.56 \text{ m}^3$
 $= 29.02 \text{ m}^3$

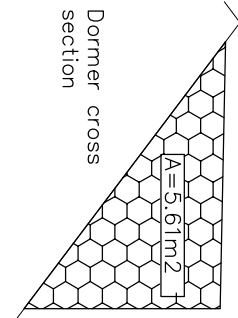

ONE & STRUCTURAL ENGINEERS	
K&S Planning & Design Ltd 485 Church Lane, Kingsbury Tel: 020 8500 2360 Email: info@kandse.co.uk Web: www.kandse.co.uk	
Client: 28 Station Approach HA4 6RY	Drawn: SS
Project Title: 28 Station Approach HA4 6RY	Checked: SEP 2022
Drawing Title: PROPOSED FLOOR PLANS	Scale: 1:50
	Size: A1
	Project No: KKR-1477
	Drawing No: PS-03
	Rev: