





FRONT ELEVATION
(NO CHANGE)

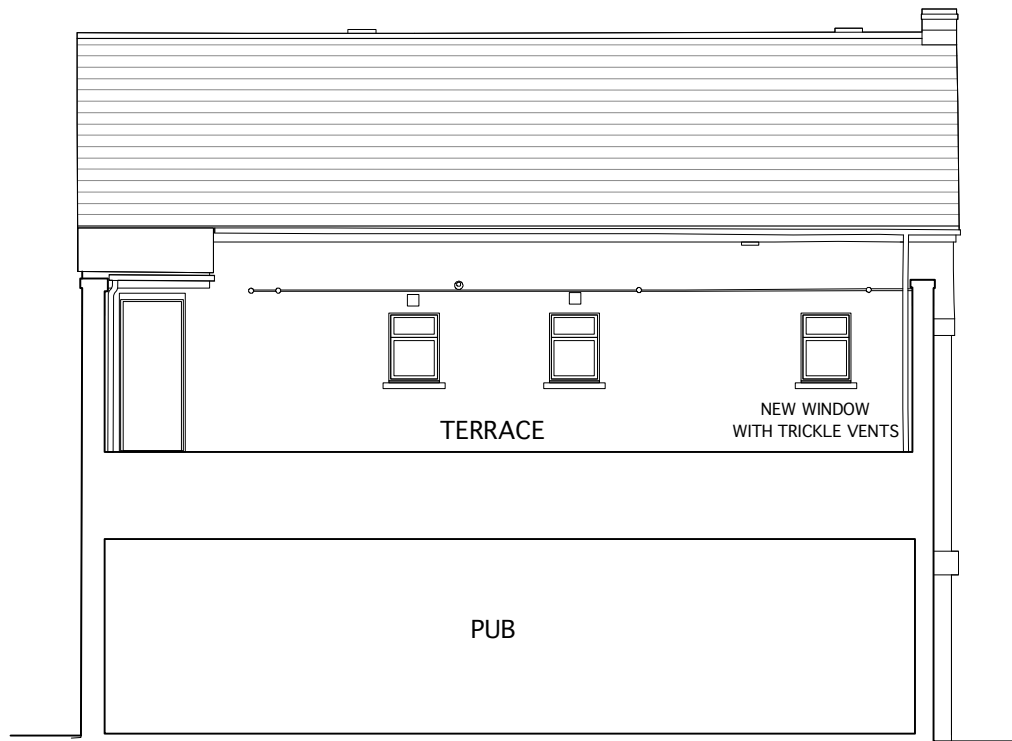


REAR TERRACE ELEVATION
TO FIRST FLOOR FLAT




SIDE ELEVATION
(PASSGE WAY)
(NO CHANGE)

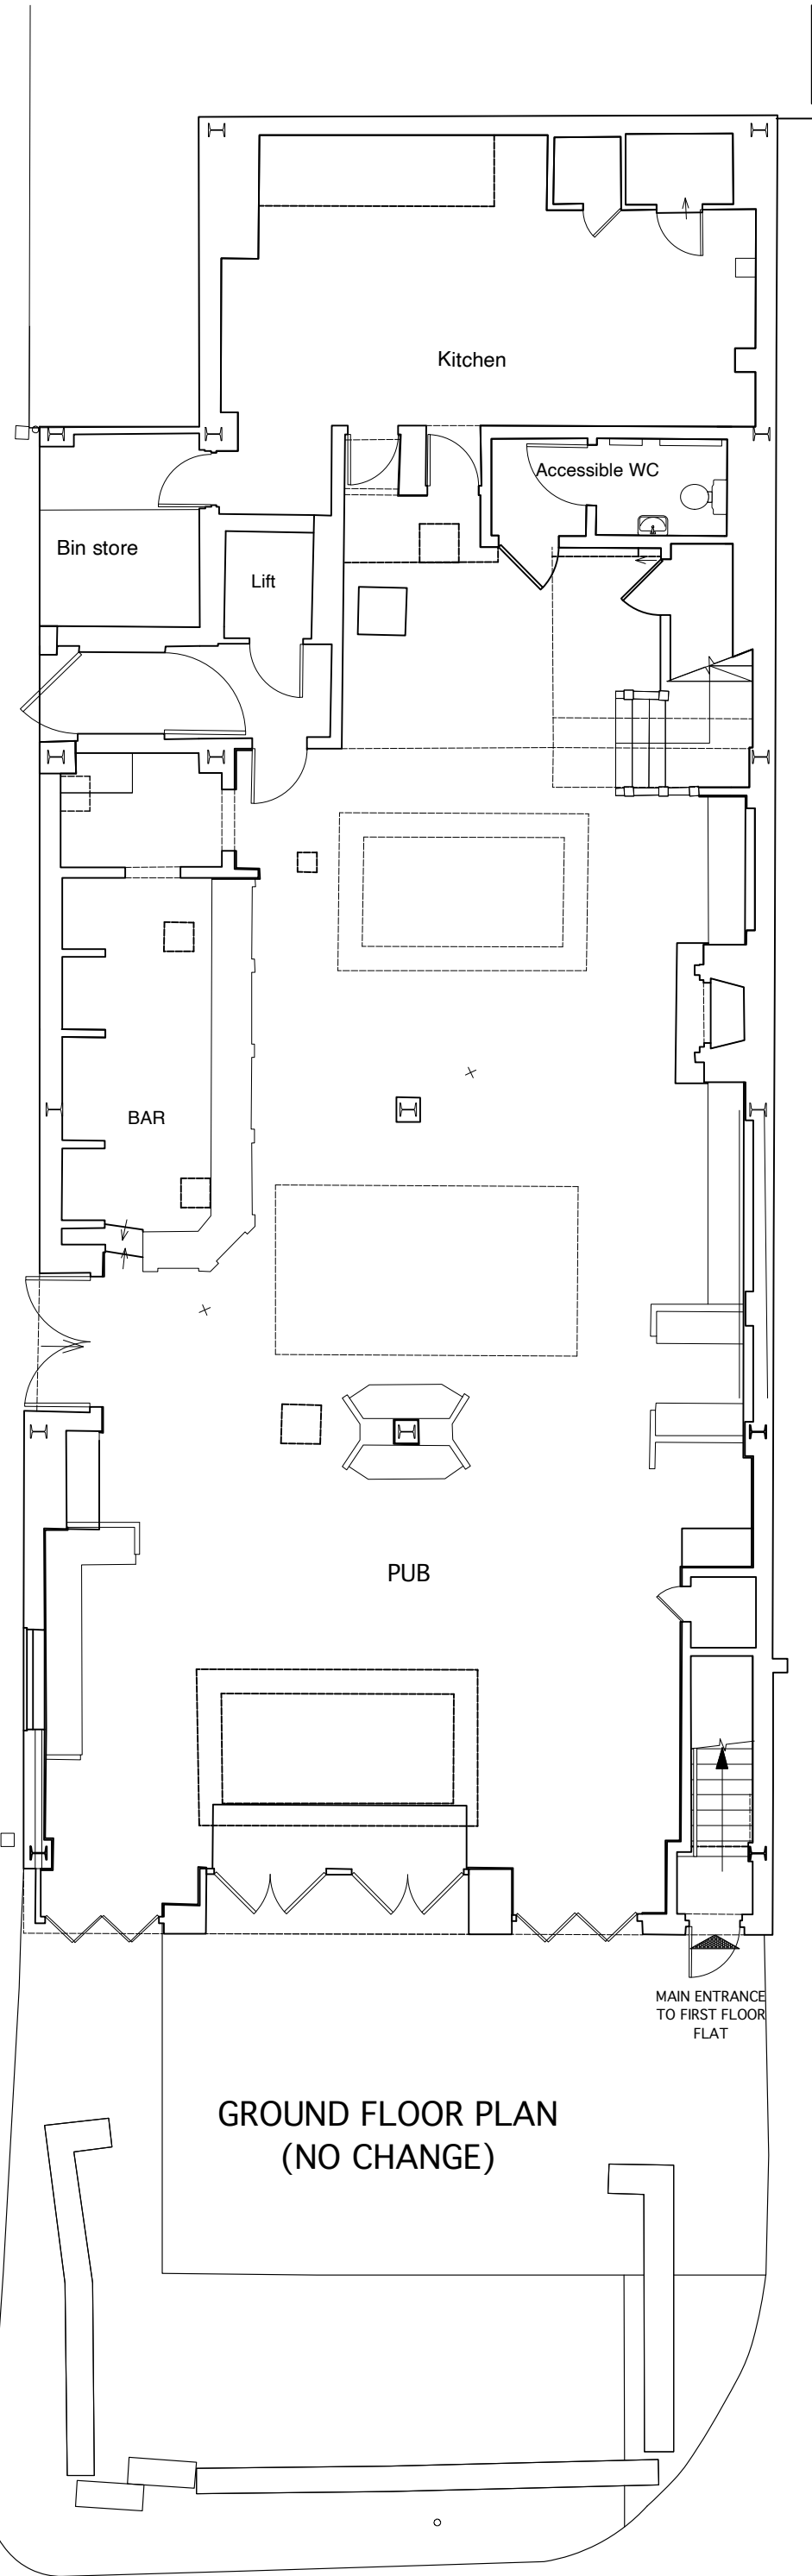


GROUND FLOOR PLAN
(NO CHANGE)

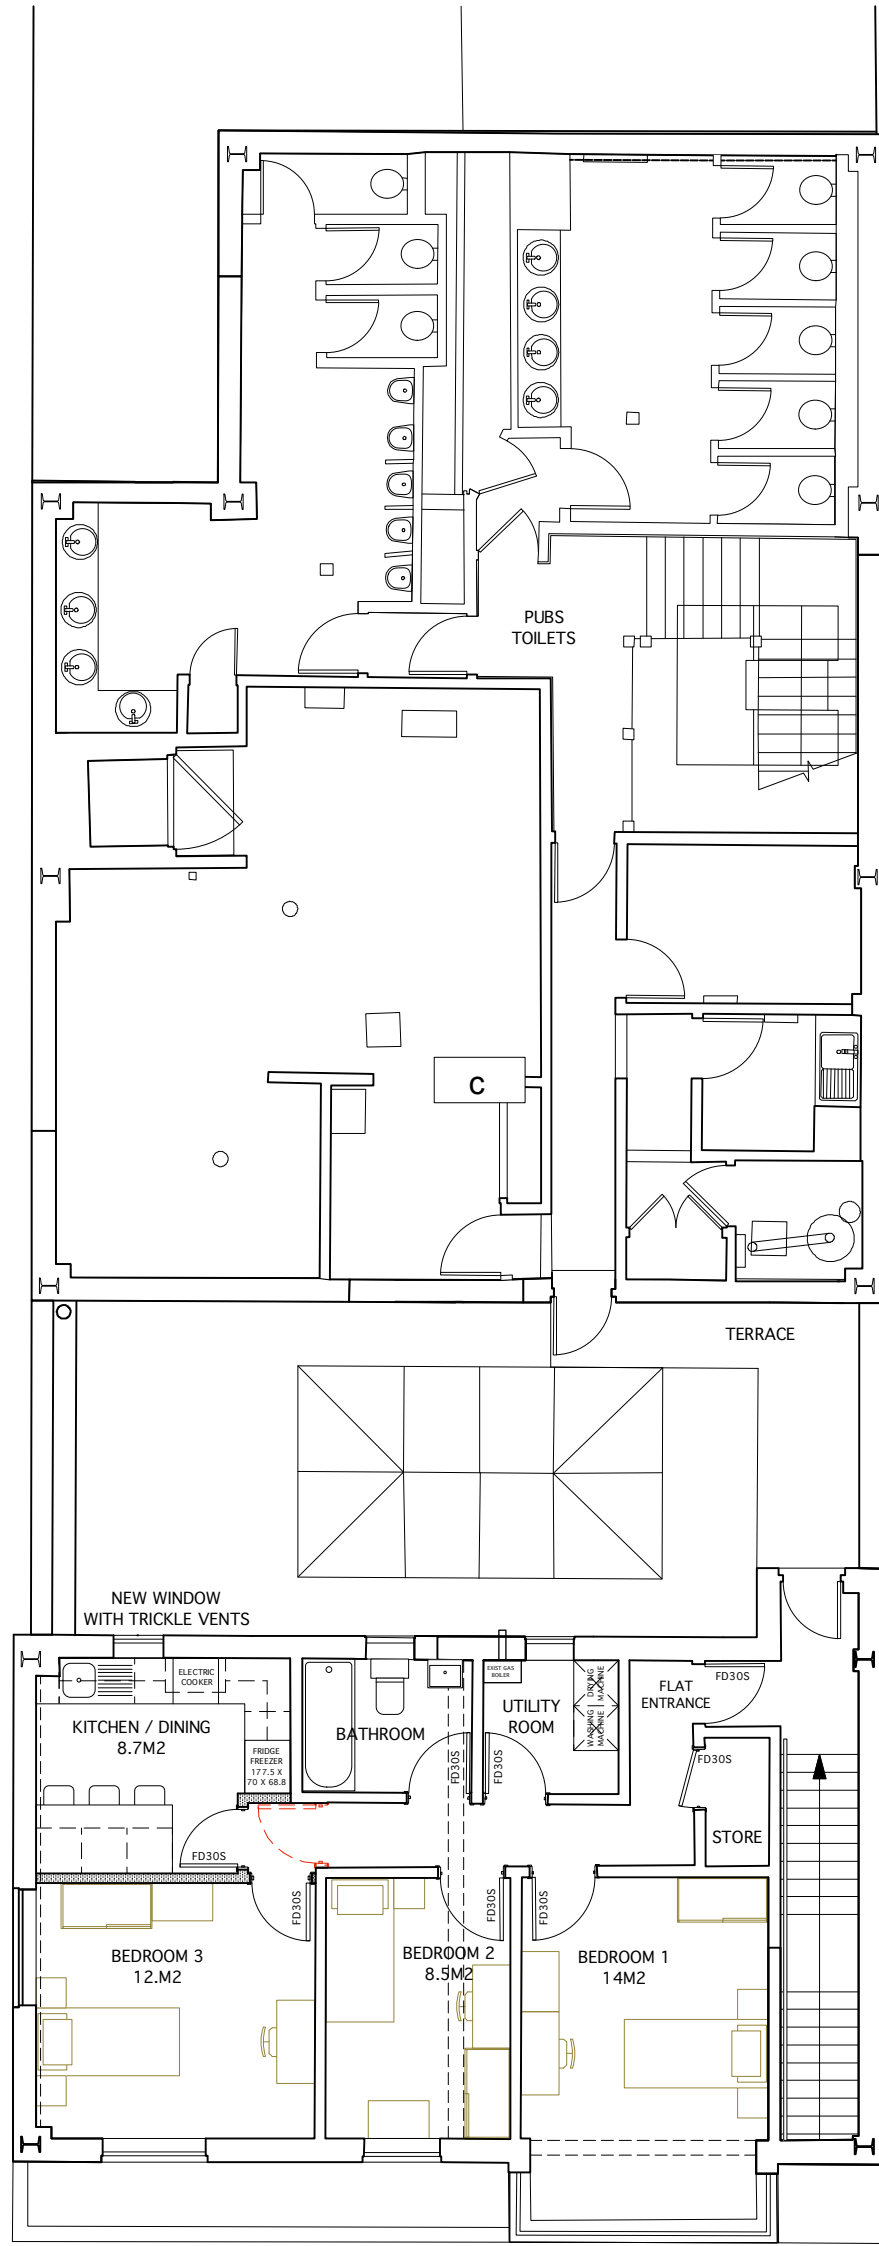


FIRST FLOOR PLAN

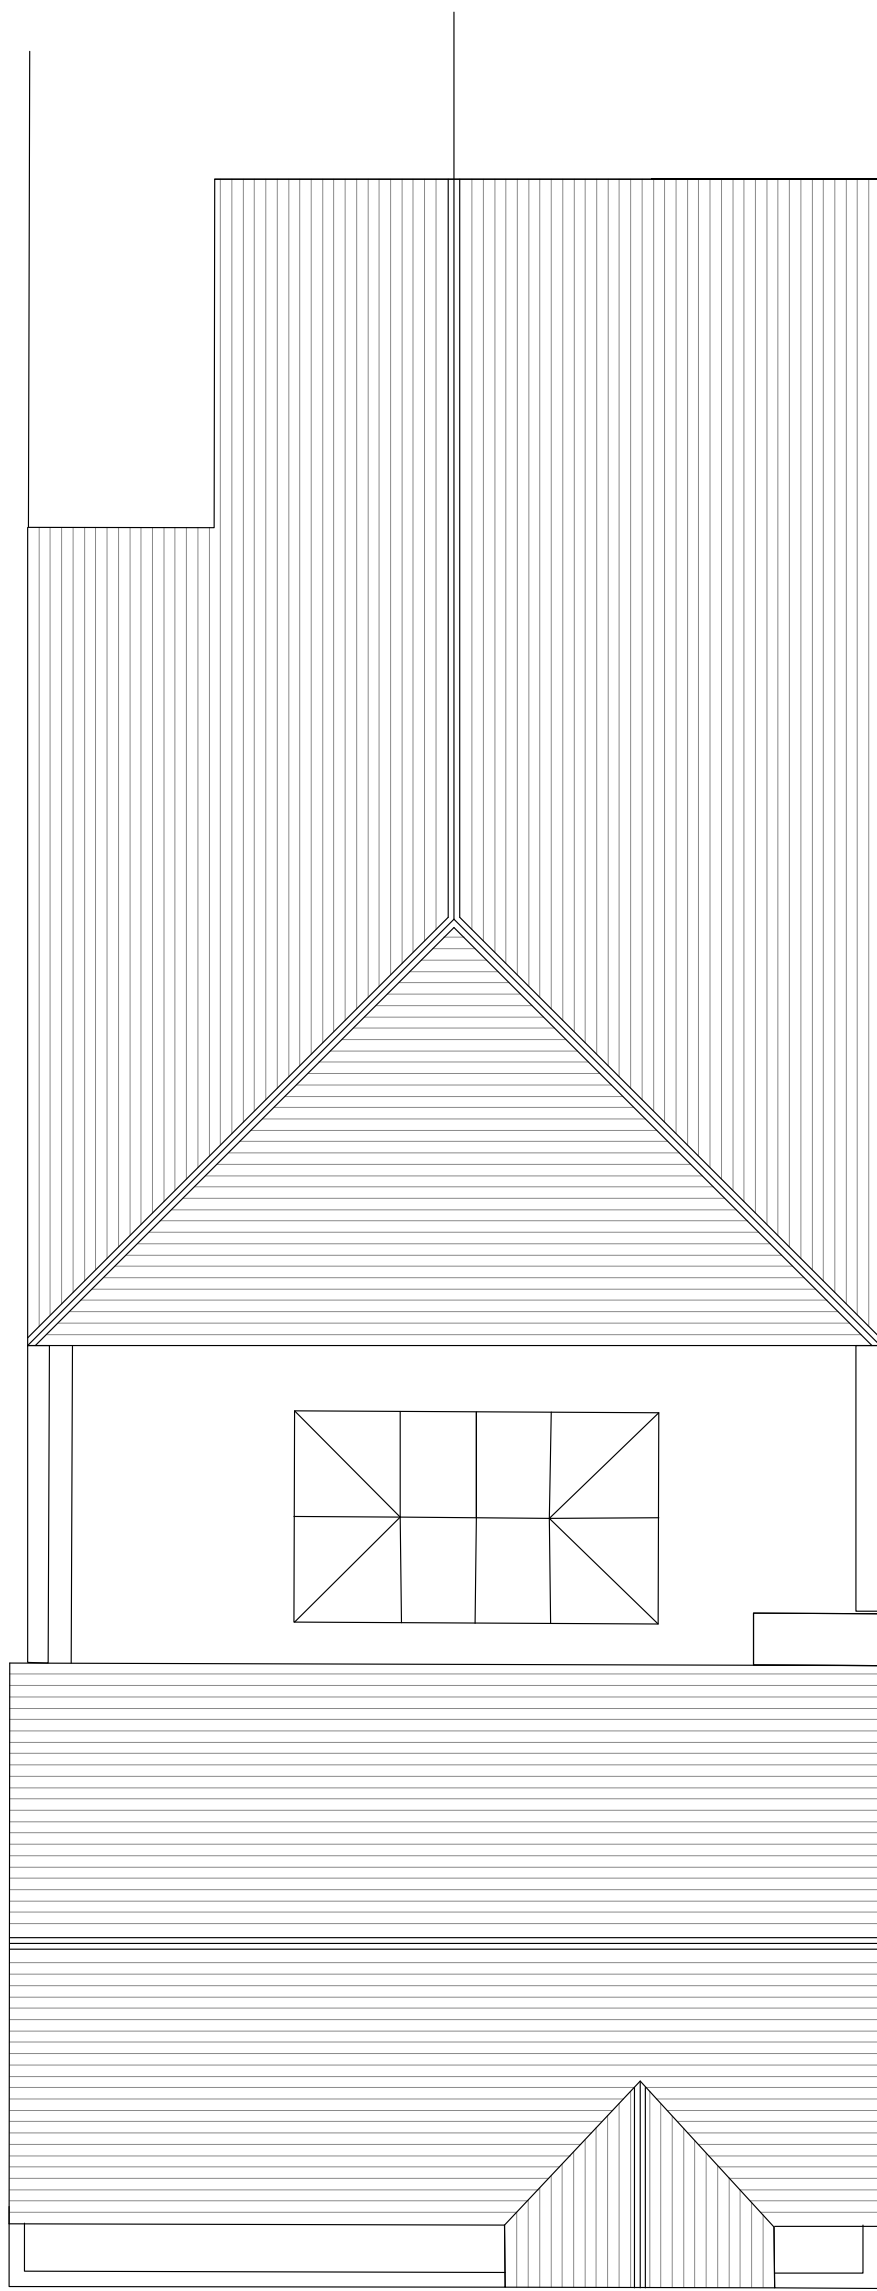

ROOF PLAN
(NO CHANGE)

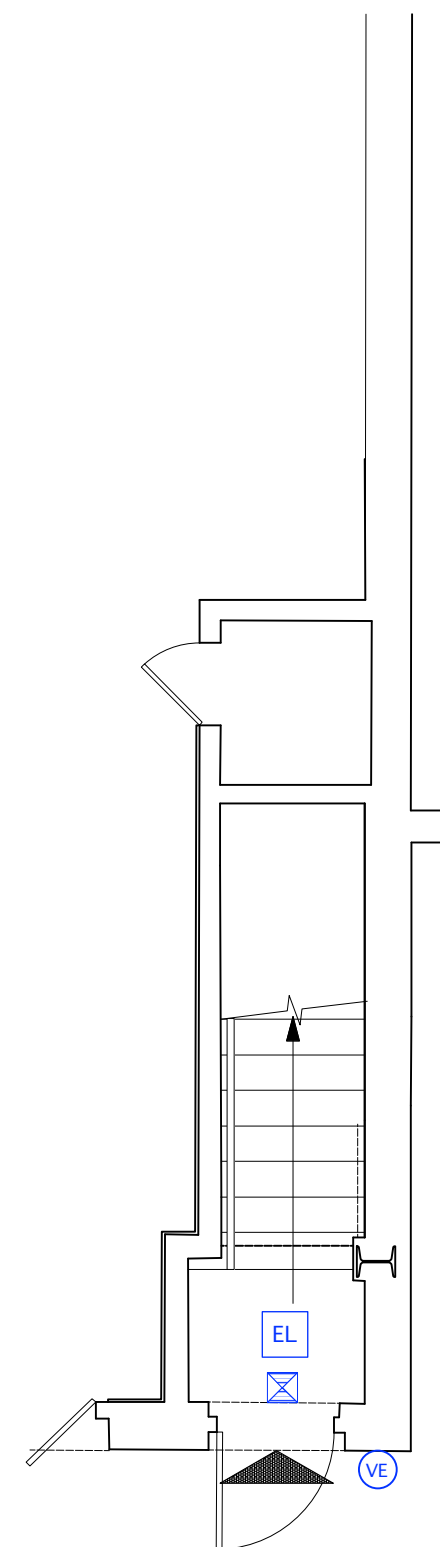

MAIN ENTRANCE GROUND FLOOR
TO FIRST FLOOR
FLAT

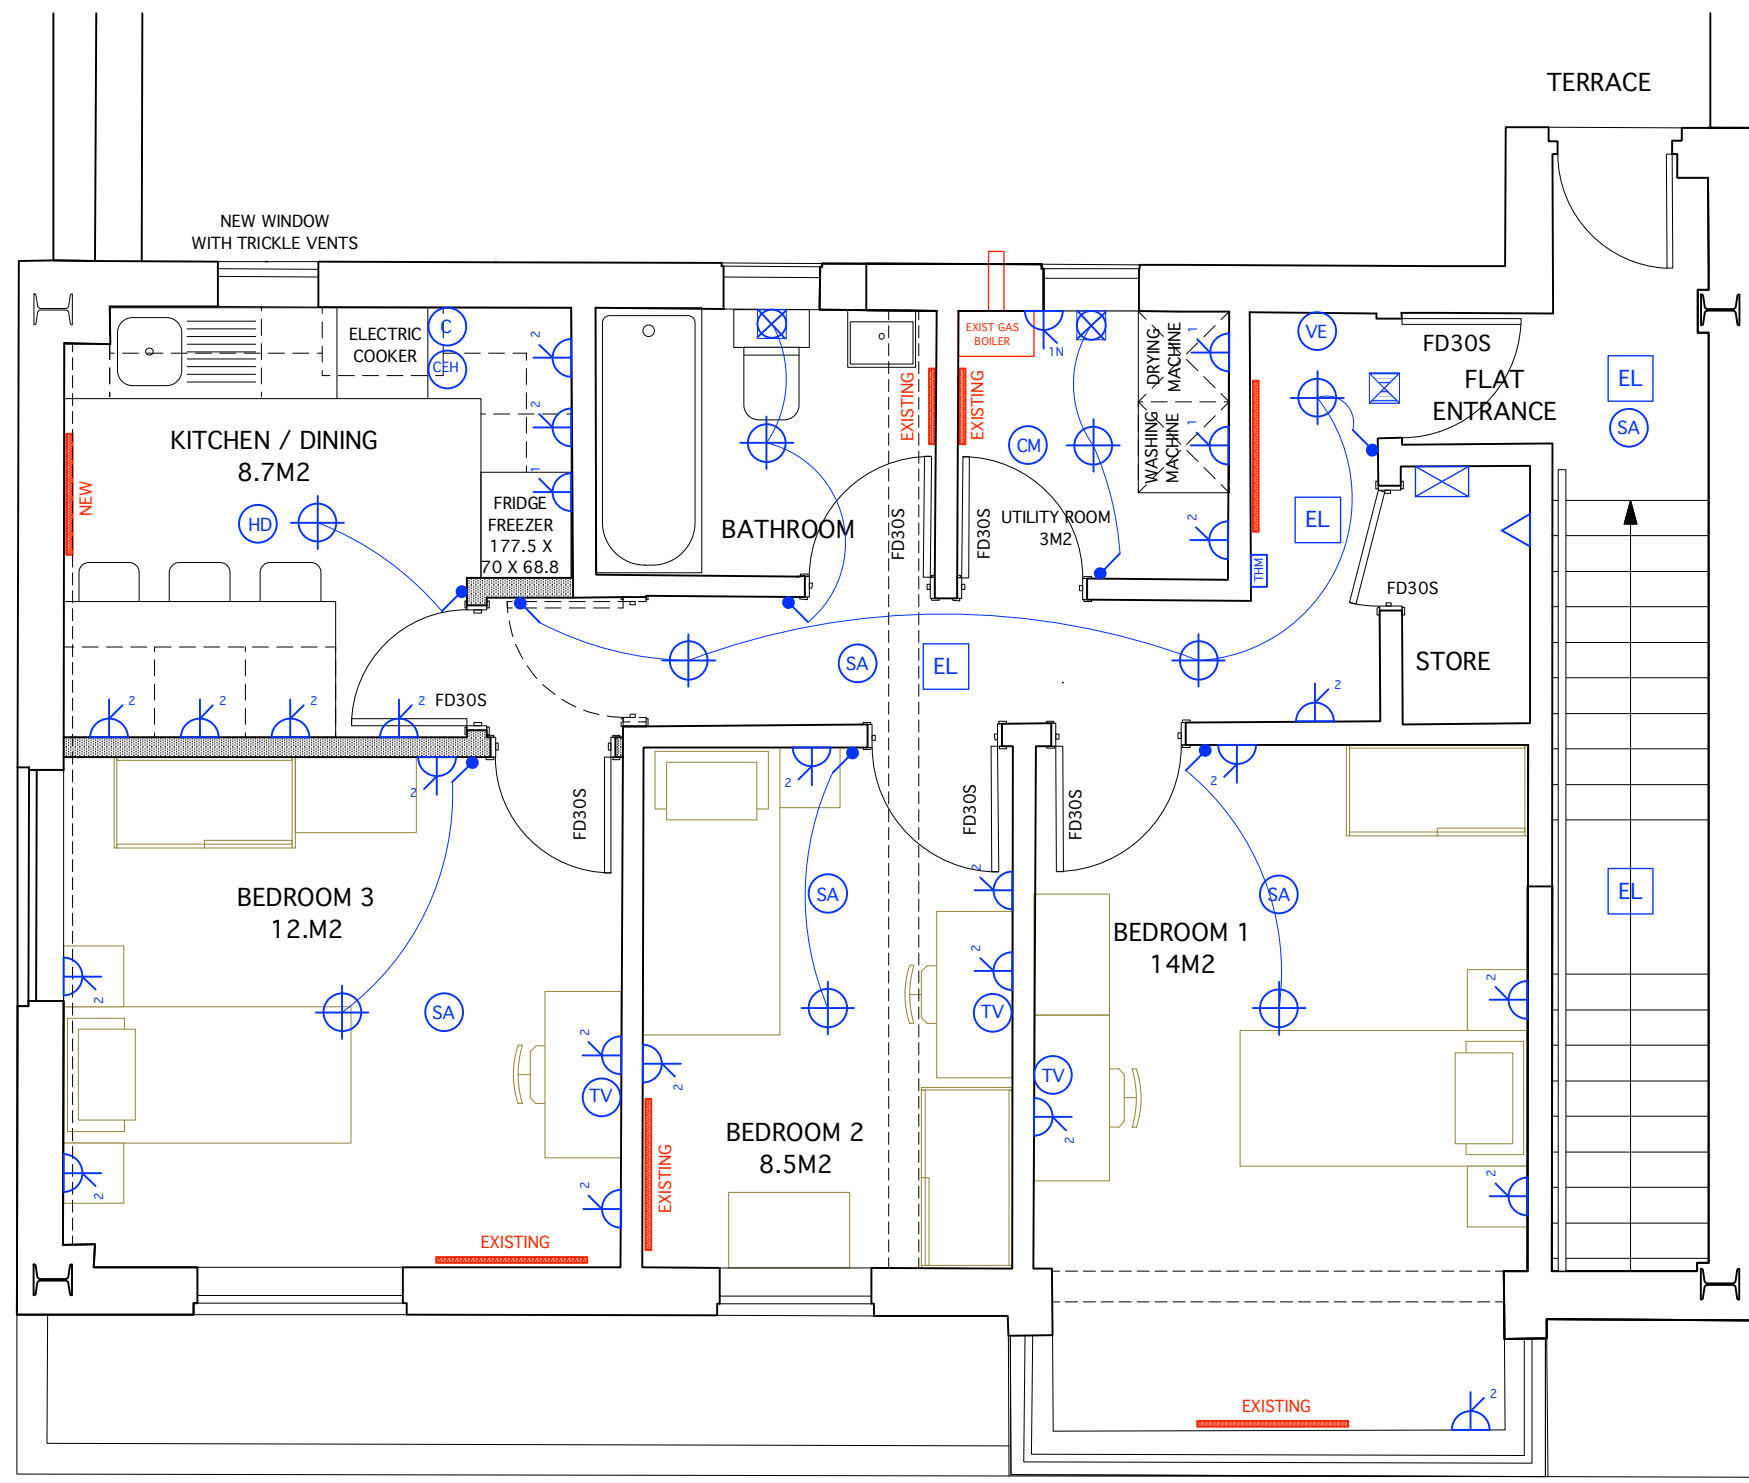

FIRST FLOOR PLAN

ELECTRICAL KEY	
	TWIN SWITCH SOCKET. BEHIND TV'S TO BE POSITIONED AT HIGH LEVEL. APPROX 1.5M BEHIND WALL MOUNTED TV'S.
	SINGLE SWITCH SOCKET FOR APPLIANCES
	BOILER SWITCH WITH NEON.
	SMOKE ALARM WITH BACK UP BATTERY
	HEAT DETECTOR WITH BACK UP BATTERY
	CARBON MONOXIDE DETECTOR WITH BACK UP BATTERY
	COOKER POINT
	COOKER EXTRACT HOOD 60L/S
	EXISTING MECHANICAL EXTRACT FAN MOUNTED 30L/S
	BT TELEPHONE SOCKET & WIRELESS INTERNET ROUTER
	TV POINT / SAT DISH / CABLE PROVIDE A DIGITAL ANTENNA EXTERNALLY
	LIGHT SWITCH
	THERMOSTAT CONTROL
	ELECTRIC INTAKE & CONSUMER UNIT.
	PENDANT LRD LIGHT.
	EXISTING EMERGENCY LIGHTING
	FIRE ESCAPE KEEP CLEAR
	VIDEO ENTRY WITHOUT DOOR RELEASE

HEATING KEY	
	GAS BOILER
	RADIATOR

THESE ARE PLANNING APPLICATION
DRAWINGS. THEY ARE NOT FOR
TENDER, BUILDING REGULATIONS
OR FOR CONSTRUCTION

0 1m 2m 3m 4m 5m
SCALE 1:100

Client
**MR RICHARD HENNESSY
SWAKELEYS LTD
2 KINGSSEND, RUISLIP HA4 8LJ**

Property
**THE ICKENHAM INN
11 SWAKELEYS ROAD
ICKENHAM
UXBRIDGE UB10 8DF**

Job Title
**FIRST FLOOR FLAT
CHANGE OF USE
FROM C3 TO C4 (HMO)**

Drawing
**PROPOSED
PLANS AND ELEVATIONS.
ELECTRIC & HEATING LAYOUT**

Date
08.06.26

Scale
1:100 & 1:50@A1

Job No
11SR

Drawing No
A - 02

Revision No

ANDREAS GEORGIU t/a GIAD
Office F7, Kingsbury House
468 Church Lane, London NW9 8UA
Tel: 020 8200 2331
TEL: 07956 587037
email: andreas@giad.co.uk
ANDREAS GEORGIU t/a GIAD
RESERVE THE COPYRIGHT ON ALL DOCUMENTS AND DRAWINGS

0 1M 2M 3M
SCALE: 1:50 @ A1