


Indicated Dropped Kerbs

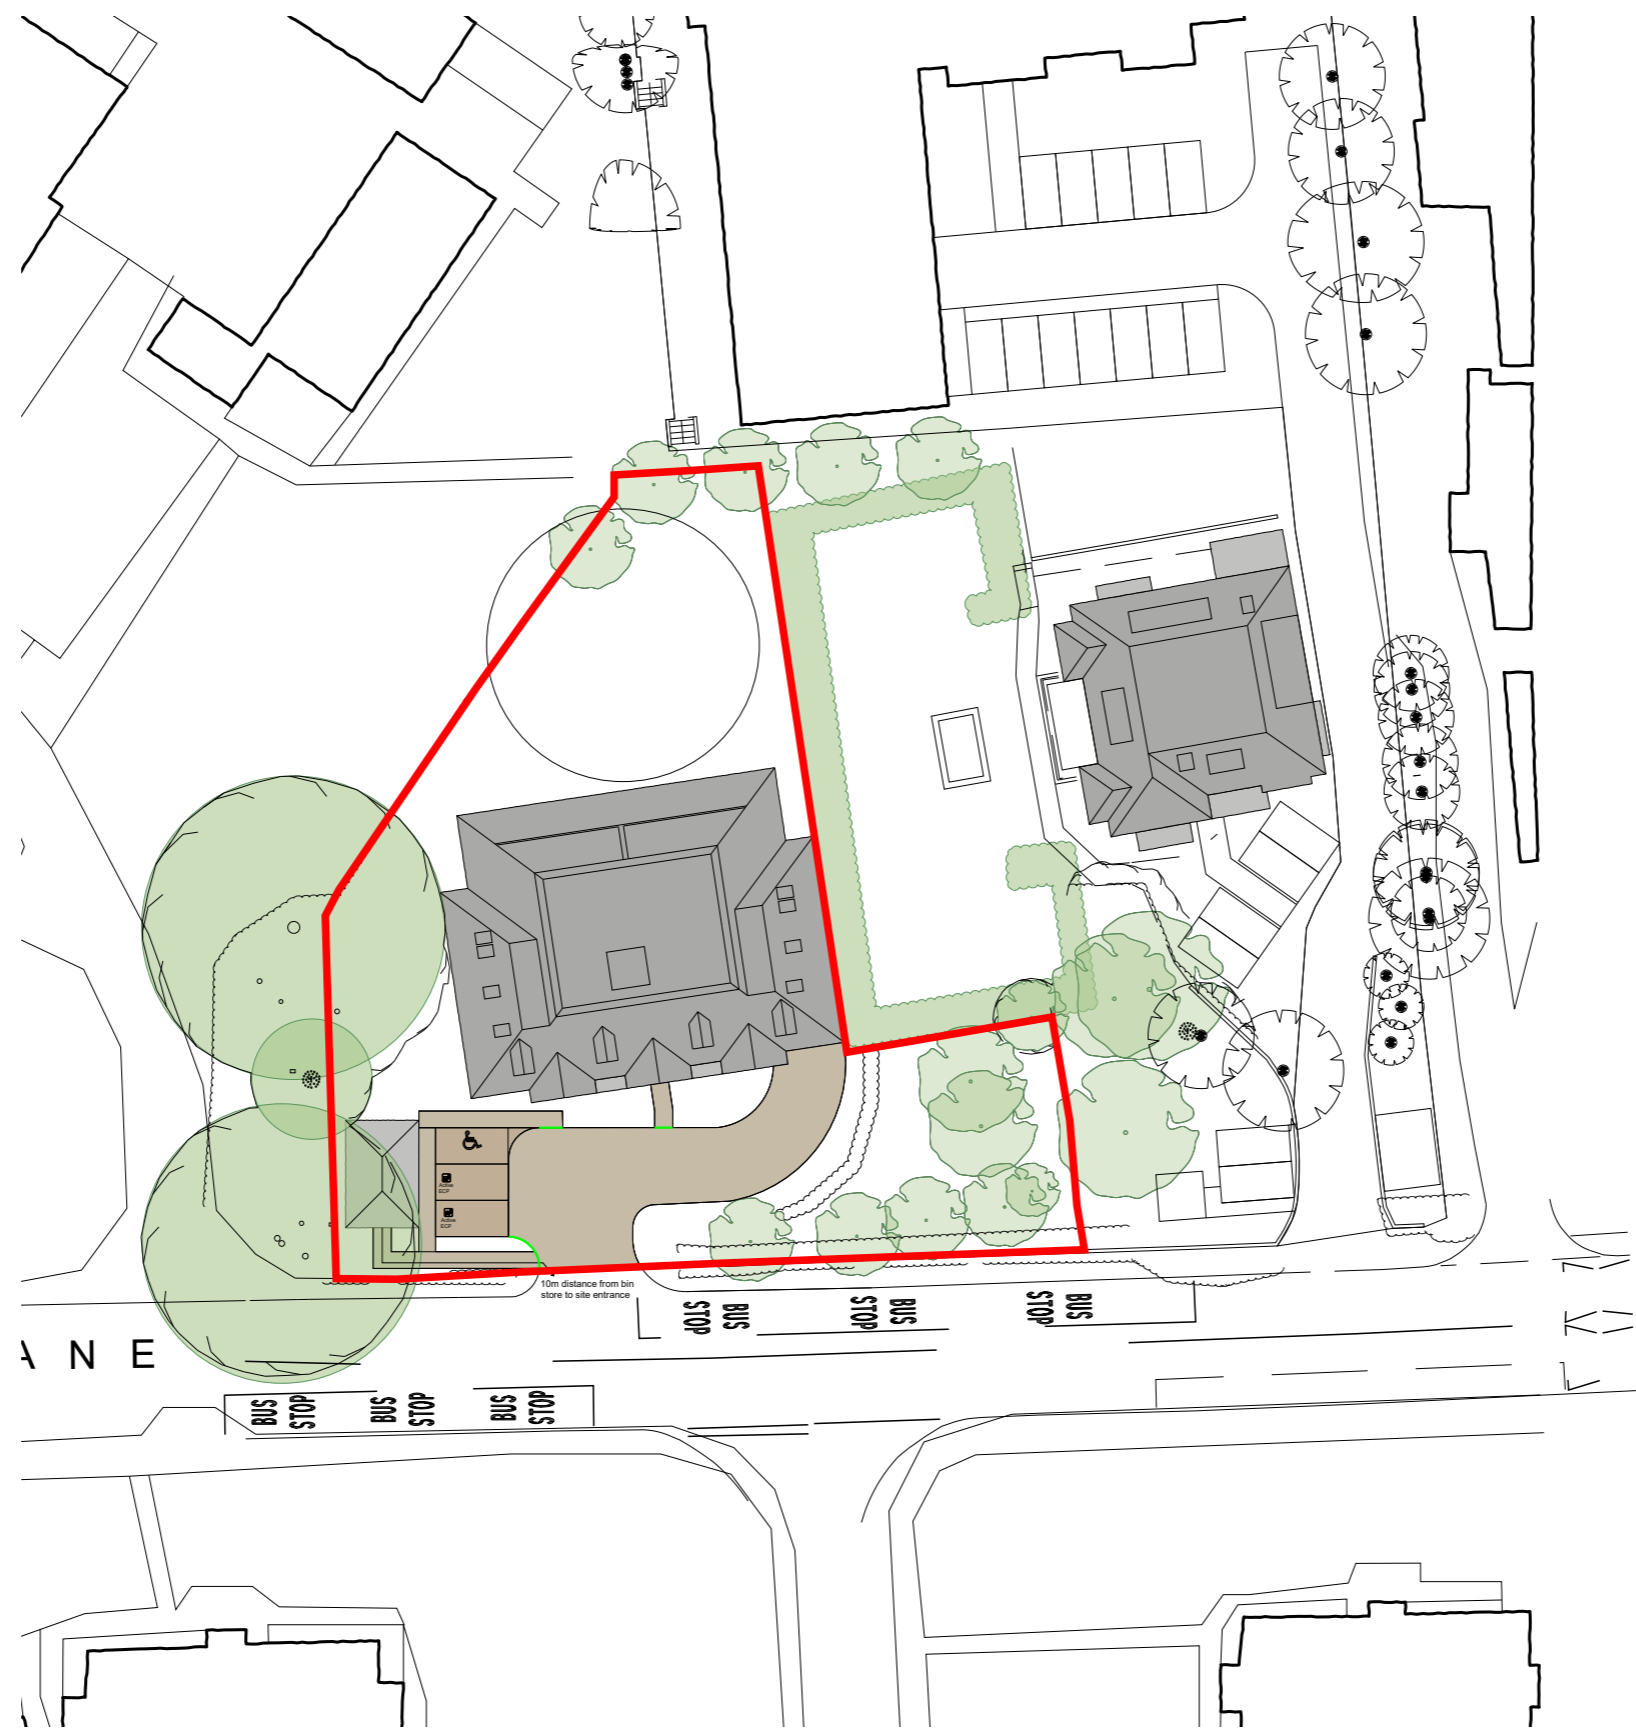

Rev	Date	Description

 
Fluent
ARCHITECTURAL DESIGN SERVICES

FLUENT
ARCHITECTURAL DESIGN SERVICES LTD
MONKEY PUZZLE HOUSE, 69-71 WINDMILL RD,
SUNBURTON TRAMES TW16 7DT
TEL: 0800 043 8828
EMAIL: INFO@FLUENT-ADS.CO.UK
WEB: FLUENT-ADS.CO.UK

Client :
Green Lane Estates Ltd

Wetherbys Nursery
Green Lane, Northwood

Site Plan



Scale 1:500 @ A3	Dwg No. FLU.441.3.02
Date 24.02.19	Rev
Drawn N.Millin	F